









1ST FLOOR SPRINKLER PLAN  
SCALE: 1/8" = 1'-0"

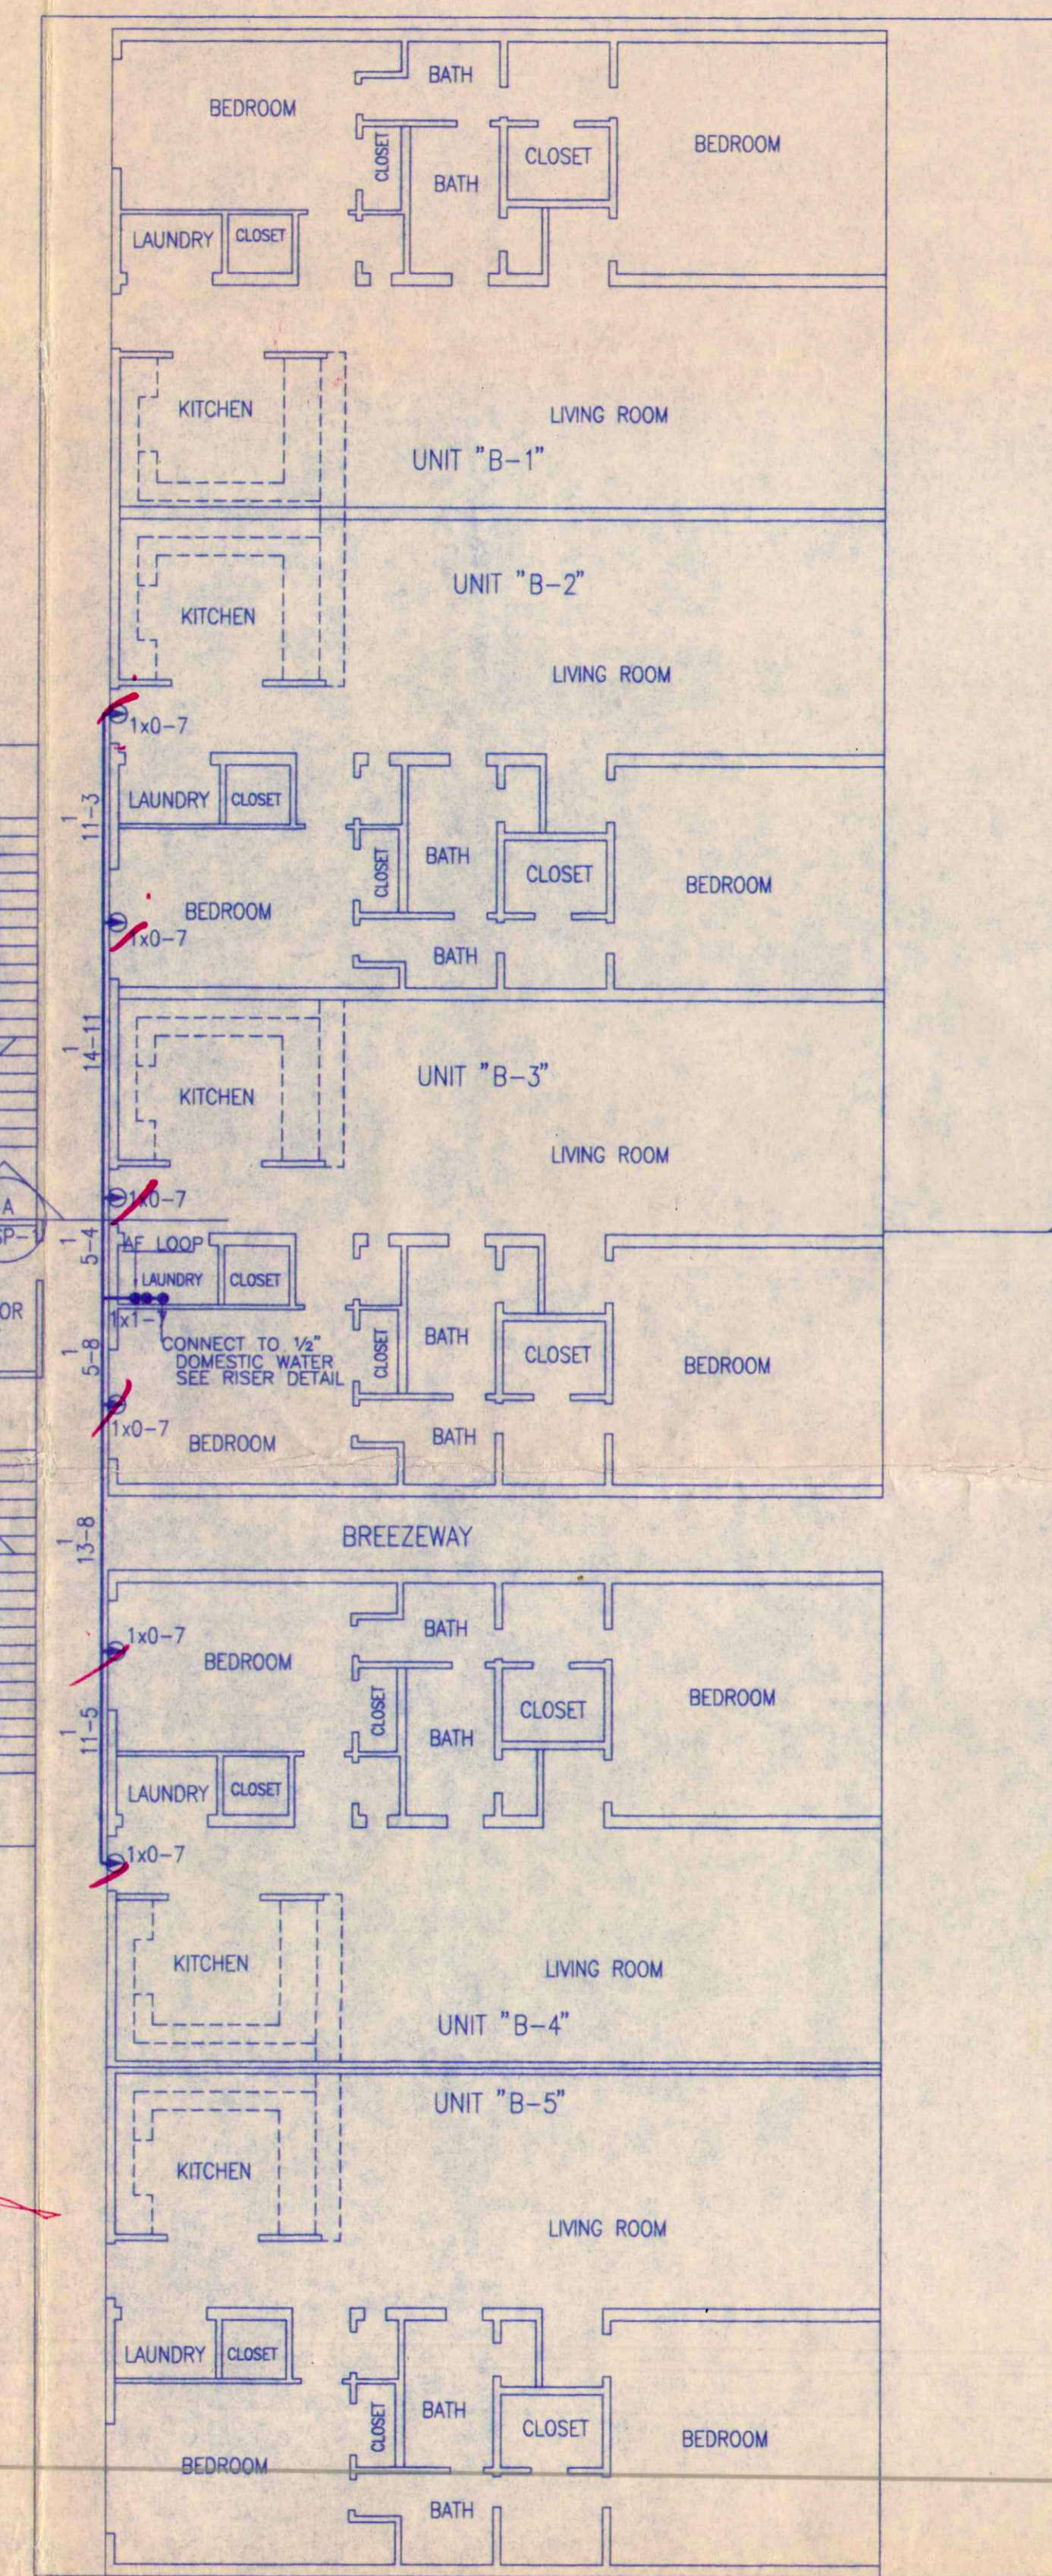

2ND FLOOR SPRINKLER PLAN  
SCALE: 1/8" = 1'-0"

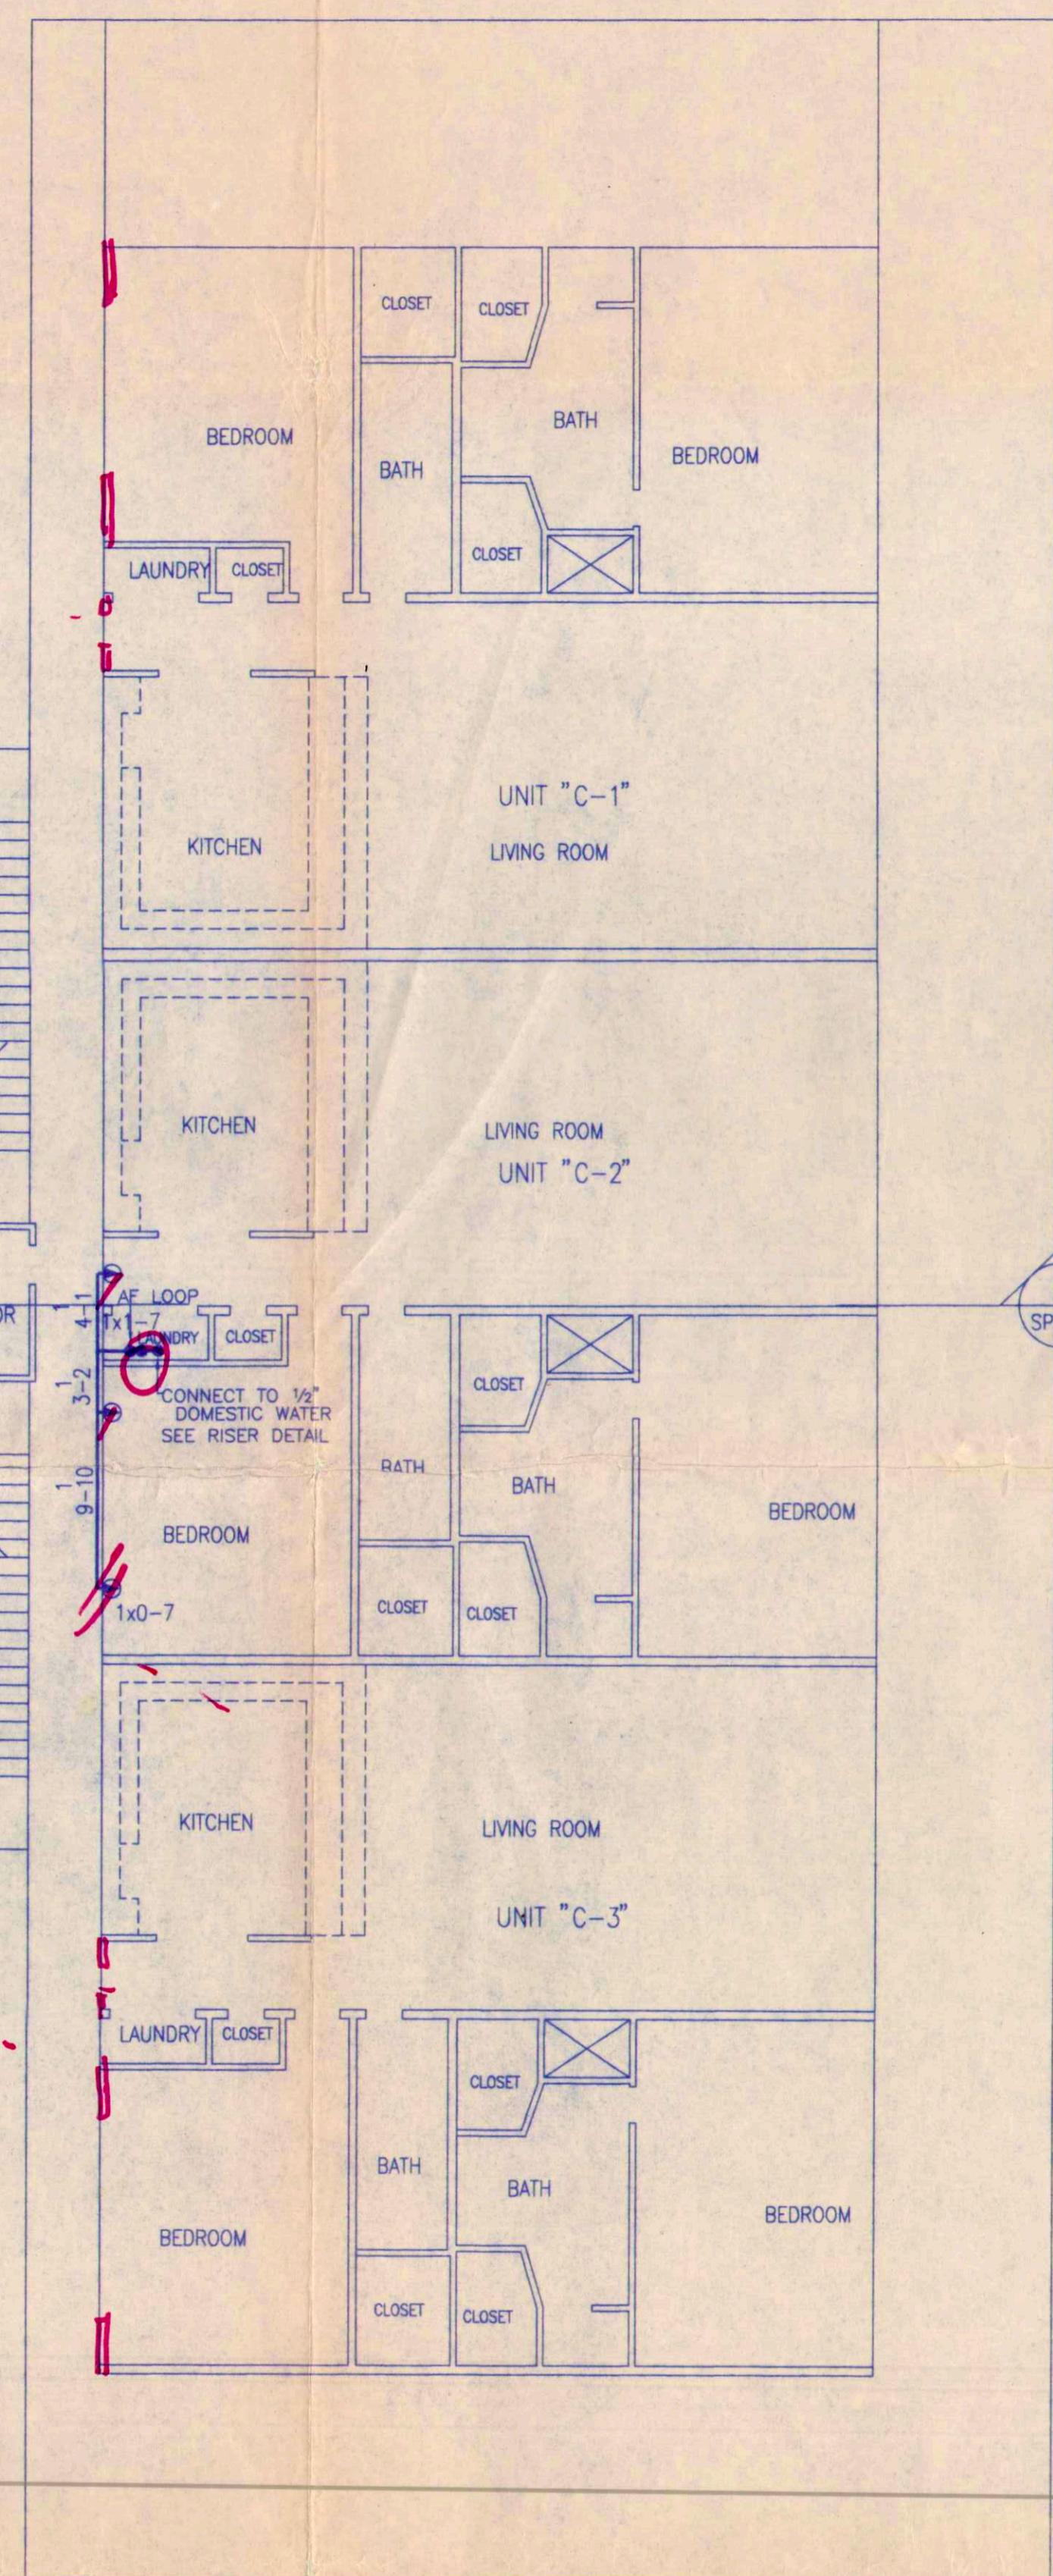


3RD FLOOR SPRINKLER PLAN  
SCALE: 1/8" = 1'-0"

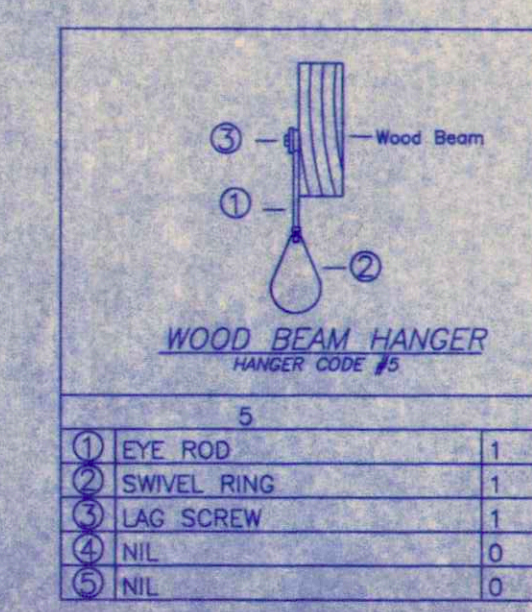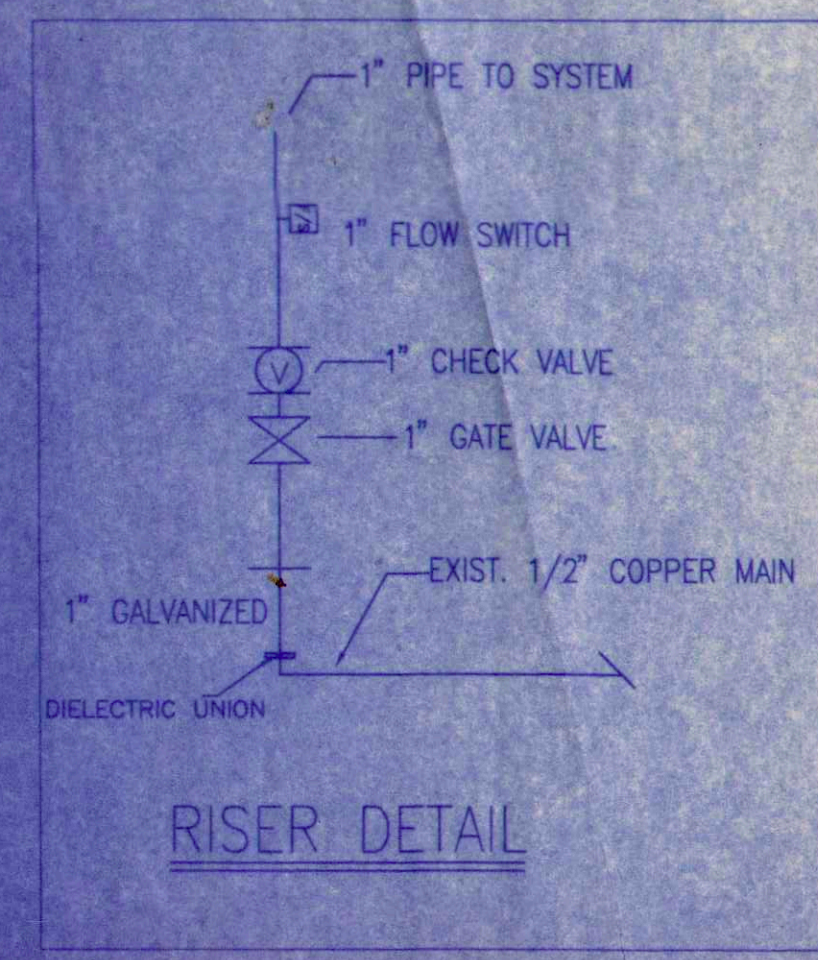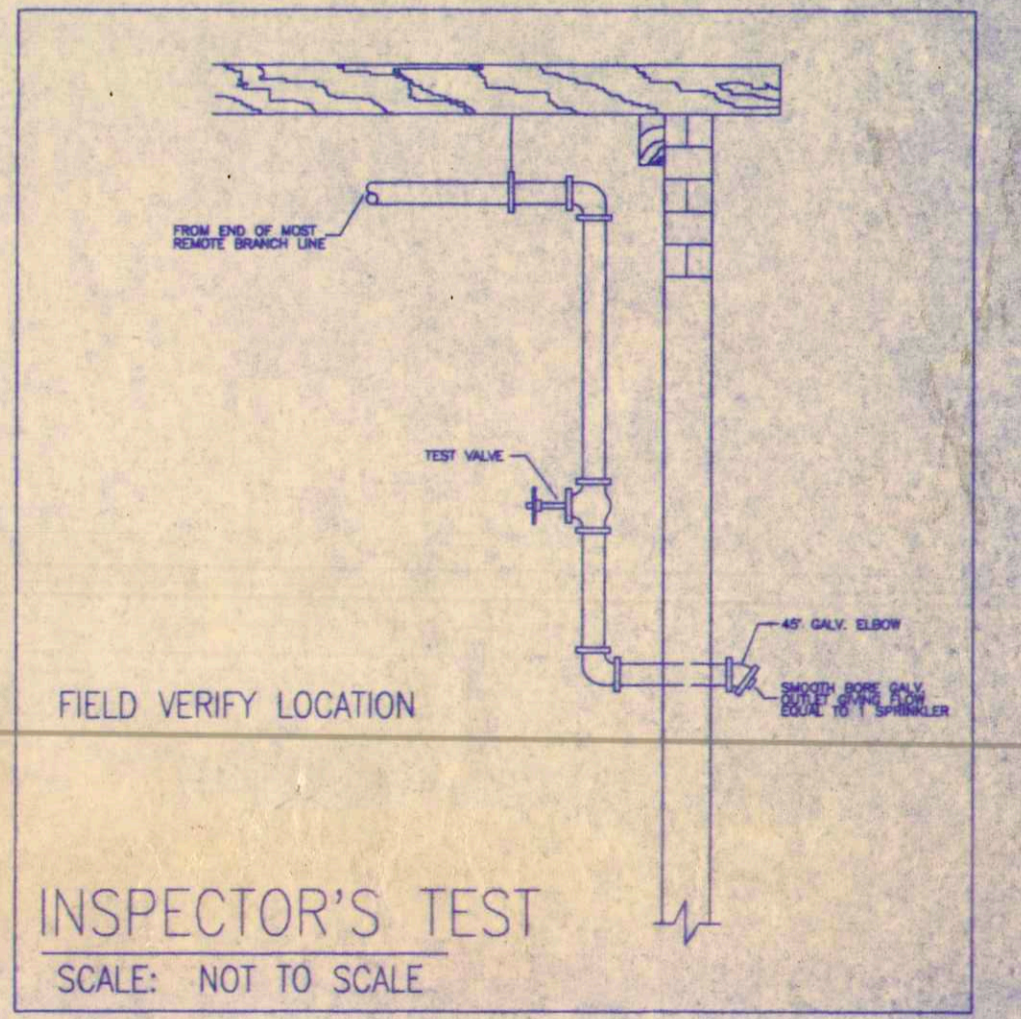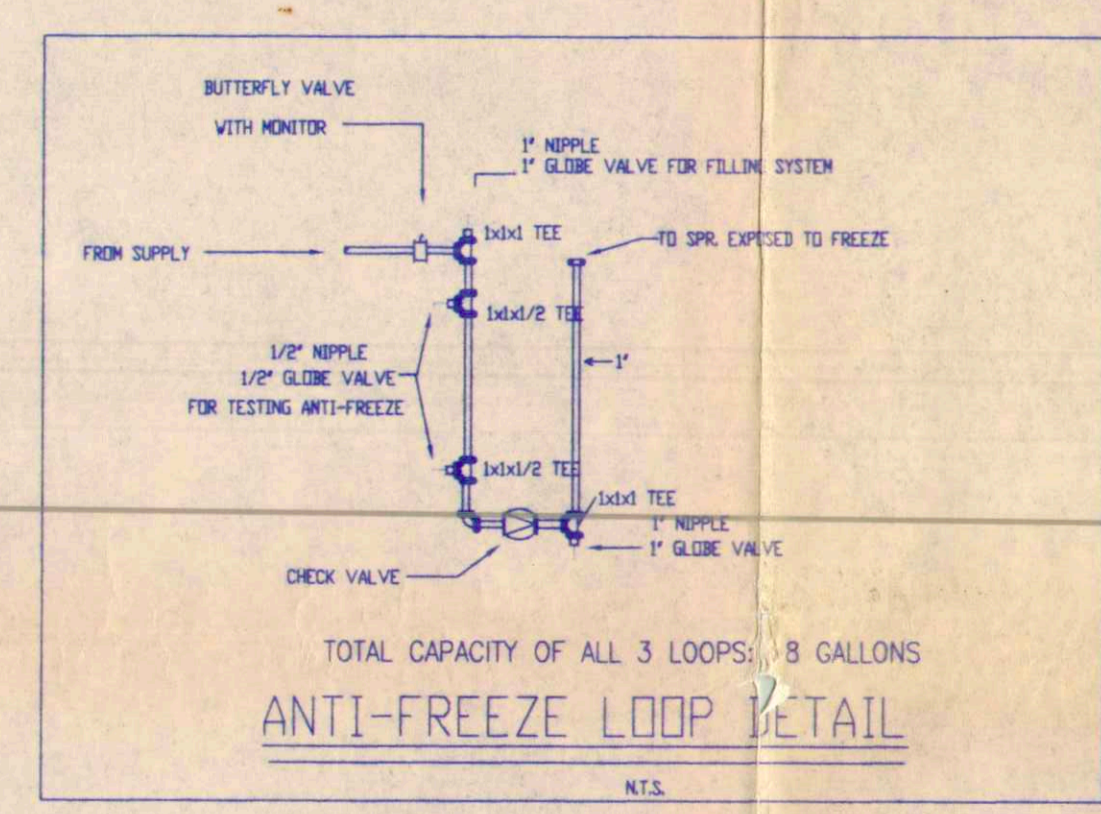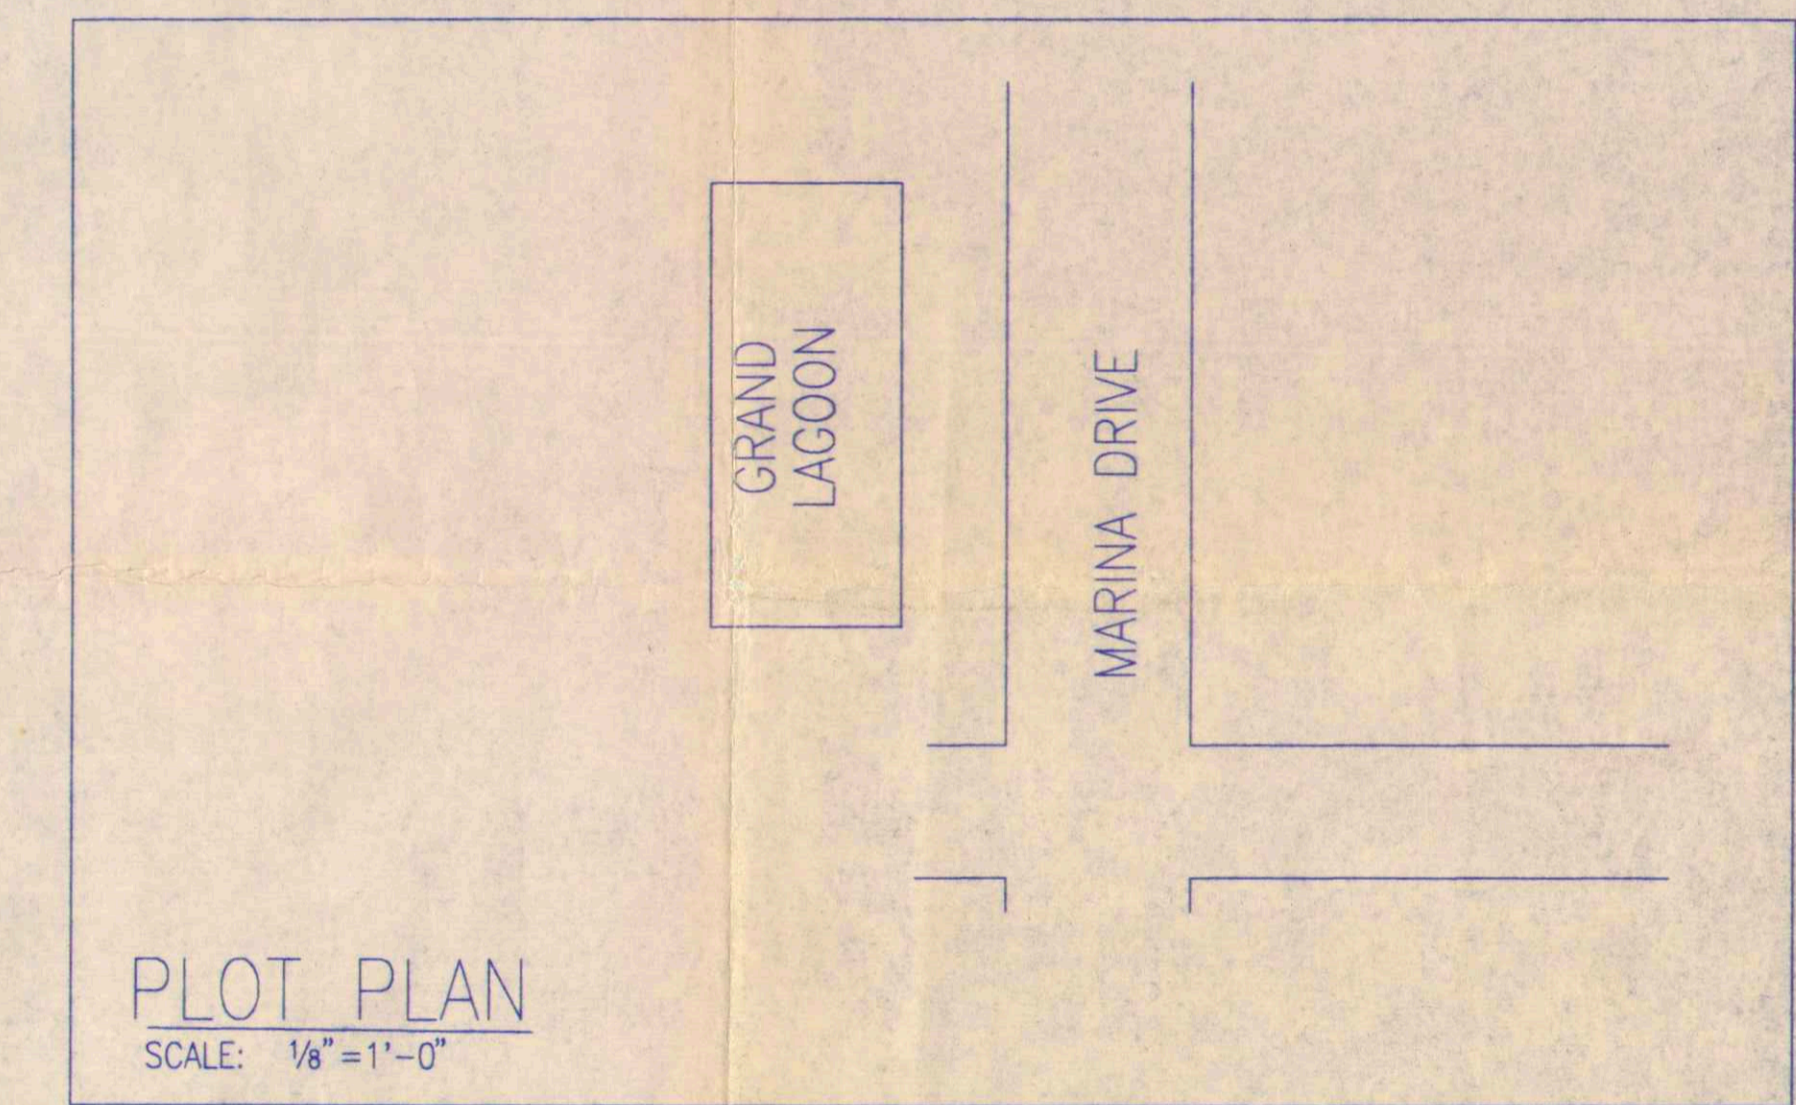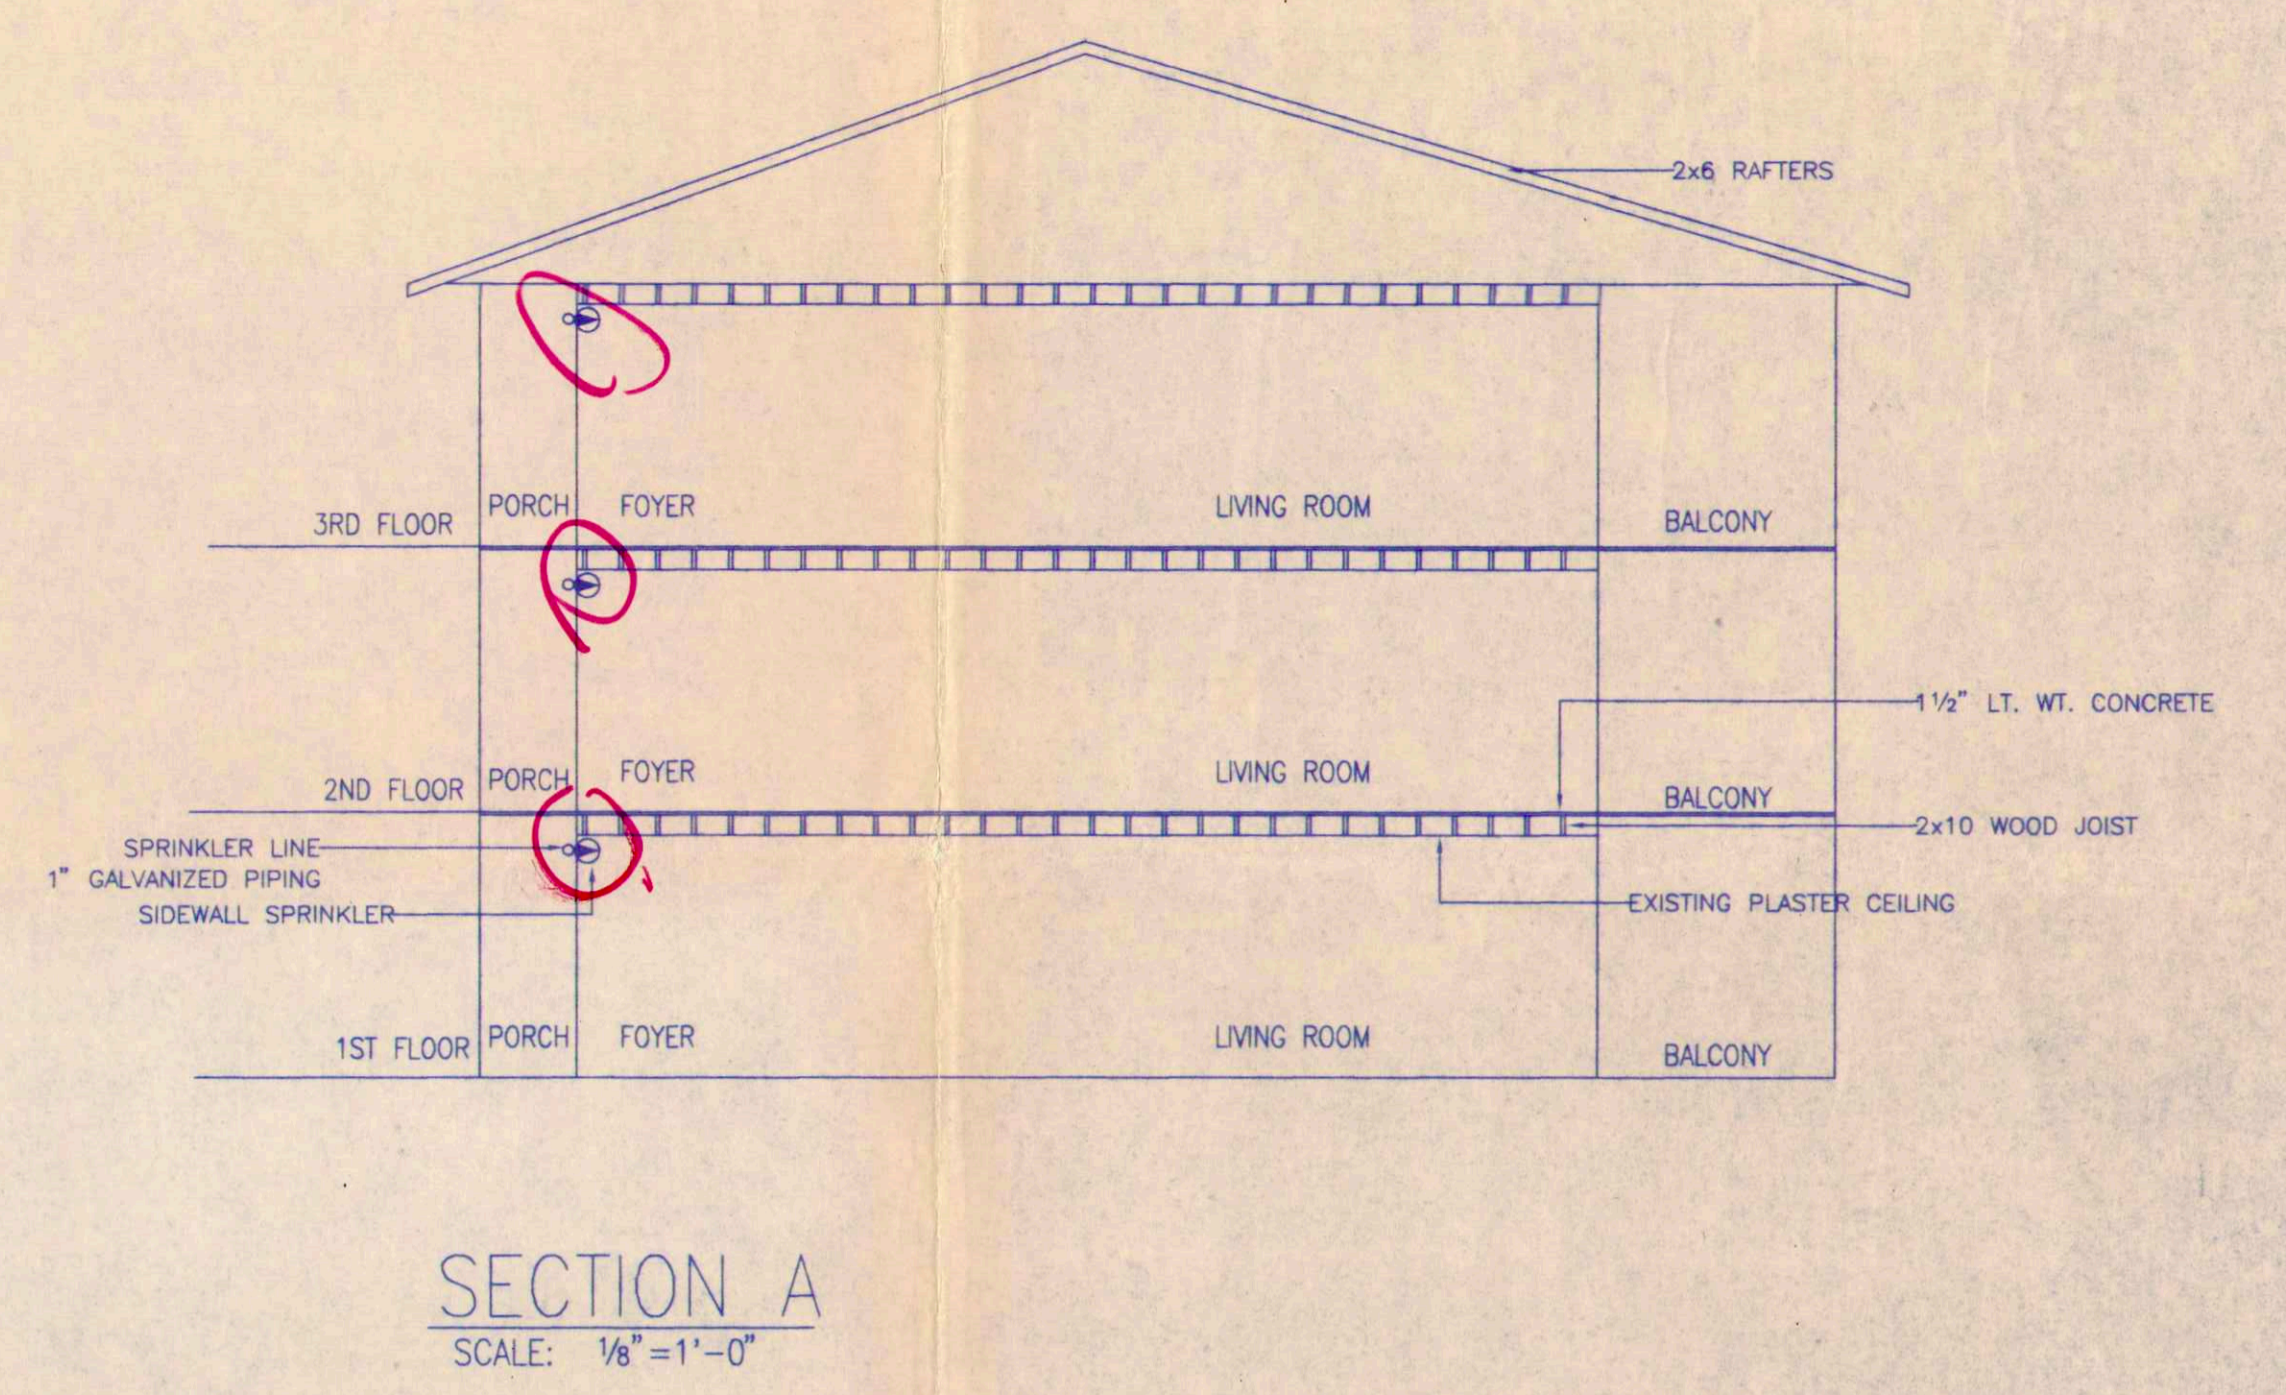

HYDRAULIC DESIGN DATA									
CALCULATION # 1		CALCULATION # 2		CALCULATION # 3					
Hazard Class									
System Type									
Density									
Calculated Area									
Area per Sprinkler									
Demand									
Flow Test Info:	Firepump: NA	GPM: NA	Pa: 0	Time: 10/5/01	Time: 9:00 am	Test By: JS			
Office Size	No. of Outlet	Pilot Press Pa	Static Pa	Residual Pa	Flow GPM	U/G Pipe:			
1	1		41	41	1480	1 1/2"			
2	1					1 1/2"			
3	1					1 1/2"			
							SAFETY (PSI)	0	

CONTRACTOR: MARION B. REAL ESTATE		
ADDRESS: SLIDELL, LA		
REVISION		
DATE	DESCRIPTION	BY

SPRINKLER SCHEDULE & LEGEND						
SYMBOL	SPRINKLER DESCRIPTION	ORIFICE "K"	TEMP.	FINISH	TEST	
⊙	AUTOMATIC	HR-2	RESIDENTIAL SOW/7/16"	4.0	155+	CHR
6 HEAD CART & WRENCHES PROVIDED TOTAL COUNT THIS SHEET = 15						

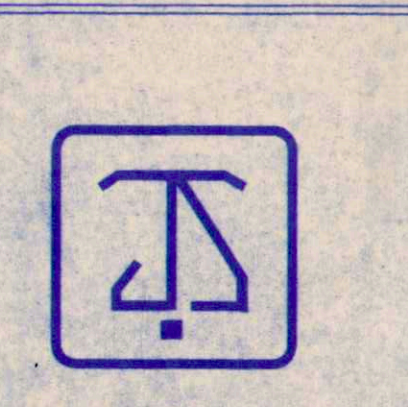

**GRAND LAGOON CONDOS** 2461 NORTH  
1141-1163 MARINA DRIVE SLIDELL, LA  
SPRINKLER PLAN

**JEFFERSON SPRINKLER, INC.**  
"Fire Protection Specialist"

1903 Hancock St. P O Box 129 Gretna, La.  
PHONE 504-393-7899 FAX 504-397-0218

DESIGNER	S. ENCLADE
SCALE	1/8" = 1'-0"
CHECK BY	
FILE NUMBER	71
APPROVAL	
DATE	8/21
DRAWING NO.	1 OF

APPROVED  APPROVED AS NOTED  REVISE AND RESUBMIT  REJECTED

Approval by the Architect is for compatibility with the general design concept of the project only and does not relieve the Contractor of his responsibility for compliance with the original contract documents. When errors or omissions are later discovered on the shop drawings, the architect and owner shall be corrected by the Contractor at no cost of their payment. This shall be the responsibility of the Contractor.

By: *[Signature]* ROBERT R. QAULEY  
Architect / Associate

Notice: Pipe to installation vendor to coordinate installation, as activities w/ Architect Management Co. 8/28/01

REVIEWED FOR STATE FIRE MARSHAL AS PER REVIEW LETTER BY RON C. WATHIS 8/28/01