

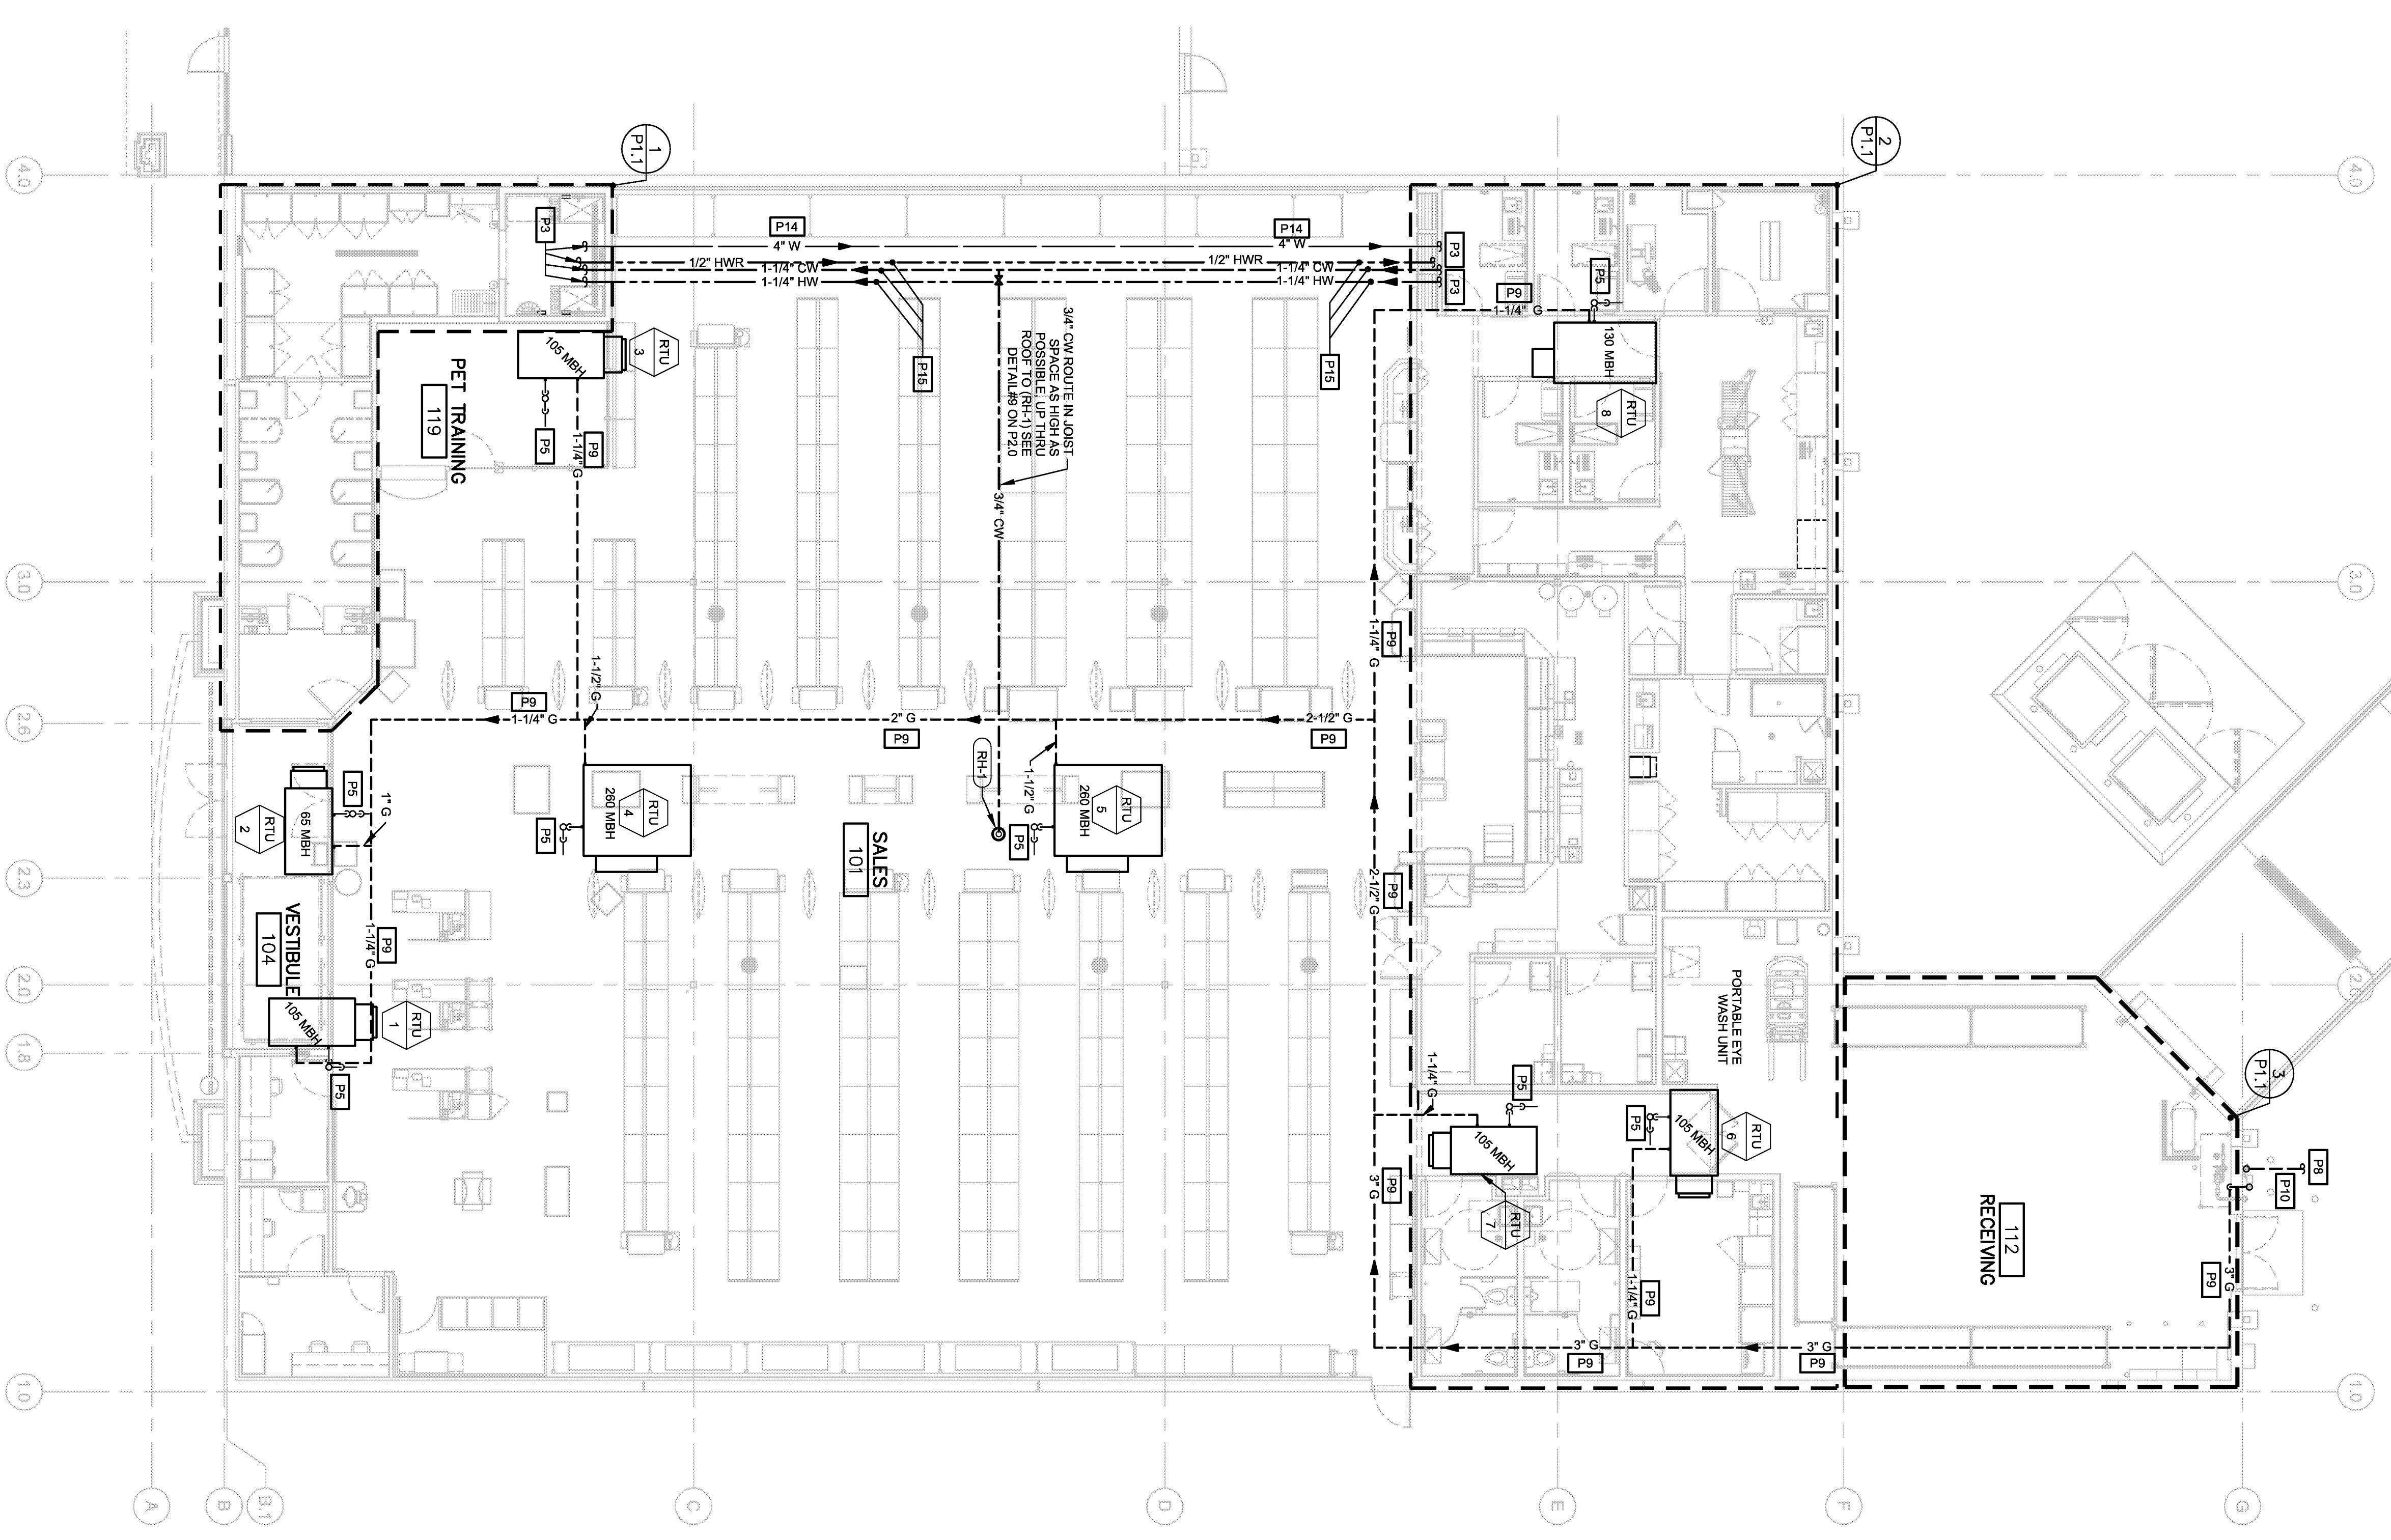


**1 PLUMBING FLOOR PLAN**  
SCALE: 1/8" = 1'-0"

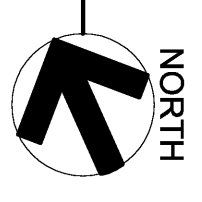


**2 FIRE/DOMESTIC RISER ELEVATION**  
SCALE: N.T.S.

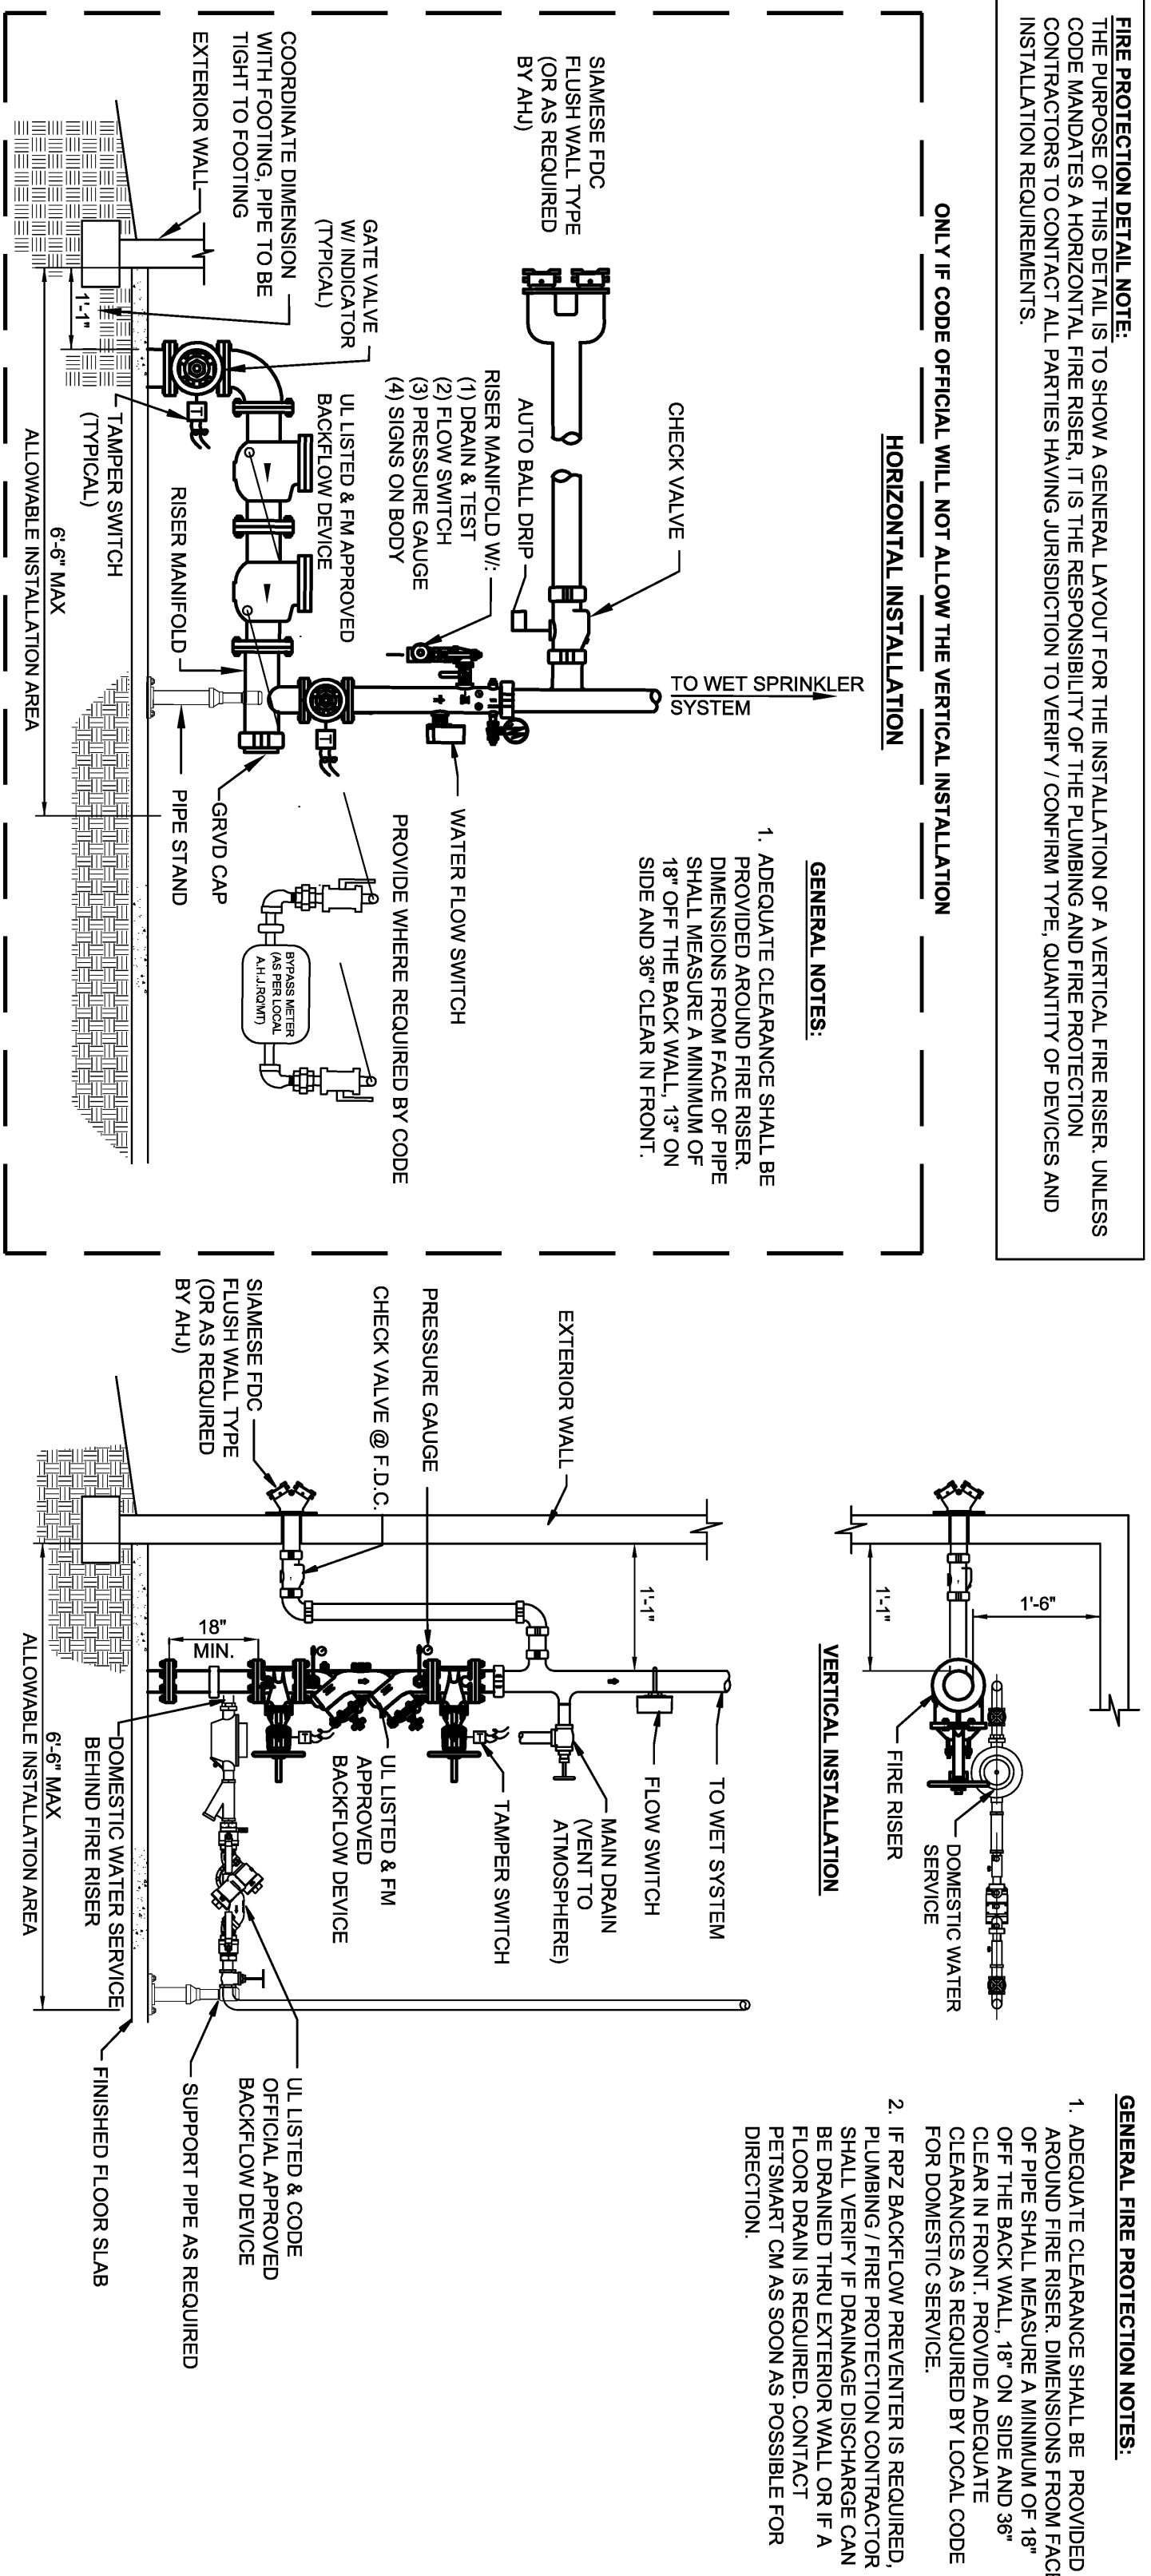

Scale: As Indicated  
Drawing: **P1.0**  
Checked: ---  
Sheet No.: **0413995-081**

**ROBERT M. LUCIUS, ARCHITECT**  
1200 Marshall St. NEF  
Minneapolis, MN 55413  
612.677.7100  
612.677.7499  
fax  
www.rmlparch.com

No.:	ISSUE:	DATE:
	ISSUE FOR PERMIT	APRIL 15, 2013

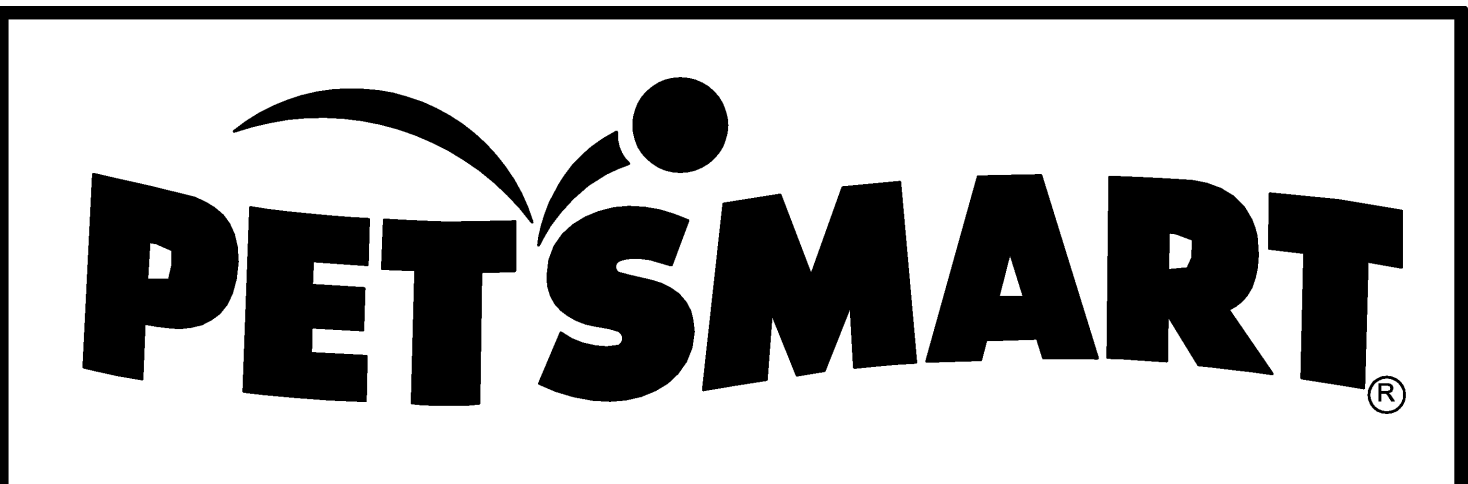

**PLUMBING FLOOR PLAN**  
**STORE NUMBER 2274**  
**FREMAUX TOWN CENTER**  
**SLIDELL, LOUISIANA**

