



DAMMON
ENGINEERING, INC.
EMMETT
DAMMON

ARCHITECT
ROBERT
SOLLBERGER

1095 FLORIDA AVENUE
SLIDELL, LA, 70458
985-649-5832

WEBSITE:
WWW.DAMMONENGINEERING.COM
EMAIL:
DAMMONENG@BELLSOUTH.NET

ARCHITECTURE
ENGINEERING
STUDIES
PLANNING
INVESTIGATION
EXPERT WITNESS

NEW OFFICE
BUILDING

PLATFORM CRANE
POWELL DRIVE
SLIDELL, LA

PLUMBING
PLAN

REV:

SCALE: AS NOTED


JOB#: 1898

DATE: 10-8-07

SHEET 24

P-1

OF 25

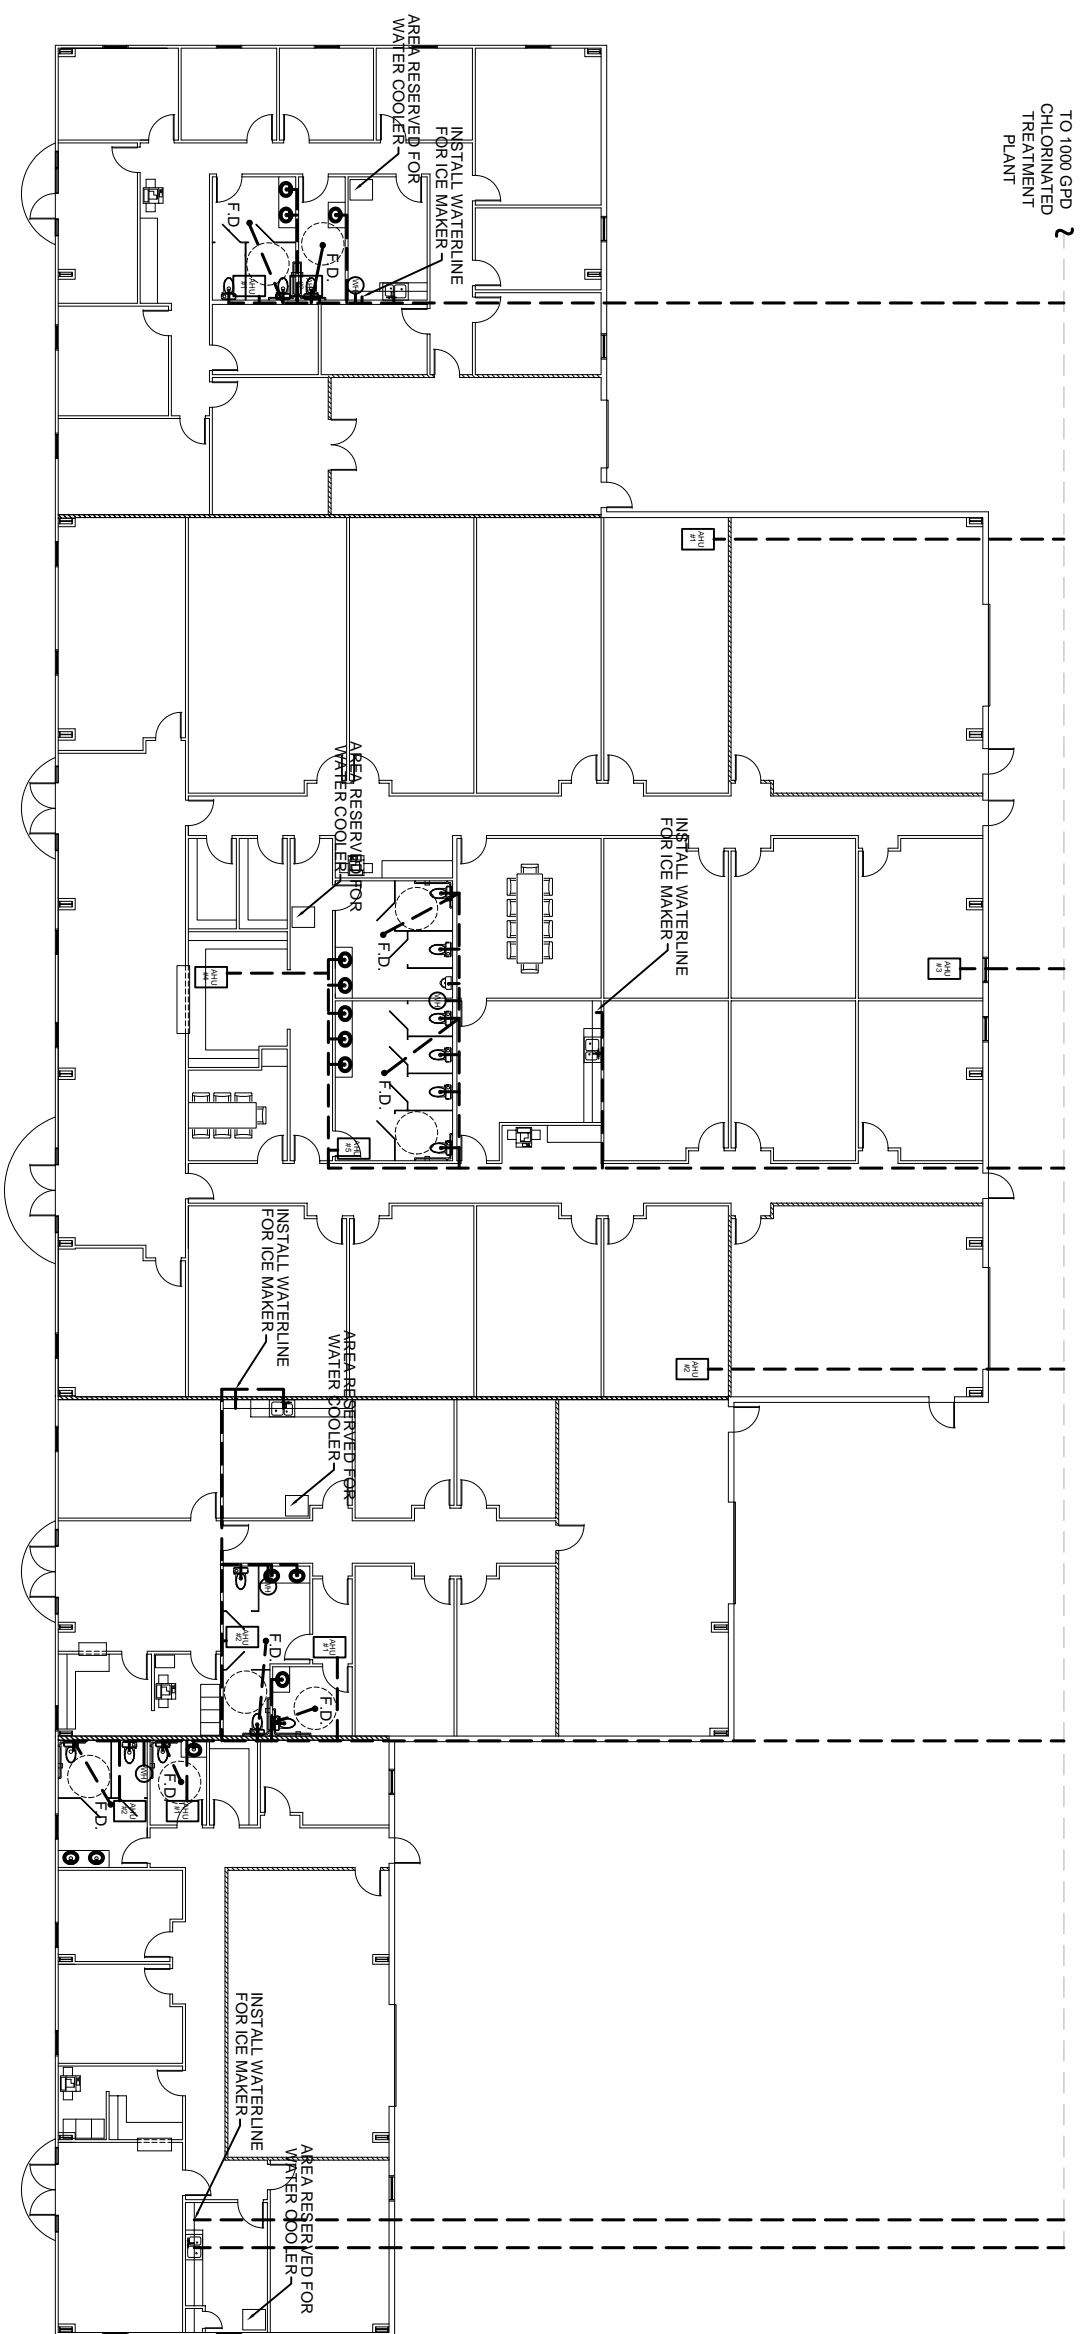

PLUMBING PLAN
SCALE: 3/32"=1'-0"

FOR PLUMBING
NOTES SEE E-2