



DAMMON
ENGINEERING, INC.
EMMETT
DAMMON

ARCHITECT
ROBERT
SOLBERGER
1095 FLORIDA AVENUE
SLIDELL, LA. 70458
985-649-5832

WEBSITE:
WWW.DAMMONENGINEERING.COM
EMAIL:
DAMMONENG@BELLSOUTH.NET

ARCHITECTURE
ENGINEERING
STUDIES
PLANNING
INVESTIGATION
EXPERT WITNESS

**NEW OFFICE
BUILDING**
PLATFORM CRANE
POWELL DRIVE
SLIDELL, LA

**MECHANICAL
PLAN
SUITE C**

REV:

SCALE: AS NOTED



JOB#: 1898

DATE: 10-8-07

SHEET 17

M-3

OF 25

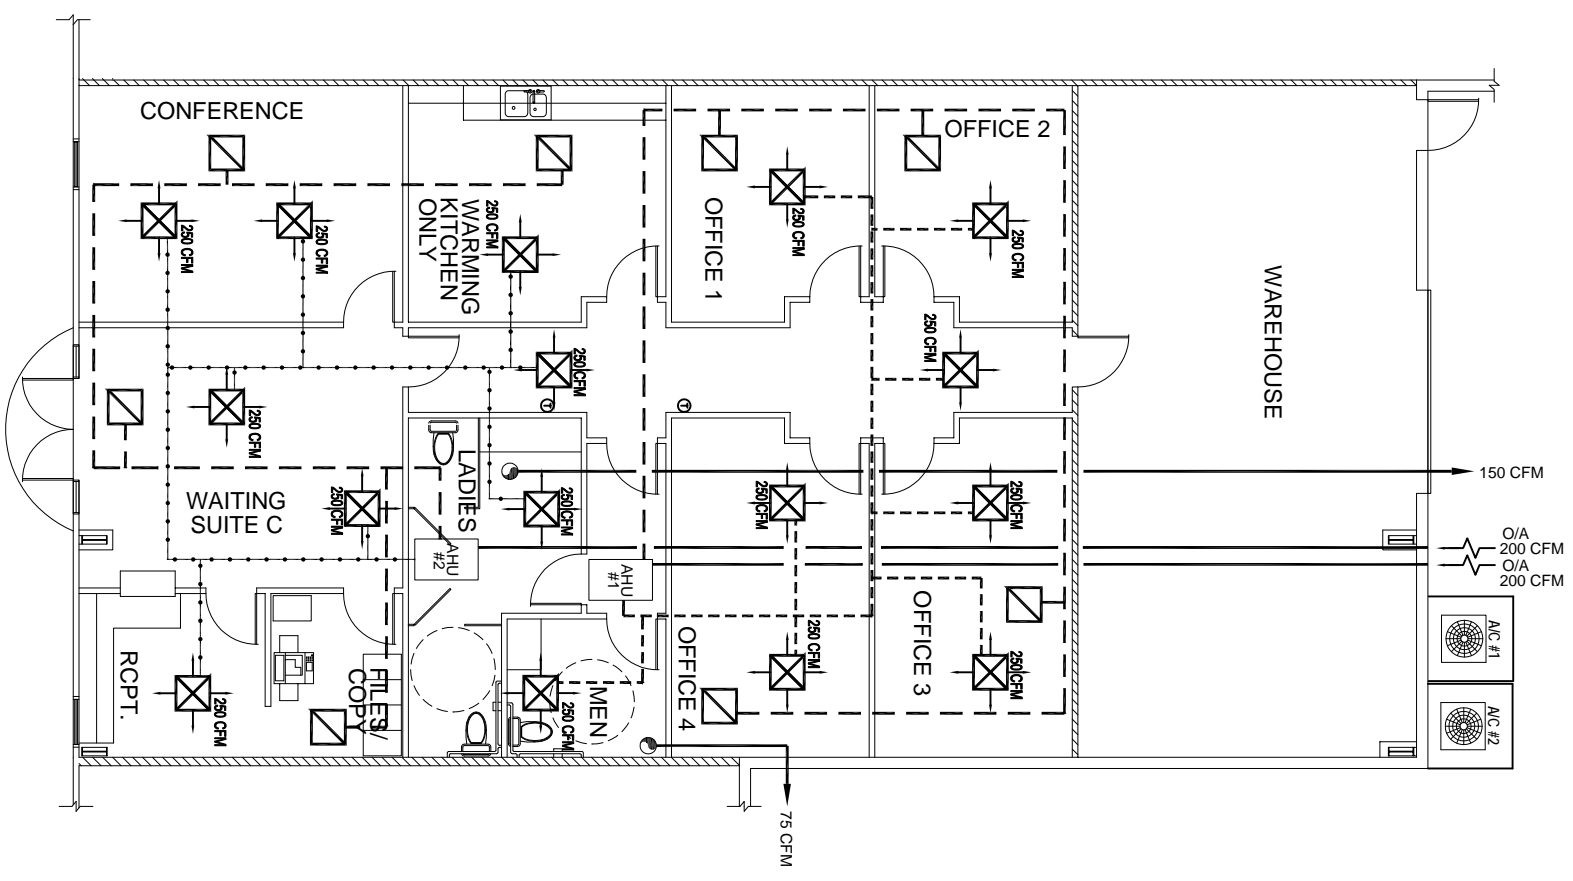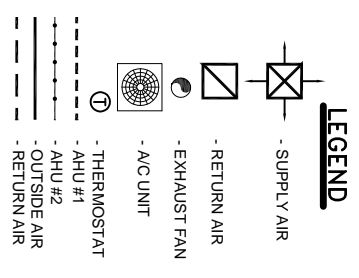

FOR MECHANICAL
NOTES SEE M-1

EXHAUST FAN SCHEDULE

LOC	CFM	VOLTAGE	TYPE	MANUF.
TOILETS	SEE DWG.	120	VENT/LIGHT	-

A/C SPLIT UNIT SCHEDULE

No.	TOTAL BTU	CFM	O.A.	HEAT (KW)	VOLTAGE	ELECTRICAL MCA	REF. BRKS	COMMENTS
1	60,000	2,000	200	20	209V, 3ø	-	MOP-2, 4, 8	CARRIER
2	60,000	2,000	200	20	209V, 3ø	-	MOP-2, 4, 8	CARRIER

MECHANICAL PLAN SUITE C
SCALE: 3/16" = 1'-0"

