



DAMMON ENGINEERING, INC.

EMMETT DAMMON

ARCHITECT
ROBERT SOLBERGER

1095 FLORIDA AVENUE
SLIDELL, LA. 70458
985-649-5832

WEBSITE: WWW.DAMMONENGINEERING.COM

EMAIL: DAMMONENG@BELLSOUTH.NET

ARCHITECTURE
ENGINEERING
STUDIES
PLANNING
INVESTIGATION
EXPERT WITNESS

NEW OFFICE BUILDING

PLATFORM CRANE
POWELL DRIVE
SLIDELL, LA

MECHANICAL PLAN
SUITE C

REV:

SCALE: AS NOTED



JOB#: 1898

DATE: 10-8-07

SHEET 17

M-3

OF 25

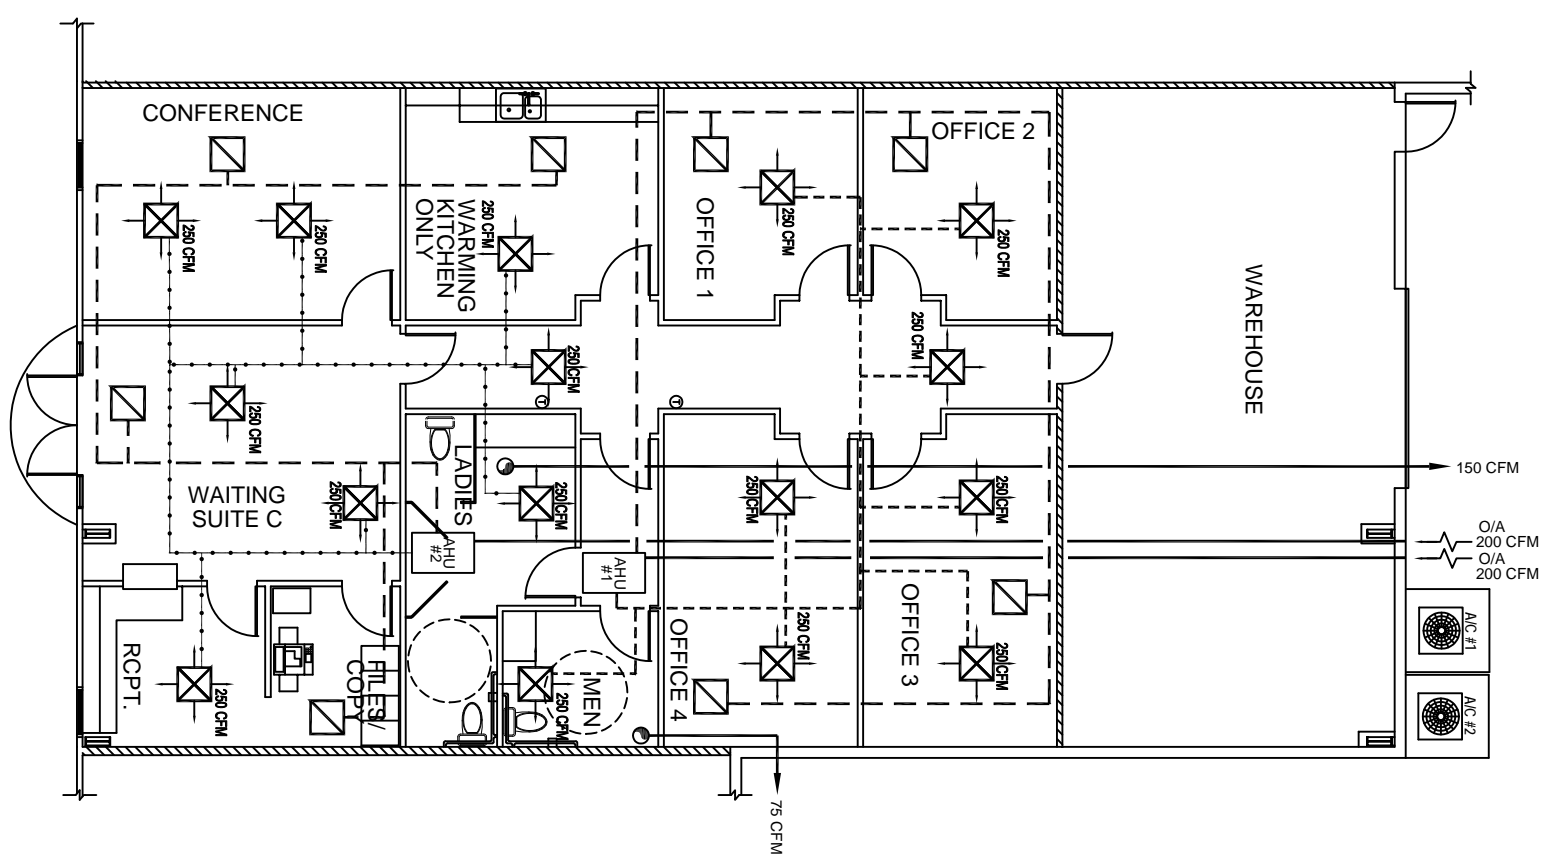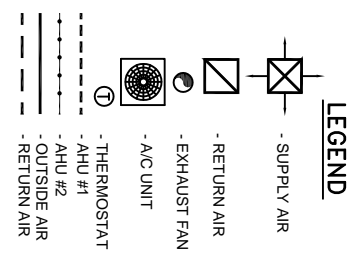

FOR MECHANICAL NOTES SEE M-1

EXHAUST FAN SCHEDULE

LOC	CFM	VOLTAGE	TYPE	MANF.
TOILETS	SEE DWG	120	VENT/LIGHT	-

A/C SPLIT UNIT SCHEDULE

NO.	TOTAL TONN	CFM	O.A. CFM	HEAT (KW)	VOLTAGE	ELECTRICAL MCK	CRCT BRKR	COMMENTS
1	60,000	2,000	200	20	208V/3P	-	MDP3-2,4,6	CARRIER
2	60,000	2,000	200	20	208V/3P	-	MDP3-8,10,12	CARRIER

MECHANICAL PLAN SUITE C
SCALE: 3/16"=1'-0"