

**DAMMON**  
ENGINEERING, INC.

CHIEF ENGINEER  
EMMETT  
DAMMON, P.E.  
CHIEF ARCHITECT  
ROBERT  
WILTSE

1095 FLORIDA AVENUE  
SLIDELL, LA. 70456  
OFFICE: 985-649-5832  
FAX: 985-641-5950


WEBSITE: [WWW.DAMMONENGINEERING.COM](http://WWW.DAMMONENGINEERING.COM)  
EMAIL: [DAMMONENG@BELLSOUTH.NET](mailto:DAMMONENG@BELLSOUTH.NET)

ARCHITECTURE  
ENGINEERING  
STUDIES  
PLANNING  
INVESTIGATION  
EXPERT WITNESS

NEW  
WAREHOUSE

BOB BAKER  
CAMP VILLERE  
SLIDELL, LA

POWER  
PLAN

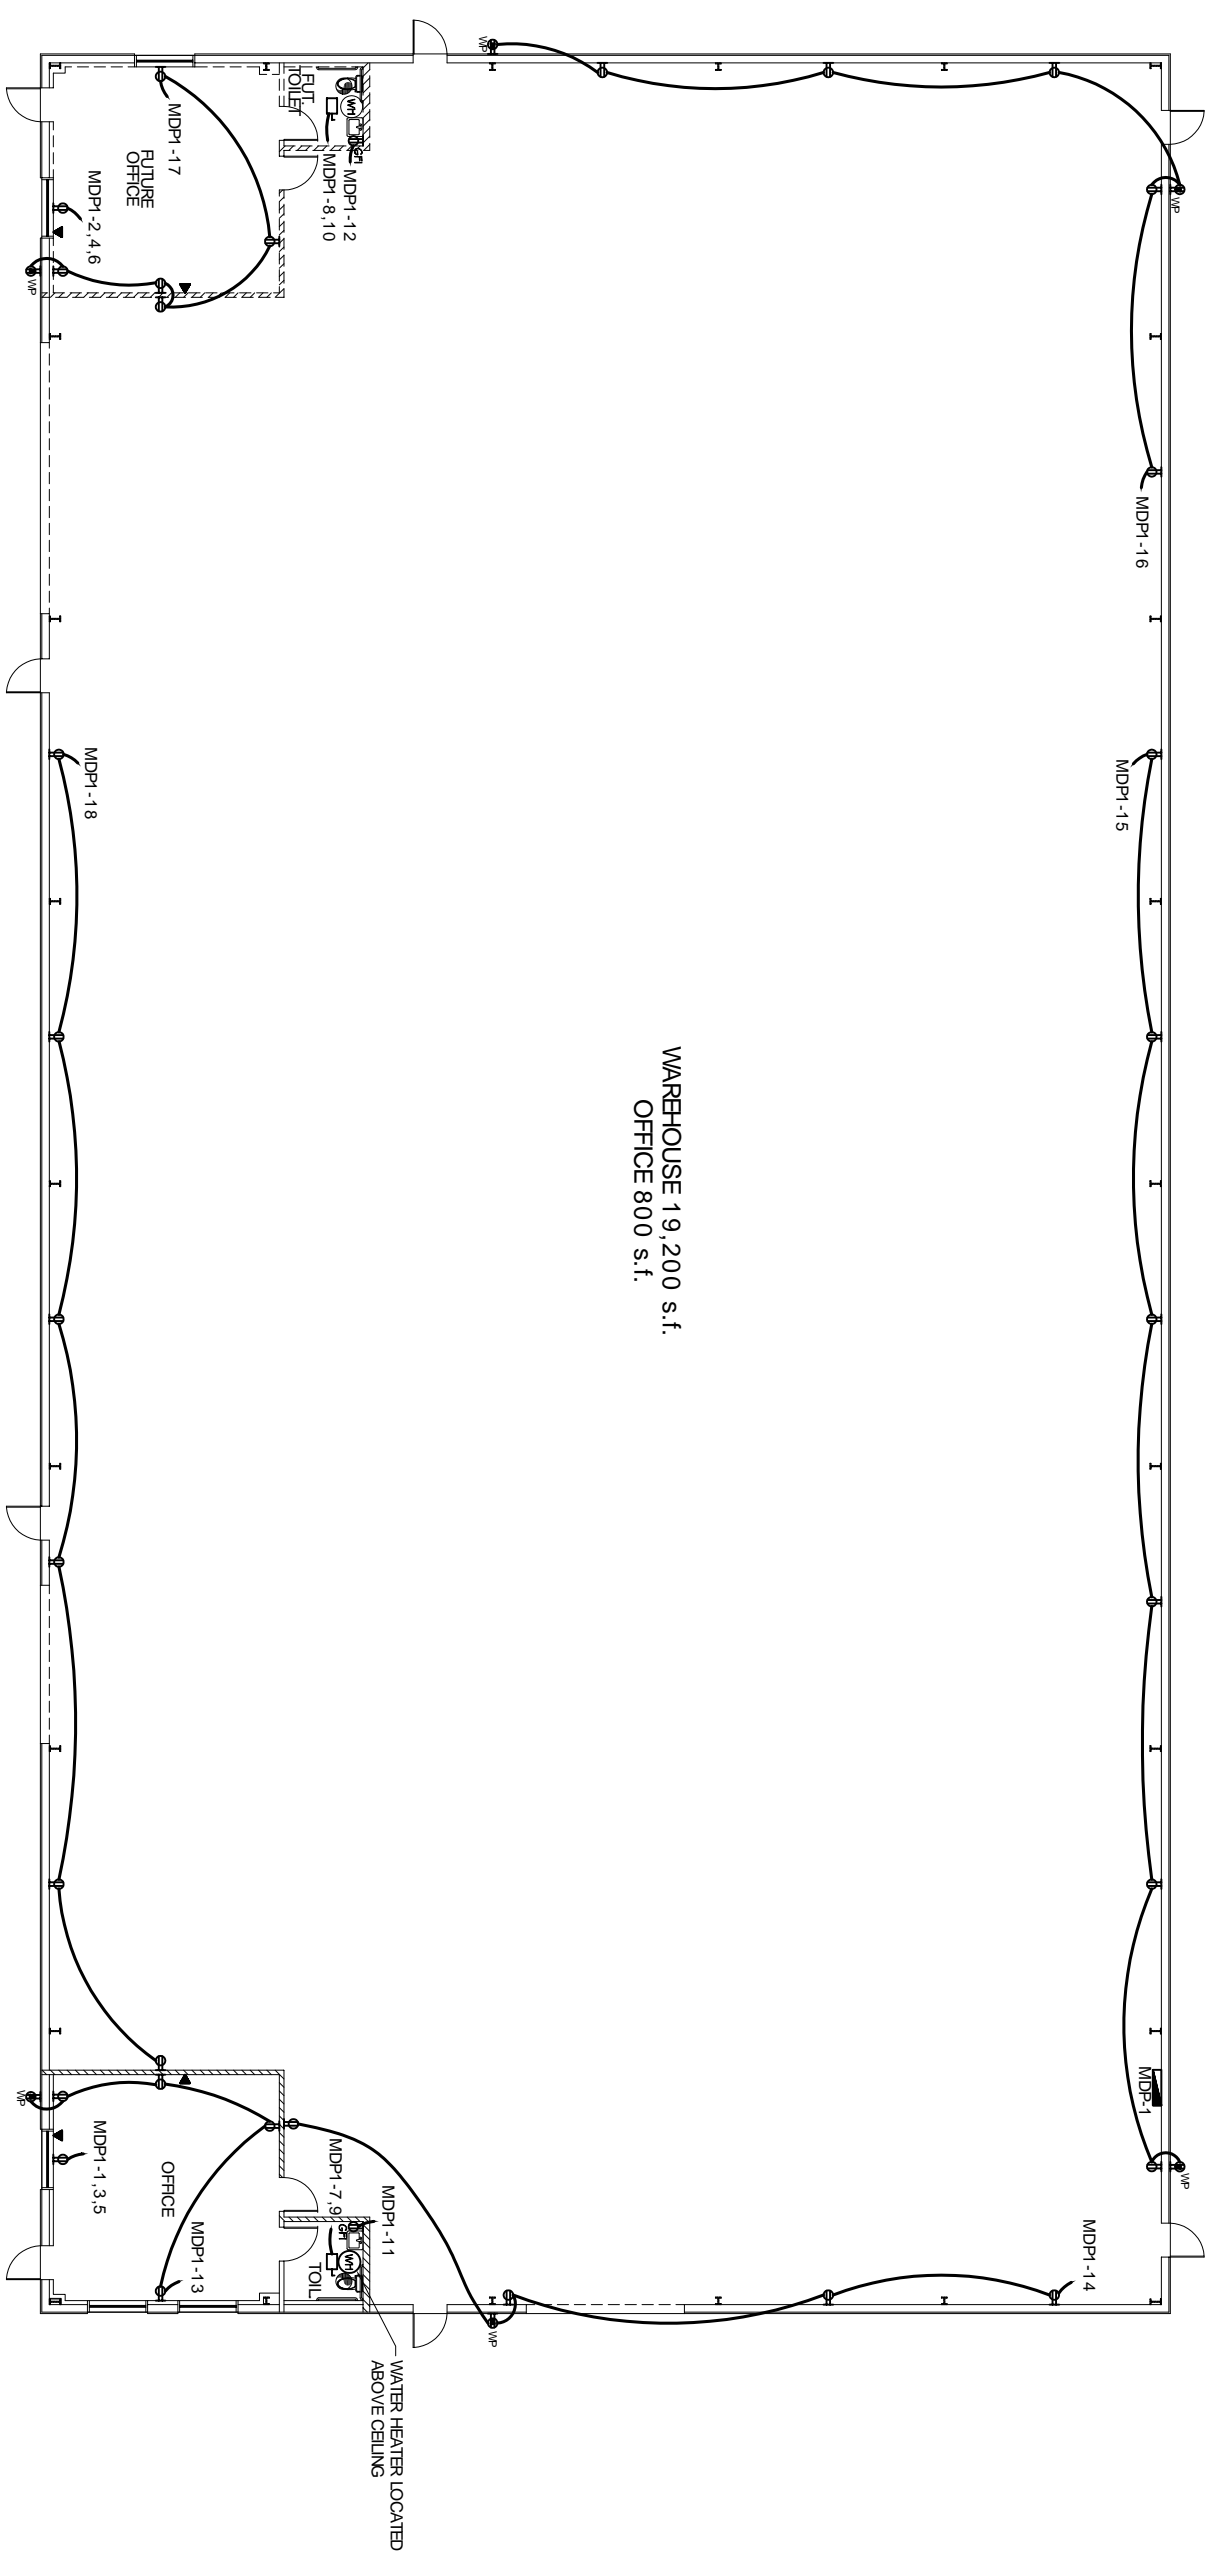

WAREHOUSE 19,200 s.f.  
OFFICE 800 s.f.

POWER PLAN  
SCALE 1/8" = 1'-0"



SEE E-3 FOR ELECTRICAL NOTES

**LEGEND**

- ⊕ - 120V, 20A DUPLEX RECEPTACLE
- ⊕<sub>GR</sub> - 120V, GR RECEPTACLE
- ⊕<sub>WP</sub> - 120V, WEATHER PROOF RECEPTACLE
- ⬮ - POWER PANEL
- ⬮ - TELEPHONE/COMPUTER
- ⬮ - EXHAUST FAN
- ⊕<sub>MH</sub> - 5 GAL WATER HEATER
- ⊔ - FUSED DISCONNECT

REV:

SCALE: AS NOTED

JOB#: 1927

DATE: 3-28-08

SHEET 16

E-1

OF 19