

DAMMON
ENGINEERING, INC.

CHIEF ENGINEER
EMMETT
DAMMON, P.E.
CHIEF ARCHITECT
ROBERT
WILTSE

1 095 FLORIDA AVENUE
SLIDELL, LA. 70456
OFFICE: 985-649-5832
FAX: 985-641-5950

WEBSITE:
WWW.DAMMONENGINEERING.COM
EMAIL:
DAMMONENG@BELLSOUTH.NET

ARCHITECTURE
ENGINEERING
STUDIES
PLANNING
INVESTIGATION
EXPERT WITNESS

NEW
WAREHOUSE

BOB BAKER
CAMP VILLERE
SLIDELL, LA

LIGHTING
PLAN

REV:

SCALE: AS NOTED


JOB#: 1927

DATE: 3-28-08

SHEET 17

E-2

OF 19

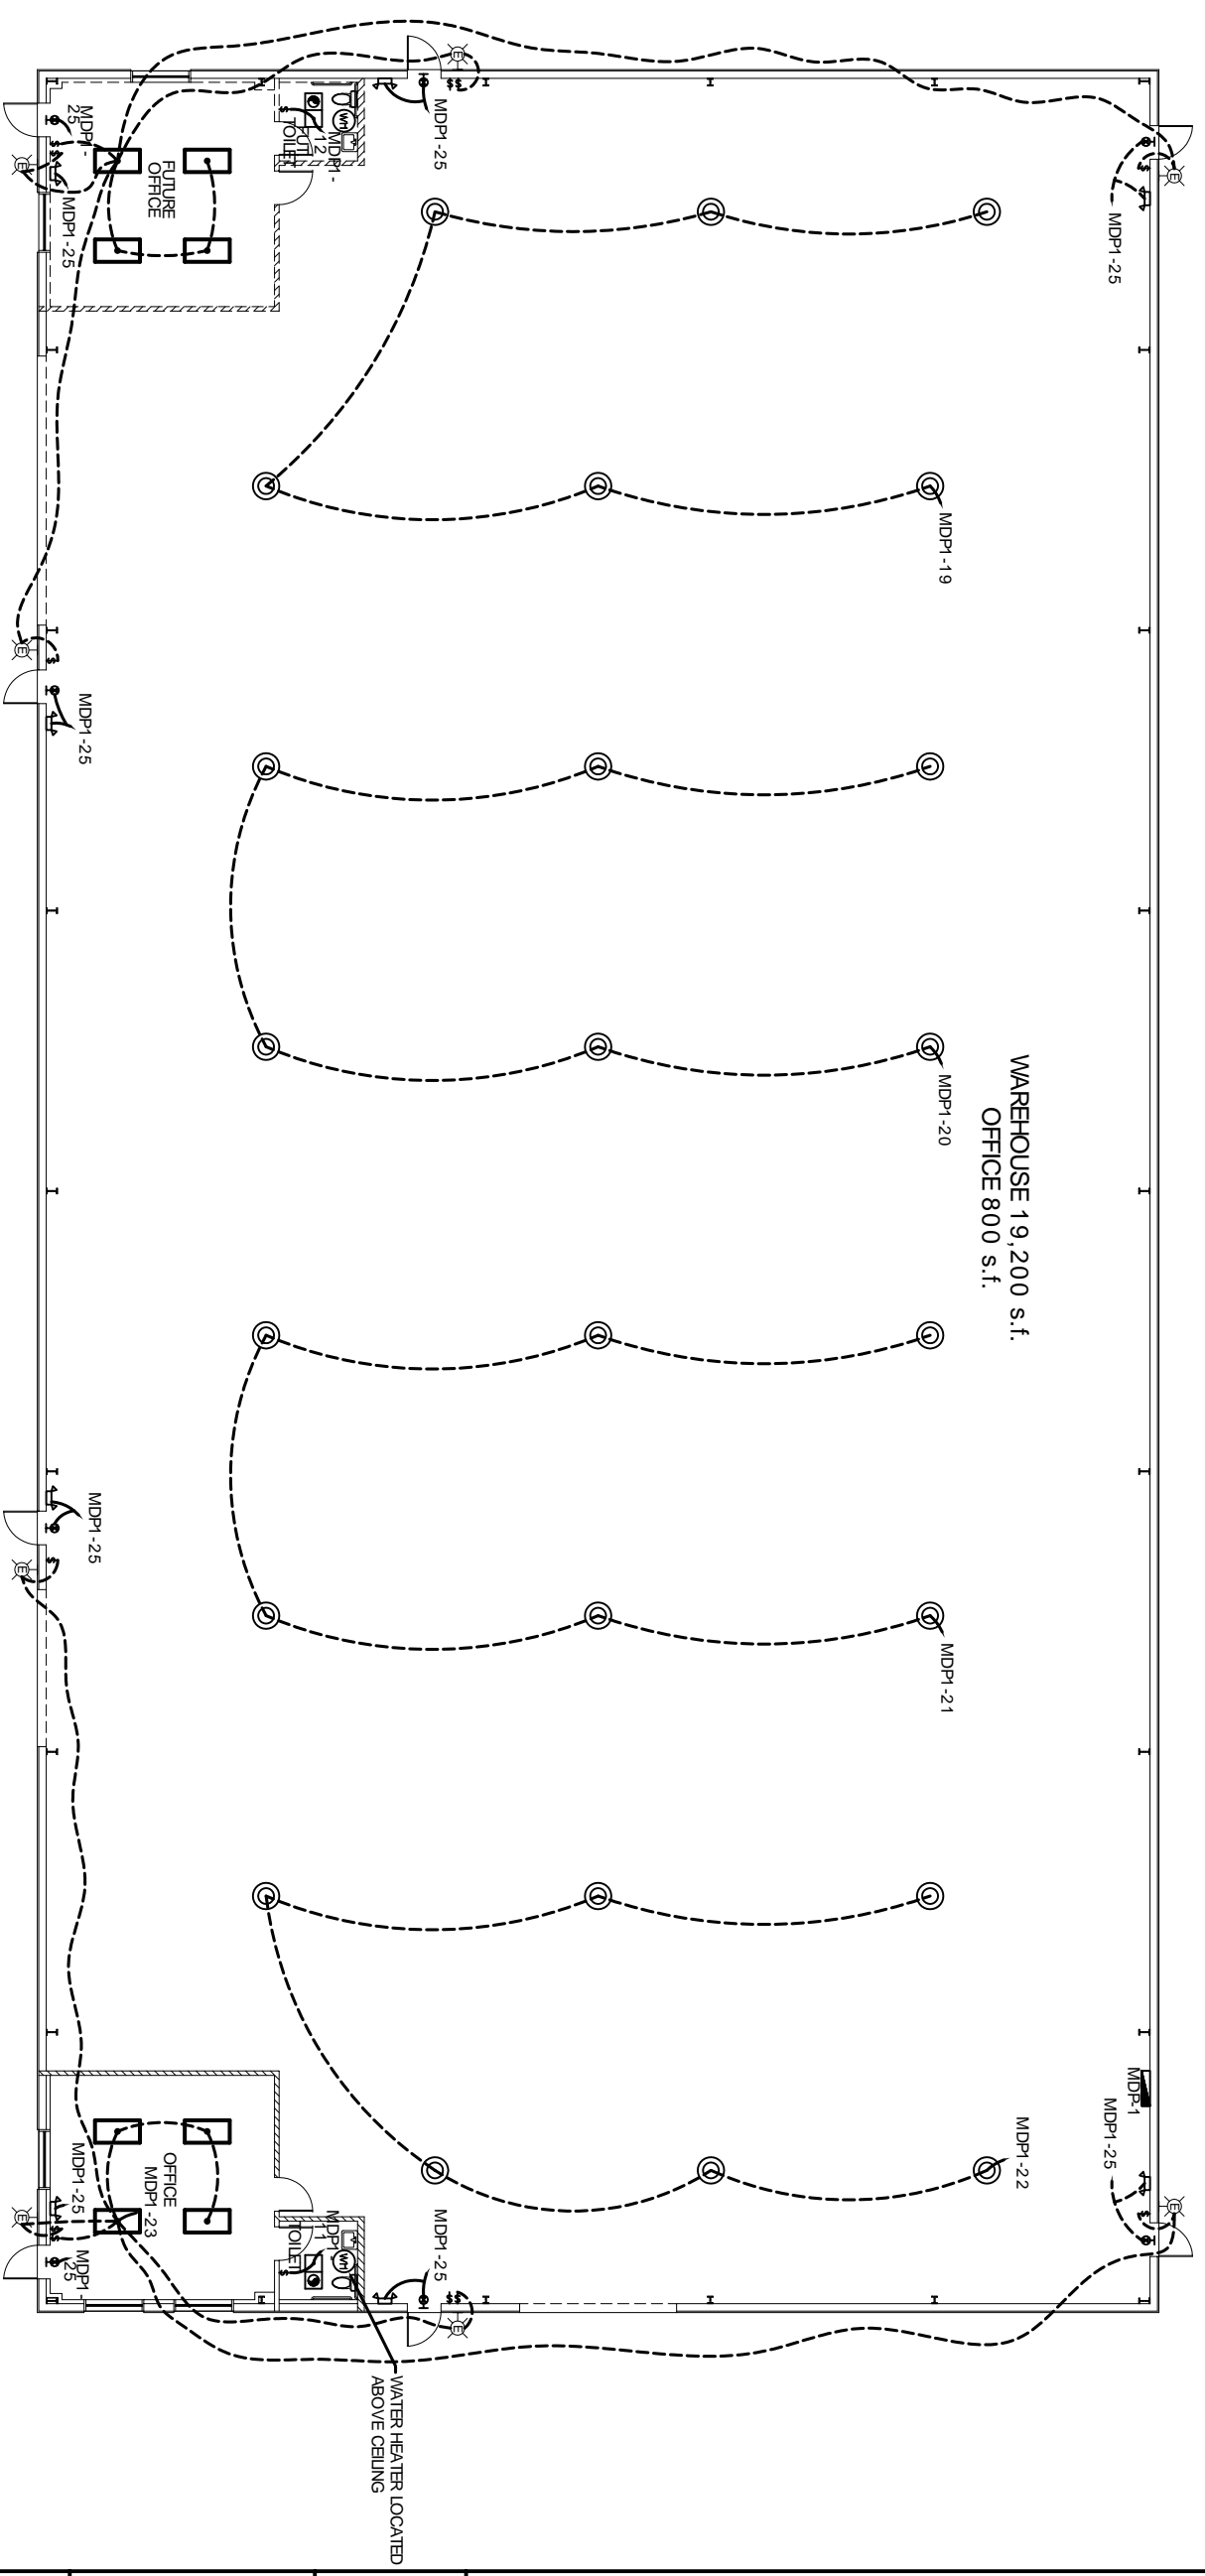

WAREHOUSE 19,200 S.F.
OFFICE 800 S.F.

LIGHTING PLAN
SCALE 1/8" = 1'-0"

SEE E-3 FOR ELECTRICAL NOTES

- LEGEND**
- - 2'x4' RECESSED FLUORESCENT LAMP, STEEL HOUSING
 - ⊕ - EXT LIGHT, 90 MINUTE BATTERY BACK-UP
 - ⊖ - EMERGENCY LIGHT WITH 90 MIN BATTERY BACKUP
 - ⊗ - EXTERIOR WALL MOUNT FIXTURE
 - ⚡ - SWITCH
 - ⊙ - HIGH BAY LIGHT
 - ⊞ - POWER PANEL
 - ⊞ - 5 GAL WATER HEATER
 - ⊞ - VENTILIGHT