

**DAMMON**  
ENGINEERING, INC.

CHIEF ENGINEER  
EMMETT  
DAMMON, P.E.  
CHIEF ARCHITECT  
ROBERT  
WILTSE

1095 FLORIDA AVENUE  
SUDDELL, LA. 70458  
OFFICE: 985-649-5832  
FAX: 985-641-3990

WWW.DAMMONENGINEERING.COM  
EMAIL: DAMMONENG@BELLSOUTH.NET

ARCHITECTURE  
ENGINEERING  
STUDIES  
PLANNING  
INVESTIGATION  
EXPERT WITNESSES

**WINDWARD, INC.**  
37362  
BROWNSVILLE RD.  
SUDDELL, LA. 70460

ELECTRICAL  
POWER  
PLAN

REV:

SCALE: AS NOTED


JOB#: 19344A

DATE: 07-18-08

SHEET 8

**E-1**

OF 11

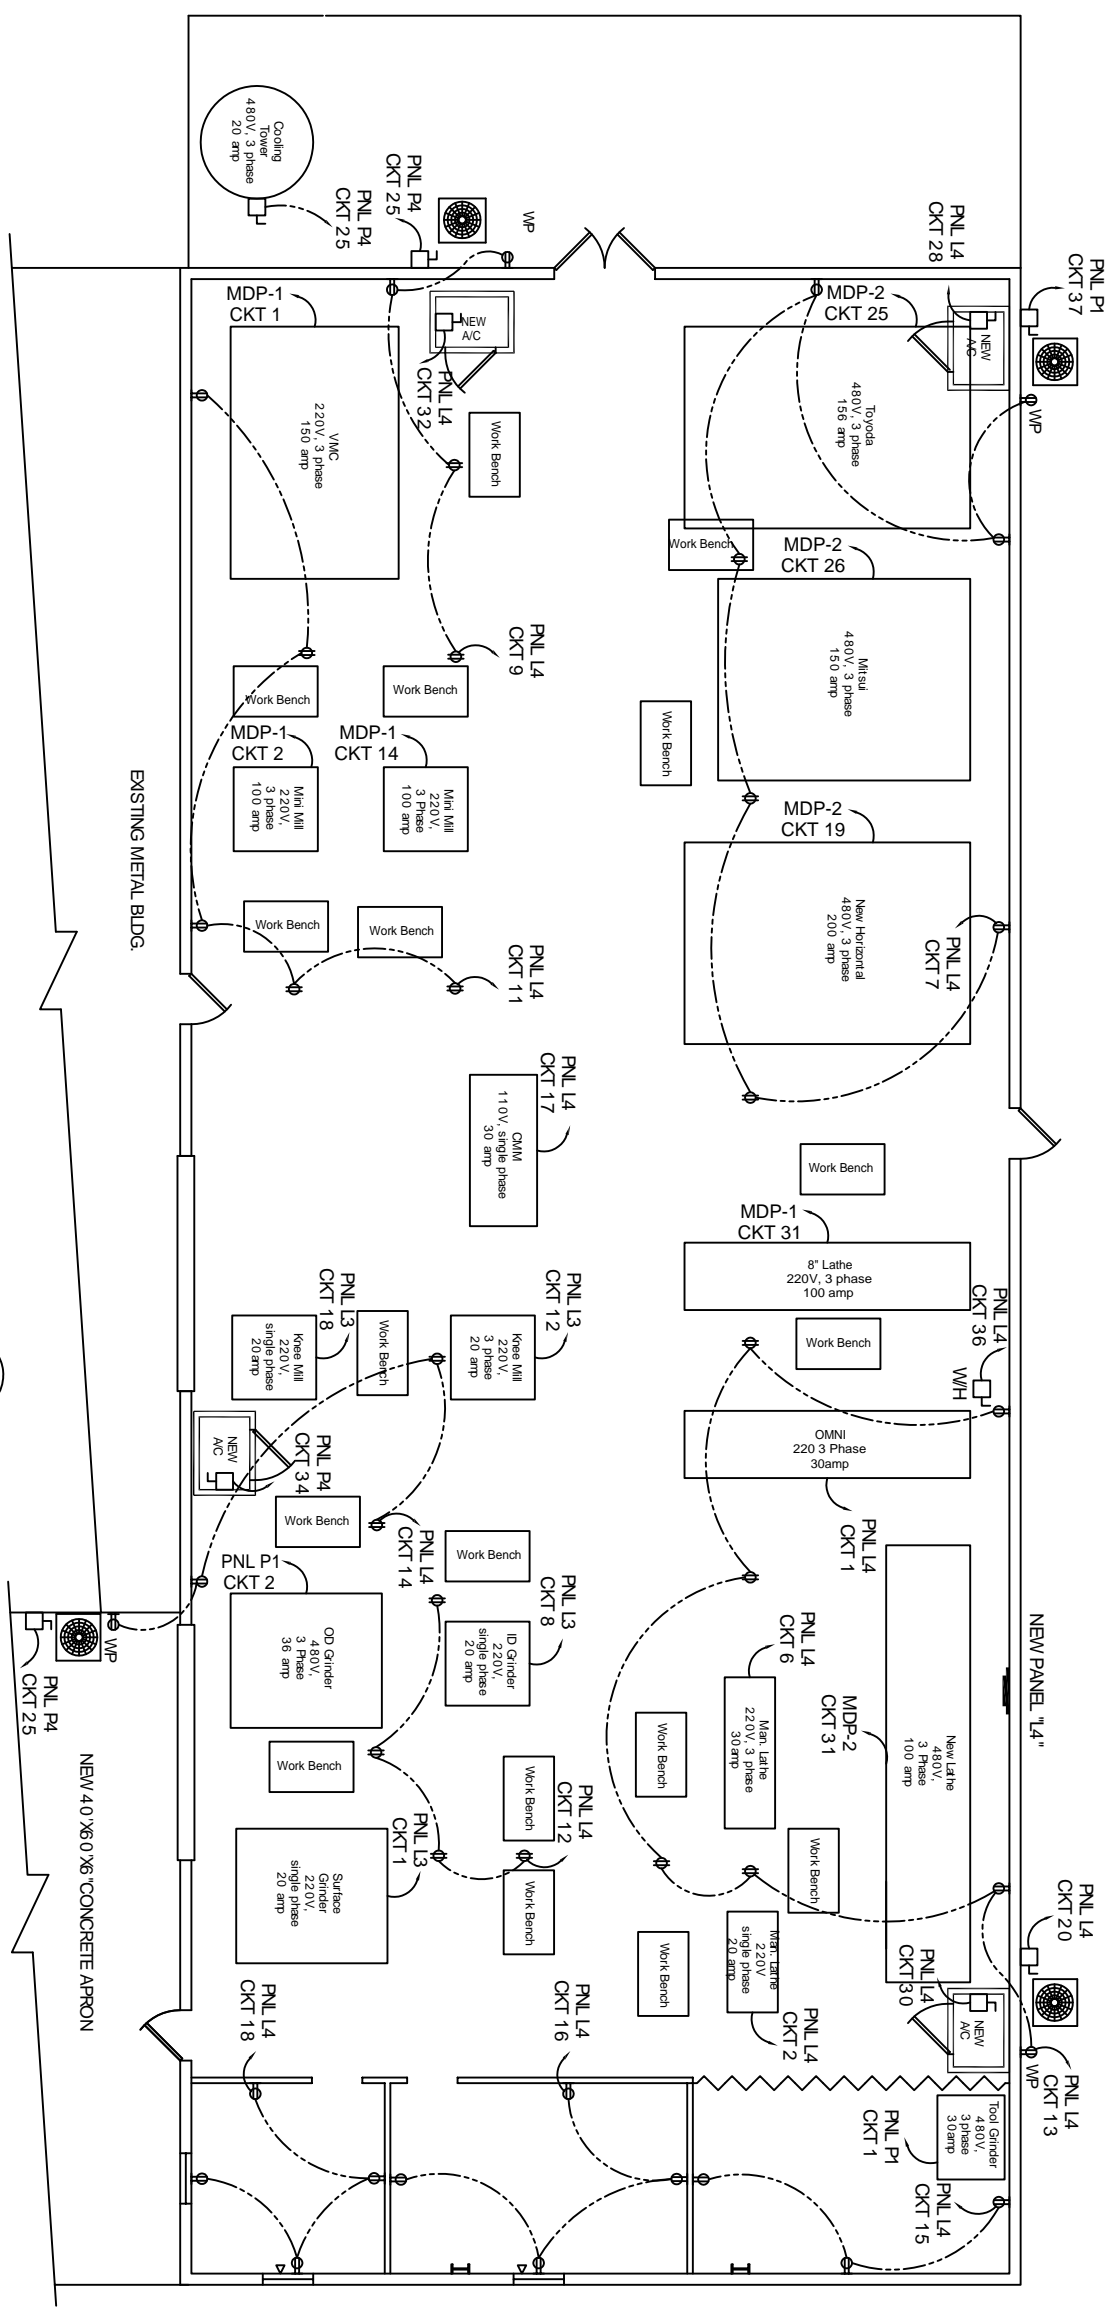

**POWER PLAN**  
SCALE: 3/16"=1'-0"



**LEGEND**

- WP GF1 - 120V, 20A DUPLEX GF1 RECEPTACLE, WEATHER PROOF
- GF1 - 120V, 20A DUPLEX GF1 RECEPTACLE ON HOSE REEL
- GF2 - 120V, 20A DUPLEX GF1 RECEPTACLE
- ⊙ - JUNCTION BOX
- ▭ - POWER PANEL
- ▷ - TELEPHONE/COMPUTER
- ⊠ - DISCONNECT