


D:\WORK - A\1 - Pools\2019 - Terra Bella Pool\2019-01-11 Pool Piping Plan.dwg - 2019-01-11 10:02:00

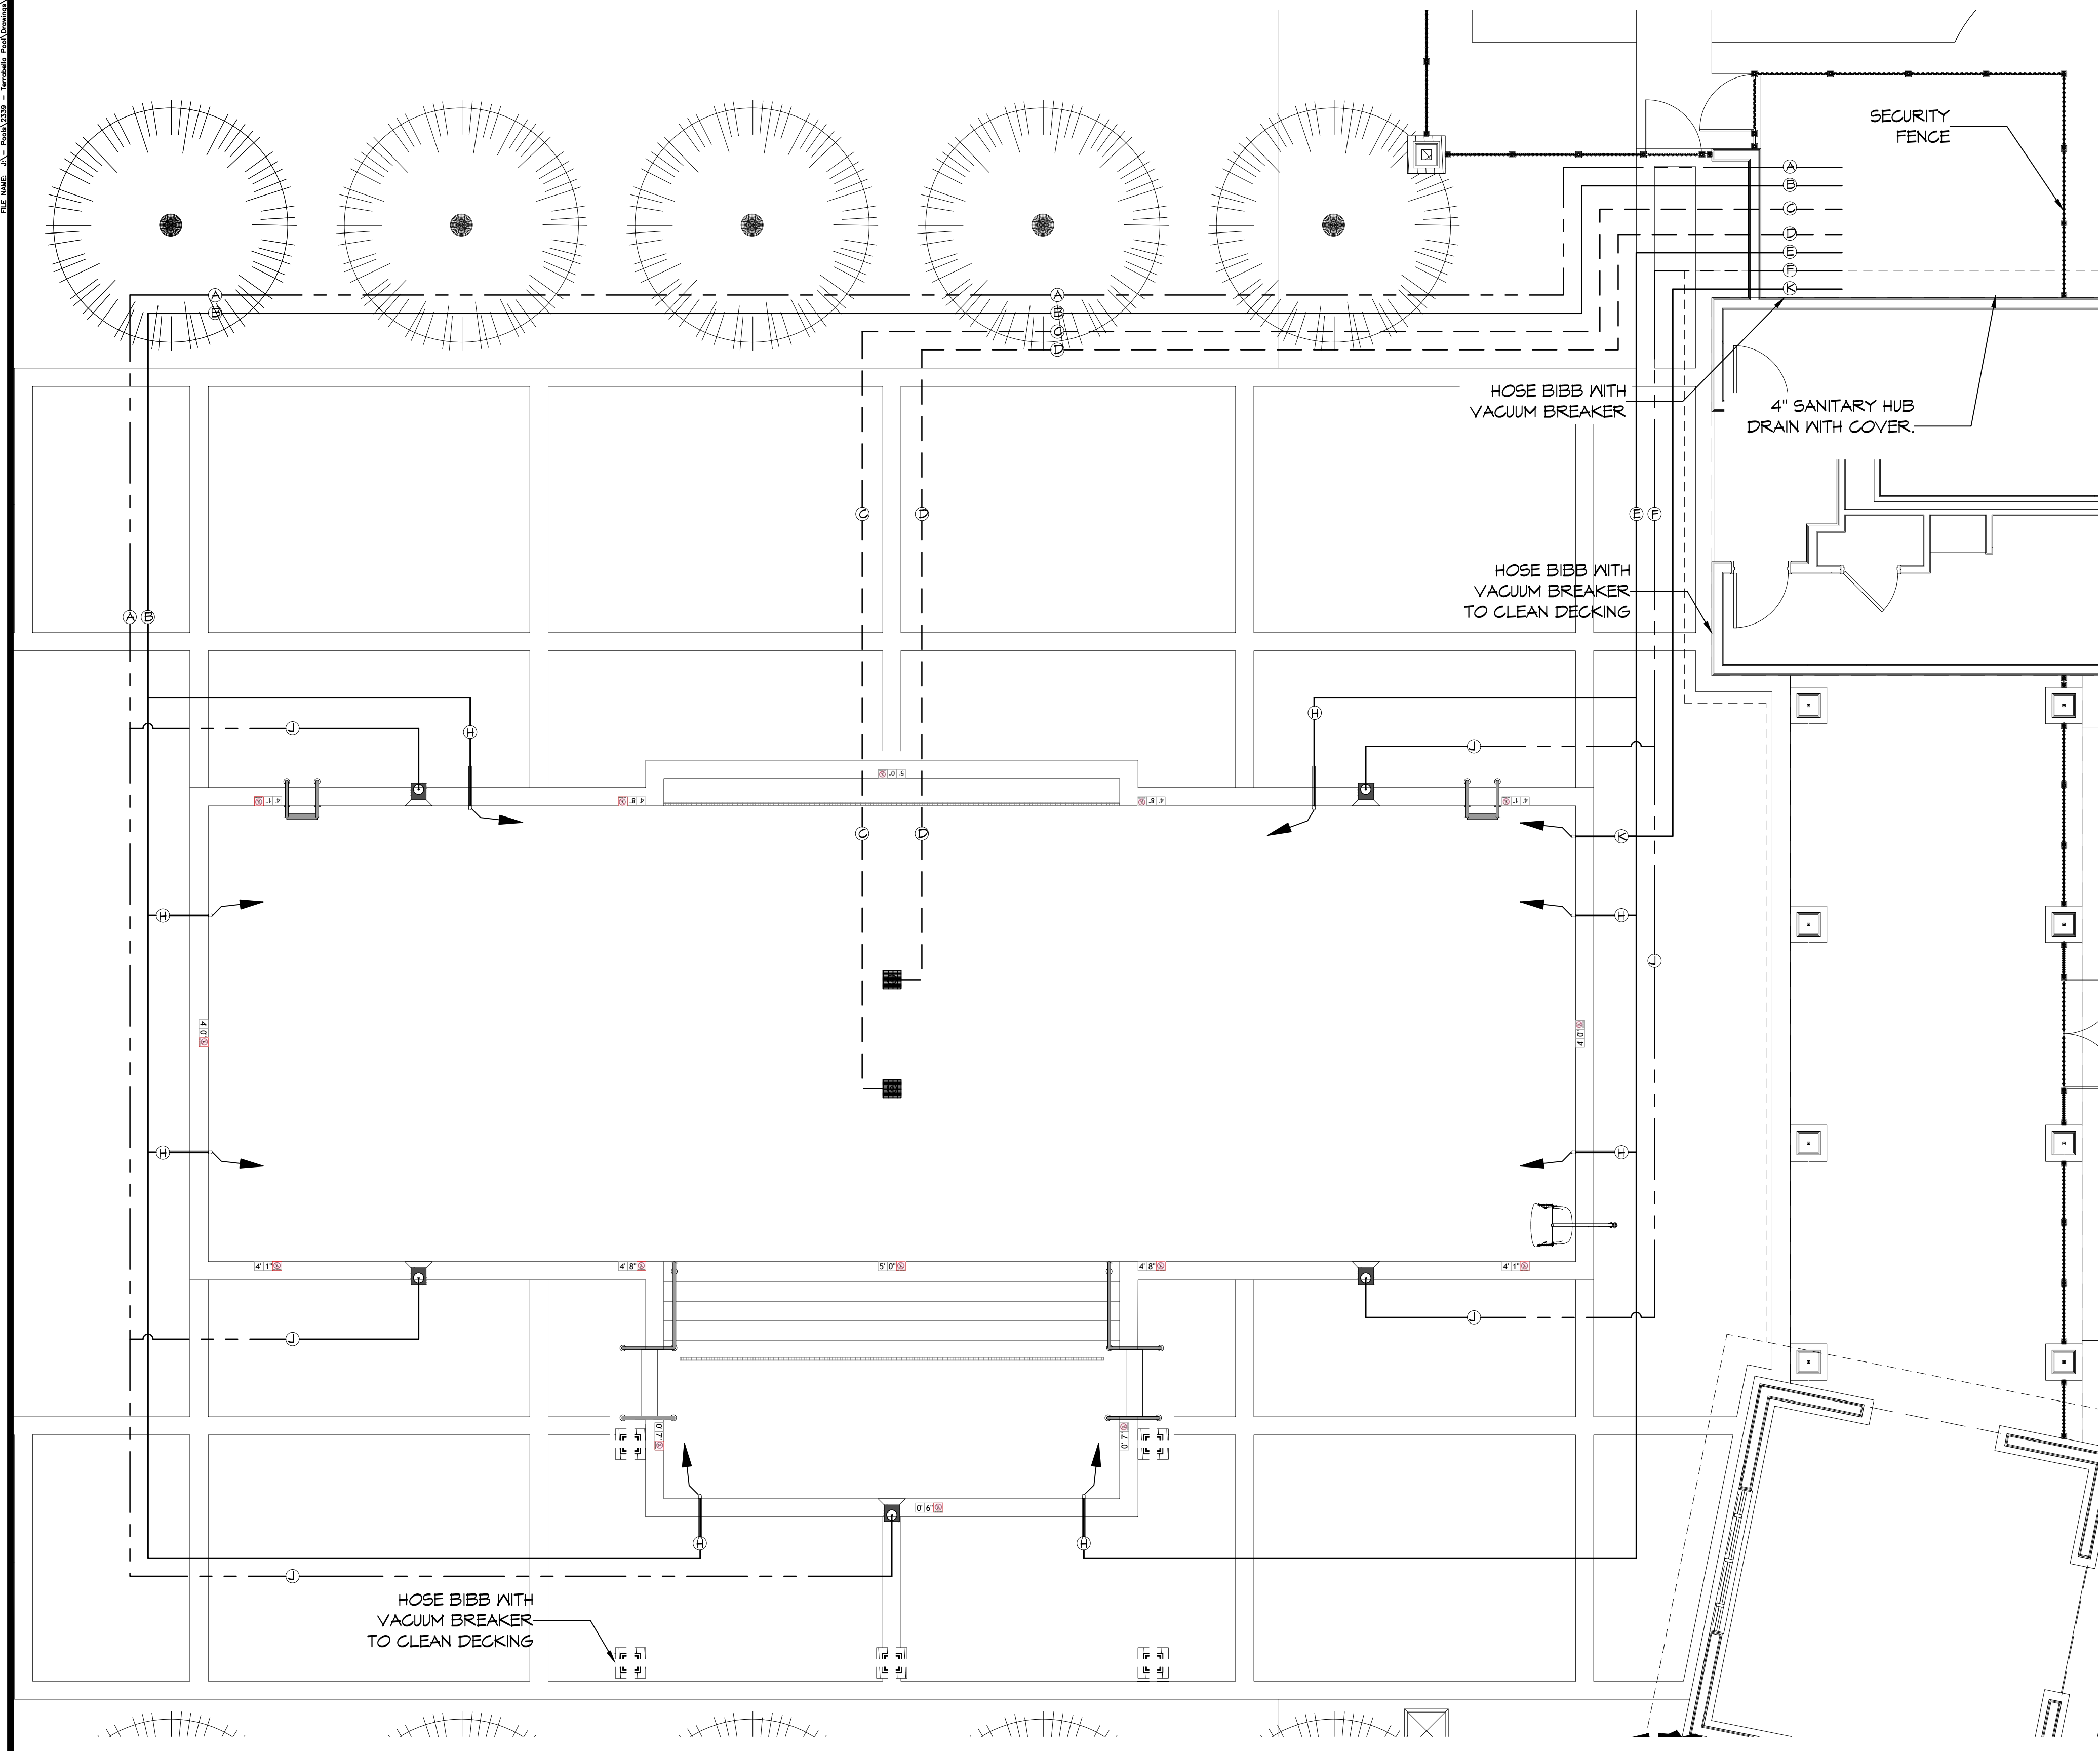

PIPE SCHEDULE					
PIPE ID	DESCRIPTION	SIZE	TYPE	FLOW RATE	VELOCITY
A	SKIMMER SUCTION	2.0 INCH	SCH 40 PVC	GPM	FPS
B	RETURN LINE	2.0 INCH	SCH 40 PVC	GPM	FPS
C	MAIN DRAIN	2.0 INCH	SCH 40 PVC	GPM	FPS
D	MAIN DRAIN	2.0 INCH	SCH 40 PVC	GPM	FPS
E	RETURN LINE	2.0 INCH	SCH 40 PVC	GPM	FPS
F	SKIMMER SUCTION	2.0 INCH	SCH 40 PVC	GPM	FPS
H	INDIVIDUAL RETURN LINE	1.5 INCH	SCH 40 PVC	GPM	FPS
J	INDIVIDUAL SKIMMER	2.0 INCH	SCH 40 PVC	GPM	FPS
K	FILL LINE	2.0 INCH	SCH 40 PVC	N/A	N/A

SYMBOL IDENTIFICATION LEGEND

- ADA POOL LIFT PER CODE
- SKIMMER (NSF CERTIFIED - VGB 2011 COMPLIANT)
- MAIN DRAIN (NSF CERTIFIED - VGB 2011 COMPLIANT)
- WALL INLET FITTING FOR SENSOR
- ADJUSTABLE EYEBALL WALL INLET
- MAIN DRAIN (VGB AND NSF COMPLIANT)
- 1.90" O.D. S.S. HANDRAIL PER CODE
- 1.90" O.D. S.S. LADDER PER CODE
- DEPTH MARKERS PER CODE
- UNDER WATER POOL LIGHTING

1 POOL PIPING PLAN
 SCALE: 3/16" = 1'-0"

DAMMON ENGINEERING, INC.
 LOUISIANA & MISSISSIPPI
 Chief Engineer: Brian Mitchell, PE
 554 Old Spanish Trail
 Slidell, LA 70458
 www.dammonengineering.com
 info@dammonengineering.com
 PH: 985.649.5832

#	DESCRIPTION	DATE

SEAL:

NEW POOL
TERRABELLA POOL
 PROJECT ADDRESS: _____
 JOB No: 2399 DATE: _____
 DRAWN BY: _____ CHECKED BY: _____

SHEET TITLE:
 POOL PIPING PLAN

DRAWING NUMBER:
PL-3.1