



FILE NAME: \\s1-00001339 - Terrabella\proj\00001339\00001339.dwg - Date: 10/20/2010 10:54:04 AM - User: brian.mistich

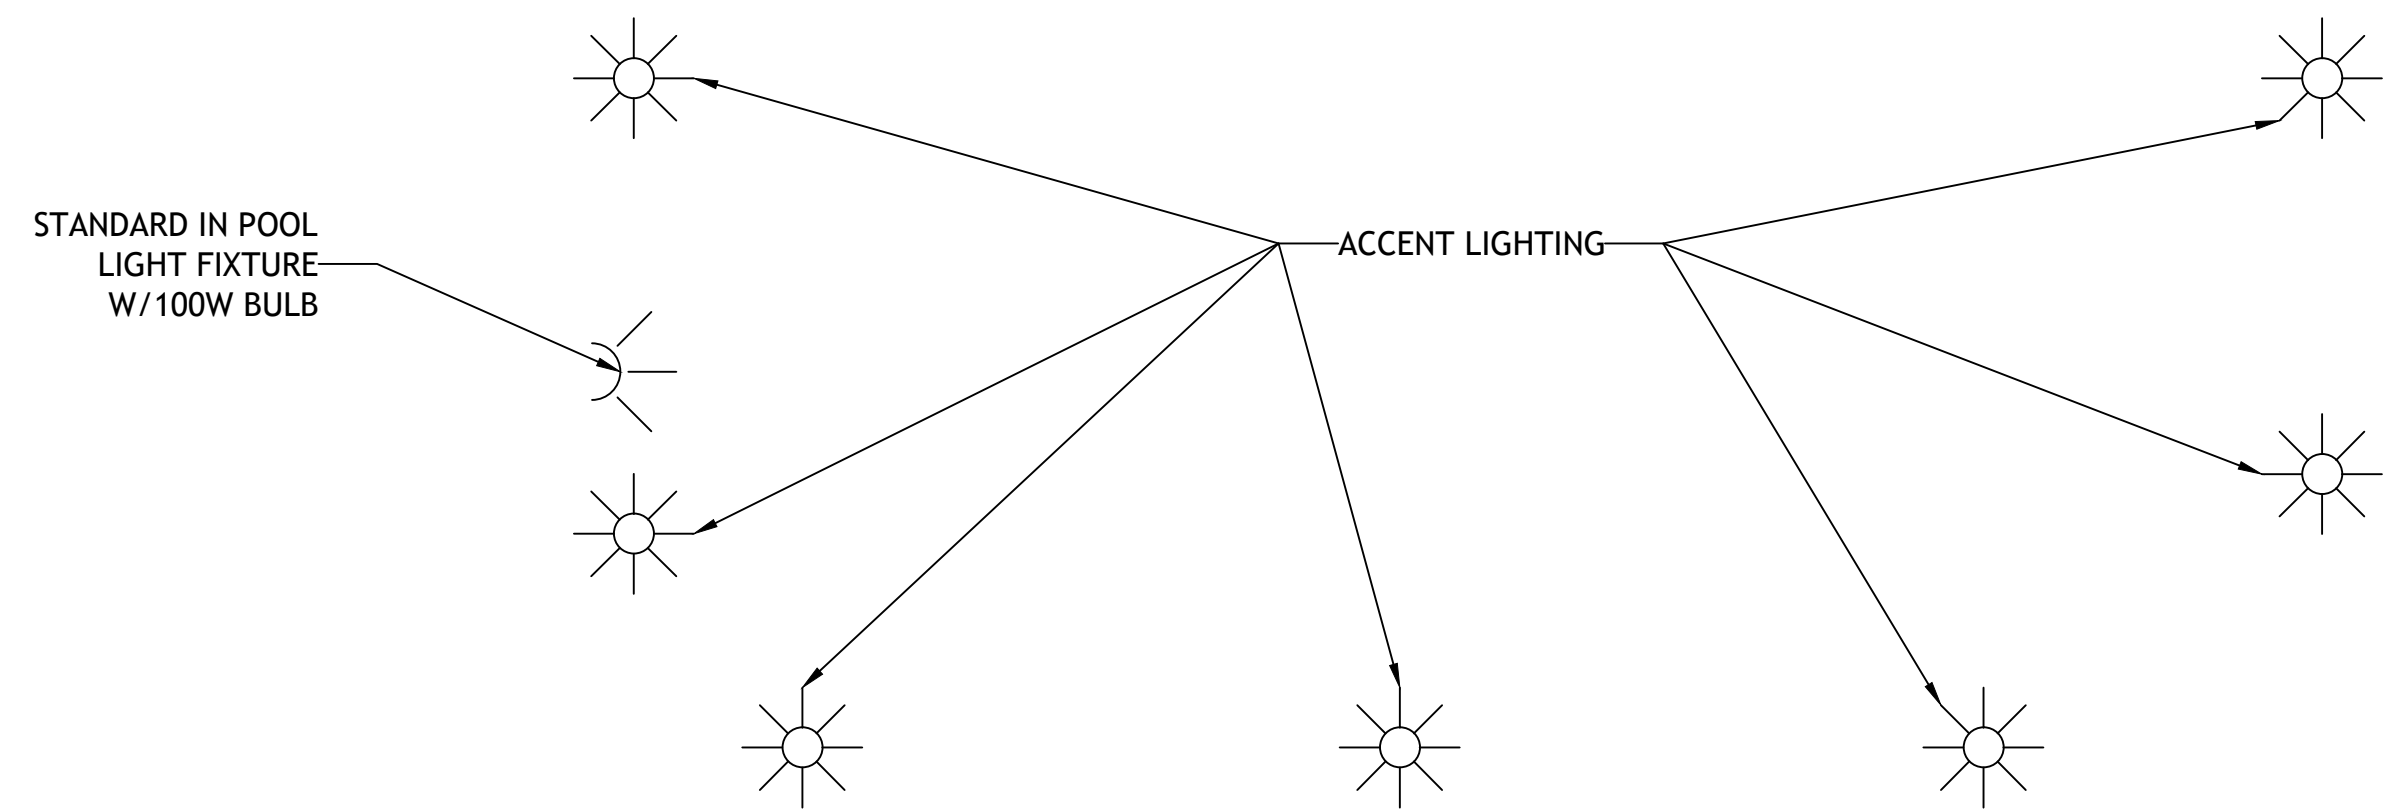

NOTE: INSTALL ACCENT LIGHTING ON VERTICAL SURFACES NEXT TO LIGHTS SHOWN.

2 POOL LIGHTING PLAN
SCALE: N.T.S.

ACCENT LIGHTING

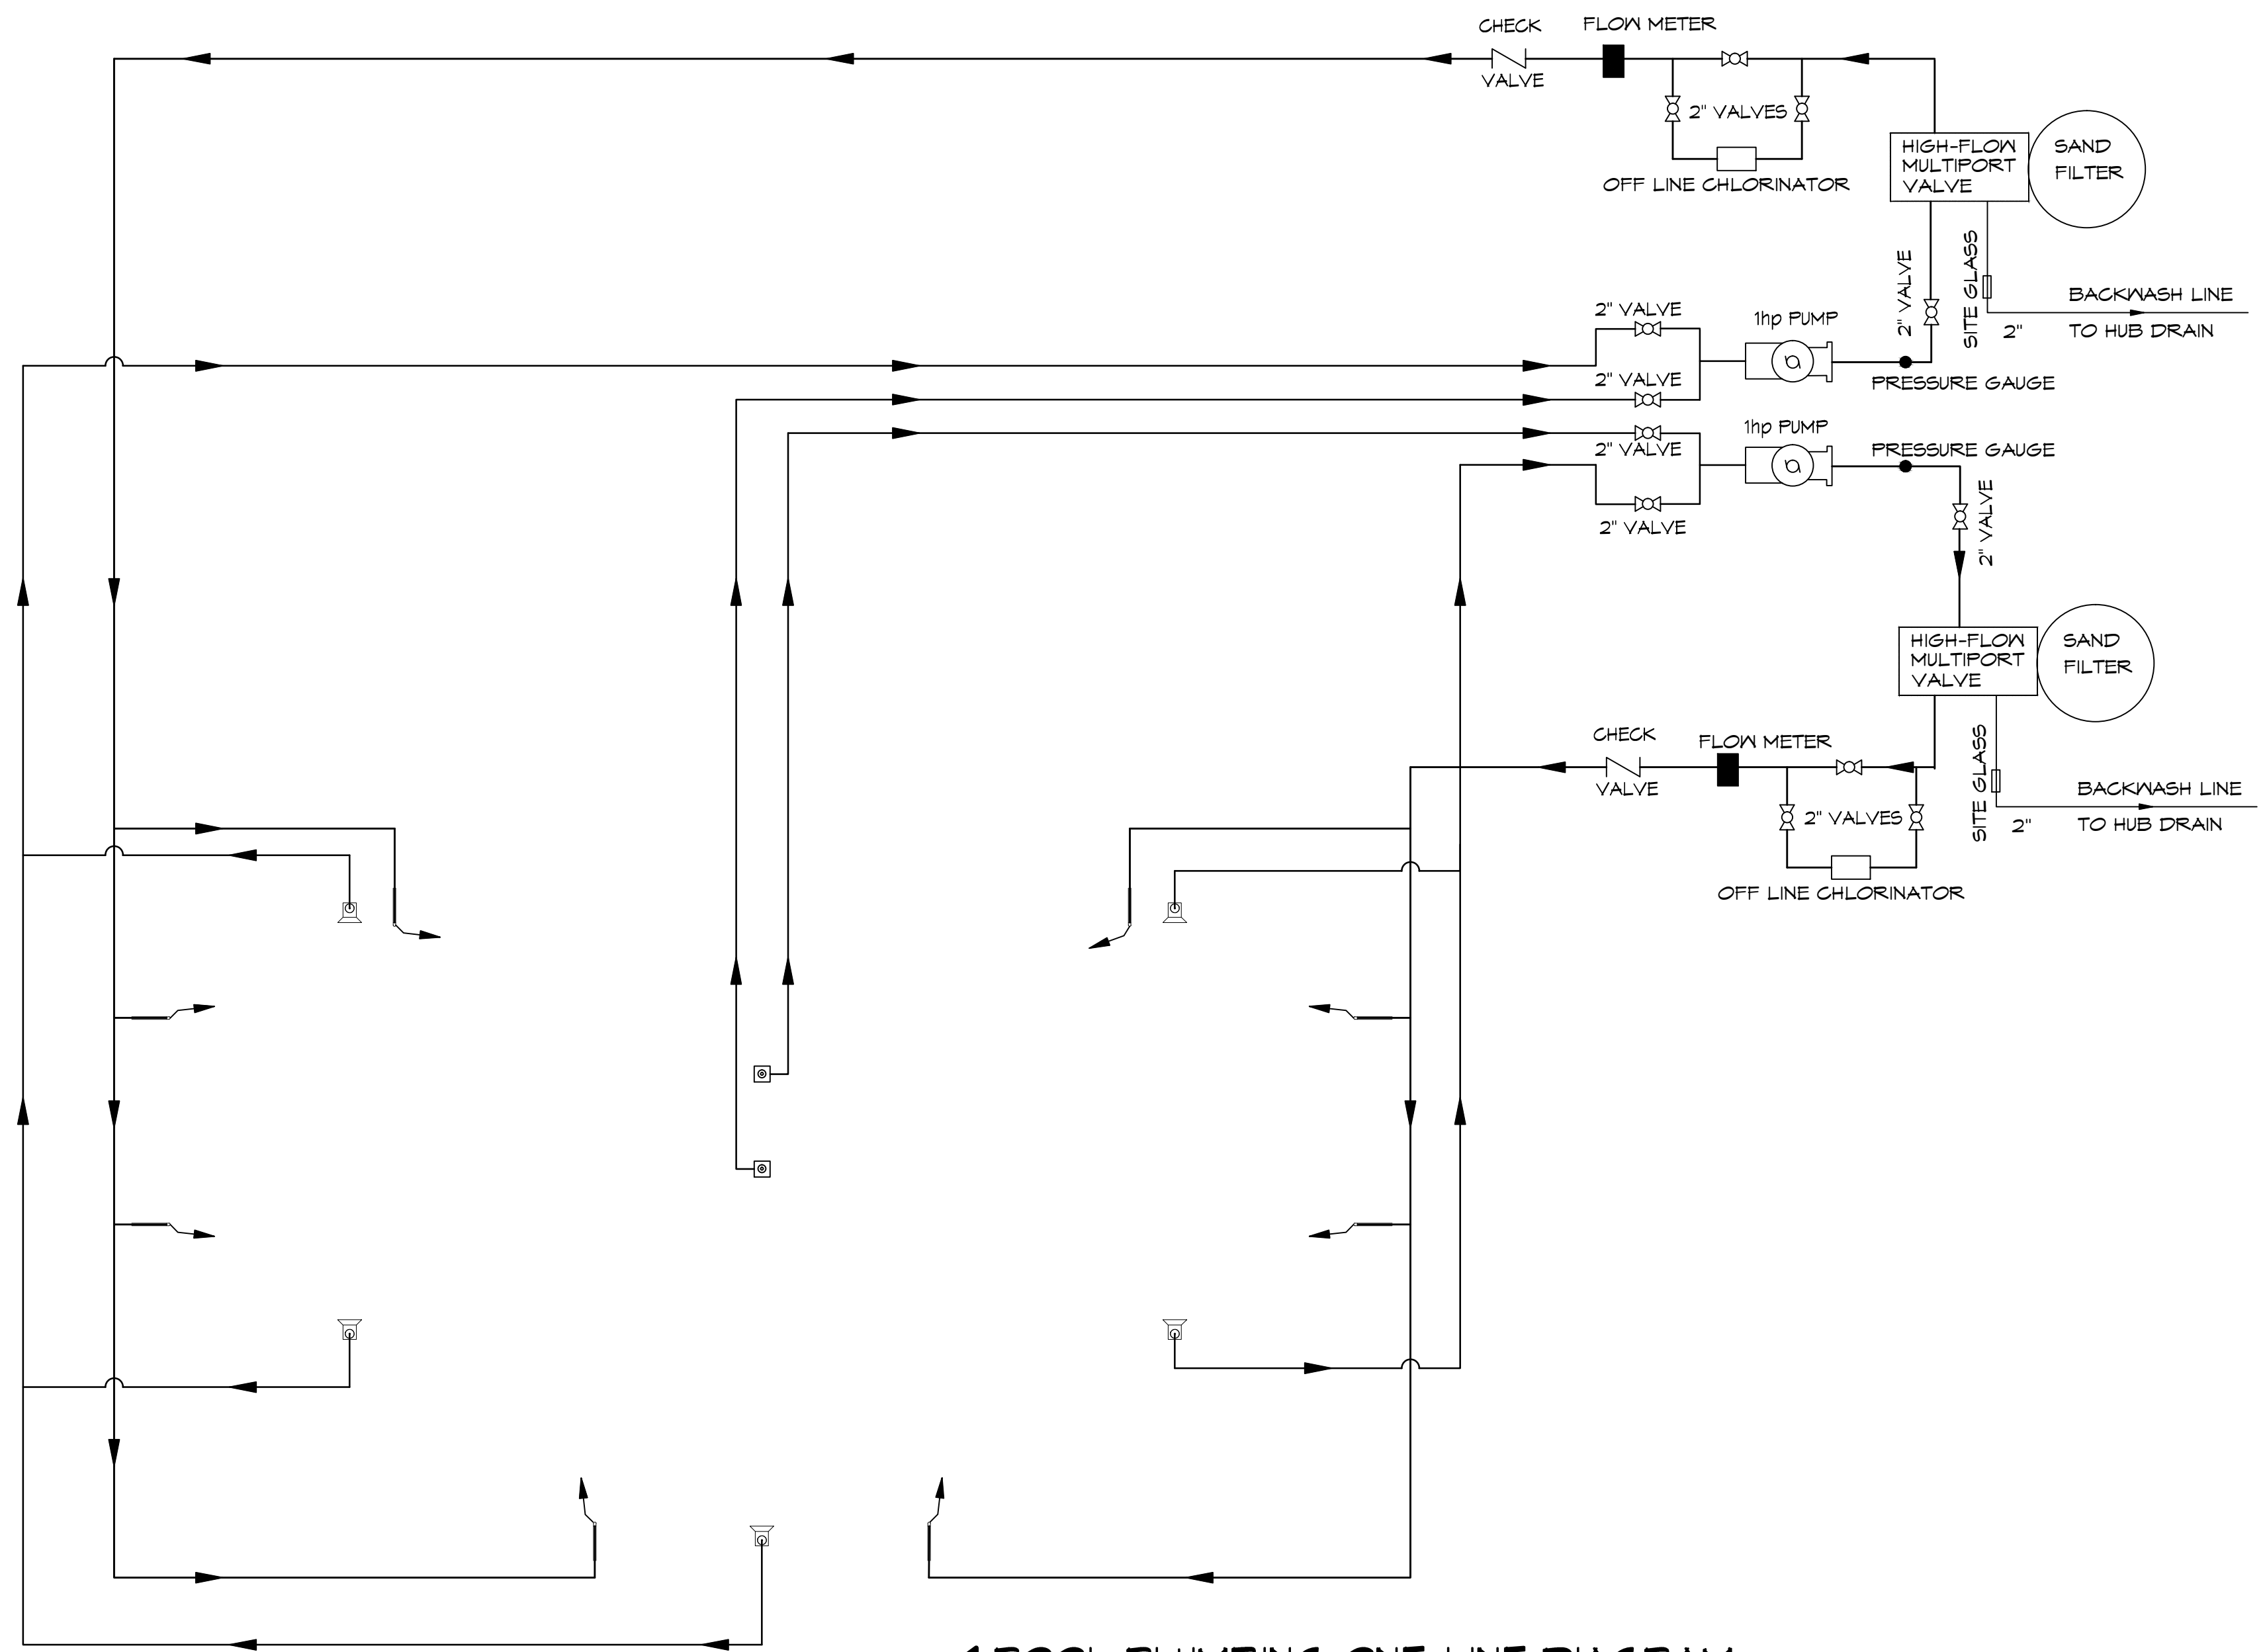

1 POOL PLUMBING ONE-LINE DIAGRAM
SCALE: N.T.S.

#	DESCRIPTION	DATE

SEAL:

NEW POOL
TERRABELLA POOL
 [PROJECT ADDRESS] [DATE] [DATE] [DATE]
 JOB No: 2939 DATE: 10/20/10
 DRAWN BY: DPE CHECKED BY: BK

SHEET TITLE:
ONE-LINE DIAGRAMS

DRAWING NUMBER:

PL-3.2