



# POOL EQUIPMENT LEGEND

QTY	DESCRIPTION
1	JANDY CL 340 CARTRIDGE FILTER WITH PRESSURE GAUGE
1	PENTAIR SUPERFLO 3/4 HP PUMP
1	F-30200P BLUE-WHITE 2.0" PVC PIPE IMPACT FLOW METER WITH OPTIONAL FLOW SENSOR F300S
1	PENTAIR RAINBOW CHLORINATOR MODEL #300
1	LEVELOR - WATER LEVEL CONTROLLER MODEL K-1100
2	TRUE-UNION BALL VALVES FOR PIPE SIZE 3" AND SMALLER
	SCH 80 PVC PIPE FOR ALL SUCTION, RETURN, AND EQUIPMENT ROOM PIPING
1	HAYWARD SP1084; AUTOMATIC SURFACE SKIMMER
3	WATERWAY 640-3600V; SUCTION ASSEMBLY WITH SPC-3V VGB COMPLIANT COVER
2	AQUA STAR 1020TST01 RETURN INLETS USING ANGLE WALL ADAPTER
2	AQUA STAR 1020TST01 RETURN INLET WITHOUT EYEBALL FOR WATER LEVEL CONTROLLER
2	1.90" O.D. HANDRAIL DMS-102B DECK MOUNTED
1	TAYLOR TEST KIT K-2006 (DPD METHOD OF TESTING FOR CHLORINE RESIDUALS)
	6X6 DEPTH MARKERS, 4" BLACK LETTERING ON WHITE BACKGROUND (SLIP RESISTANT FINISH)
	6X6 INTERNATIONAL "NO DIVING" SYMBOL
	LIFE SAVING EQUIPMENT
1	12FT. LONG STRONG POLE WITH SHEPARD'S HOOK (LIFESAVING HOOK)
1	60 FT. THROWING ROPE AND RING BUOY
1	TELEPHONE WITH POSTED EMERGENCY NAMES AND NUMBERS.

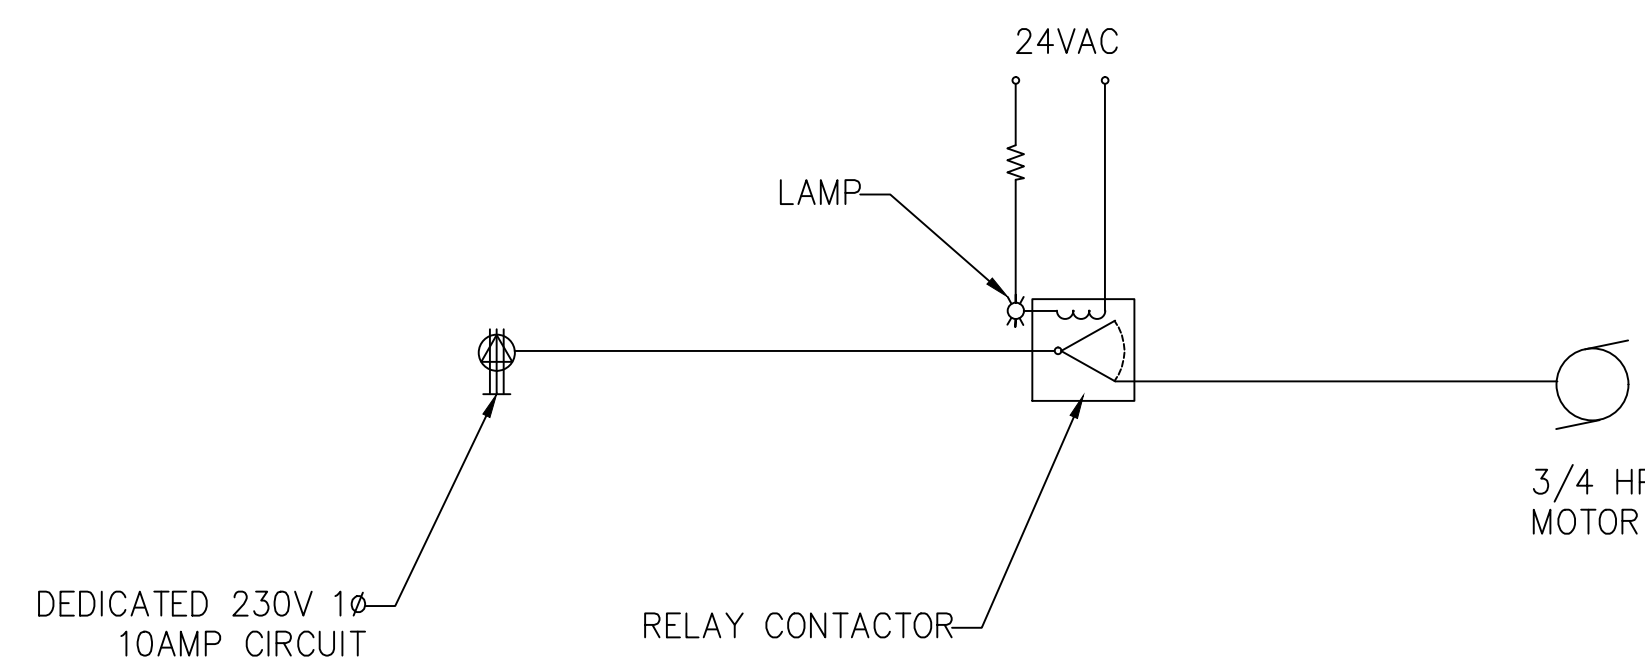

2 ELECTRICAL ONE-LINE DIAGRAM  
SCALE: N.T.S.

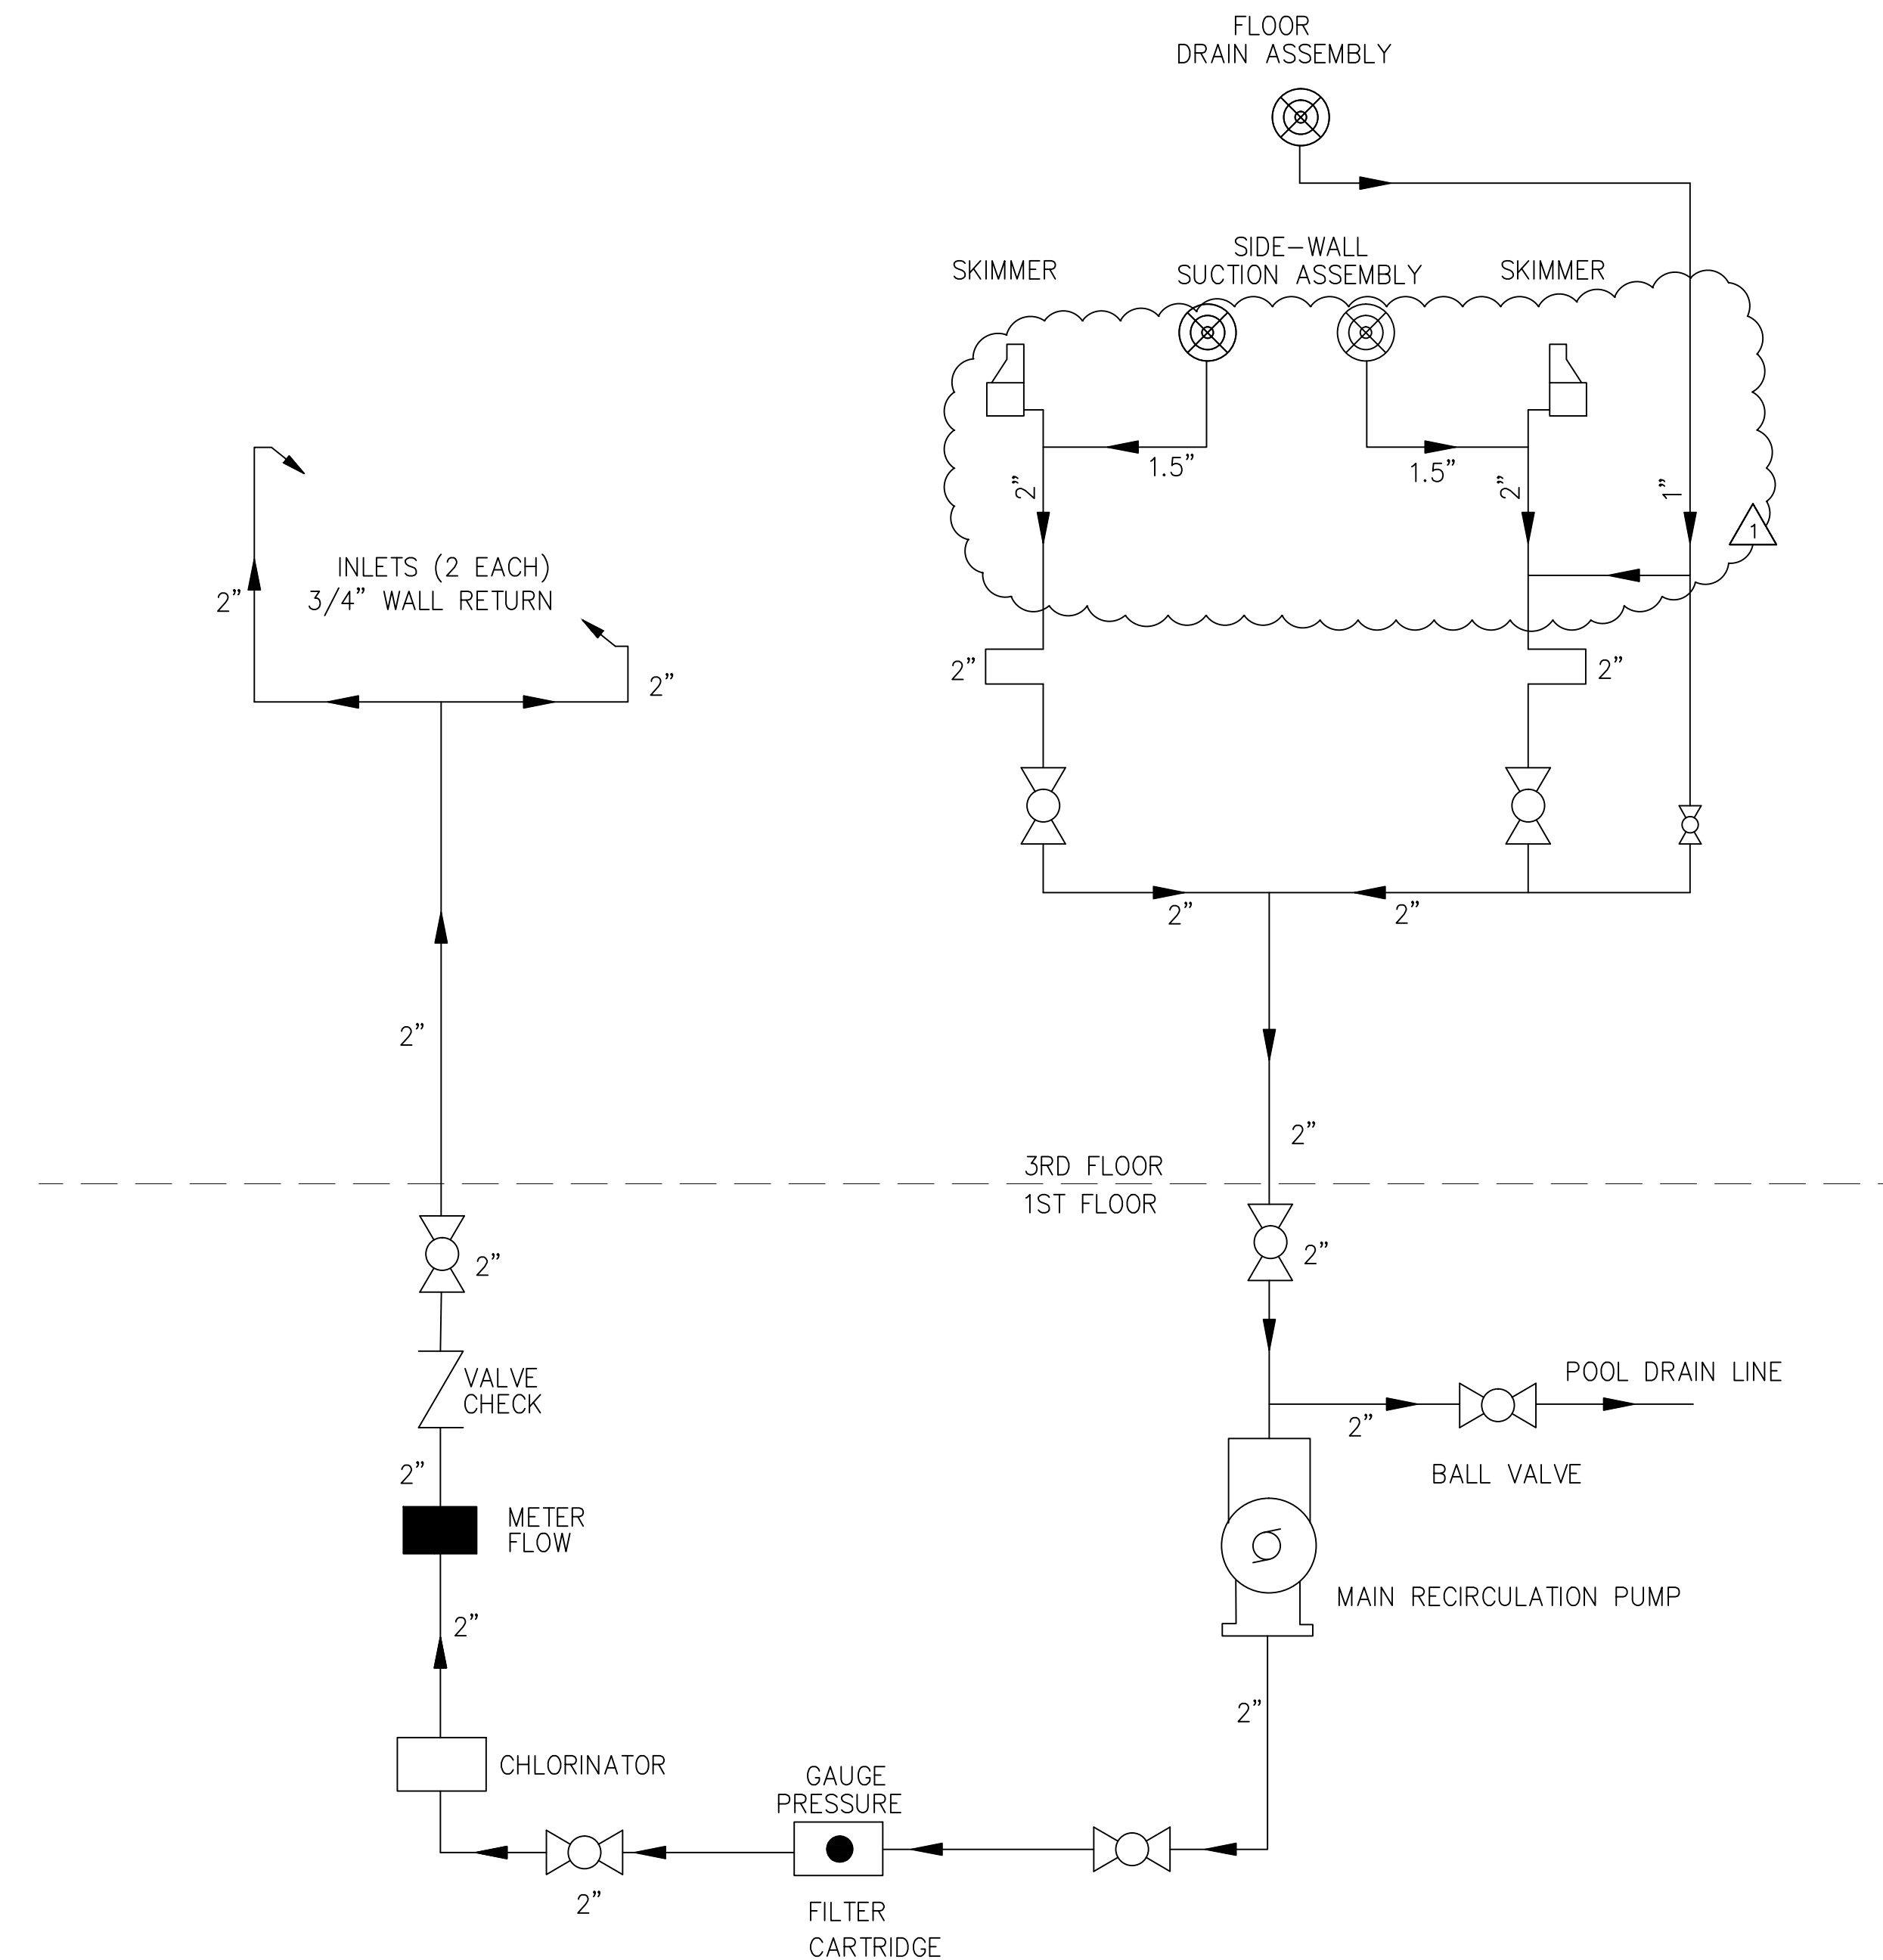

1 POOL PLUMBING ONE-LINE DIAGRAM  
SCALE: N.T.S.

#	DESCRIPTION	DATE



NEW POOL  
WAXMOSUM  
CONDOSUM

917 Conti Street  
New Orleans, Louisiana

JOB No: 2308 DATE: February 20, 2017  
DRAWN BY: DPD CHECKED BY: BM

SHEET TITLE:  
PLUMBING ONE-LINE  
DIAGRAMS

DRAWING NUMBER:  
**PL-3.1**