




3 THIRD FLOOR PLAN
SCALE: 3/32" = 1'-0"

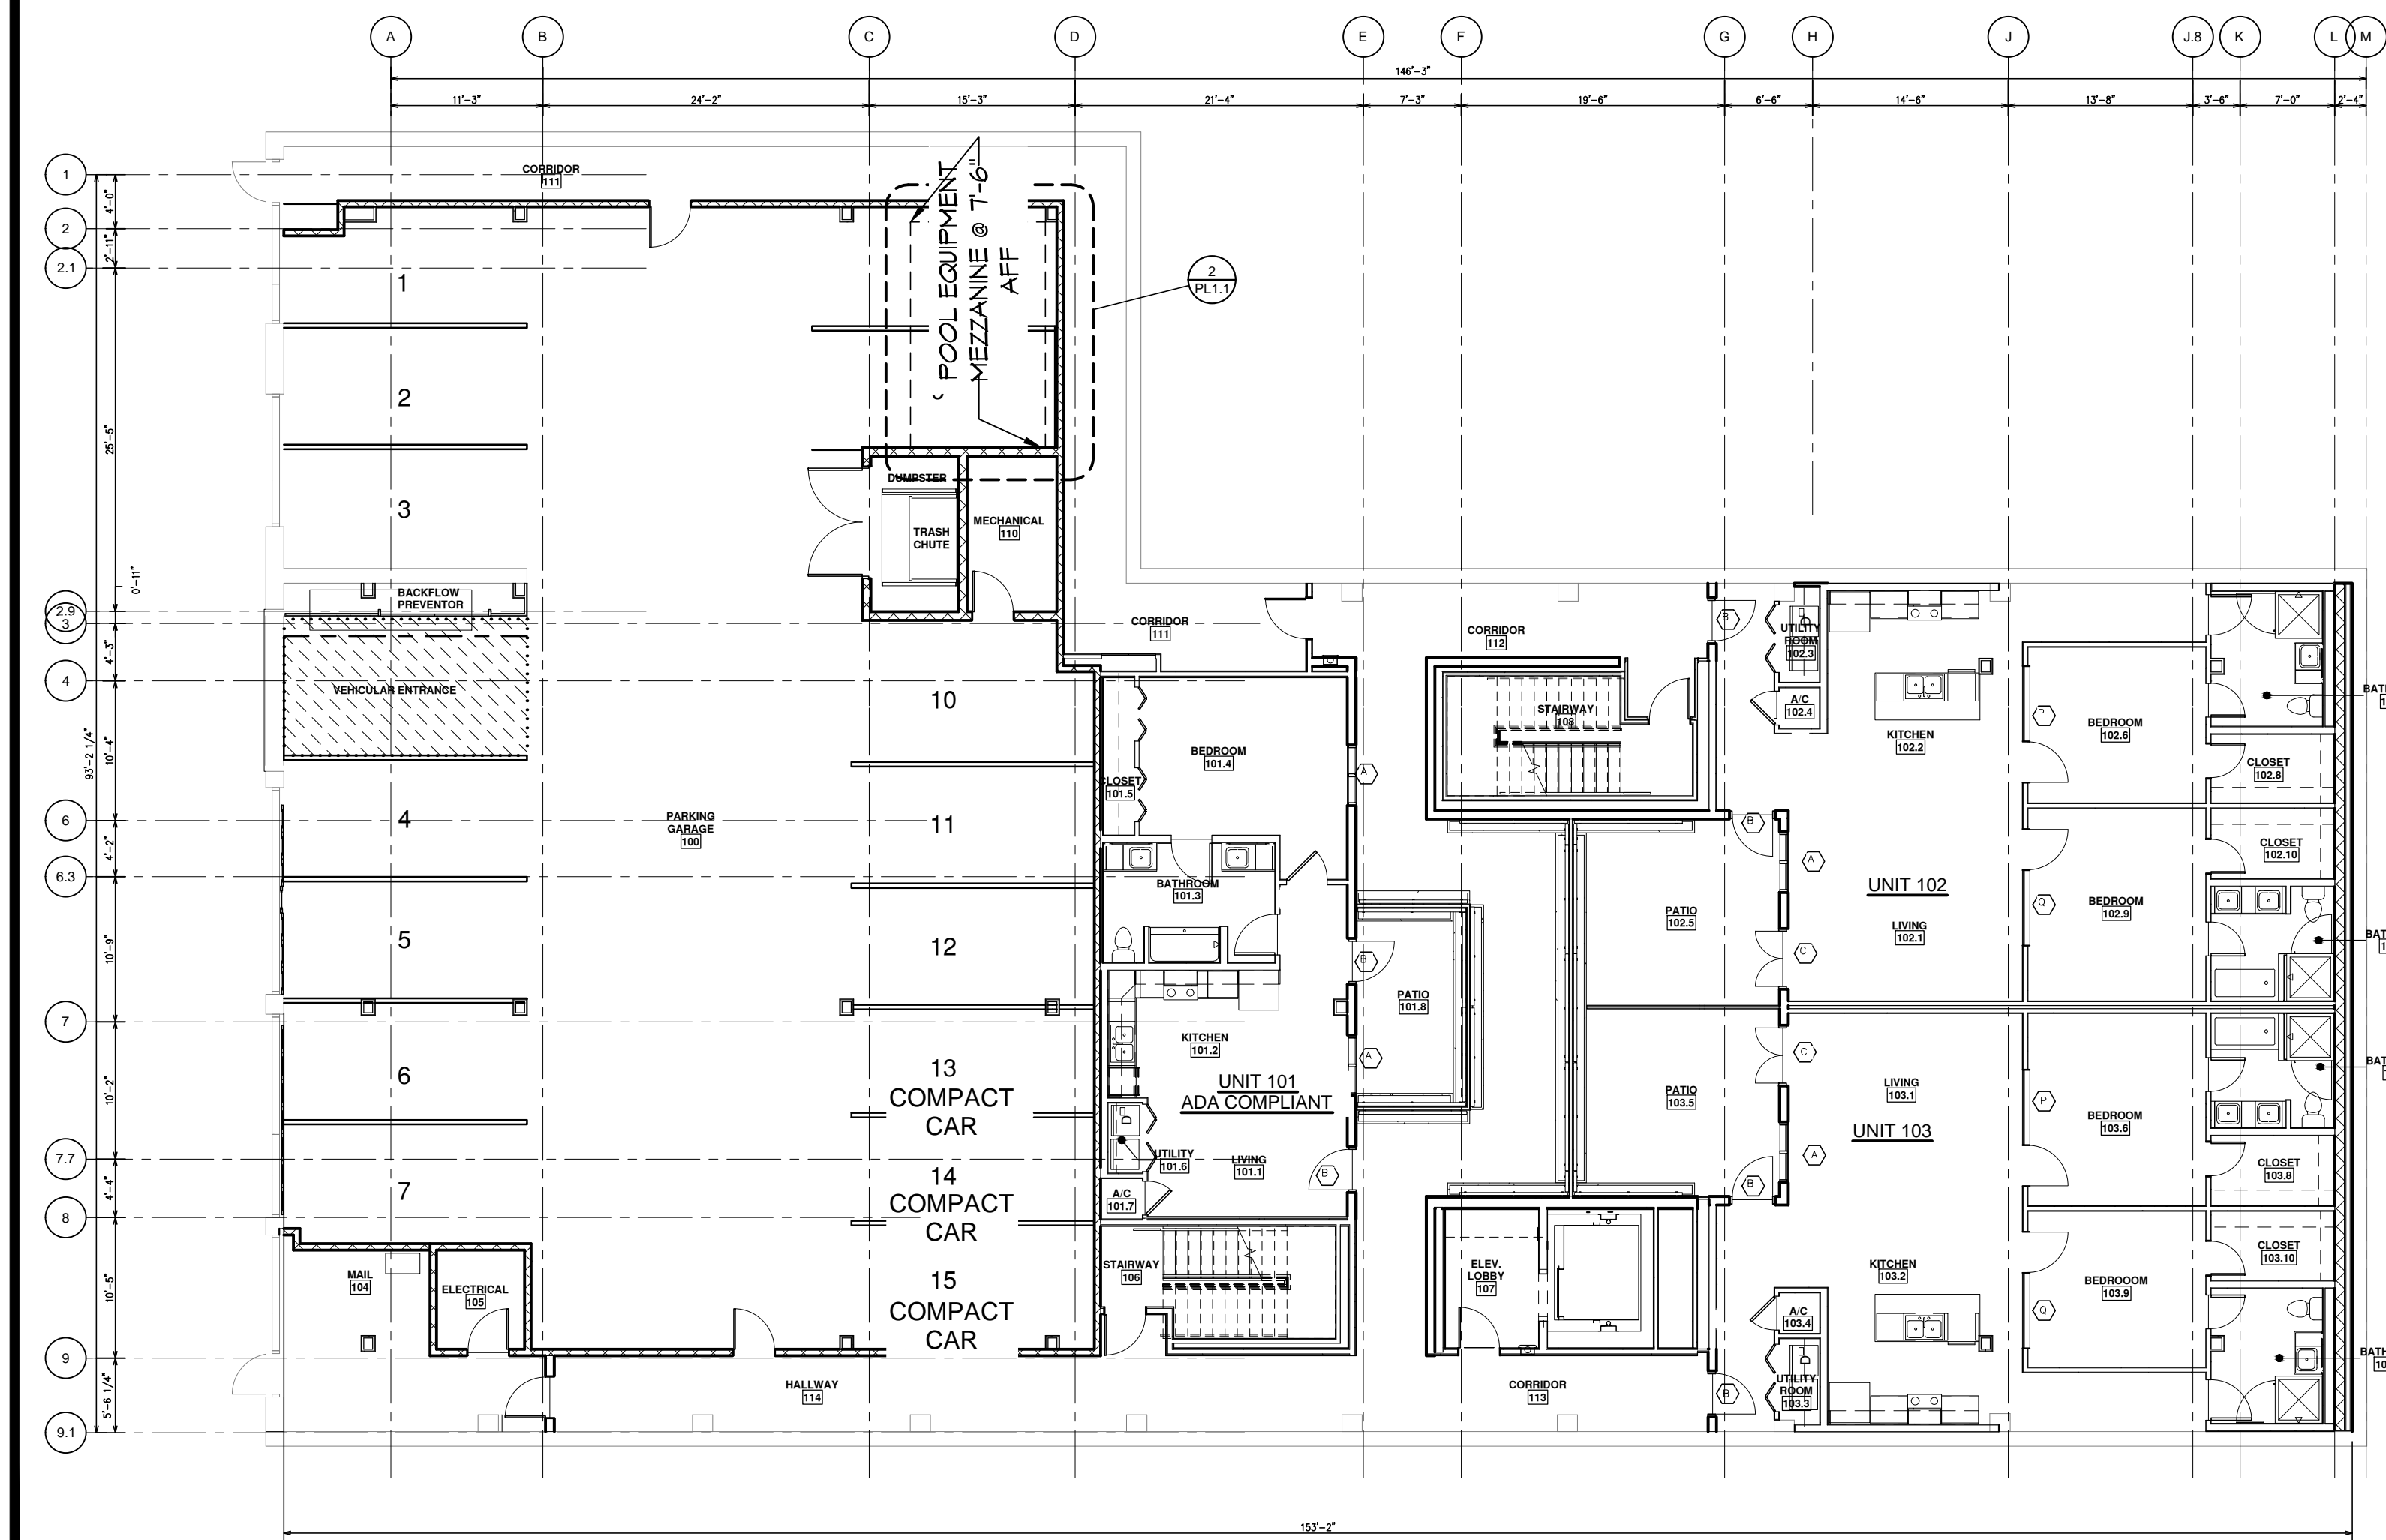

1 1ST FLOOR PLAN
SCALE: 3/32" = 1'-0"

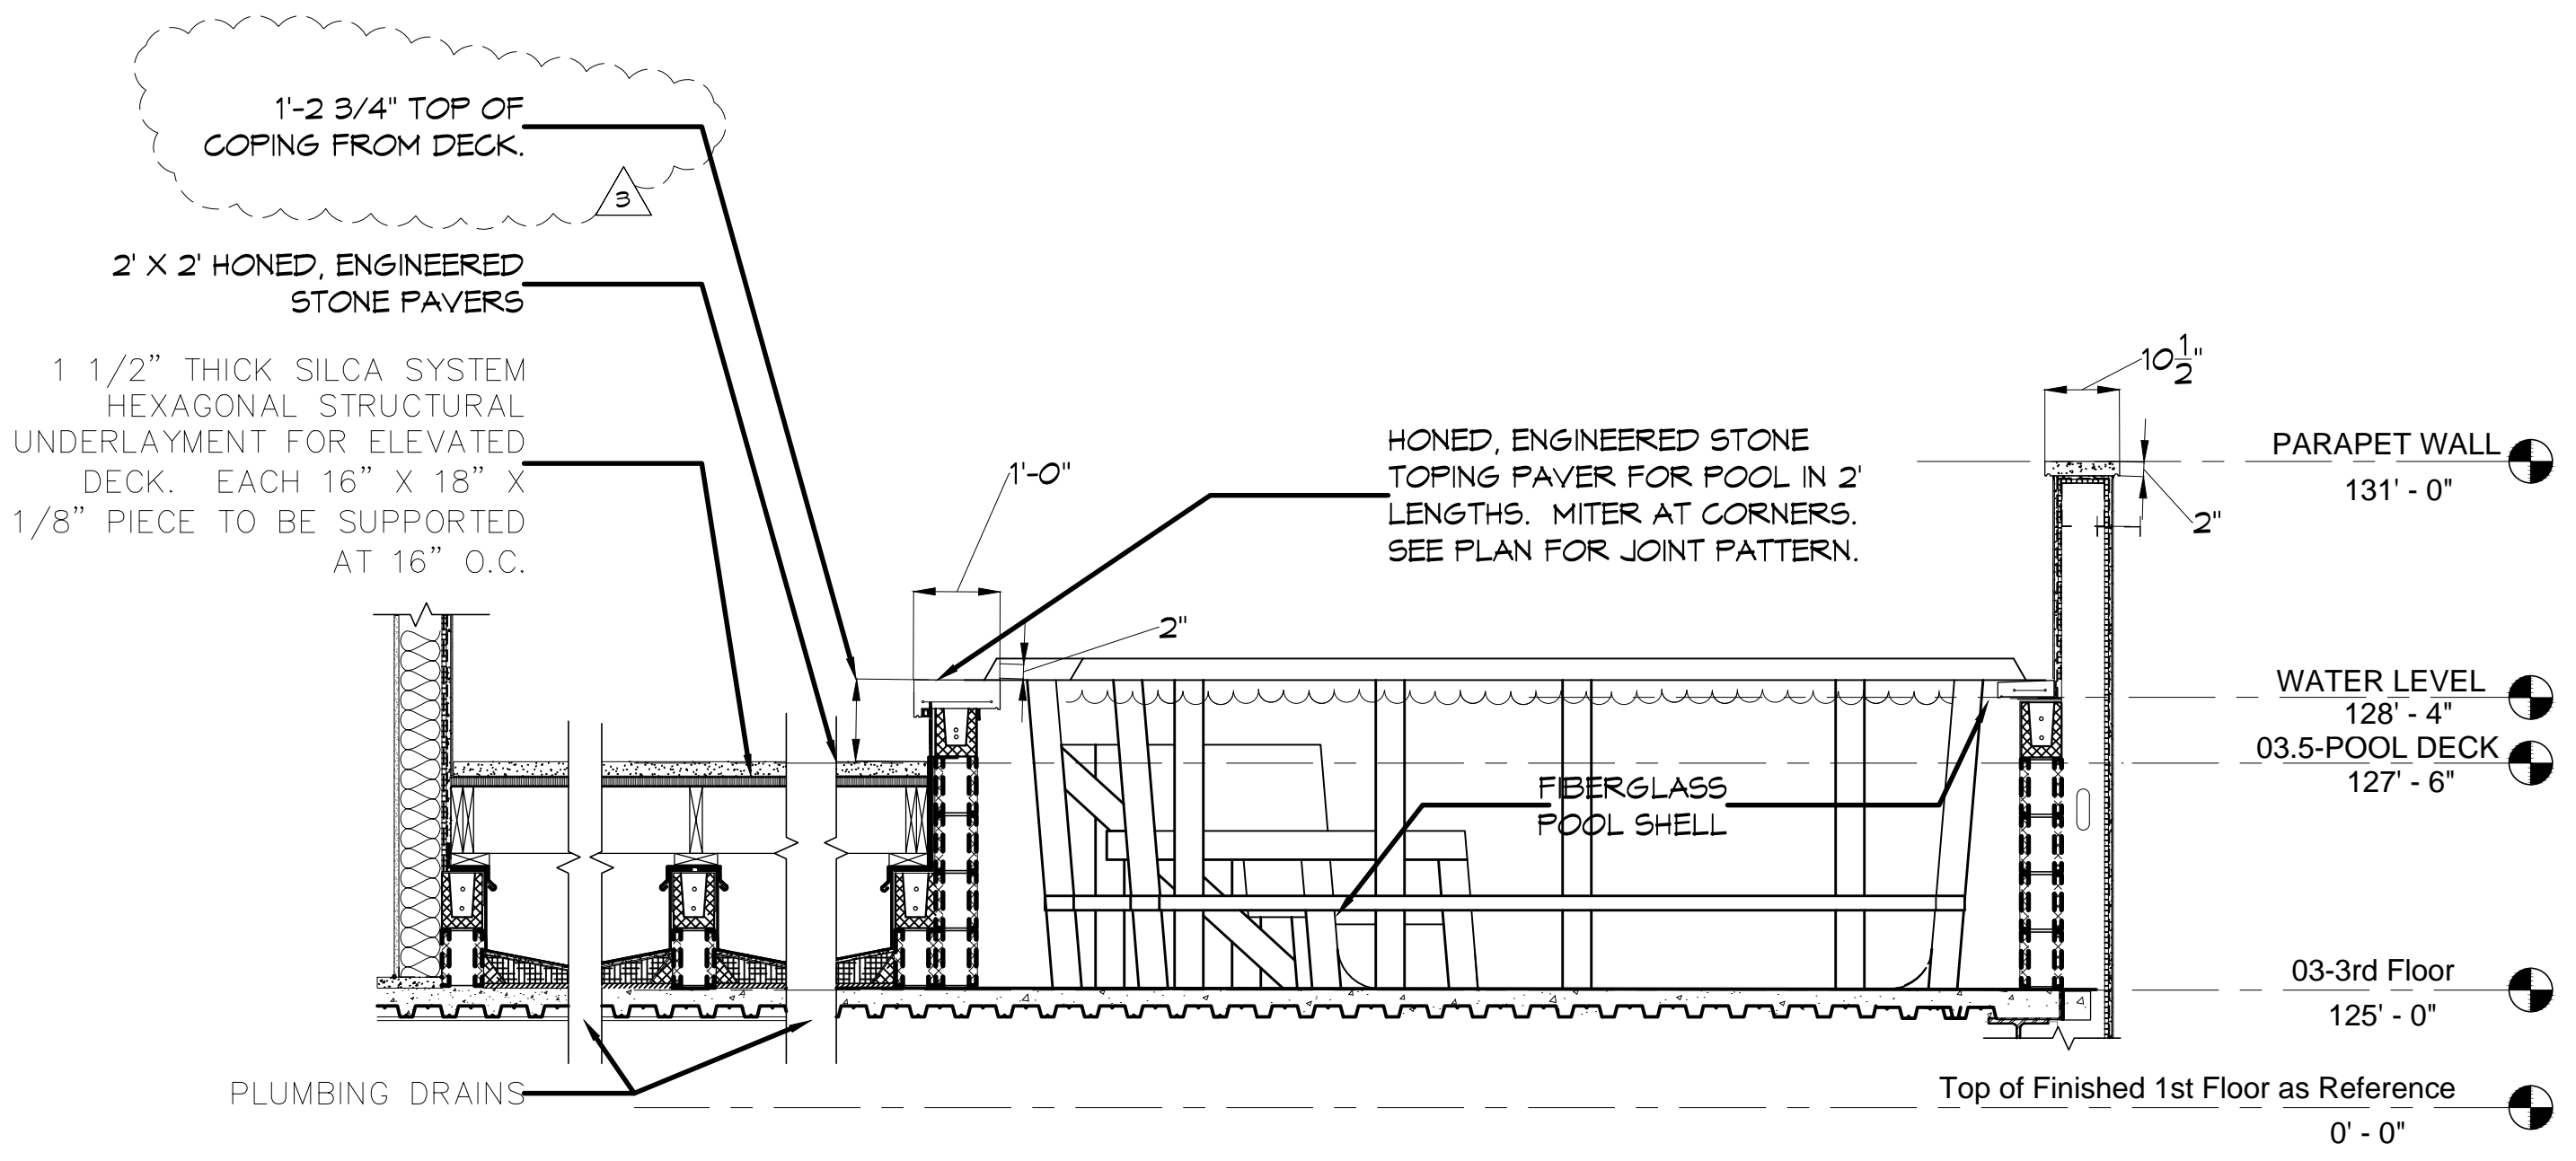

4 DECKING DETAIL
SCALE: 1/2" = 1'-0"

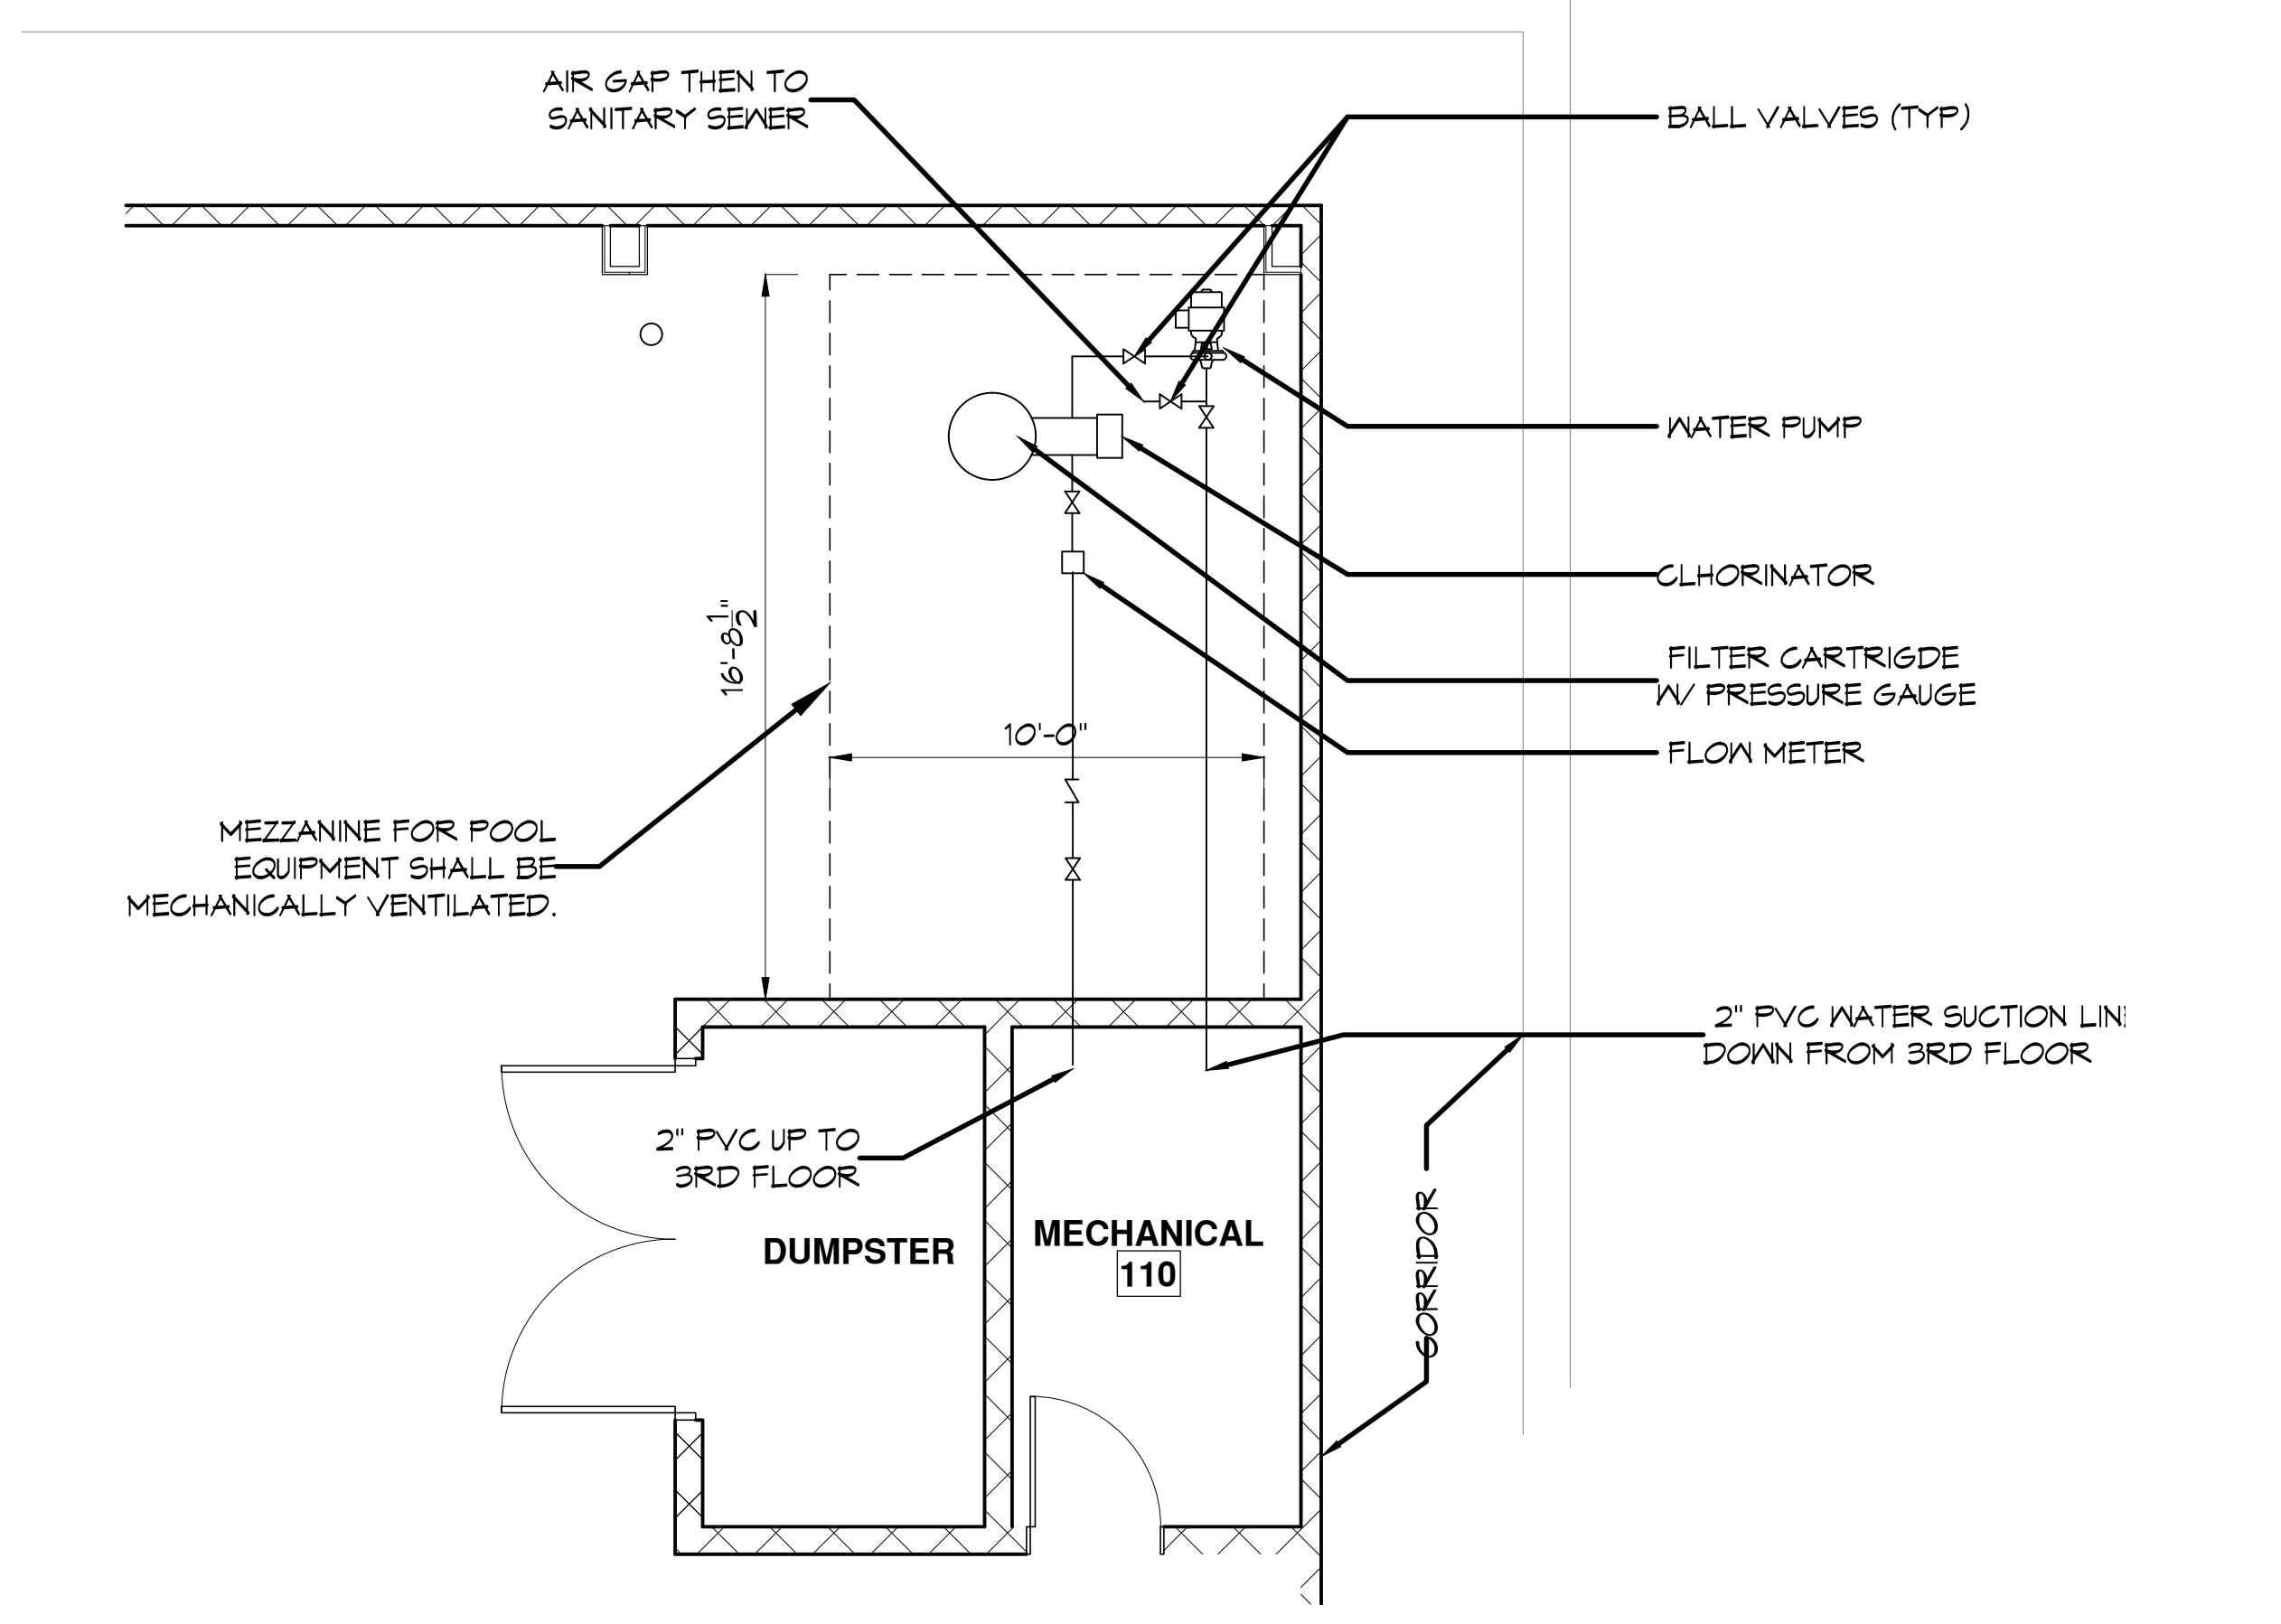

2 POOL EQUIP RM
SCALE: 1/4" = 1'-0"

#	DESCRIPTION	DATE
1	Revised Notes	4/13/2017
2	IN POOL LIGHT FIXTURE ADDED	5/11/2017



NEW POOL MUSEUM KANAMOS
917 Conti Street
New Orleans, Louisiana
JOB No: 2909 DATE: February 20, 2017
DRAWN BY: DPE CHECKED BY: CMC

SHEET TITLE:
1ST & 3RD FLOOR - FLOOR PLANS
DRAWING NUMBER:
PL-1.1
SHEET No: 2 of 5