



2 3rd FLOOR POOL PIPING AT WALL
SCALE: 1/2" = 1'-0"

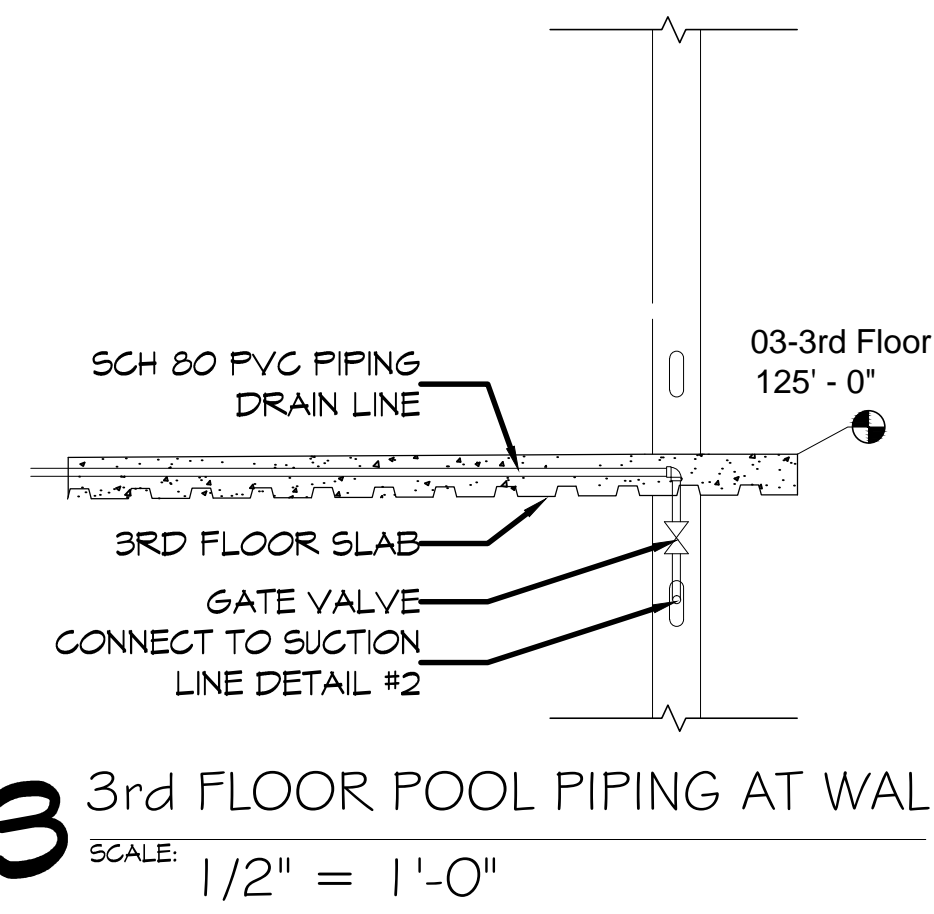

3 3rd FLOOR POOL PIPING AT WALL
SCALE: 1/2" = 1'-0"

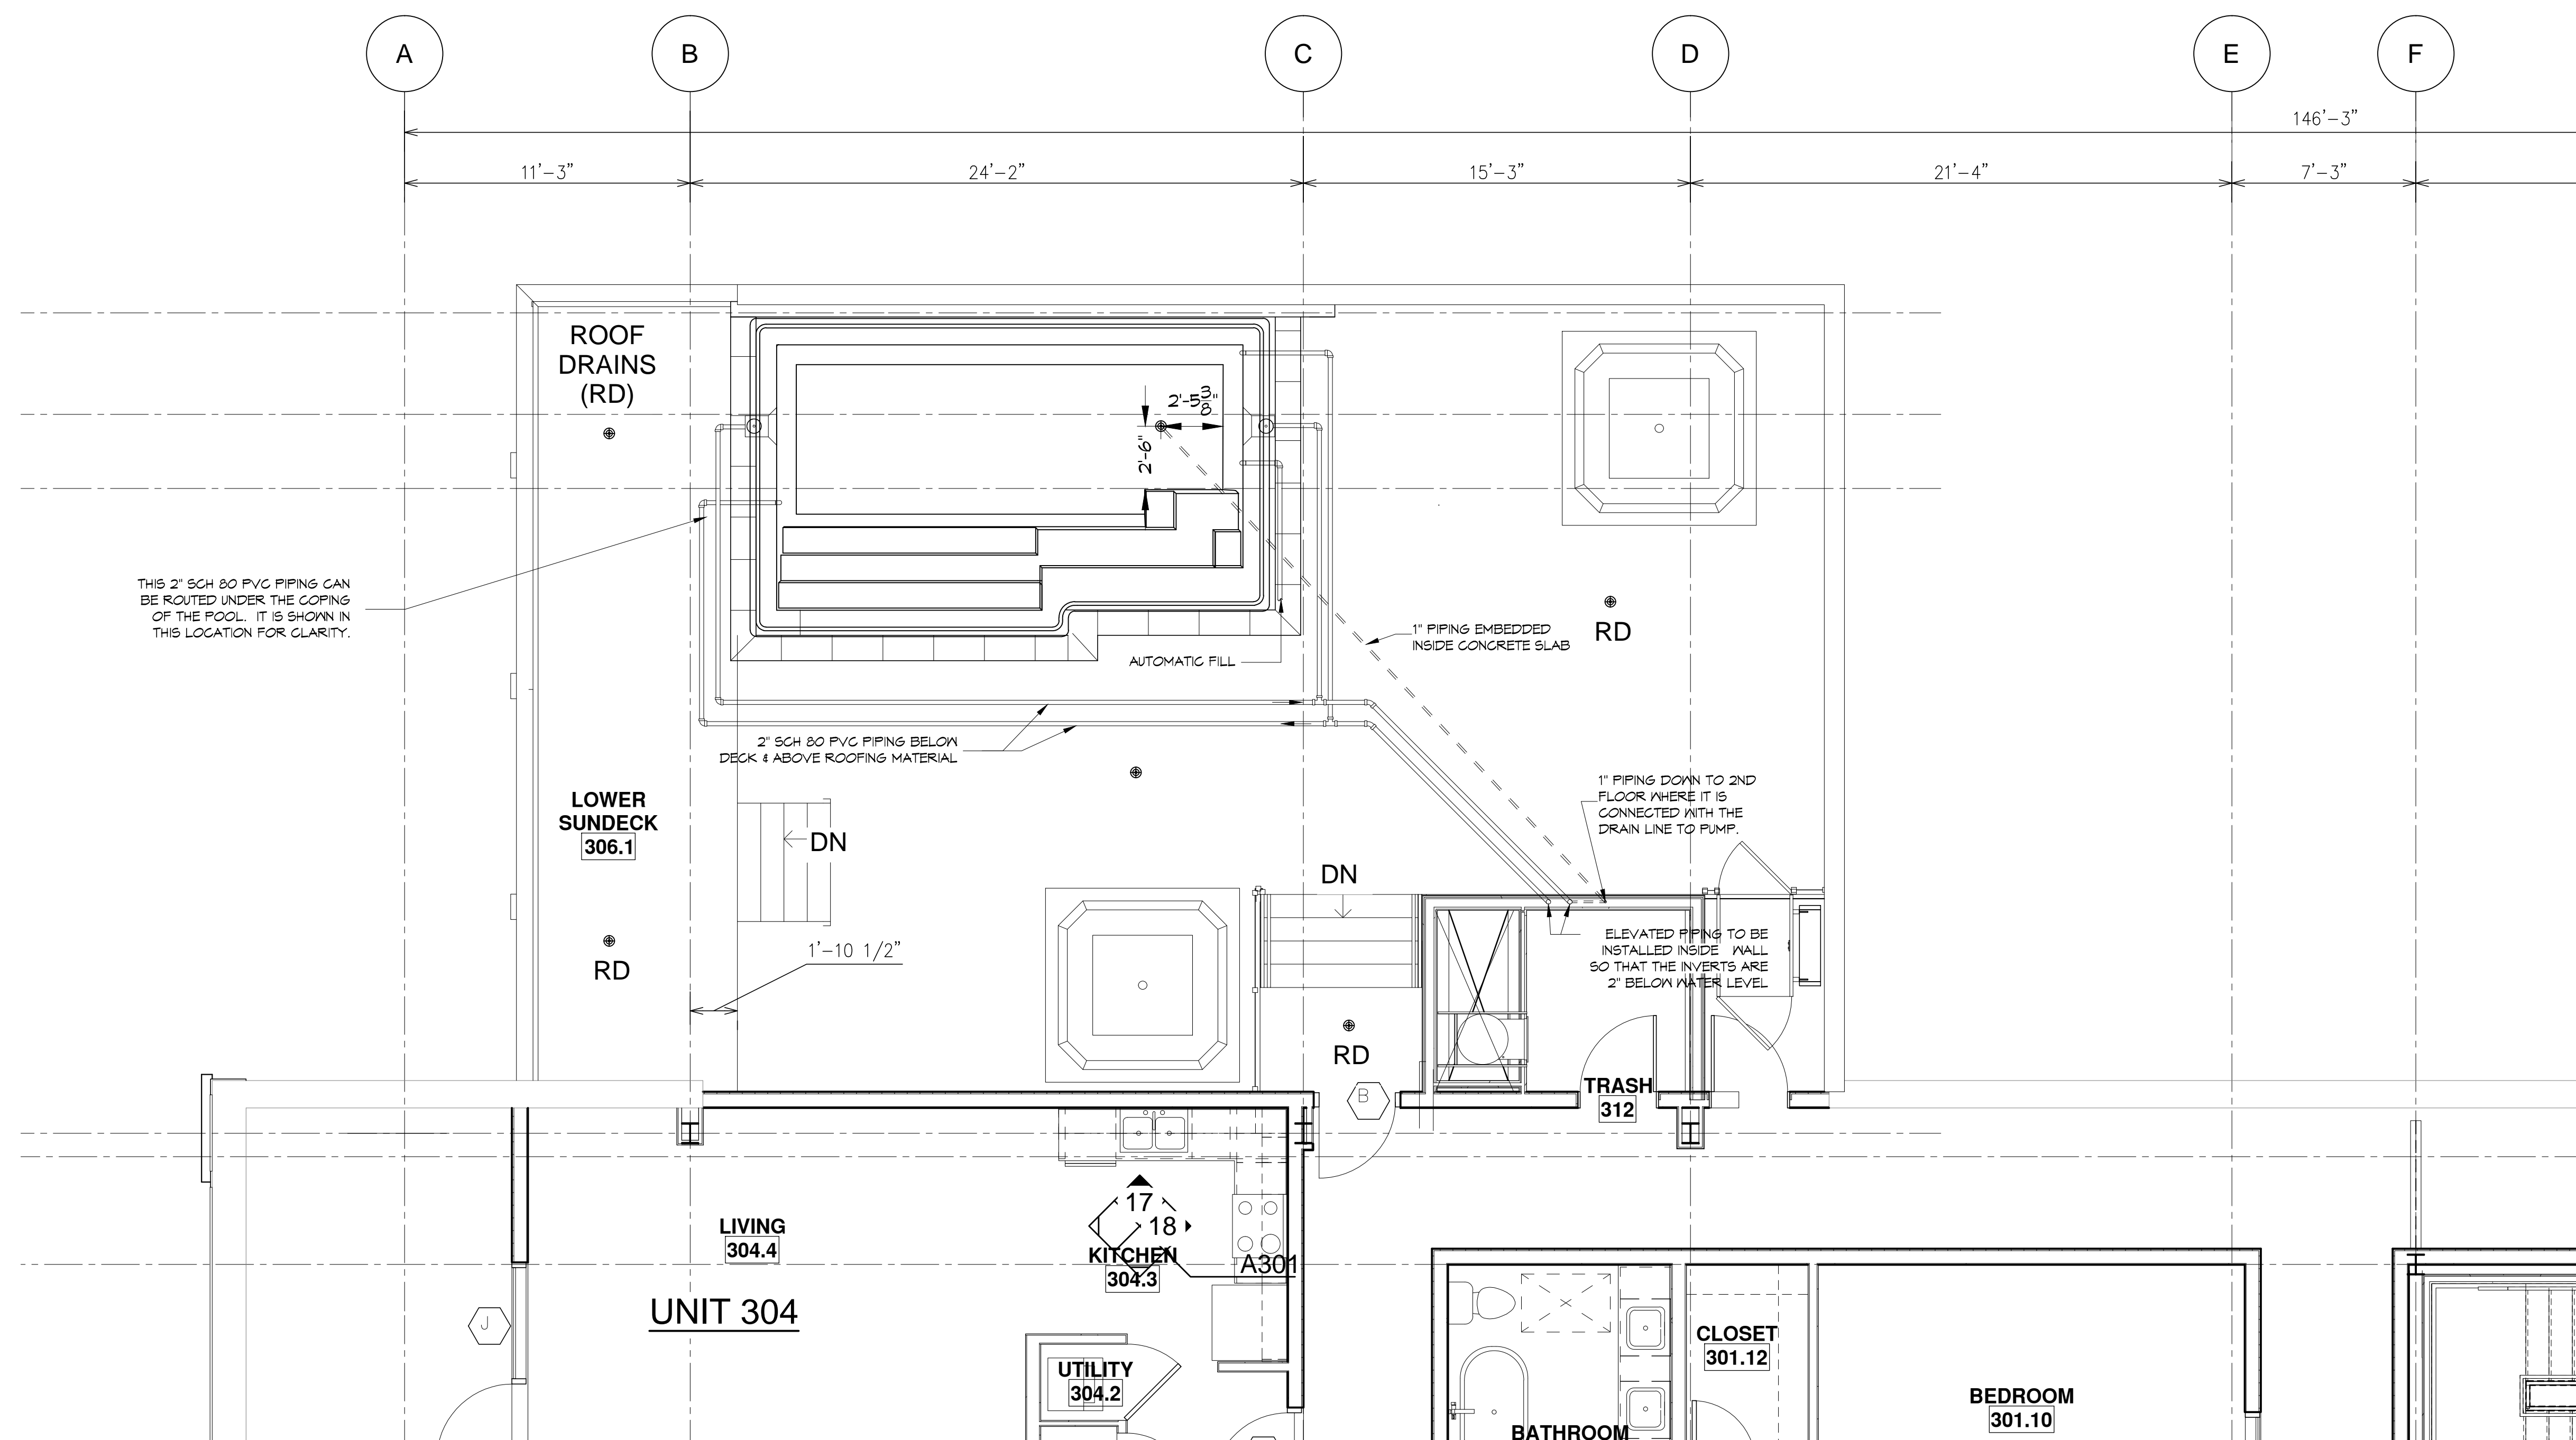

1 3rd FLOOR POOL PIPING PLAN
SCALE: 1/4" = 1'-0"

#	DESCRIPTION	DATE



NEW POOL
MUSEUM
AND
SUITES

917 Conti Street
New Orleans, Louisiana
JOB No: 2009
DATE: February 20, 2011
DRAWN BY: DFP
CHECKED BY: CKD

SHEET TITLE:
3RD FLOOR - POOL
PIPING PLAN

DRAWING NUMBER:

PL-1.2