


WATER FEATURE EQUIPMENT LEGEND

QTY	DESCRIPTION
1	JANDY CL 340 CARTRIDGE FILTER WITH PRESSURE GAUGE
1	PENTAIR SUPERFLO 3/4 HP PUMP
1	F-30200P BLUE-WHITE 2.0" PVC PIPE IMPACT FLOW METER WITH OPTIONAL FLOW SENSOR F300S
1	PENTAIR RAINBOW CHLORINATOR MODEL #300
1	LEVELOR - WATER LEVEL CONTROLLER MODEL K-1100
2	TRUE-UNION BALL VALVES FOR PIPE SIZE 3" AND SMALLER
1	6HPHA105 AQUASTAR 6INCH ROUND HOCKEY PUCK FLOOR DRAIN ASSEMBLY
	SCH 80 PVC PIPE FOR ALL SUCTION, RETURN, AND EQUIPMENT ROOM PIPING
1	HAYWARD SP1084; AUTOMATIC SURFACE SKIMMER
2	WATERWAY 640-3600V; SUCTION ASSEMBLY WITH SPC-3V VGB COMPLIANT COVER
2	AQUA STAR 1020TST01 RETURN INLETS USING ANGLE WALL ADAPTER
2	AQUA STAR 1020TST01 RETURN INLET WITHOUT EYEBALL FOR WATER LEVEL CONTROLLER
2	1.90" O.D. HANDRAIL DMS-102B DECK MOUNTED
1	TAYLOR TEST KIT K-2006 (DPD METHOD OF TESTING FOR CHLORINE RESIDUALS)
	6X6 DEPTH MARKERS, 4" BLACK LETTERING ON WHITE BACKGROUND (SLIP RESISTANT FINISH)
	6X6 INTERNATIONAL "NO DIVING" SYMBOL
	LIFE SAVING EQUIPMENT
1	12FT. LONG STRONG POLE WITH SHEPARD'S HOOK (LIFESAVING HOOK)
1	60 FT. THROWING ROPE AND RING BUOY
1	TELEPHONE WITH POSTED EMERGENCY NAMES AND NUMBERS.

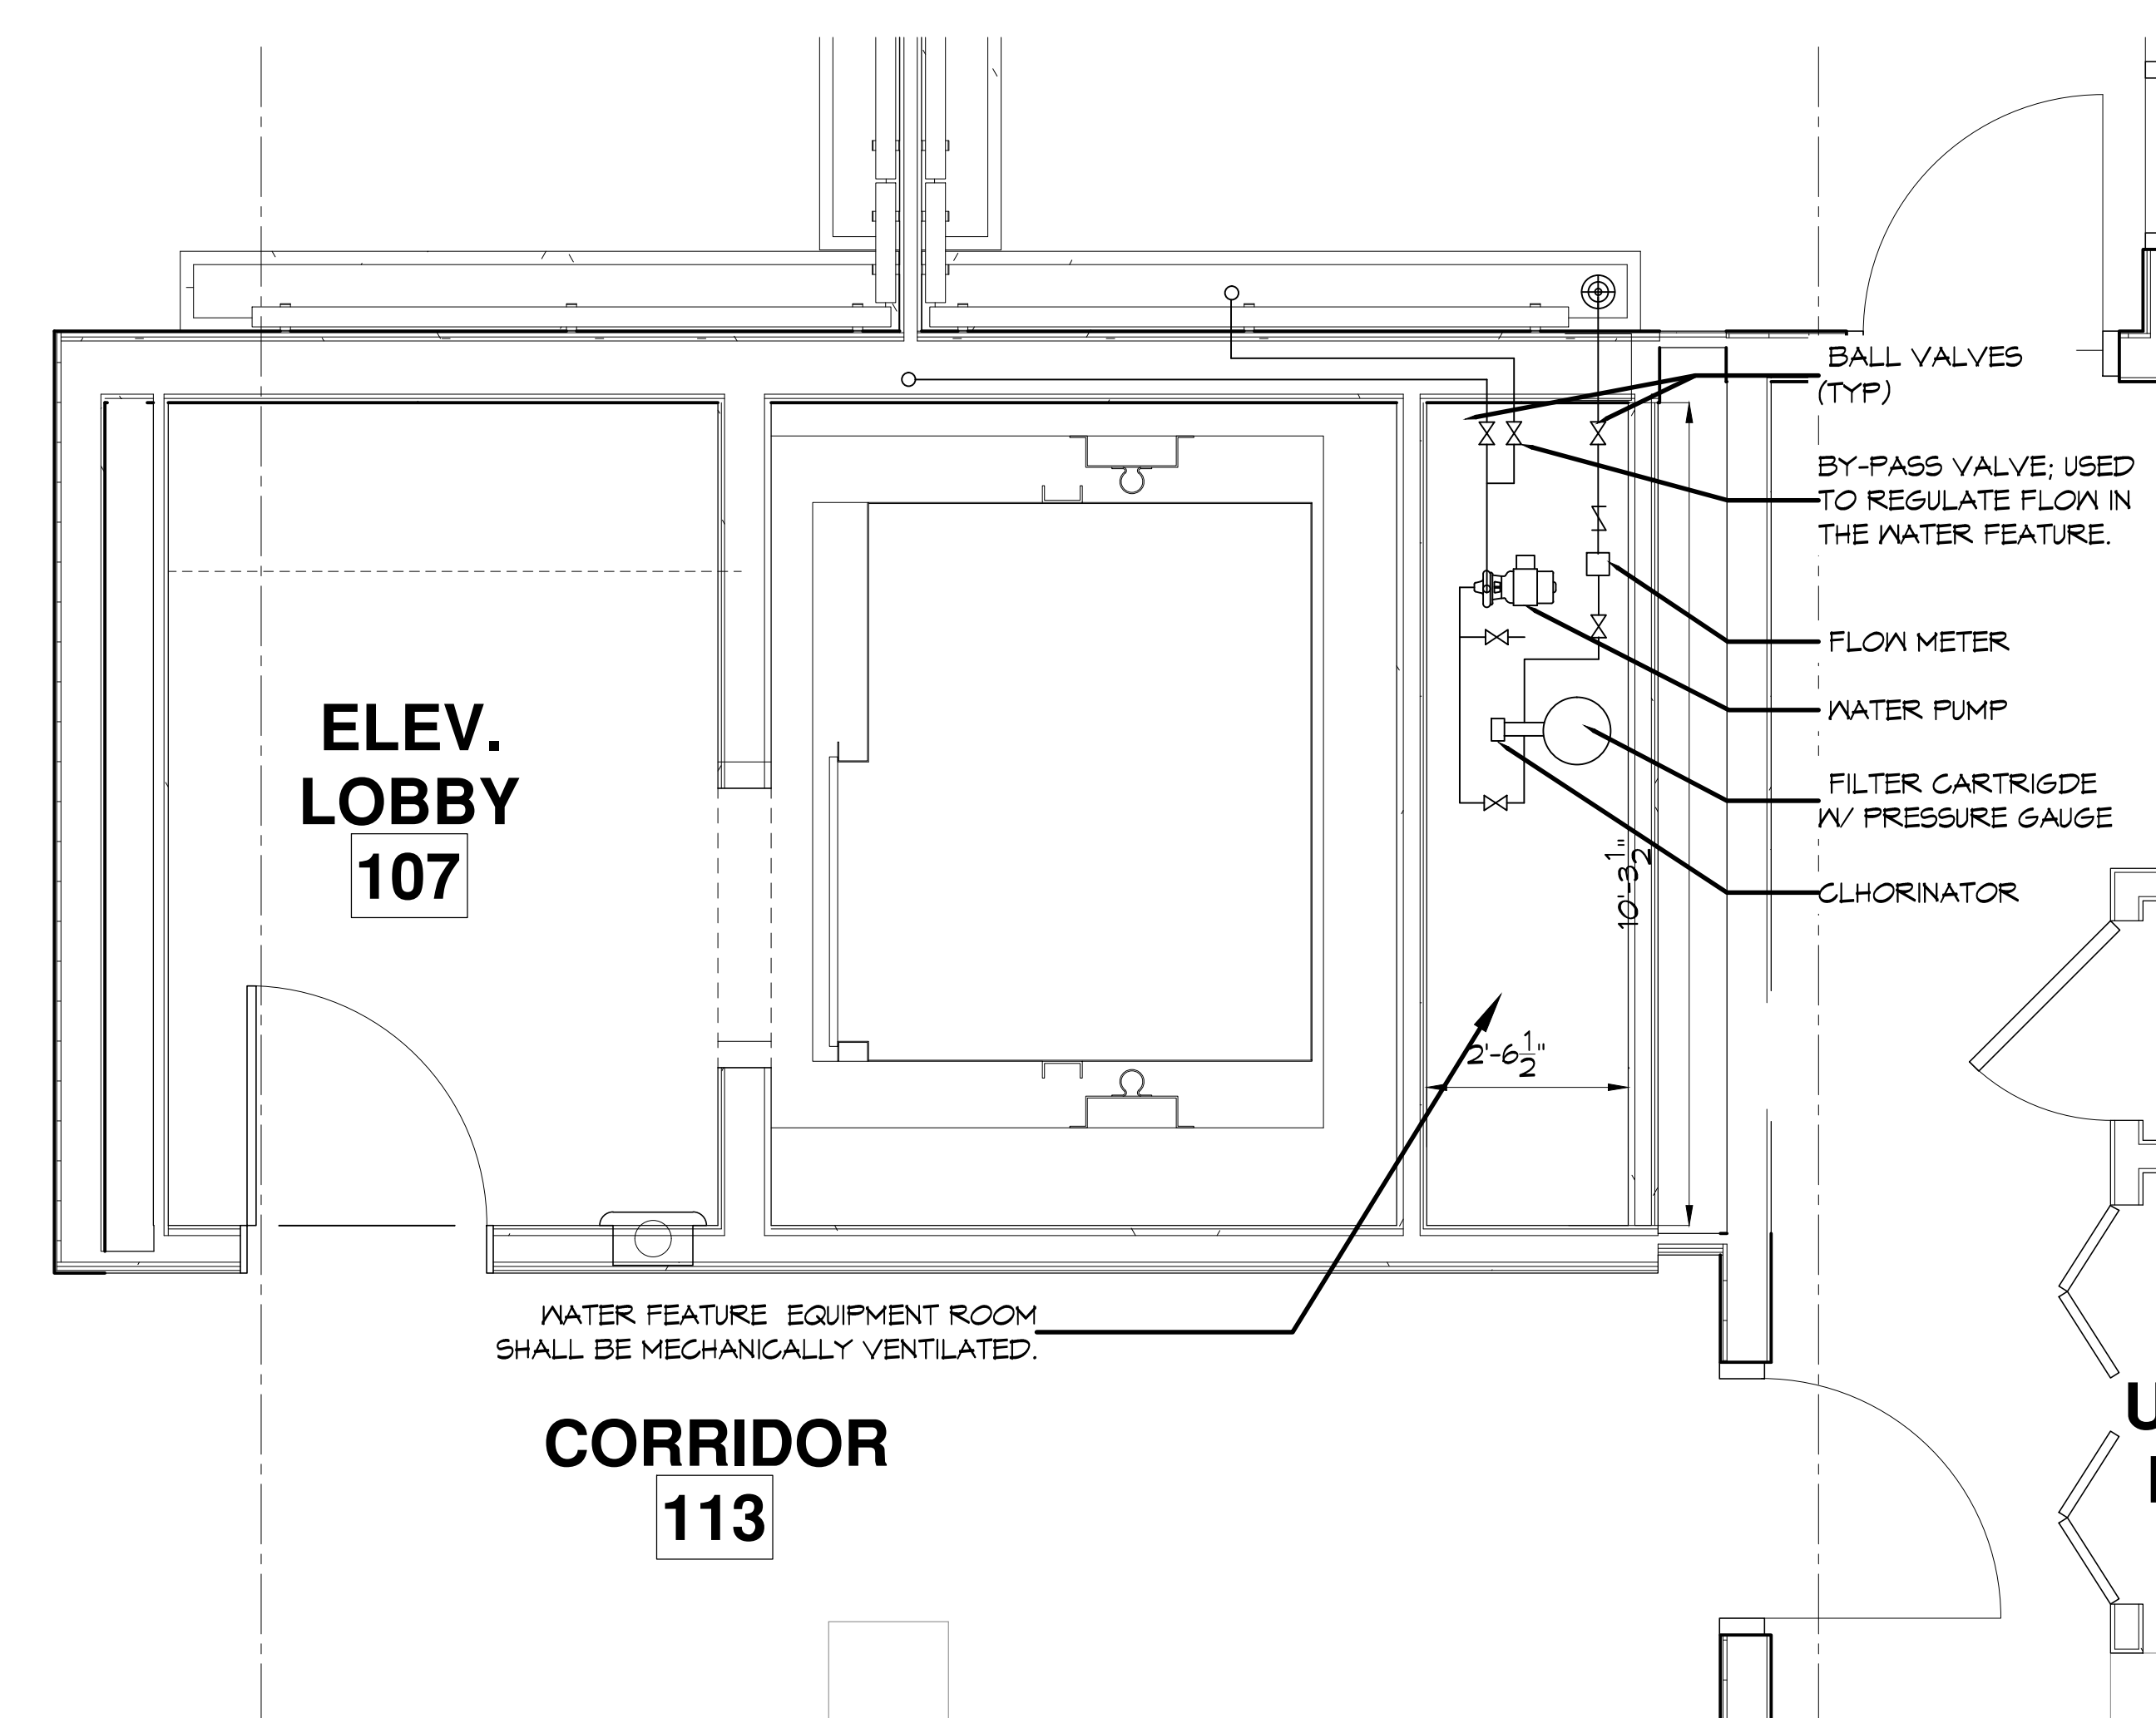

DAMMON ENGINEERING, INC.
 LOUISIANA & MISSISSIPPI
 Chief Engineer: Brian Mierich, PE
 554 Old Spanish Trail
 Slidell, LA 70568
 www.dammonengineering.com
 info@dammonengineering.com
 PH: 985.649.5832

#	DESCRIPTION	DATE
1	Revised Notes	4/13/2017
2	IN POOL LIGHT FIXTURE ADDED	5/11/2017

SEAL:

NEW POOL MUSEUM KANAMOS

917 Conti Street
 New Orleans, Louisiana
 JOB No: 2809 DATE: February 20, 2017
 DRAWN BY: DPE CHECKED BY: CCB

SHEET TITLE:
 1ST & 3RD FLOOR - FLOOR PLANS

DRAWING NUMBER:
PL-1.1

SHEET No: 2 of 5

1 1ST FLOOR PLAN
 SCALE: 3/32" = 1'-0"

2 POOL EQUIP ROOM SCALE: 1/4" = 1'-0"
2 WATER FALL & EQUIPMENT ROOM SCALE: 1/2" = 1'-0"