


**5 ADDITION FLOOR PLAN**

SCALE: 1/2" = 1'-0"


ARCHITURAL

DOOR SCHEDULE							REMARKS
NO.	WIDTH	HEIGHT	THK	DOOR MAT	FRAME MAT	RATED	
100	2'-0"	6'-8"	1-3/4"	MASONITE	WOOD	NR	
101	3'-0"	6'-8"	1-3/4"	MASONITE	WOOD	↓	
102	16'-0"	7'-0"	1-3/4"	METAL	WOOD	130MPH	

LIGHTING LEGEND		POWER LEGEND	
○	RECESSED LIGHT - FLUORESCENT OR LED	□	ELECTRIC PANEL BOARD
⏏	FLUORESCENT OR LED	⚡	LIGHT SWITCH 120V
		⦿	EXHAUST FAN/LIGHT COMBO
		⊕	STANDARD 120V DUPLEX RECEPTACLE, 18" AFF (UNLESS OTHERWISE NOTED)
		⊕	GFCI DUPLEX RECEPTACLE
		◀	WALL MOUNTED DATA OUTLET
		⚡	FUSED DISCONNECT, FUSE PER MANUFACTURERS RECOMMENDATIONS.

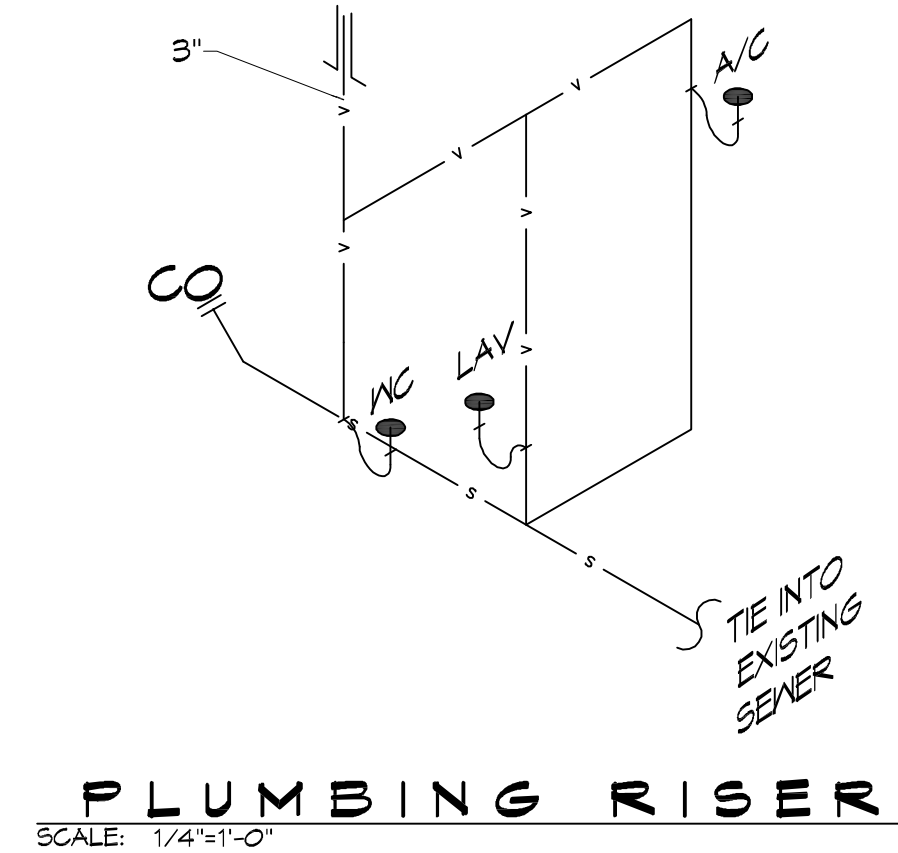

**PLUMBING RISER**  
SCALE: 1/4" = 1'-0"

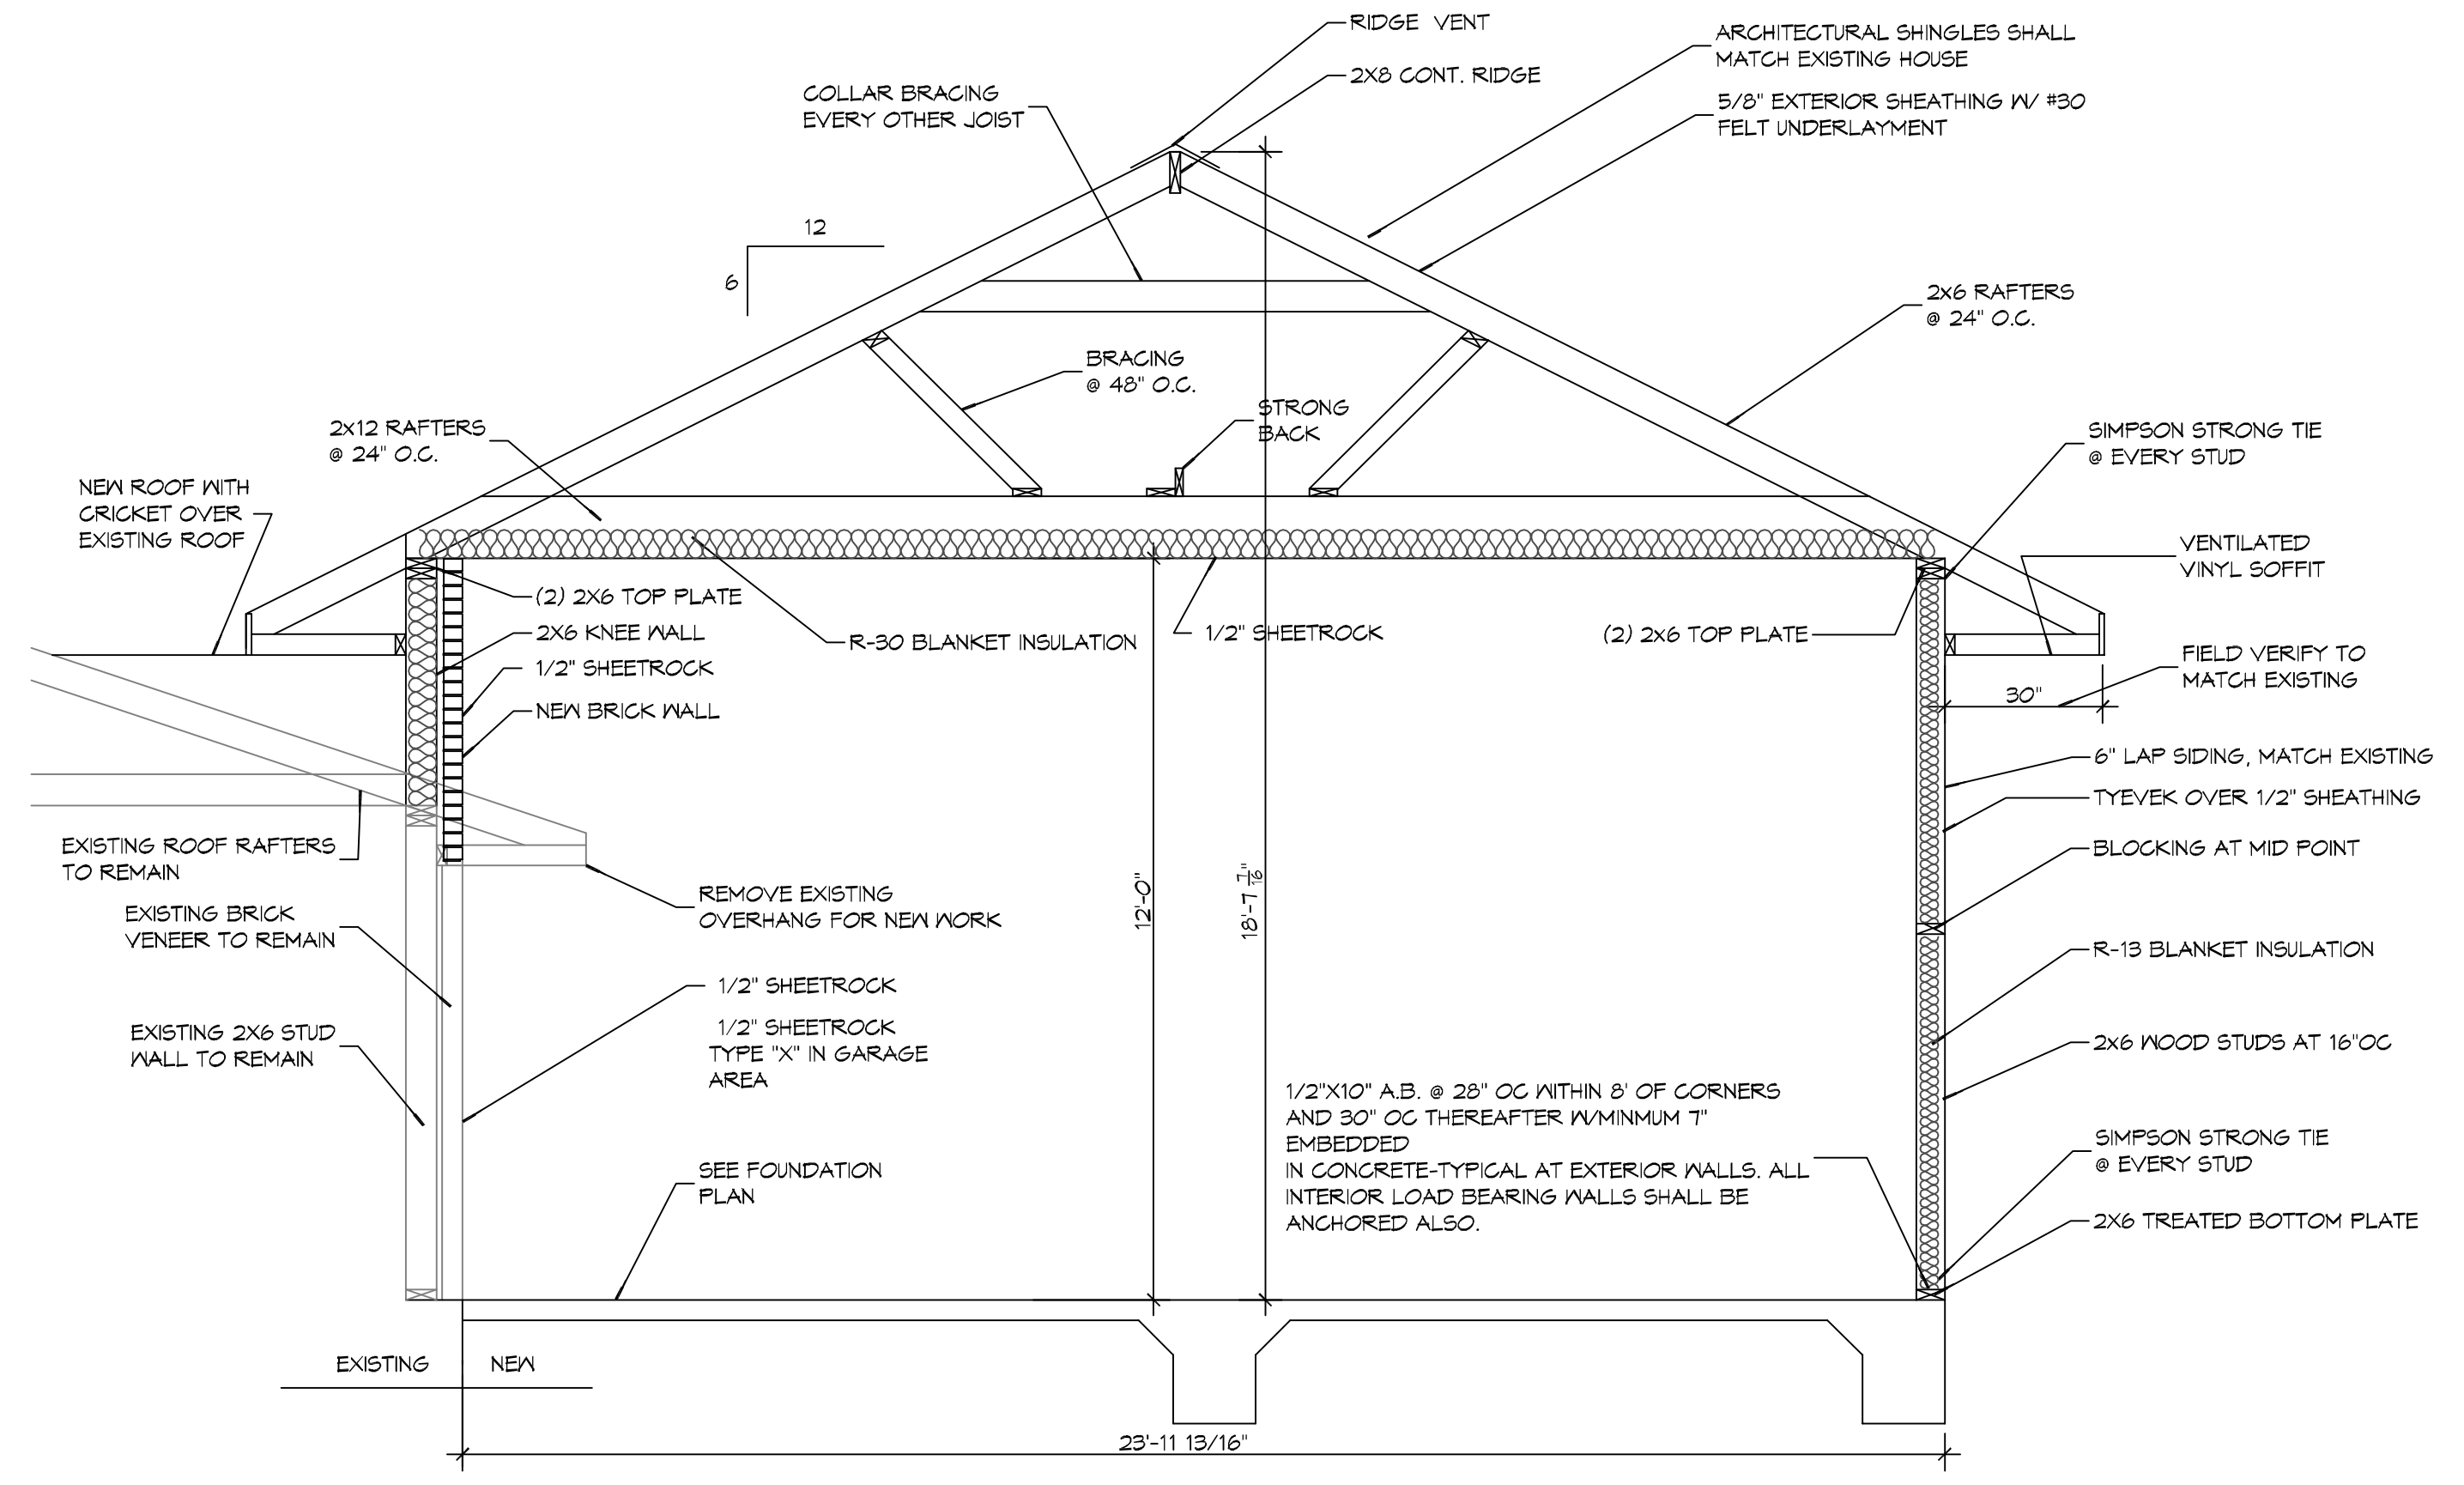

**TYPICAL SECTION**

SCALE: 3/8" = 1'-0"

FRAMING

**DAMMON ENGINEERING, INC.**

www.dammonengineering.com  
554 Old Spanish Trail  
Stell, LA 70458  
info@dammonengineering.com  
PH: 985.649.5852  
Fax: 985.641.5950

REVISIONS	DATE	DESCRIPTION



NEW GARAGE  
**ENZO PALLITTA**  
215 CHIBASCO LANE  
SLIDELL, LOUISIANA 70458  
JOB No: 2020 DATE: 01-10-2021  
DRAWN BY: CAC CHECKED BY: CAC

SHEET TITLE:  
FLOOR PLAN

DRAWING NUMBER:

**A101**