

LEGEND

- SANITARY WASTE TO GREASE TRAP
- - - SANITARY WASTE DIRECTLY TO SEWER LINE

PLUMBING SANITARY PLAN
3/16 = 1'-0"

PLUMBING ABBREVIATIONS


SYM.	DESCRIPTION
WC	WATER CLOSET
UR	URINAL
LAV	LAVATORY
MOP	MOP SINK
FS/HD	FLOOR SINK W/FLOOR DRAIN
HD	HUB DRAIN
HS	HAND SINK
WHS	WALL-MNTD. HAND SINK
UBS	UNDER BAR HAND SINK
FD	FLOOR DRAIN
WH	WATER HEATER
AHU	AHU DRAIN
DD	DISHWASHER DRAIN
DW	DISH WASHER
TS	TRIPLE SINK

PLUMBING FIXTURE SCHEDULE

MARK	DESCRIPTION	TYPE	ROUGH-IN SIZES	NOTES
			WASTE VENT CW H.W.	
WC	WATER CLOSET	VALVE	4" - 4"	1" - -
UR	URINAL	-	2" - 2"	1" - -
LAV	LAVATORY	-	2" - 2"	1/2" - 1/2"
MOP	MOP SINK	-	2" - 2"	1/2" - 1/2"
FS/HD	FLOOR SINK W/FLOOR DRAIN	-	2" - 2"	1/2" - 1/2"
HD	HUB DRAIN	-	2" - 2"	1/2" - 1/2"
HS	HAND SINK	-	2" - 2"	1/2" - 1/2"
WHS	WALL-MNTD. HAND SINK	-	2" - 2"	1/2" - 1/2"
UBS	UNDER BAR HAND SINK	-	2" - 2"	1/2" - 1/2"
FD	FLOOR DRAIN	-	3" - 2"	- -
WH	WATER HEATER	-	2" - 3/4"	3/4" - -
AHU	AHU DRAIN	-	4" - 2"	- -
DD	DISHWASHER DRAIN	-	2" - 1/2"	1/2" - -
DW	DISH WASHER	-	2" - 1/2"	1/2" - -
TS	TRIPLE SINK	-	2" - 2"	1/2" - 1/2"

- FIXTURE NOTES:**
1. PROVIDE CHAIR CARRIER FOR WALL HUNG FIXTURES.
 2. PROVIDE CHAR CARRIER FOR WALL HUNG FIXTURES.
 3. INSTALL CONTINUOUS SHIP VALVE ON ALL FLOOR DRAINS.

In joint venture with:

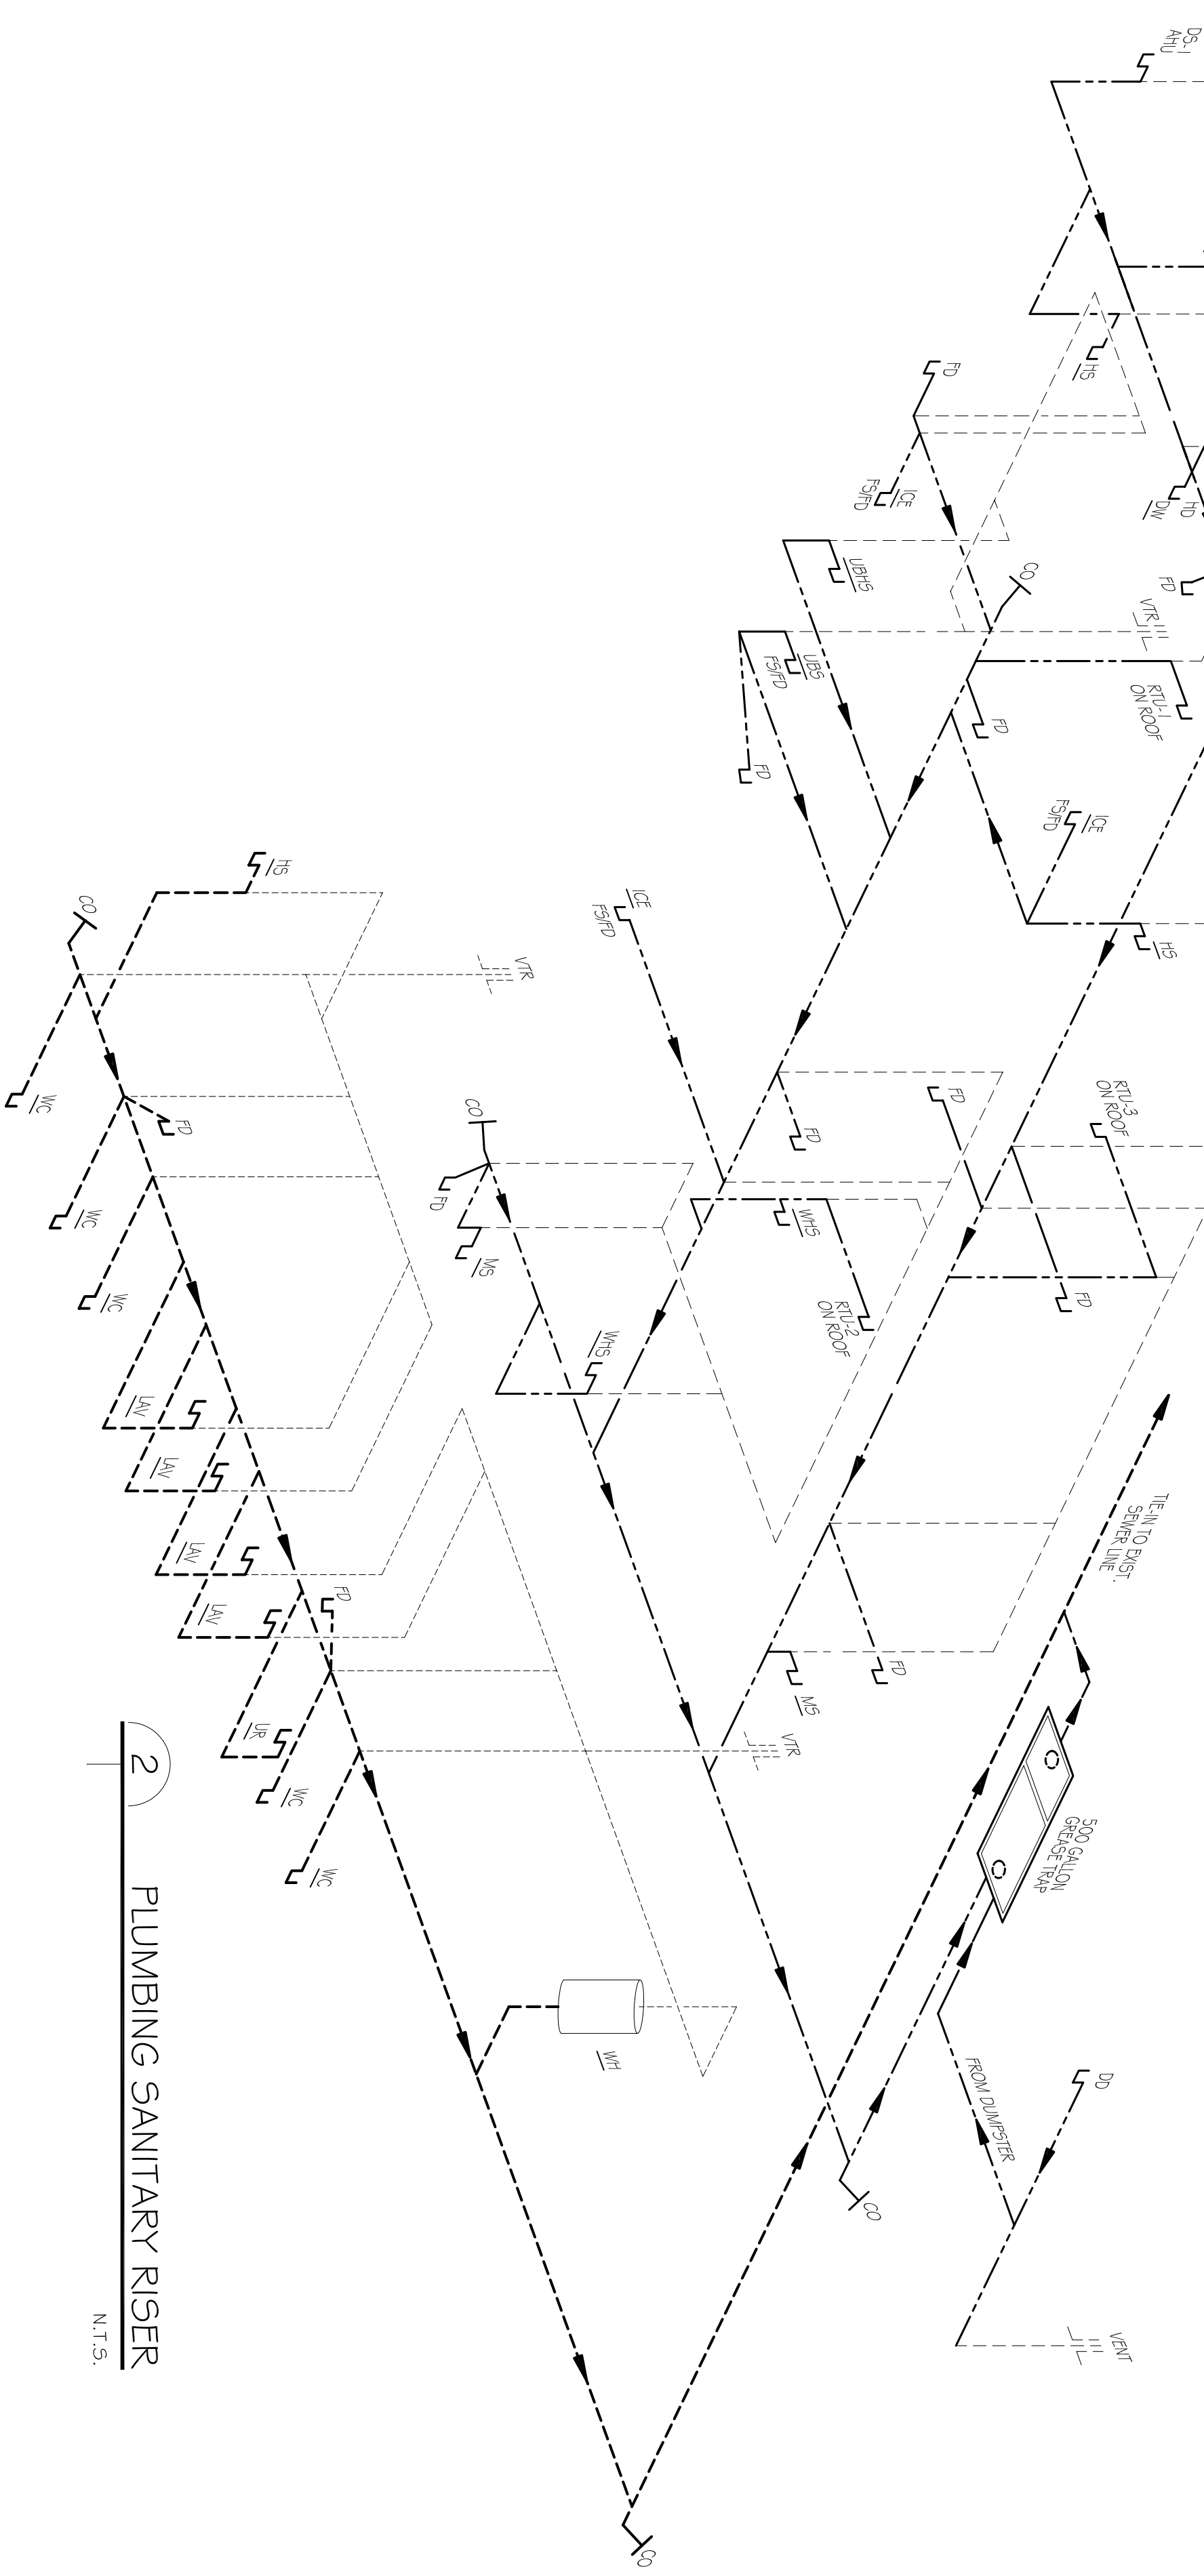


2 PLUMBING SANITARY RISER
N.T.S.

DAMMON ENGINEERING, INC.
Architects & Engineers

Chief Engineer: Brian Match, PE
334 Old Station Trail
Mandeville, LA 70448
www.dammonengineering.com
dammoneng@dammoneng.com
F: 985.641.3590

PLUMBING SANITARY PLAN & RISER
MUGSHOTS GRILL & BAR
RIDGELAND, MS

sheet no. **P-1**
of _____ sheets

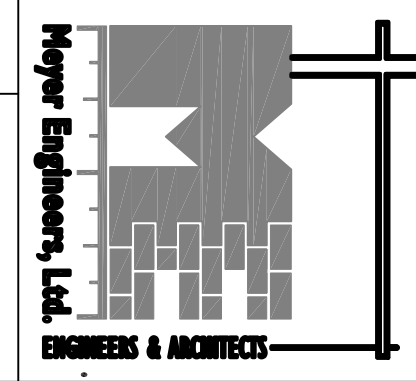

Meyer Engineers, Ltd.
4937 Hearst Street . Suite 1B . Metairie, Louisiana 70001
2031 Claiborne Street . Mandeville, Louisiana 70448
phone.504.885.9892 . fax.504.887.5056
website.www.meyer-e-l.com

Project no.	20-1348/
drawn	JTL
checked	CKD
date	08/12/2014
revised	