



FILE NAME: A:\PROJECTS\2022\22-0000\22-0000-MECH-PLAN-LEVEL-2.dwg
 PLOT DATE: 3/11/2023 11:05:25 AM
 PLOT BY: J. K. K.

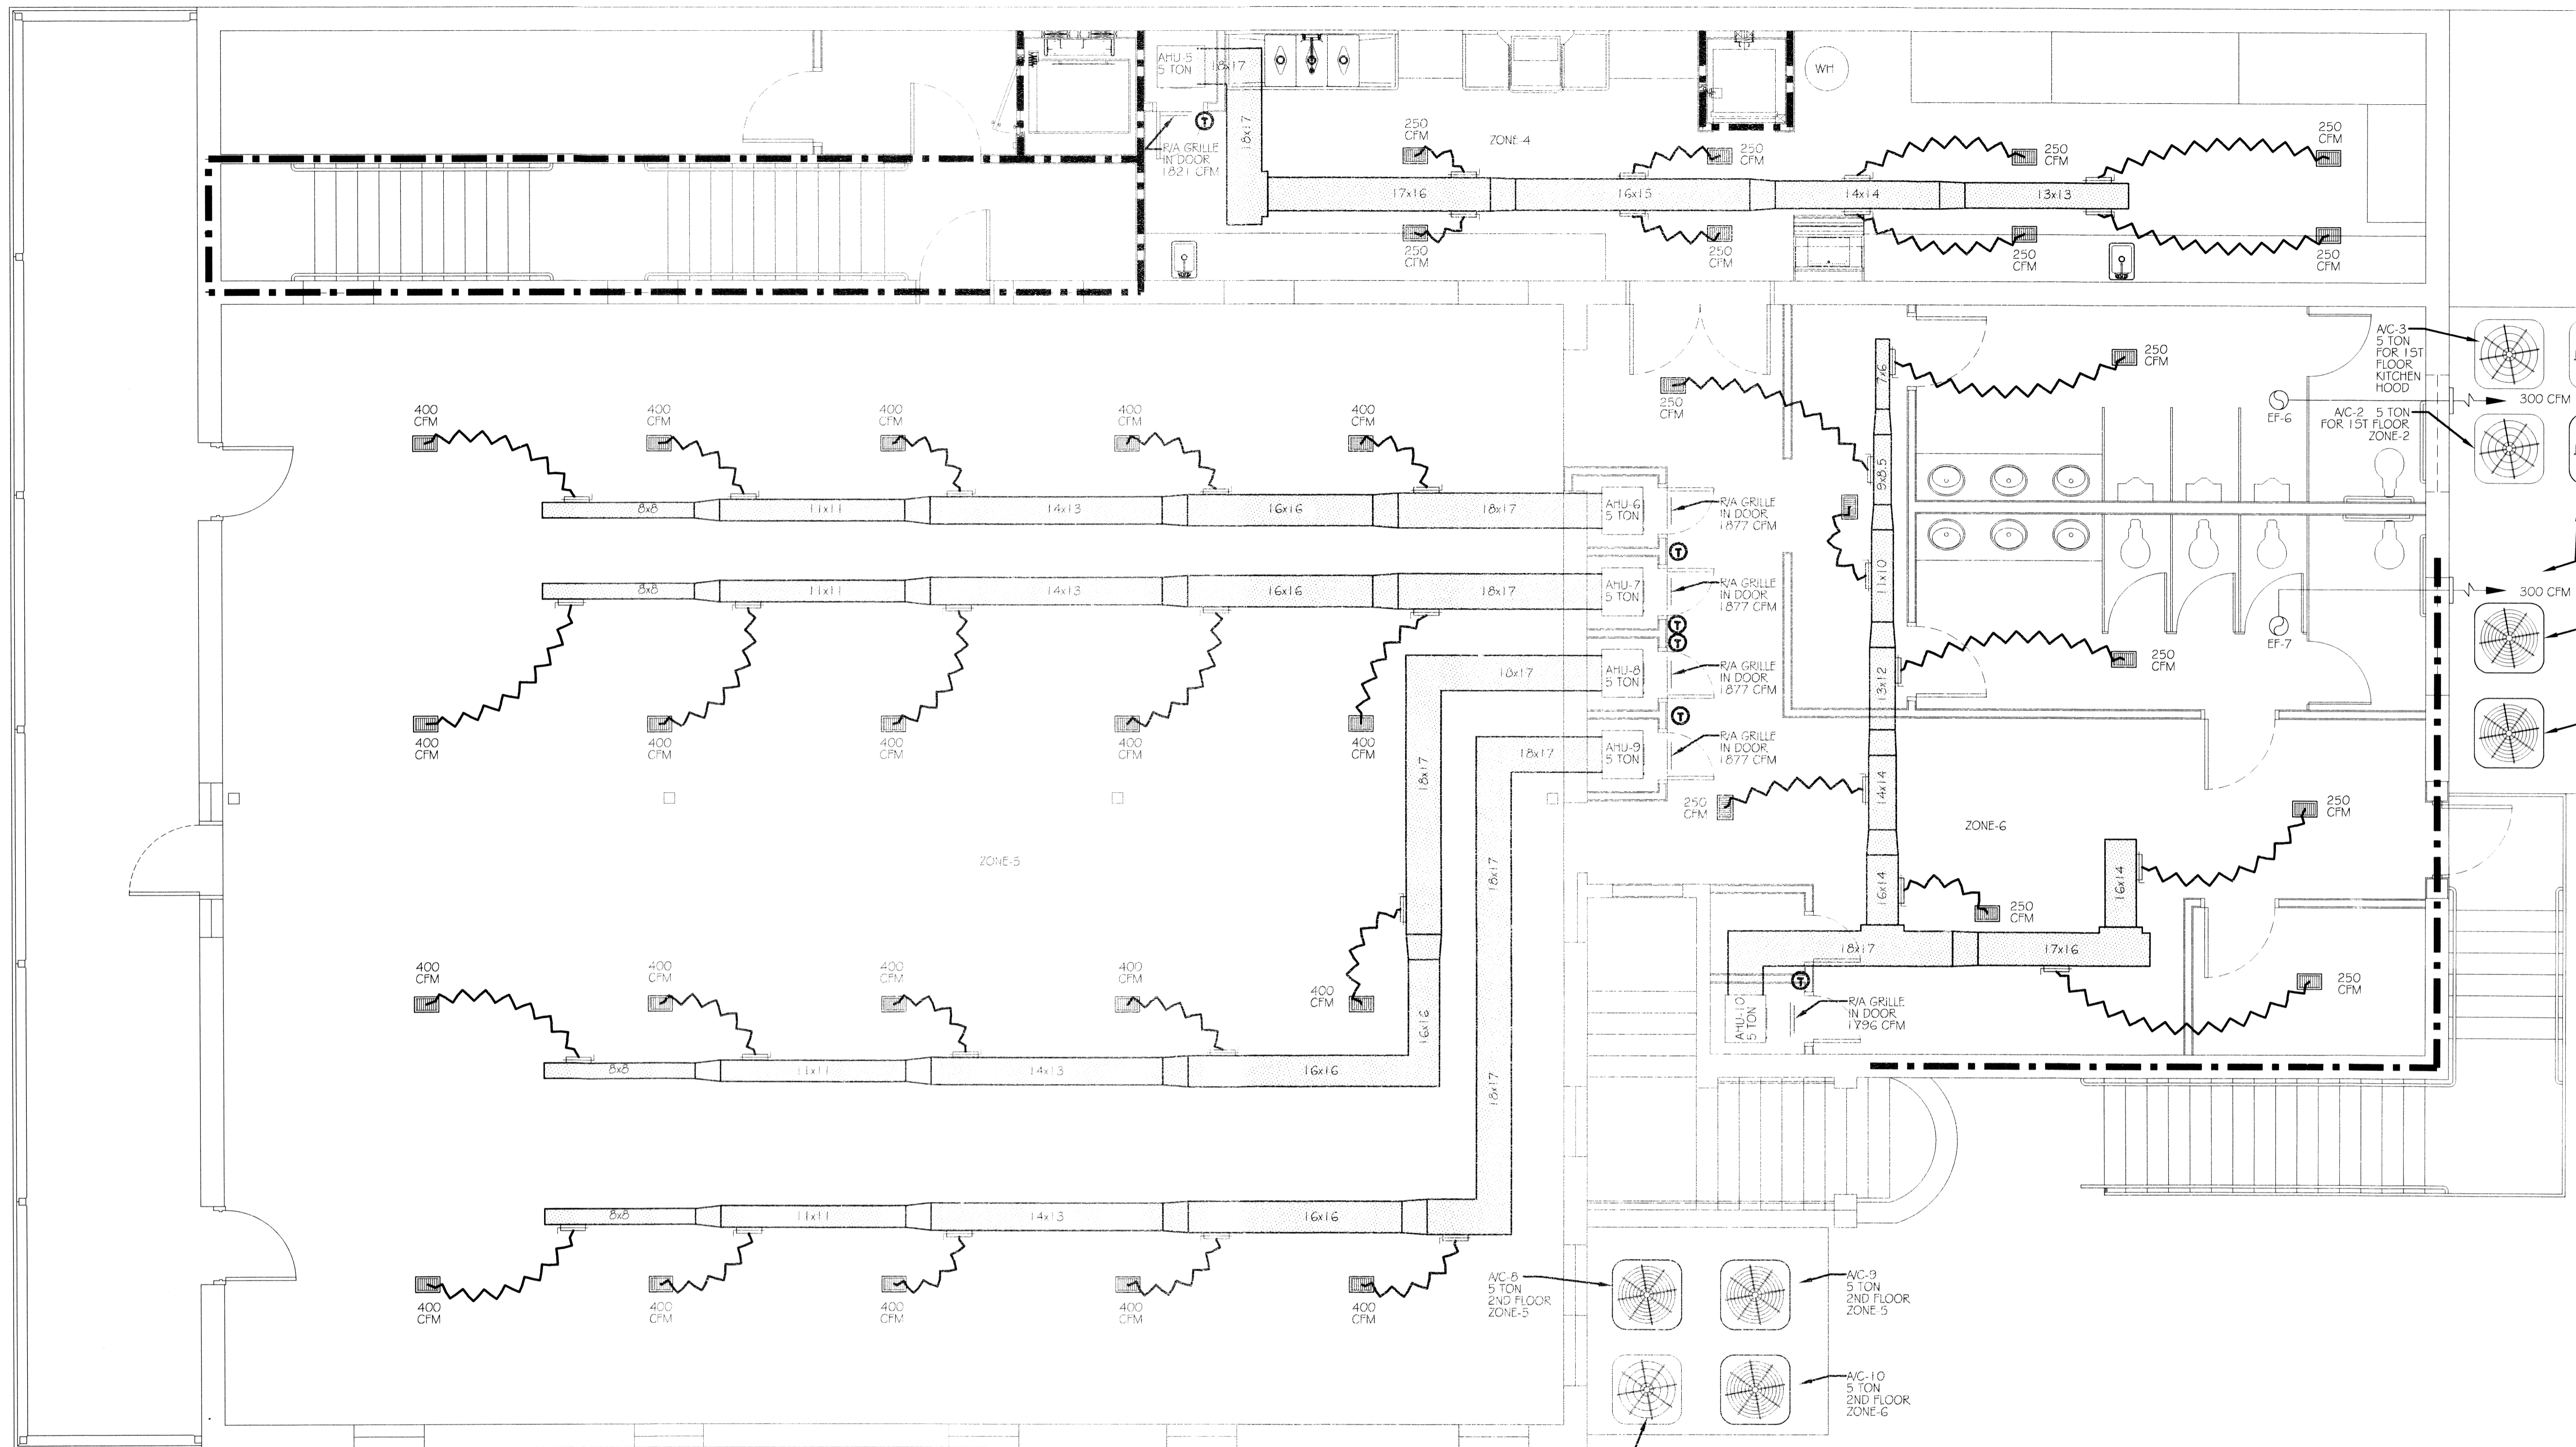

- LEGEND**
- SUPPLY AIR GRILLE CEILING MOUNTED
 - RETURN AIR GRILLE IN HVAC CLOSET DOOR
 - DAMPER CONTROL AT DUCTWORK
 - SUPPLY AIR DUCT FOR AHU UNITS
 - ROUND FLEX DUCT, MAX LENGTH 14'-0" MIN. R-G. PROVIDE MAN. DAMPER AT TRUNK LINE, DUCT SIZES AS SHOWN
 - EXHAUST FAN
 - DUCTLESS SYSTEM OUTSIDE CONDENSING UNIT (FOR 1ST FLOOR)
 - SPLIT SYSTEM AIR HANDLING UNIT (AHU) IN CLOSET
 - SPLIT SYSTEM CONDENSING UNIT OUTSIDE ON DECK (FOR 1ST FLOOR)
 - SPLIT SYSTEM CONDENSING UNIT OUTSIDE ON DECK (FOR 2ND FLOOR)
 - THERMOSTAT

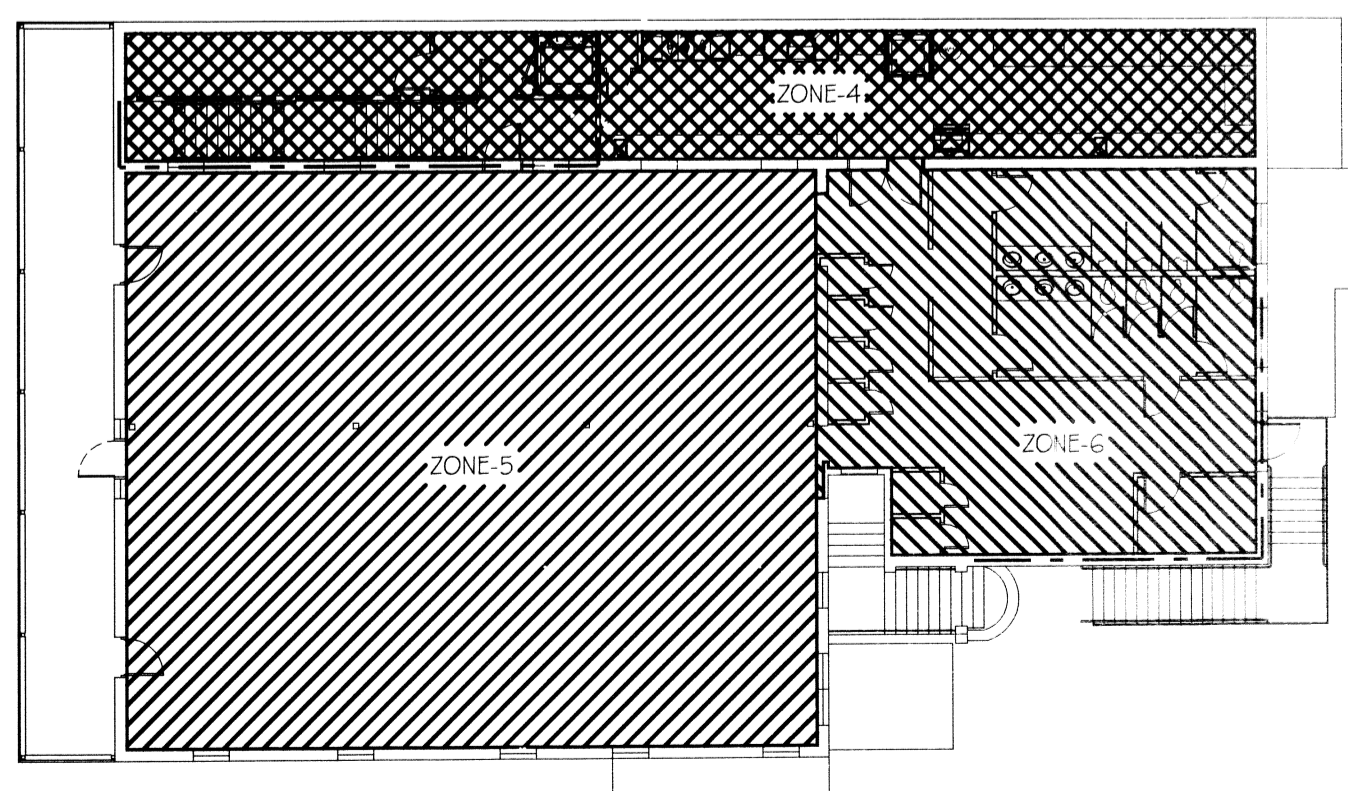


2 ZONE KEY PLAN
SCALE: 1/16" = 1'-0"

1 MECHANICAL PLAN - LEVEL 2
SCALE: 1/4" = 1'-0"

DAMMON ENGINEERING, INC.
 ARCHITECTS & ENGINEERS
 www.dammonengineering.com
 info@dammonengineering.com
 55 Old Spanish Trail
 Metairie, LA 70002
 PH: 985.649.9832
 F: 985.641.9950

#	DESCRIPTION	DATE

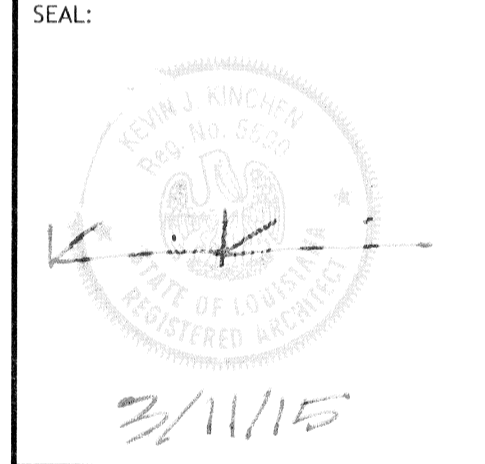

RECEPTION HALL RENOVATION FOR:
BEV, INCORPORATED
 211 COUSIN STREET
 SUITE 100
 SUDBURY, LOUISIANA 70458
 JOB No: 2220 DATE: MARCH 08-2023
 DRAWN BY: KJK CHECKED BY: CAD

SHEET TITLE:
 MECHANICAL PLAN
 LEVEL 2
 DRAWING NUMBER:
M2
 SHEET No: 13 of 19

465406
 REVIEWED FOR
 STATE FIRE MARSHAL
 AS PER REVIEW LETTER
 BY: WILLIAM D. JONES, ARCHITECT, CBO
William D. Jones