

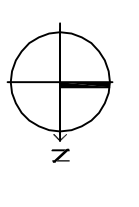



COPYRIGHT  
 THESE DOCUMENTS ARE PROTECTED BY UNITED STATES COPYRIGHT LAW. THEY HAVE BEEN PREPARED SPECIFICALLY FOR THE PROJECT IDENTIFIED AND ARE NOT SUITABLE FOR USE ON ANY OTHER PROJECT OR AT ANY OTHER LOCATION WITHOUT THE EXPRESS WRITTEN APPROVAL AND PARTICIPATION OF MURRAY ARCHITECTS. REPRODUCTION OF THESE DOCUMENTS MUST BE AUTHORIZED BY THE ARCHITECT. ALL RIGHTS ARE RESERVED TO MURRAY ARCHITECTS.

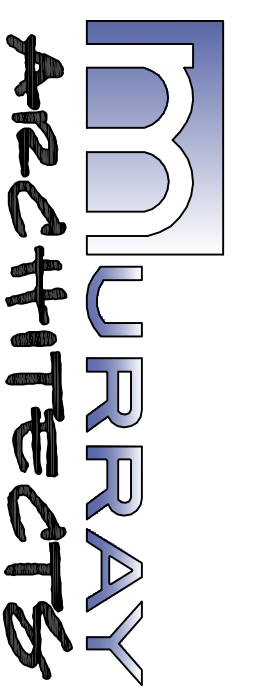

MECHANICAL ROOF PLAN  
 SCALE: 1/4"=1'-0"

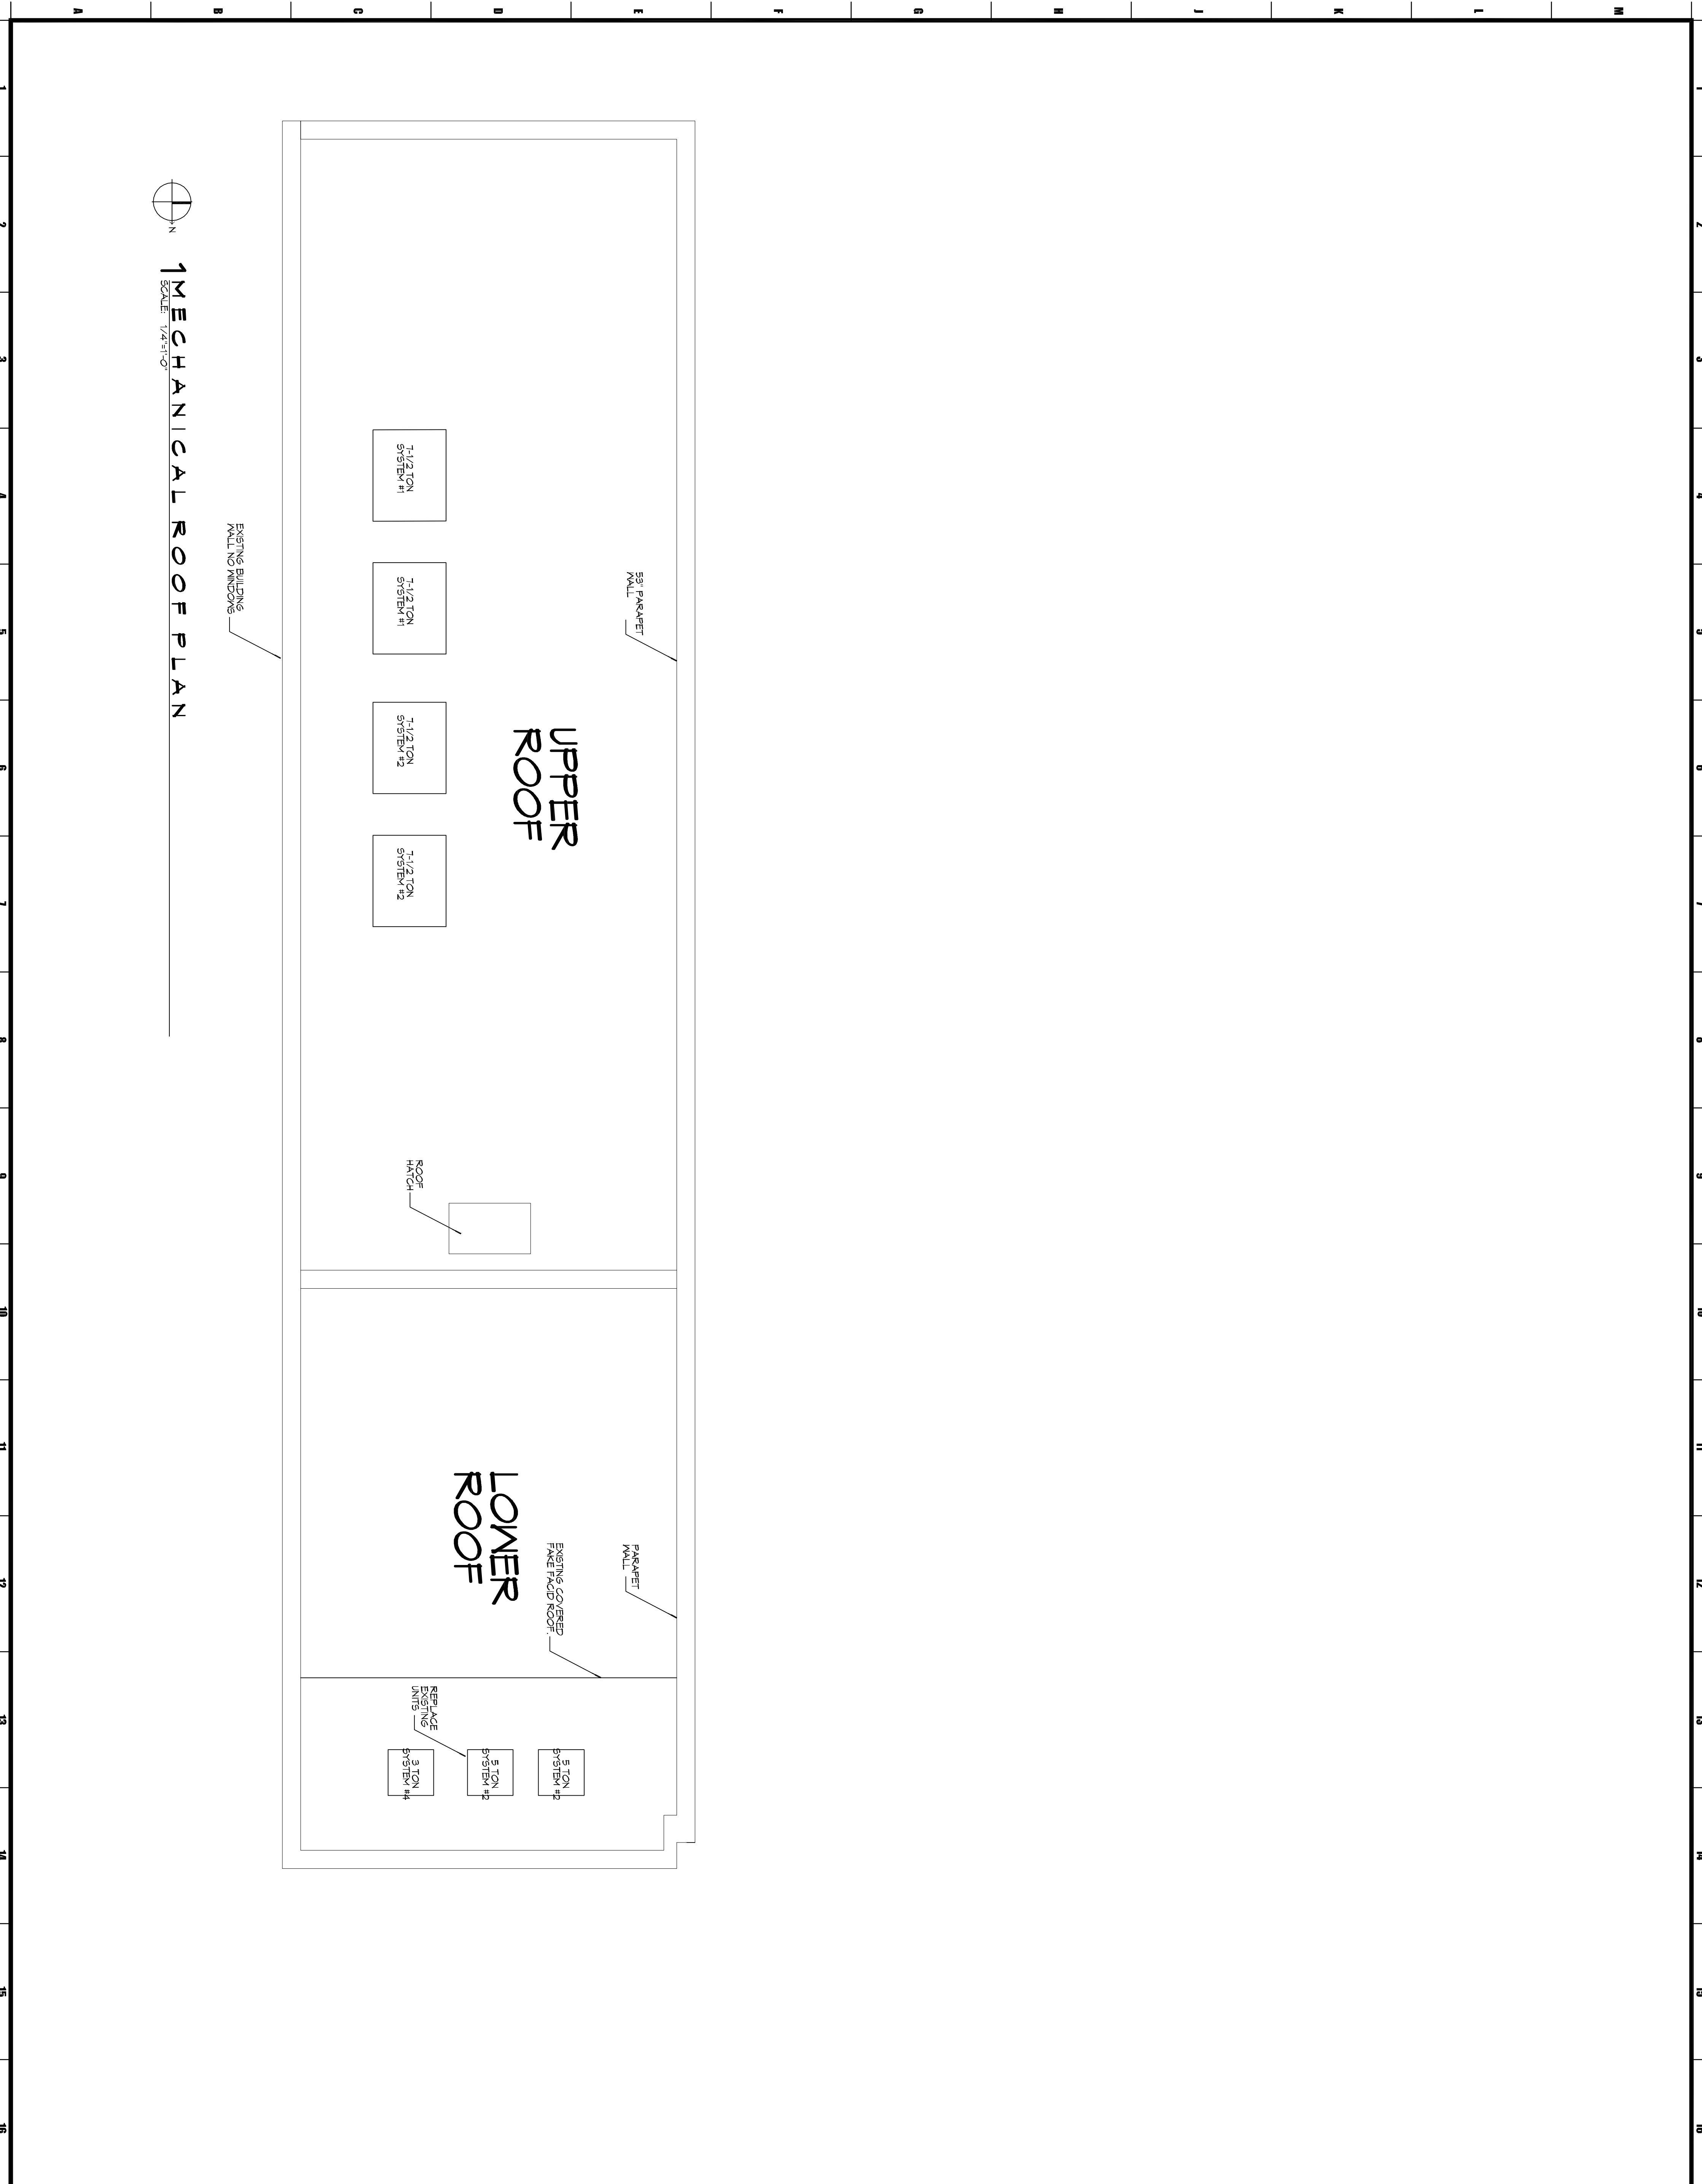

131 ormond center court  
 destrehan, la 70047  
 (985) 764-7275  
 fax (985) 725-0182

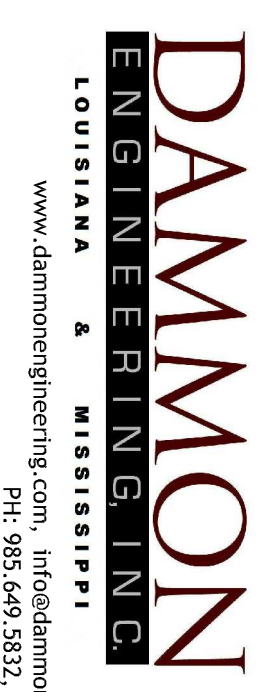

Chief Engineer:  
 Brian Mastich, PE  
 554 Old Spanish  
 Trail  
 Slidell, LA 70458

NO.	REVISION	DATE
1		
2		
3		
4		
5		
6		

301 ROYAL ST.

Scale: **M102**

**MURRAY ARCHITECTS**  
 PROJECT NUMBER: 1334  
 DATE: 7.1.2013  
 DRAWING NUMBER: M102

CD

