



1 ENLARGED RESTROOM PLAN
SCALE: 3/8" = 1'-0"


NOTE: REFER TO INTERIOR DESIGN DRAWINGS BY OTHERS FOR INTERIOR FINISH SPECIFICATIONS, PAINT AND STAIN COLORS (FLOORS, WALLS, CEILING, ETC.).

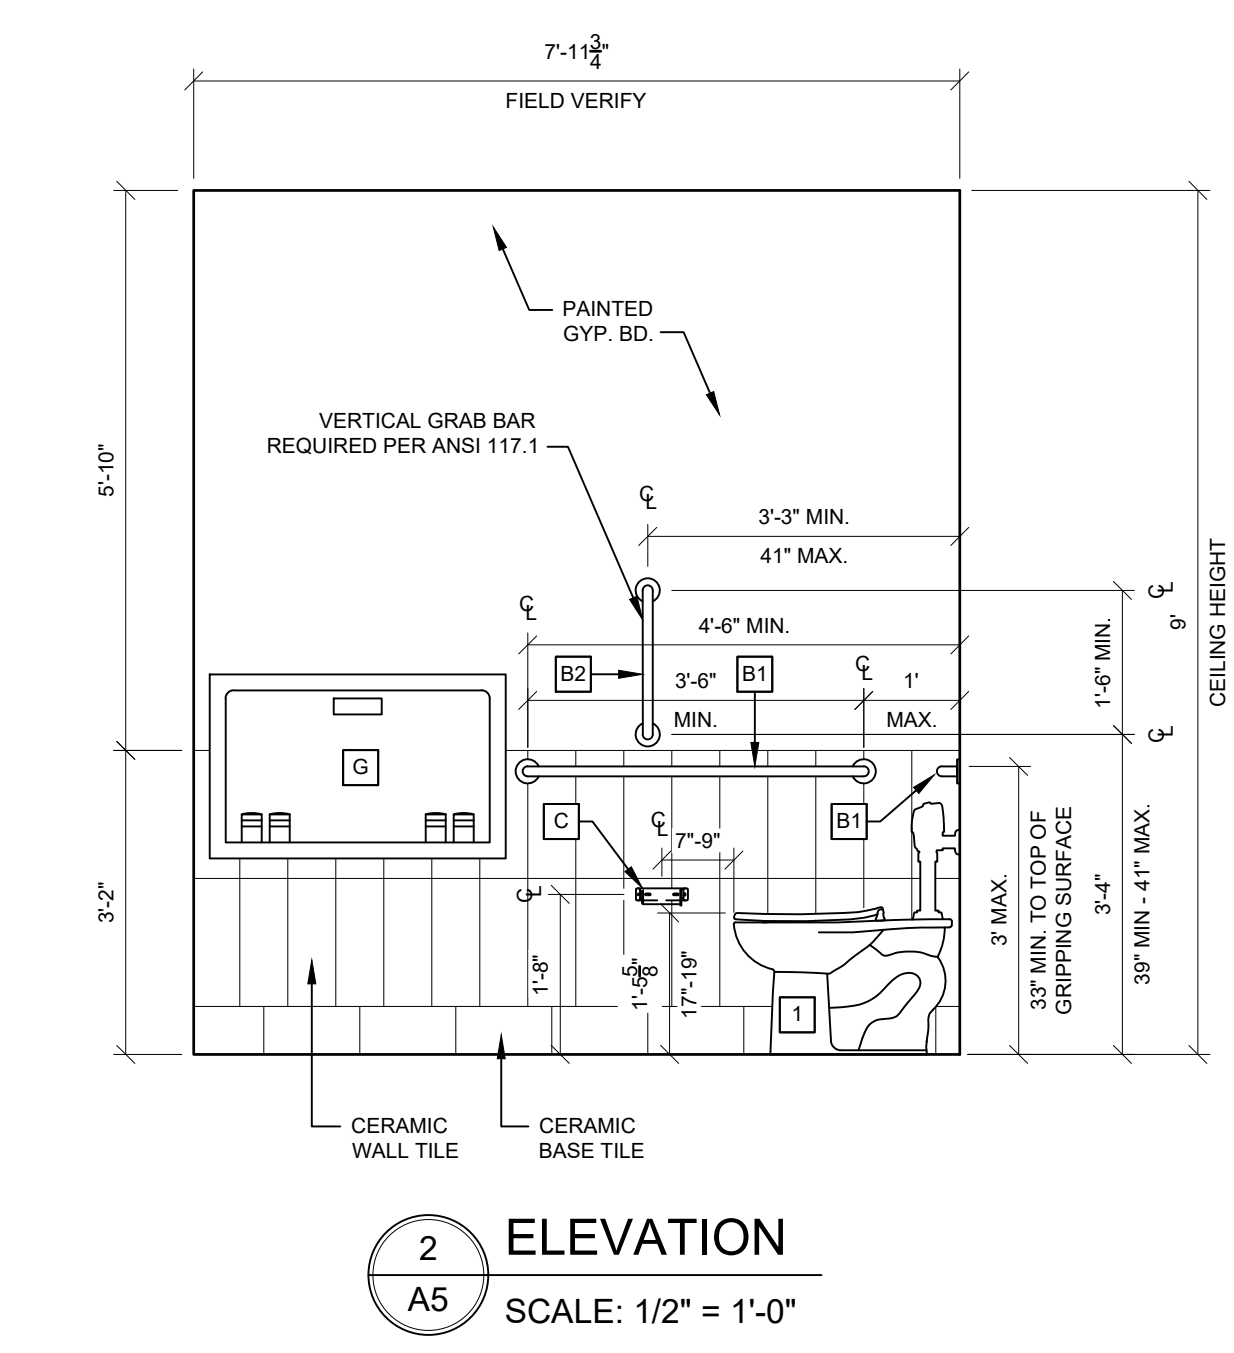


2 ELEVATION
SCALE: 1/2" = 1'-0"

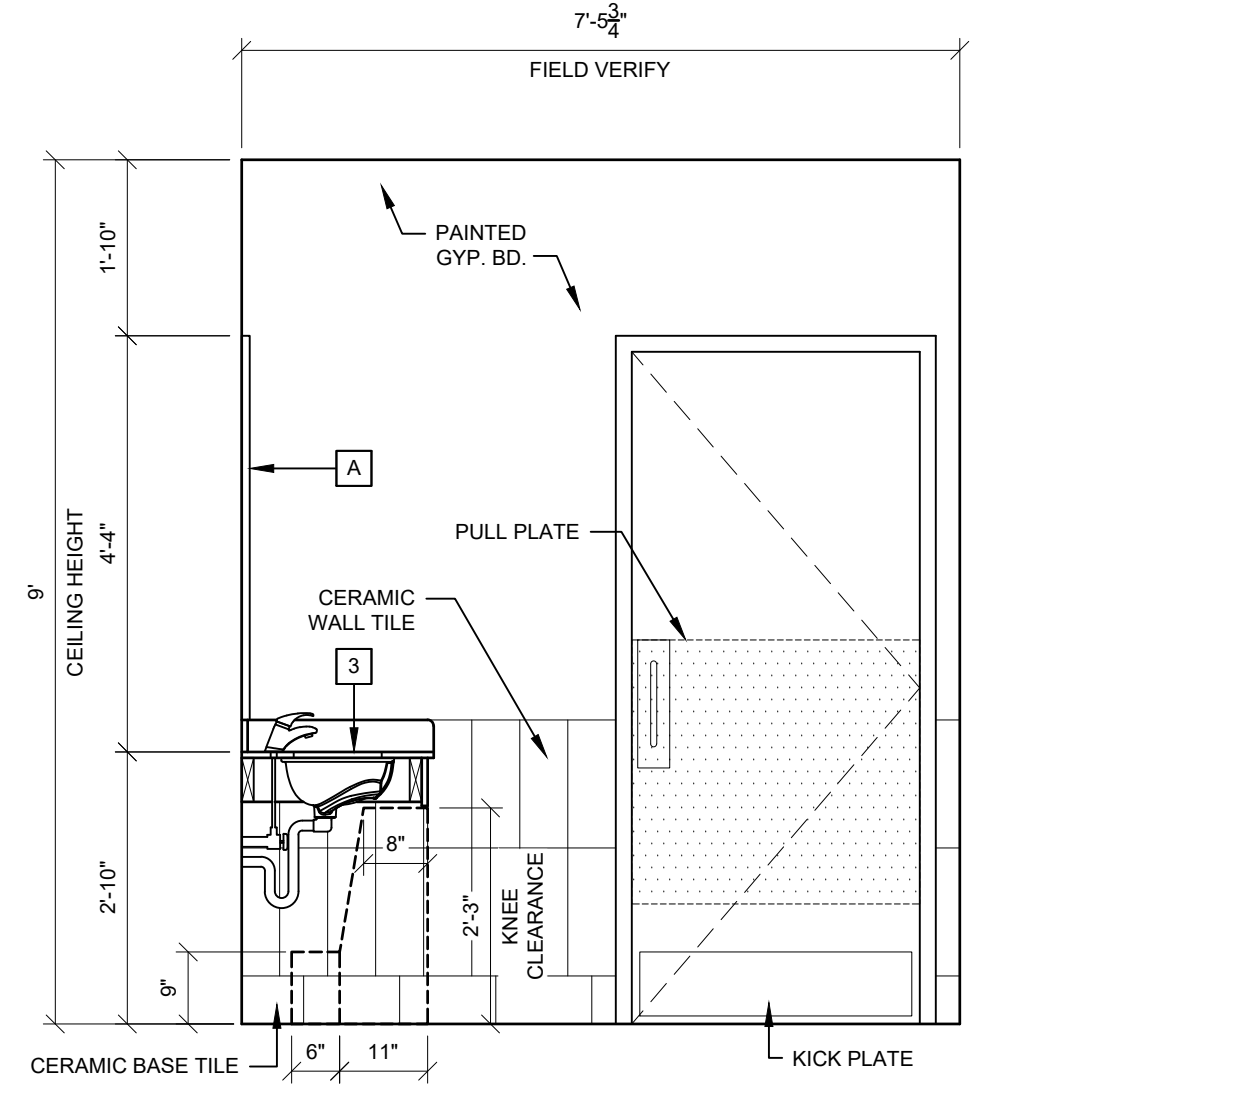


4 ELEVATION
SCALE: 1/2" = 1'-0"

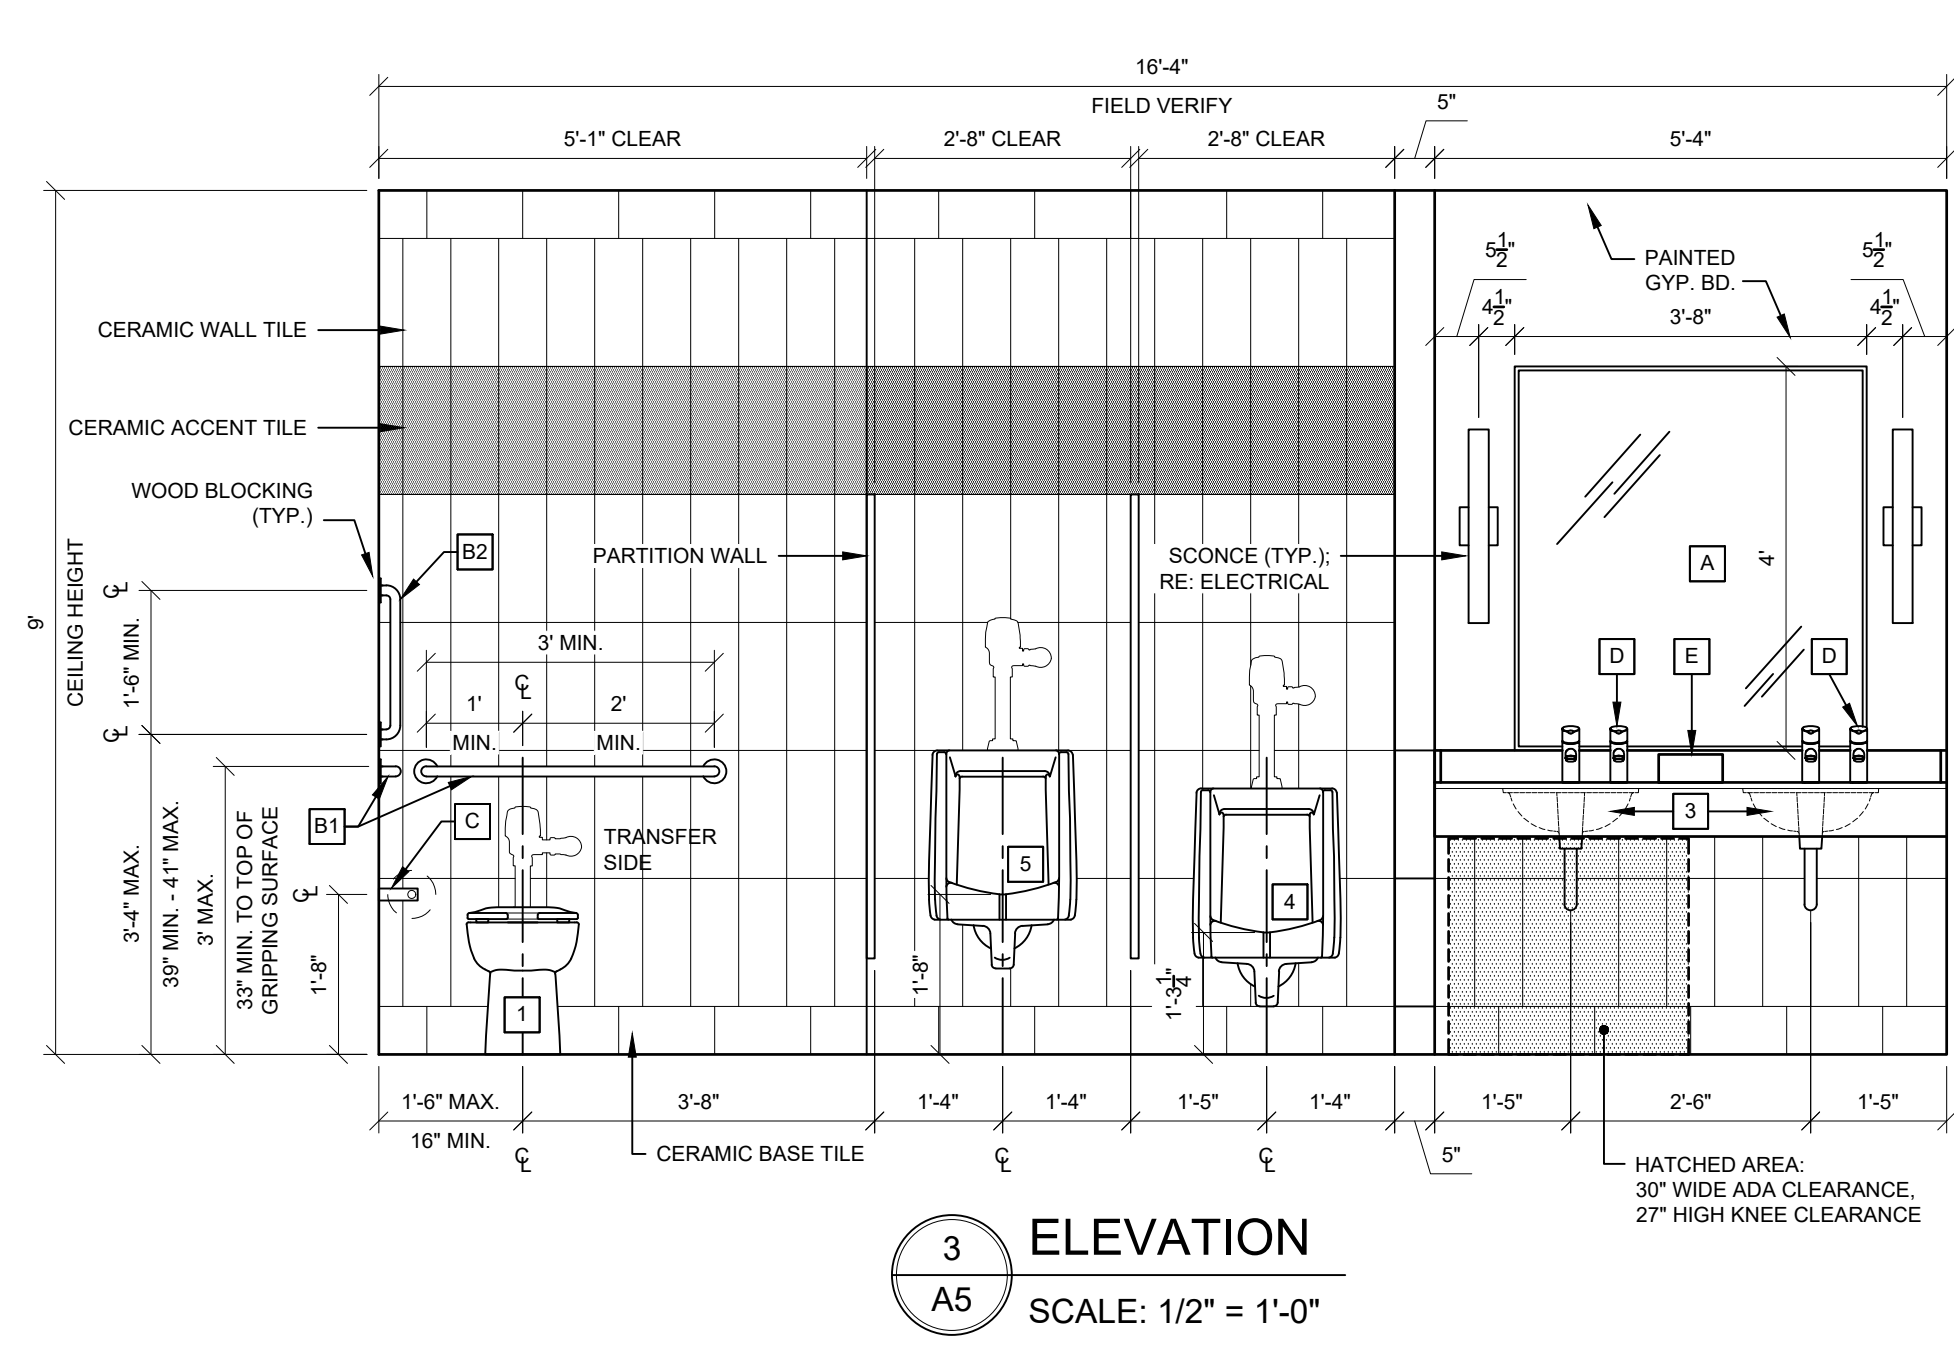


3 ELEVATION
SCALE: 1/2" = 1'-0"

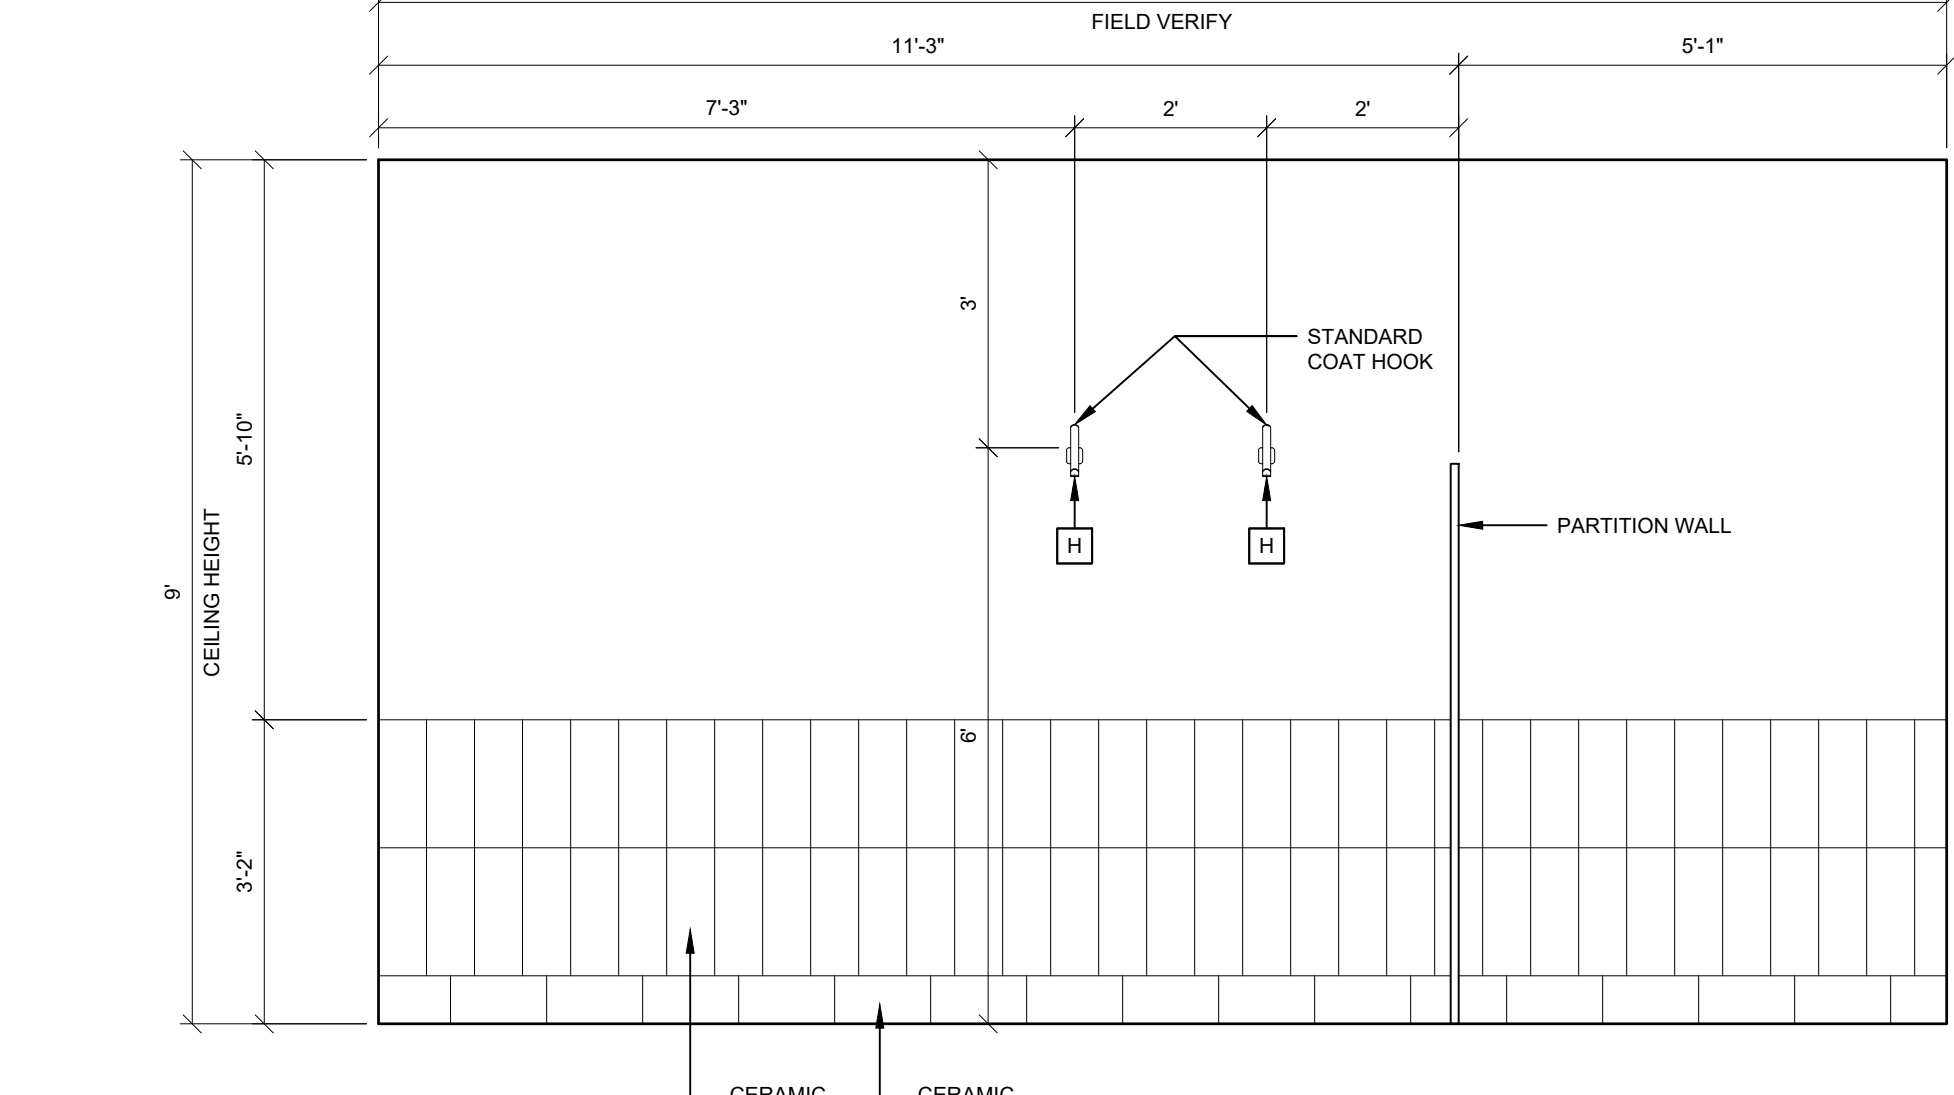

5 ELEVATION
SCALE: 1/2" = 1'-0"

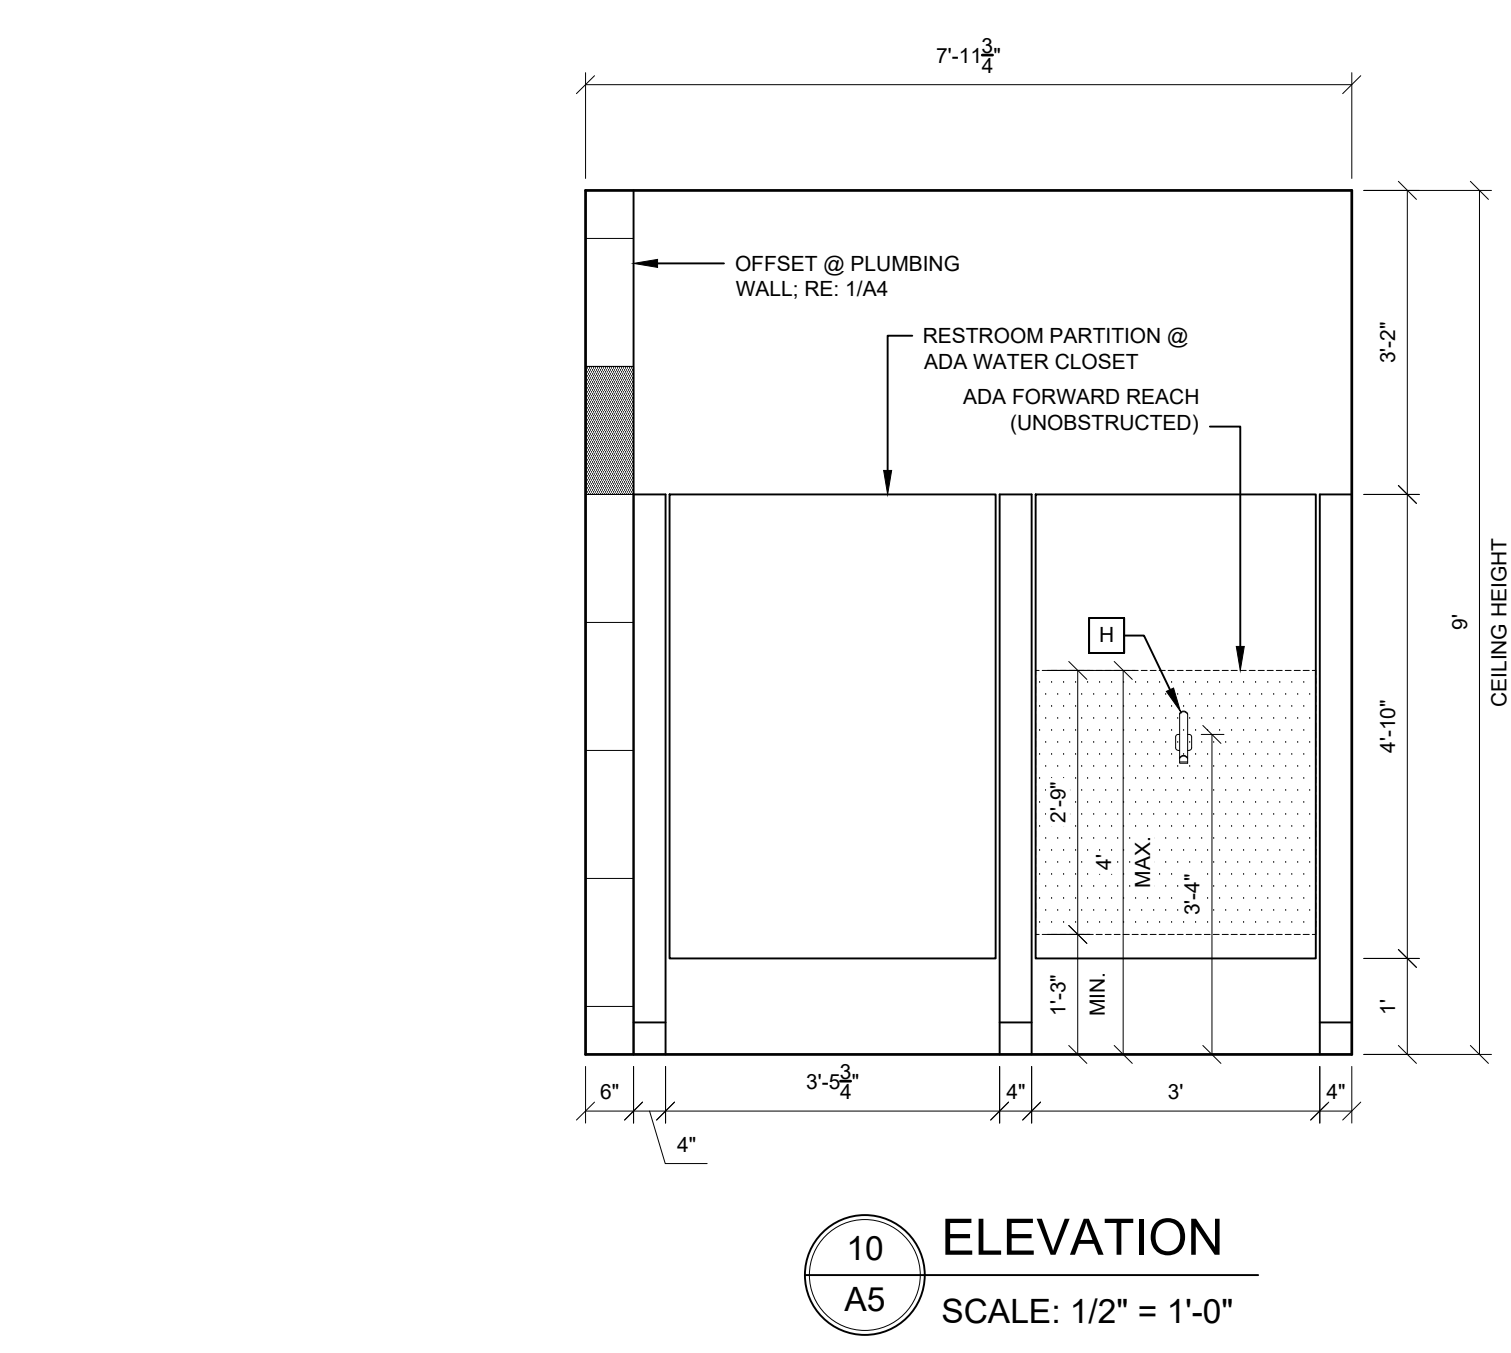

10 ELEVATION
SCALE: 1/2" = 1'-0"

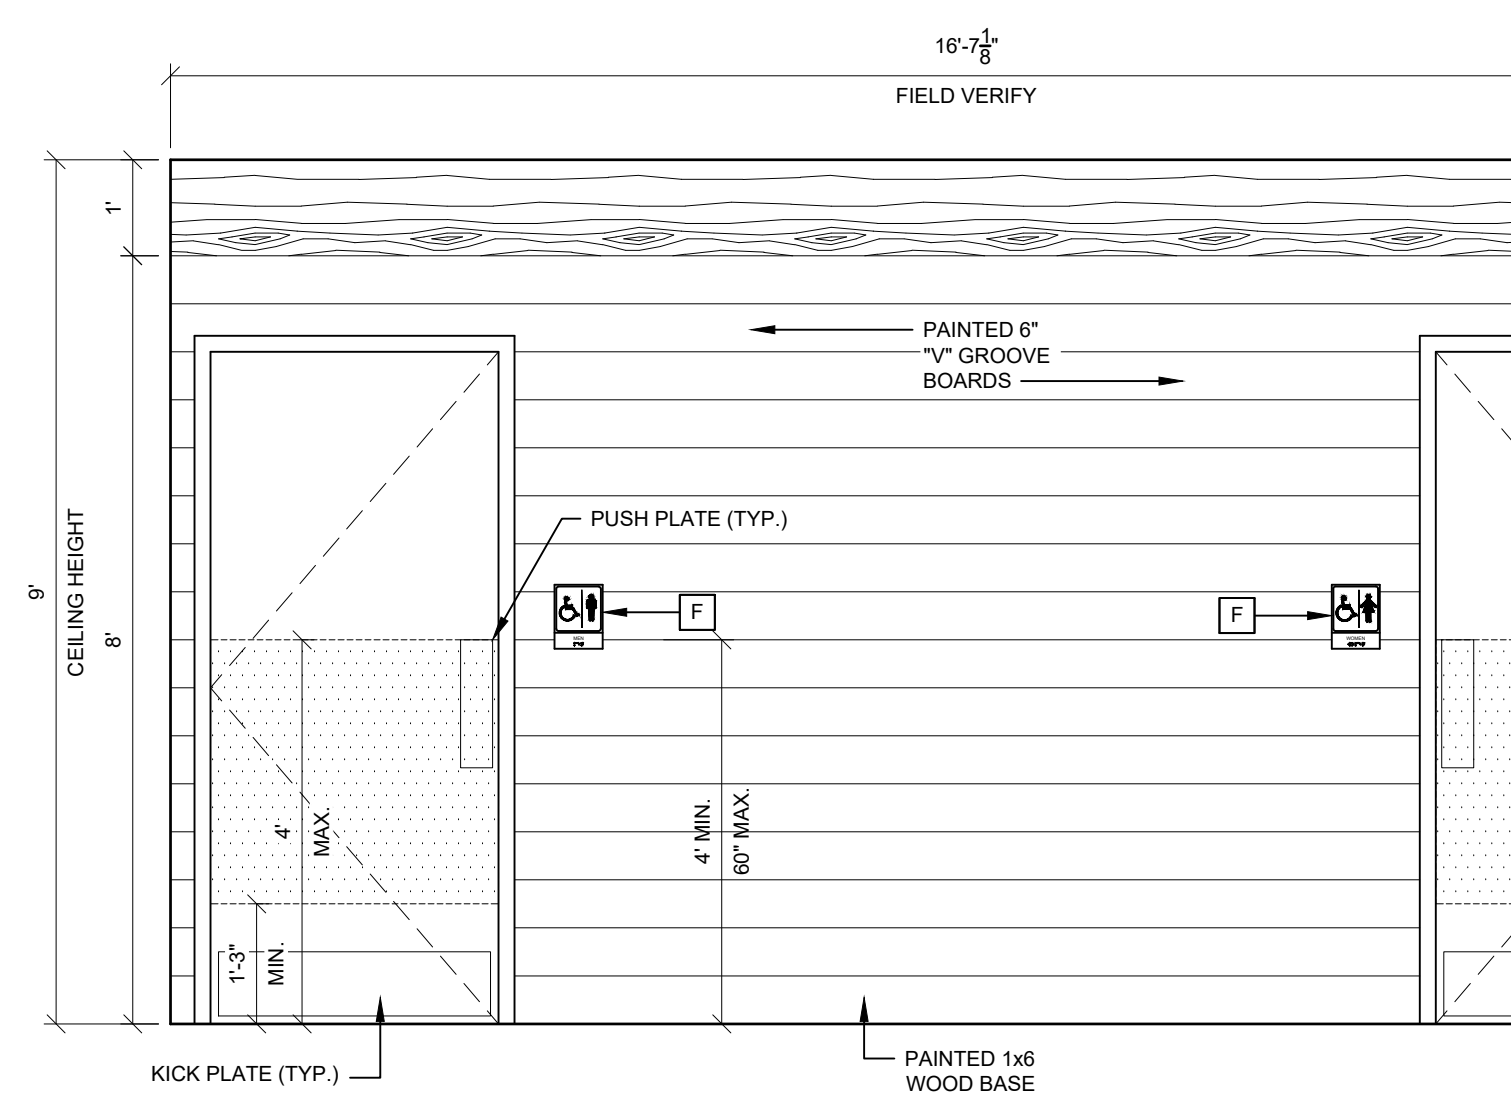


11 ELEVATION - VESTIBULE
SCALE: 1/2" = 1'-0"


DESCRIPTION	TAG	MANUFACTURER / CATALOG NO.
MIRROR	A	PROVIDED BY TENANT. INSTALLED BY CONTRACTOR. MOUNT 40" A.F.F. MAX. TO BOTTOM OF REFLECTIVE SURFACE. REFER TO INTERIOR DESIGN DRAWINGS FOR ADDITIONAL INFORMATION.
HORIZONTAL GRAB BAR	B1	EXISTING GRAB BAR TO REMAIN. REMOVE FOR INSTALLATION OF NEW WALL FINISHES. REFER TO RESTROOM PLAN AND ELEVATIONS THIS SHEET FOR MOUNTING DIMENSIONS.
VERTICAL GRAB BAR	B2	VERTICAL GRAB BAR: BOBRICK B-8606 x 18", 18 GAUGE TYPE 304 STAINLESS STEEL. SATIN FINISH OR EQUAL (MATCH EXISTING). MOUNT TO WALL USING ANCHOR PLATES TO WITHSTAND 250 LB. VERTICAL AND HORIZONTAL PRESSURE. GRAB BARS SHALL NOT ROTATE WITHIN THEIR FITTINGS. EDGES SHALL HAVE A MINIMUM RADIUS OF 1/8". GRAB BARS SHALL BE 1-1/2" CLEAR FROM WALL. REFER TO RESTROOM PLAN AND ELEVATIONS THIS SHEET FOR MOUNTING DIMENSIONS.
TOILET PAPER DISPENSER	C	PROVIDED BY TENANT. INSTALLED BY CONTRACTOR. MOUNT 20" A.F.F. TO CENTER LINE. REFER TO INTERIOR DESIGN DRAWINGS FOR ADDITIONAL INFORMATION.
SOAP DISPENSER	D	PROVIDED BY TENANT. INSTALLED BY CONTRACTOR. COUNTER MOUNTED NEAR LAVATORY. REFER TO INTERIOR DESIGN DRAWINGS FOR ADDITIONAL INFORMATION.
PAPER TOWEL DISPENSER	E	PROVIDED BY TENANT. INSTALLED BY CONTRACTOR. MOUNT PER ADA REACH REQUIREMENTS. REFER TO INTERIOR DESIGN DRAWINGS FOR ADDITIONAL INFORMATION.
ADA TACTILE SIGNAGE	F	PROVIDED BY TENANT. INSTALLED BY CONTRACTOR. MOUNT PER ADA REQUIREMENTS.
CHANGING TABLE	G	EXISTING CHANGING TABLE TO REMAIN. REMOVE FOR INSTALLATION OF NEW WALL FINISHES. REFER TO RESTROOM PLAN AND ELEVATIONS THIS SHEET FOR MOUNTING DIMENSIONS.
HAT AND COAT HOOK	H	*THIS ITEM IS OPTIONAL - VERIFY WITH TENANT* IF REQUIRED, ITEM SHALL BE PROVIDED BY TENANT. INSTALLED BY CONTRACTOR.
WATER CLOSET	1	ADA FLOOR MOUNTED FLUSH VALVE OPERATED WATER CLOSET. RE: PLUMBING
WATER CLOSET	2	STANDARD HEIGHT FLOOR MOUNTED FLUSH VALVE OPERATED WATER CLOSET. RE: PLUMBING
LAVATORY	3	ADA UNDER COUNTER MOUNTED LAVATORY. RE: PLUMBING
URINAL	4	ADA WALL MOUNTED FLUSH VALVE OPERATED URINAL. RE: PLUMBING
URINAL	5	STANDARD HEIGHT WALL MOUNTED FLUSH VALVE OPERATED URINAL. RE: PLUMBING

RESTROOM SPECIFIC NOTES:


- SEE PLUMBING DRAWINGS FOR PLUMBING FIXTURE SPECIFICATIONS.
- ALL FIXTURES AND ACCESSORIES ARE NEW EXCEPT WHERE NOTED.
- CONTRACTOR SHALL PROVIDE BLOCKING FOR ALL WALL MOUNTED FIXTURES & ACCESSORIES PER MANUFACTURER'S SPECIFICATIONS.

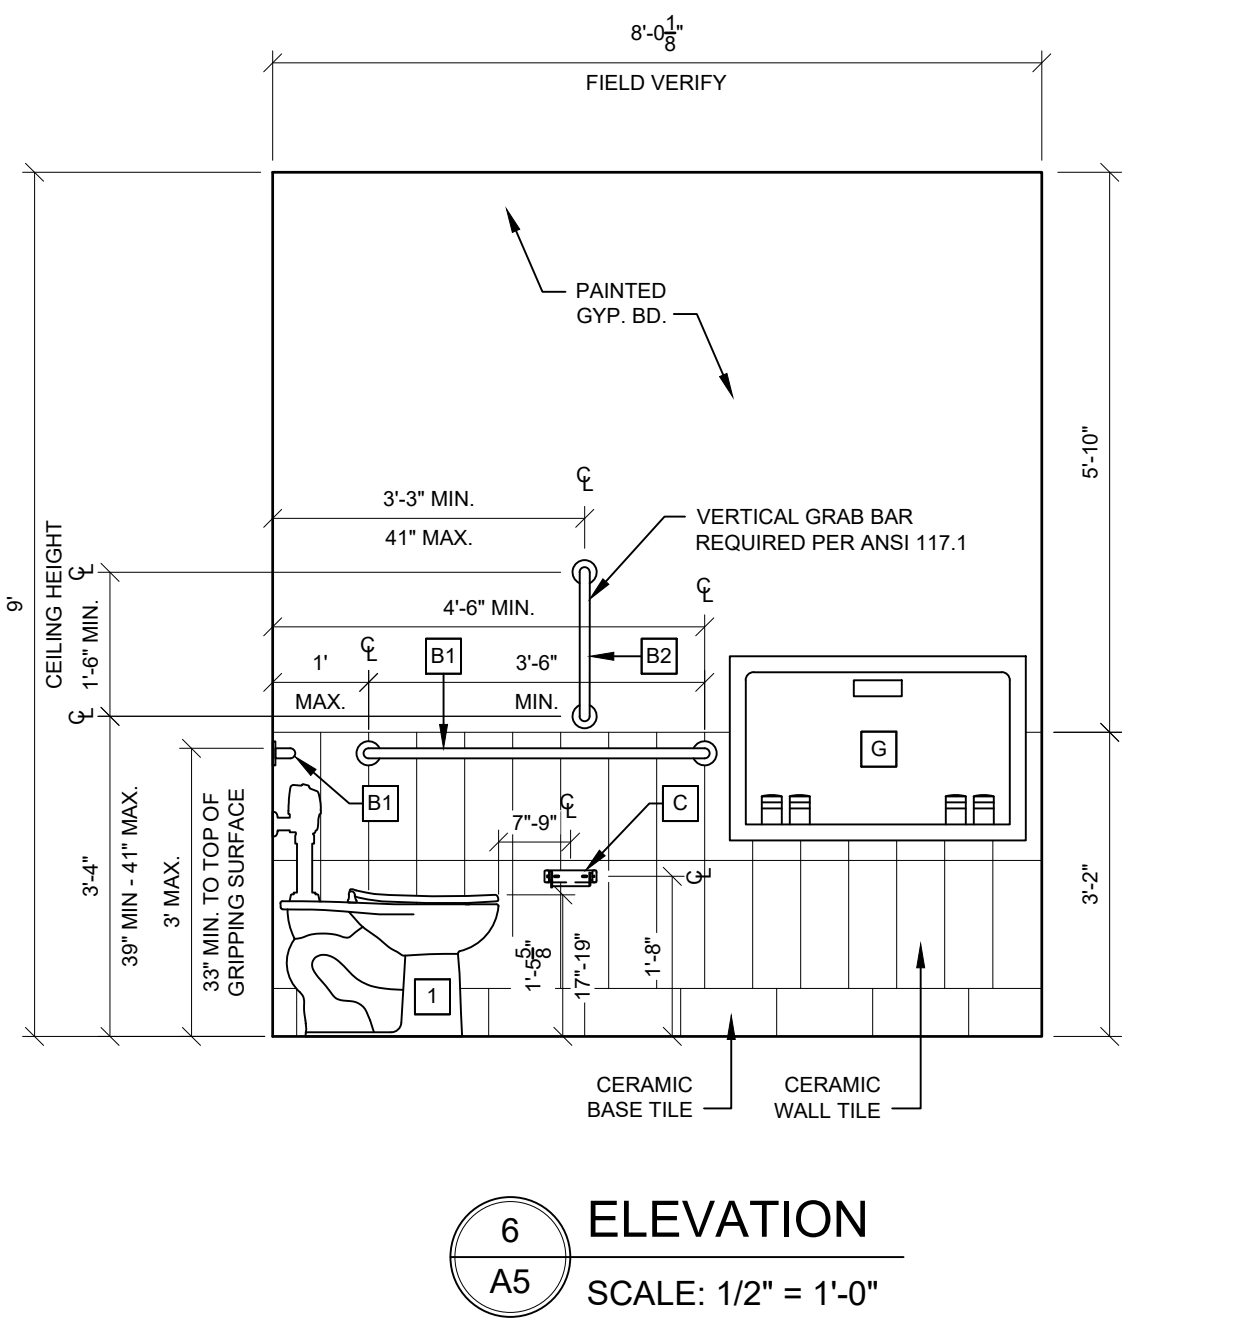


6 ELEVATION
SCALE: 1/2" = 1'-0"

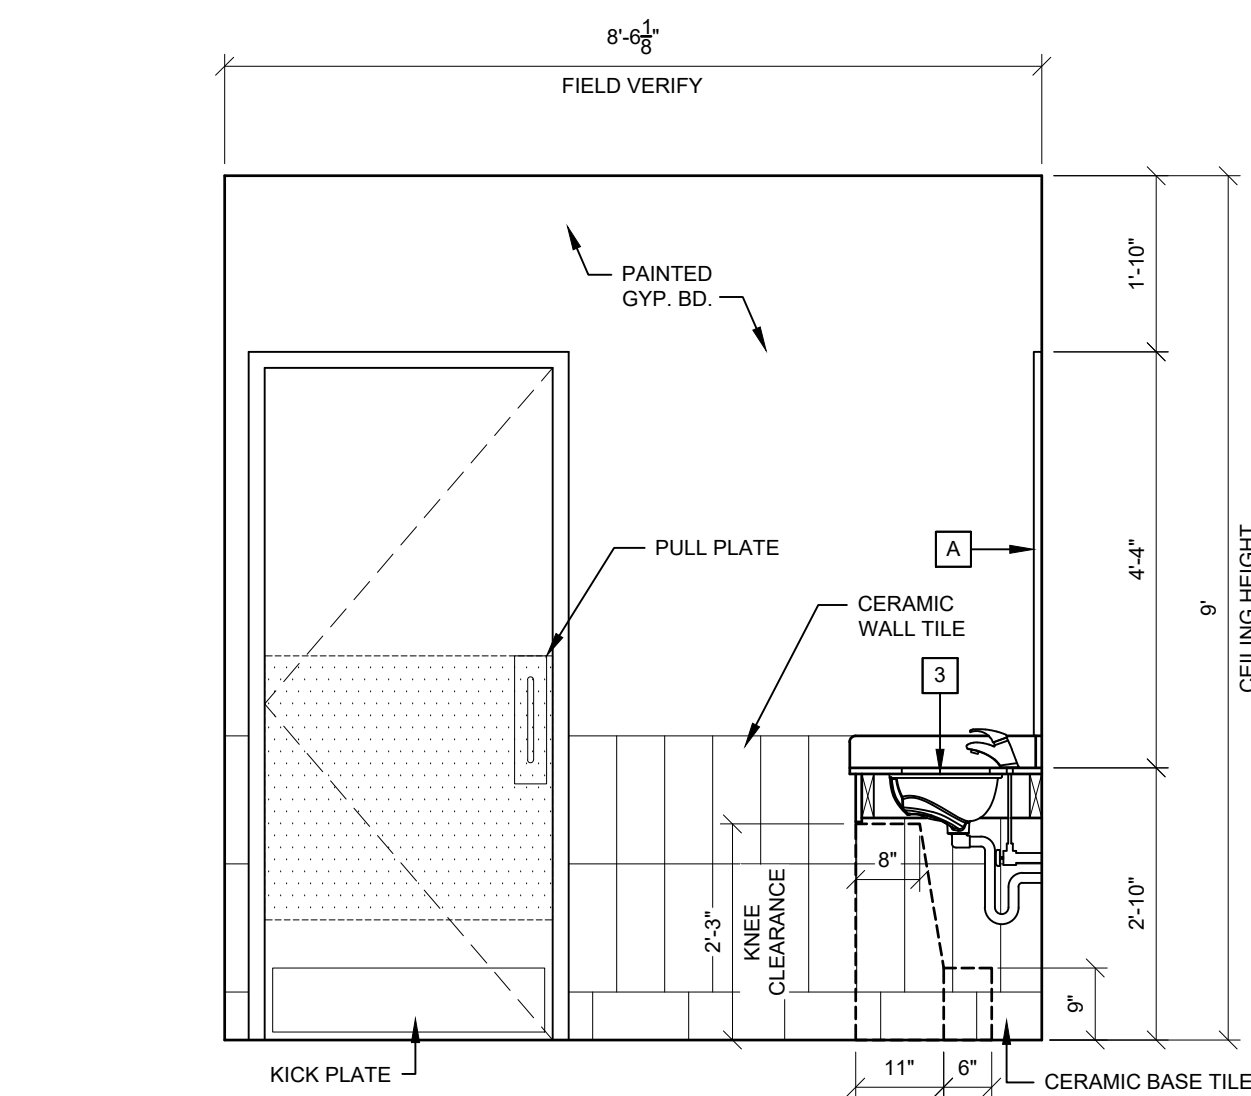


8 ELEVATION
SCALE: 1/2" = 1'-0"

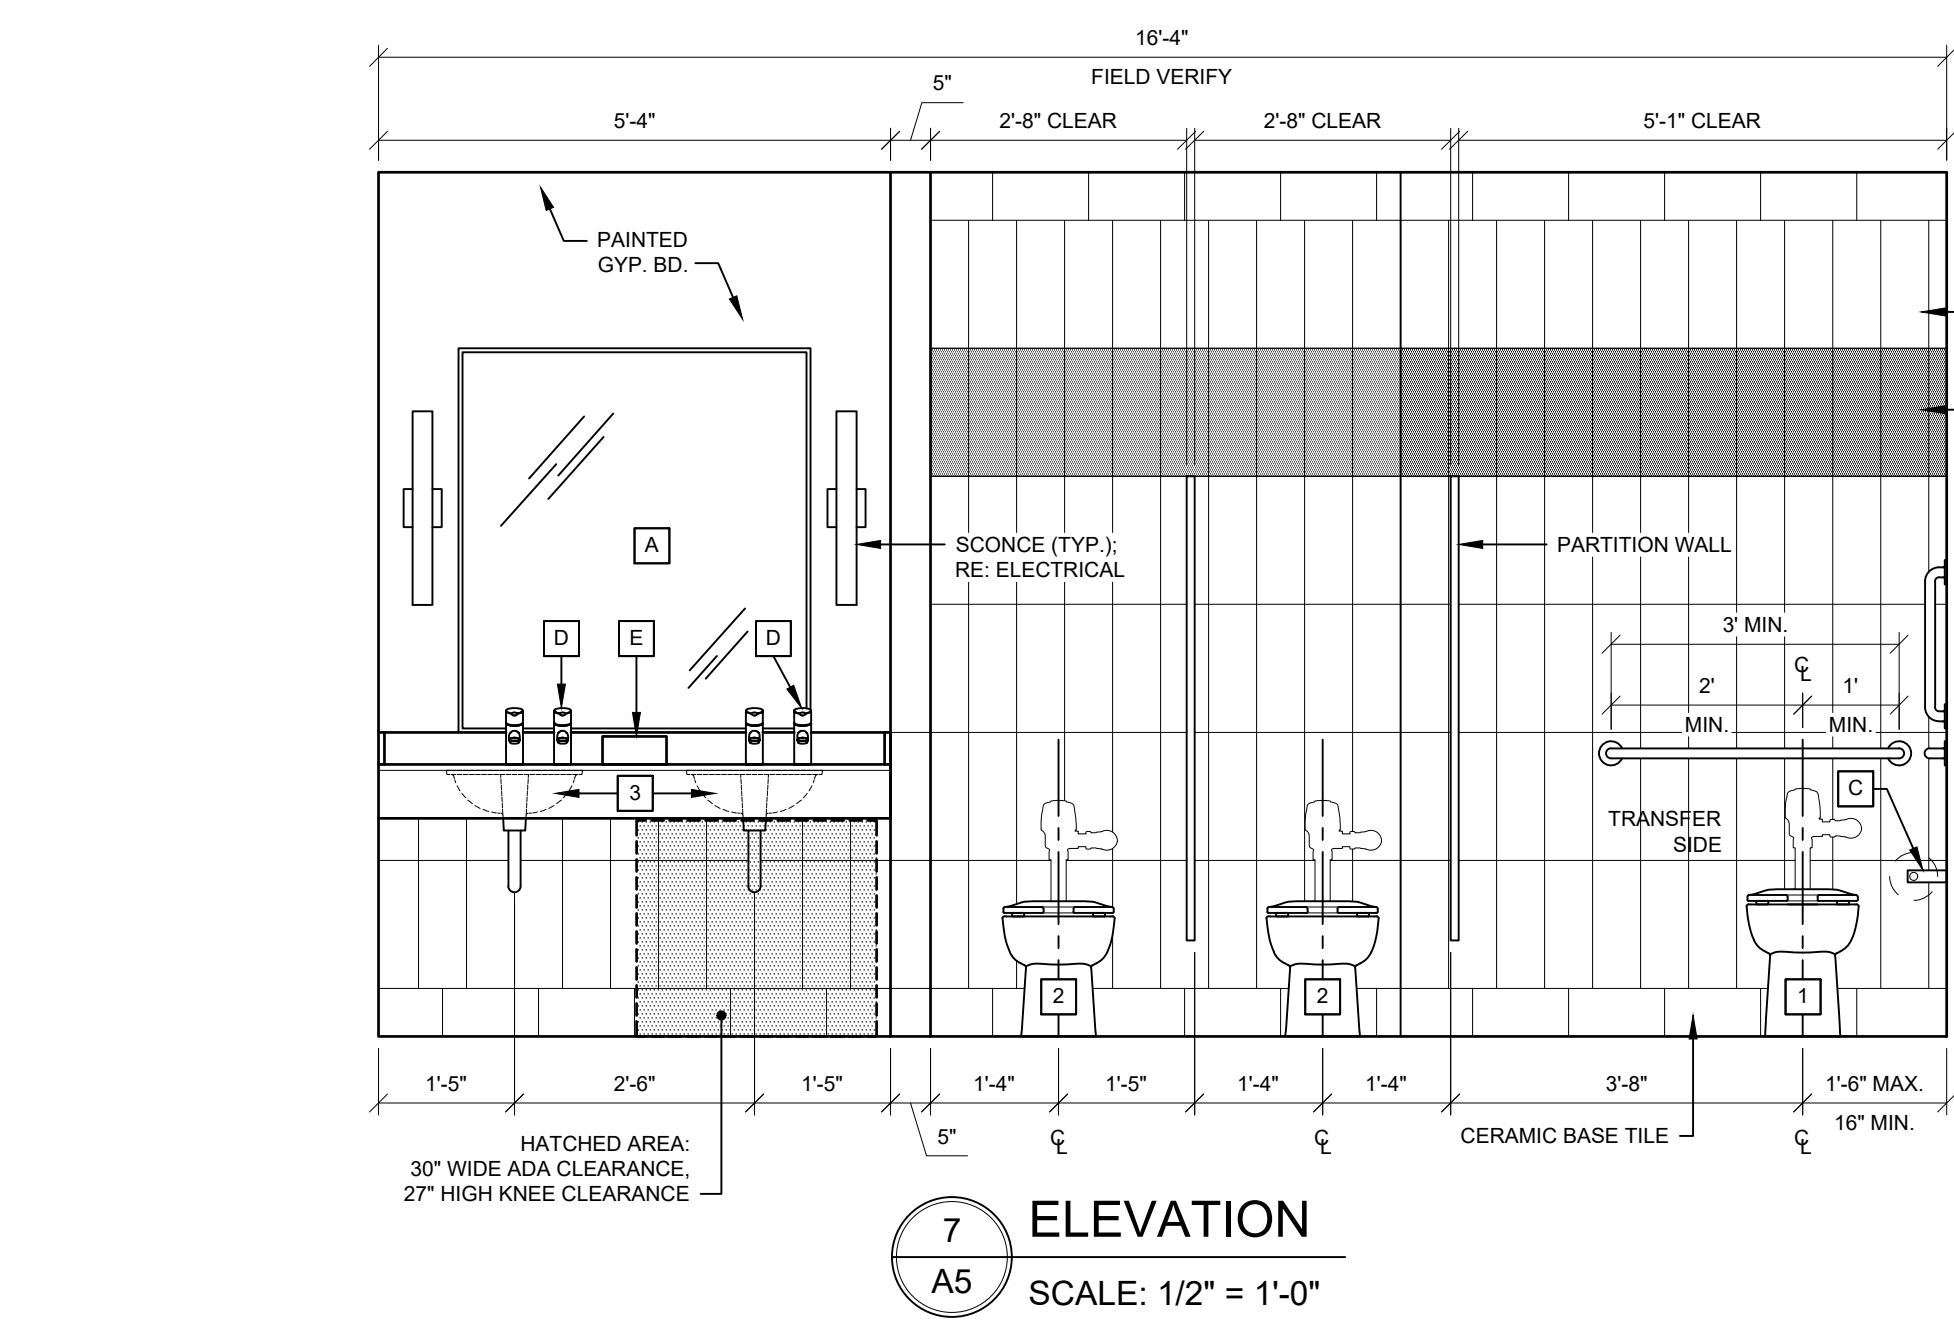

7 ELEVATION
SCALE: 1/2" = 1'-0"

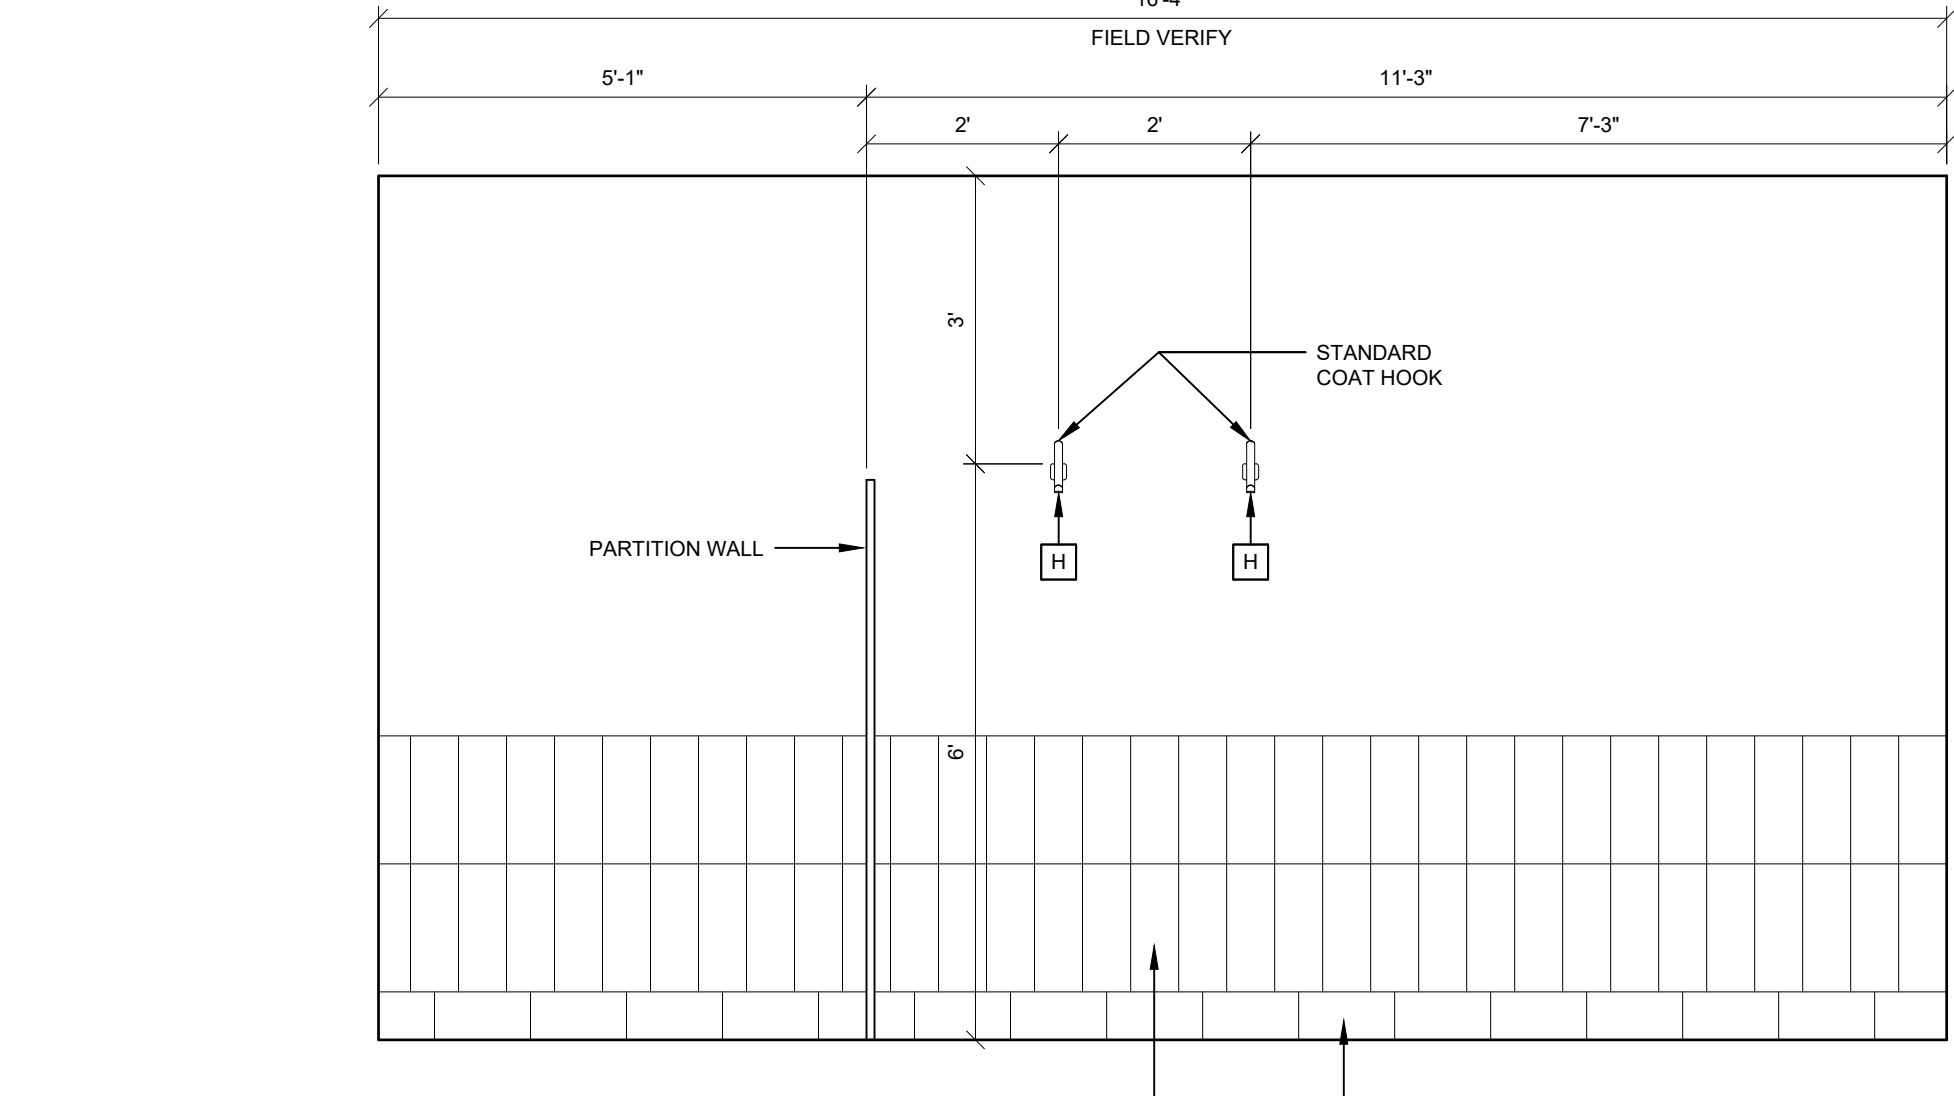

9 ELEVATION
SCALE: 1/2" = 1'-0"

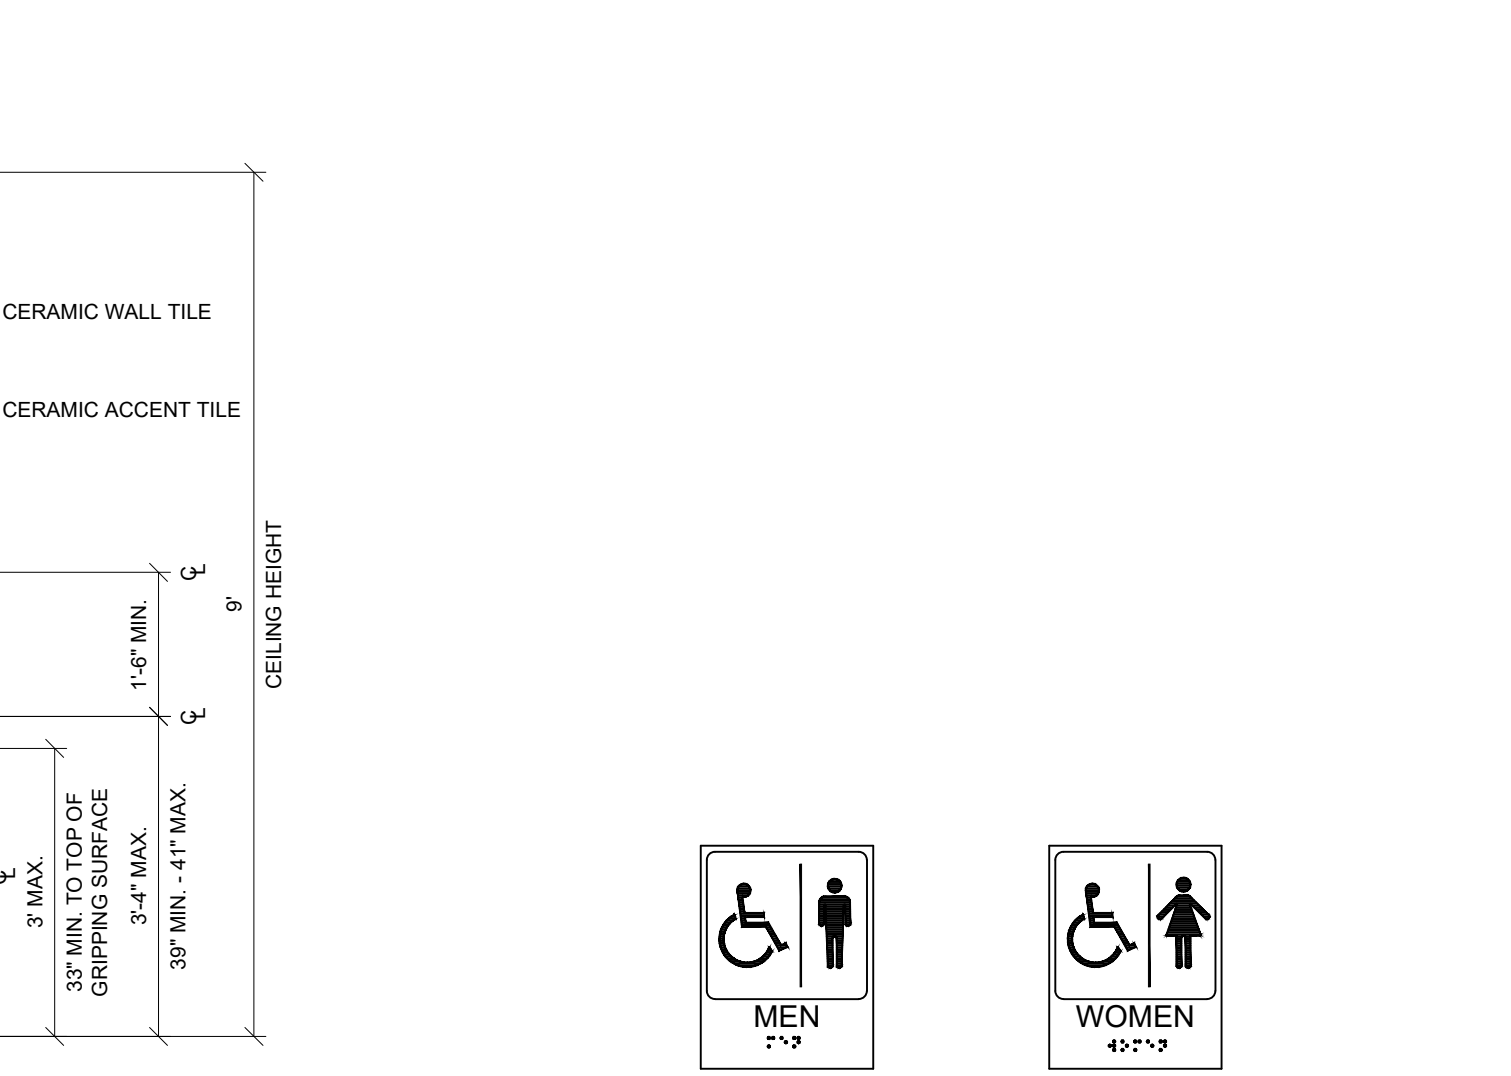

TYPICAL HANDICAP SIGNAGE


CHARACTER PROPORTION: LETTERS AND NUMBERS ON SIGNS SHALL HAVE A WIDTH-TO-HEIGHT RATIO BETWEEN 3:5 AND 1:1 AND A STROKE-TO-HEIGHT RATIO BETWEEN 1:5 AND 1:10.

RAISED AND BRAILLE CHARACTERS AND PICTORIAL SYMBOL SIGNS (PICTOGRAMS): LETTERS AND NUMBERS SHALL BE RAISED 1/32 IN.; UPPER CASE, SANS SERIF OR SIMPLE SERIF TYPE AND SHALL BE ACCOMPANIED WITH GRADE BRAILLE. RAISED CHARACTERS SHALL BE AT LEAST 5/8 IN. (16 MM) HIGH, BUT NO HIGHER THAN 2 IN. (50 MM). PICTOGRAMS SHALL BE ACCOMPANIED BY THE EQUIVALENT VERBAL DESCRIPTION PLACED DIRECTLY BELOW THE PICTOGRAM. THE BORDER DIMENSION OF THE PICTOGRAM SHALL BE 6 IN. (152 MM) MINIMUM OF HEIGHT.

FINISH AND CONTRAST: THE CHARACTERS AND BACKGROUND OF SIGNS SHALL BE EGGSHELL, MATTE, OR OTHER NON-GLOSS FINISH. CHARACTERS AND SYMBOLS SHALL CONTRAST WITH THEIR BACKGROUND EITHER LIGHT CHARACTERS ON A DARK BACKGROUND OR DARK CHARACTERS ON A LIGHT BACKGROUND.

MOUNTING LOCATION AND HEIGHT: WHERE PERMANENT IDENTIFICATION IS PROVIDED FOR ROOMS AND SPACES, SIGNS SHALL BE INSTALLED ON THE WALL ADJACENT TO THE LATCH SIDE OF THE DOOR. WHERE THERE IS NO WALL SPACE TO THE LATCH SIDE OF THE DOOR, INCLUDING AT DOUBLE LEAF DOORS, SIGNS SHALL BE PLACED ON THE NEAREST ADJACENT WALL. TACTILE CHARACTERS ON SIGNS SHALL BE LOCATED 48 INCHES (1220 MM) MINIMUM ABOVE THE FINISH FLOOR OR GROUND SURFACE. MEASURED FROM THE BASELINE OF THE LOWEST TACTILE CHARACTER AND 60 INCHES (1525 MM) MAXIMUM ABOVE THE FINISH FLOOR OR GROUND SURFACE. MEASURED FROM THE BASELINE OF THE HIGHEST TACTILE CHARACTER. MOUNTING LOCATION FOR SUCH SIGNAGE SHALL BE SO THAT A PERSON MAY APPROACH WITHIN 3 INCHES (76 MM) OF SIGNAGE WITHOUT ENCOUNTERING PROTRUDING OBJECTS OR STANDING WITHIN THE WING DOOR.

SYMBOLS OF ACCESSIBILITY: FACILITIES AND ELEMENTS REQUIRED TO BE IDENTIFIED AS ACCESSIBLE BY SECTION 4.1 OF THE ADAAG, SHALL USE THE INTERNATIONAL SYMBOL OF ACCESSIBILITY.

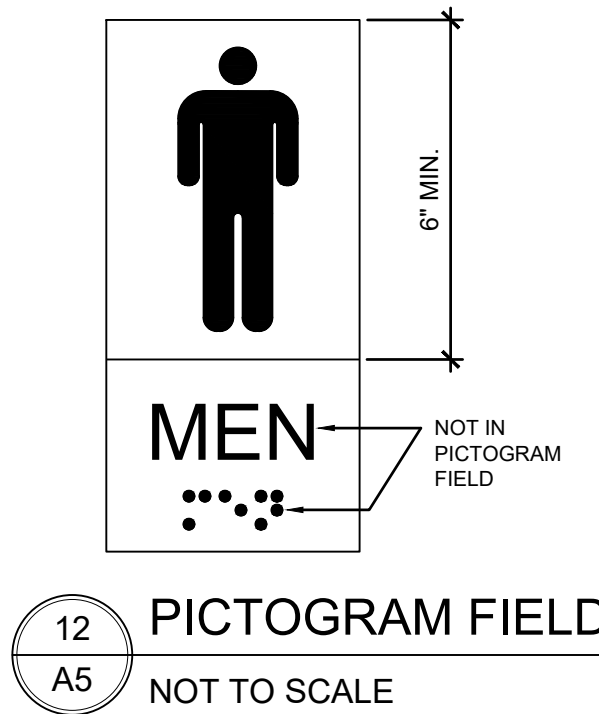

12 PICTOGRAM FIELD
NOT TO SCALE

© COPYRIGHT 2021
ZITO • RUSSELL
ARCHITECTS, P.C.

REVISIONS:	

NOT FOR
PRELIMINARY
CONSTRUCTION

ZR JOB #	4124
DATE	JUNE XX, 2021
SHEET	