
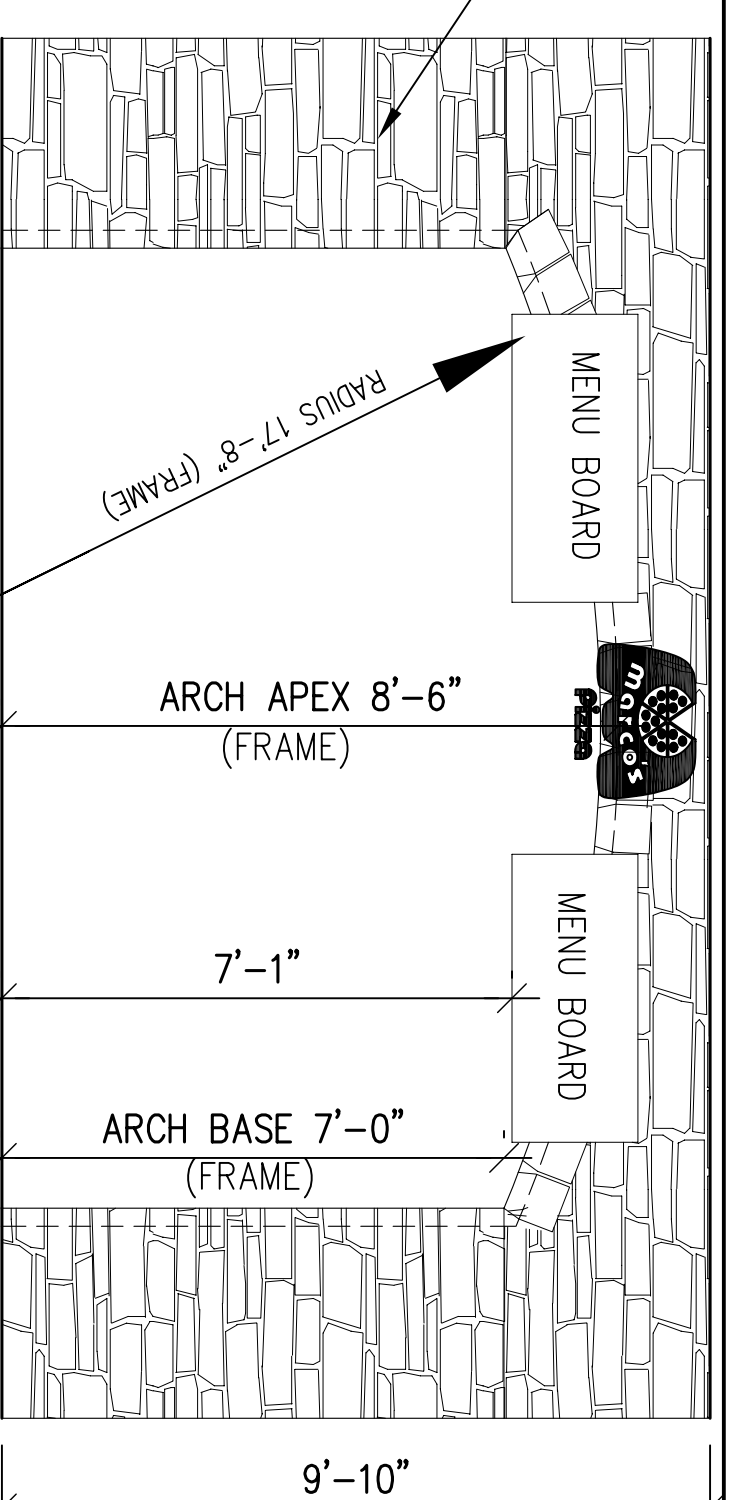



NOT APPROVED FOR CONSTRUCTION

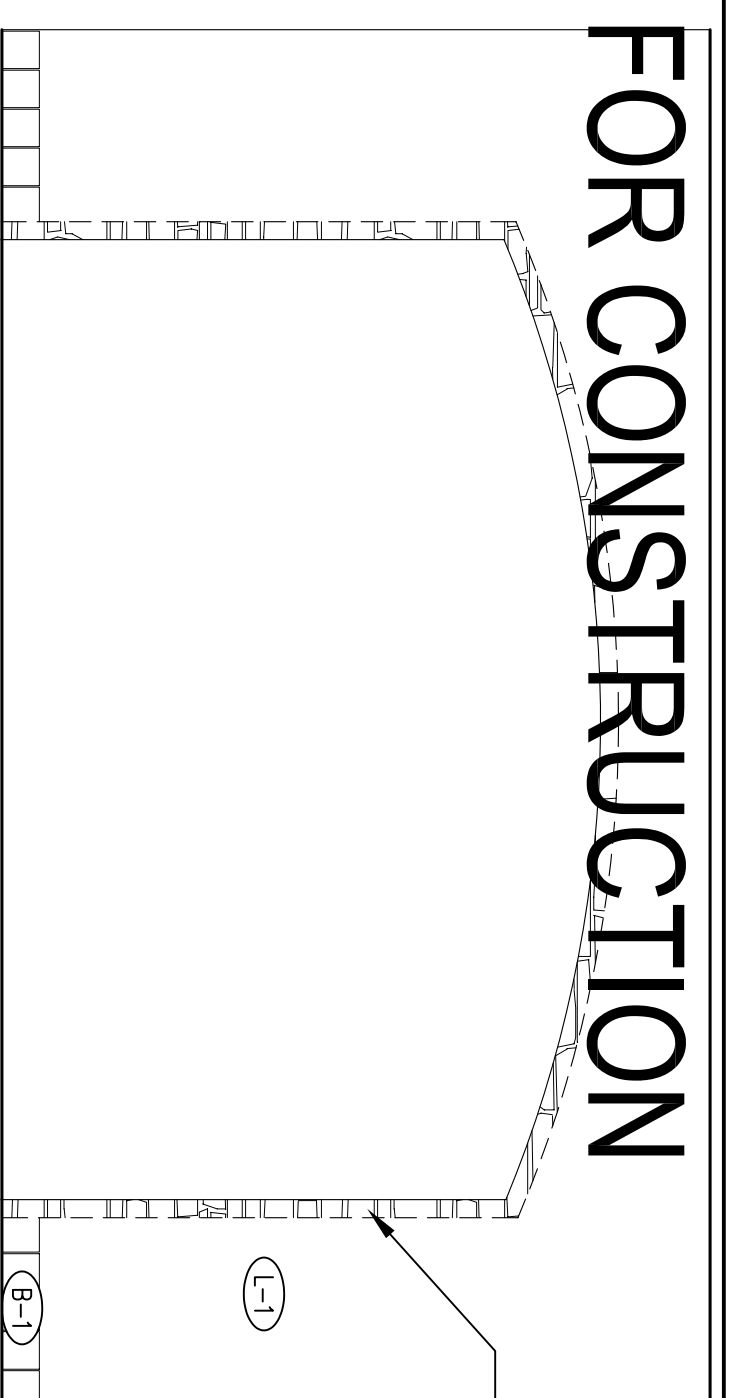


STONE VENEER WALL AND ARCH (SEAL W/HEALTH DEPARTMENT APPROVED SEALER)

VENUEER WALL  
SCALE: 3/8" = 1'-0"

ITEM #	QTY	MFG.	MODEL	DESCRIPTION	ELECTRICAL			PLUMBING												
					VOLTS	Ø RATED AMP	K.W.	H.P.	CONN.	C.W.	H.W.	WASTE	GAS	BTU/HR.						
1	1 EA.	SIBBRAND	PS303X	SCALE PERFOR. DIGITAL																
1A	1 EA.	SCOR MARK	SWP292	PIZZA PREP TABLE REFRIGERATED	120	1	8.5													
1B	1 EA.	BK RESOURCES	CUSTOM	5/8" WALL SHELF (16" X 8')																
2	1 EA.	ROMAN CABINET CO.	CUSTOM	SALES & PHONE COUNTER																
2A	1 EA.	UP	SHELVING	SALES & PHONE COUNTER SHELVING																
3	1 EA.	BK RESOURCES	VTR-3030	18 GA 5/8" WORK TABLE (30" X 30")																
4	1 EA.	TRAE	TOR-10	UPRIGHT DOOR RE-FRIGERATOR	120	1	9.0													
5	1 EA.	EAGLE GROUP	T010708-B5	18 GA 5/8" PIZZA STRETCH TABLE (20" X 30")																
5A	1 EA.	SEF, INC.	EMW148-X	18 GA 5/8" WALL SHELF (48" X 14')																
6	1 EA.	SONNEBET	QDR-500	DOOR ROLLER / SHEETER	120	1	5.0													
7	1 EA.	MIDDLEBY	PC300 WB-0	CONVEYOR OVEN - DOUBLE DECK (2 CONNECTIONS FOR GAS & ELECTRIC)	(2) 208	(2)	(2)	(2)	(2)	2.5										2"
8	1 EA.	LIKON INDUSTRIES	CHT	CONVEYOR OVEN EXHAUST SYSTEM (VERIFY W/ HOOD DRAWINGS)	208	3	2.50	0.9	1/2	DIRECT										
8A	1 EA.	LIKON INDUSTRIES	ARS-112	SUPPLY FAN (VERIFY W/ HOOD DRAWINGS)	208	3	3.70	1.3	3/4	DIRECT										
8B	2 EA.	LIKON INDUSTRIES	18096B	EXHAUST FAN (VERIFY W/ HOOD DRAWINGS)	208	3	3.70	1.3	3/4	DIRECT										
9	1 EA.	ROMAN CABINET CO.	CUSTOM	CUT TABLE BASE W/ CASTERS																
10	1 EA.	JOHN BOOS	CUSTOM	CUT TABLE BASE W/ CASTERS																
11	1 EA.	MIDWEST	CUSTOM	CUTTING TABLE OVERSHELF																
12	2 EA.	BK RESOURCES	BRS-M-1410-H	S-S HAND SINK (2 CONNECTIONS FOR GAS & ELECTRIC)																
13	1 EA.	SEF, INC.	14-CHX20-D-X	S-S ONE COMPARTMENT SINK W/ BASKET DRAIN																
13B	1 EA.	T&S BRASS	B-2030-LN	FAUCET																
14	1 EA.	MORGAN	QPH13	SAFE																
15	1 EA.	HAZCO	BR4-6033	FOOD WARMER (GAS & PLUG BY OWNER)	120	1	12.3	2.1												
16	1 EA.	SHIMAN M&M	CUSTOM	WALK-IN COOLER (VERIFY W/ WALK-IN DRAWINGS)																
16A	1 EA.	SHIMAN M&M	CUSTOM	CONDENSER (VERIFY W/ WALK-IN DRAWINGS)	208	1														
17	1 EA.	BK RESOURCES	BRS-3-420-12-81	THREE COMPARTMENT SINK																
17A	3 EA.	BK RESOURCES	CUSTOM	BASKET DRAIN / LEVER W/ST WASTE																2"
17B	1 EA.	T&S BRASS OR =	B-0133	PRE RINSE ASSEMBLY																
17C	1 EA.	T&S BRASS OR =	P-660	60 QUART WARMER																
18	1 EA.	401 T&BEO	VES-307	14 GA 5/8" WORK TABLE (64" X 30")	208	3	8.6	3.1	2.5	DIRECT										
18A	1 EA.	REBUD	NS2500N-6	EAST SIDEEN MANUAL																
19A	1 EA.	EDUMD	TS	MANUAL OMI FREEZER W/ CASTERS																
20	1 EA.	ARTIC AIR	F220W	REACH-IN FREEZER W/ CASTERS	120	1	15	1.8	1/3	PLUG										
21	1 EA.			GREASE INTERCEPTOR																
21A				OPEN																
22	5 EA.	CANORO	DMS40-480	DUNNAGE RACKS																
22A	2 EA.	NATIONAL CART	KAP2448290	HEAVY DUTY ALUMINUM DUNNAGE RACK																
22B	2 EA.	NATIONAL CART	ALD92407290	HEAVY DUTY ALUMINUM DUNNAGE RACK																
23	2 EA.	SEF, INC.	UG18180-X	WIRE SHELVING W/ CASTERS																
24	1 EA.	HIDDES OR =	EXOXY	12" X 42" WALL SHELVING (W/ER SHELF)																
24A	2 EA.	HIDDES OR =	EXOXY	14" X 42" WALL SHELVING (2 COMP. SINK SHELF)																
25	1 EA.	METRO OR =	CUSTOM	ROLLING TABLE W/ CASTERS																
25A	1 EA.		CUSTOM	OVERHEAD FOOD WARMER																
26	2 EA.	SEF, INC.	CUSTOM	WALK-IN SHELVING W/ CASTERS																
27	2 EA.	LARGENS	5 LB	WALL MOUNT DRY CHEMICAL FIRE EXTINGUISHER PER LOCAL CODE (BY OWNER)																
28	1 EA.	TRUE	ICW-3358L-44	MERCHANTS REFRIGERATOR	120	1	7.8	0.8	1/3	PLUG										
29	1 EA.	HOWARD CO		MENU BOARD																
30	1 EA.	BY OTHERS		POS CASH REGISTER STATION (VERIFY MECHANICALS W/ OWNER)	120	1														
30A	1 EA.	BY OTHERS		POS CASH REGISTER PRINTER (VERIFY MECHANICALS W/ OWNER)	120	1														
31	1 EA.	BY PC.		MOS SINK (INSTALLED BY G.C./VERIFY MECHANICALS W/ OWNER)																
32	0 EA.	BY OTHERS		BOTTLED WATER DISPENSER-BY OTHERS																
33	2 EA.	BY OTHERS		TANKLESS WATER HEATER																
34	1 EA.	BY PC		PIZZA BAG WARMING SYSTEM																
35	1 EA.	BY OTHERS		BEVERAGE STATION																
36	6 EA.	WAYVAG		FOUR TOP TABLE AND CHAIRS																
36A	2 EA.	WAYVAG		TWO TOP TABLE AND CHAIRS																
36B	2 EA.	WAYVAG		4 PERSON BOOTH																
37	2 EA.	CAS/ORK		WIRE SHELVING																
38	2 EA.	BY OTHERS		WINE SHELVING																
39	1 EA.	BY OTHERS		WAITING BENCH																
41	1 EA.	BY OTHERS		POS ORDER STATION #1 (VERIFY MECHANICALS W/ OWNER)	120	1														
41A	1 EA.	BY OTHERS		POS ORDER STATION #2 (VERIFY MECHANICALS W/ OWNER)	120	1														
41B	1 EA.	BY OTHERS		POS ORDER STATION #3 (VERIFY MECHANICALS W/ OWNER)	120	1														
42	0 EA.	BY OTHERS		POS FULL PAGE PRINTER (VERIFY MECHANICALS W/ OWNER)	120	1														
43	1 EA.	BY OTHERS		POS PRINTER (A1 CUT TABLE) (VERIFY MECHANICALS W/ OWNER)	120	1														
44	1 EA.	BY OTHERS		POS STRETCH MONITOR #1 (VERIFY MECHANICALS W/ OWNER)	120	1														
45	1 EA.	BY OTHERS		POS DRIVER STATION #1 (VERIFY MECHANICALS W/ OWNER)	120	1														
46	1 EA.	BY OTHERS		POS PRINTER (A1 DRIVER STATION) (VERIFY MECHANICALS W/ OWNER)	120	1														
47	1 EA.	BY OTHERS		PHONE OFFICE STATION (VERIFY MECHANICALS W/ OWNER)	120	1														
48	1 EA.	BY OTHERS		WALL MOUNTED LOCKABLE CABINET																
49	1 EA.	ROMAN CABINET CO.	CUSTOM	COUNTER TOP DISK																

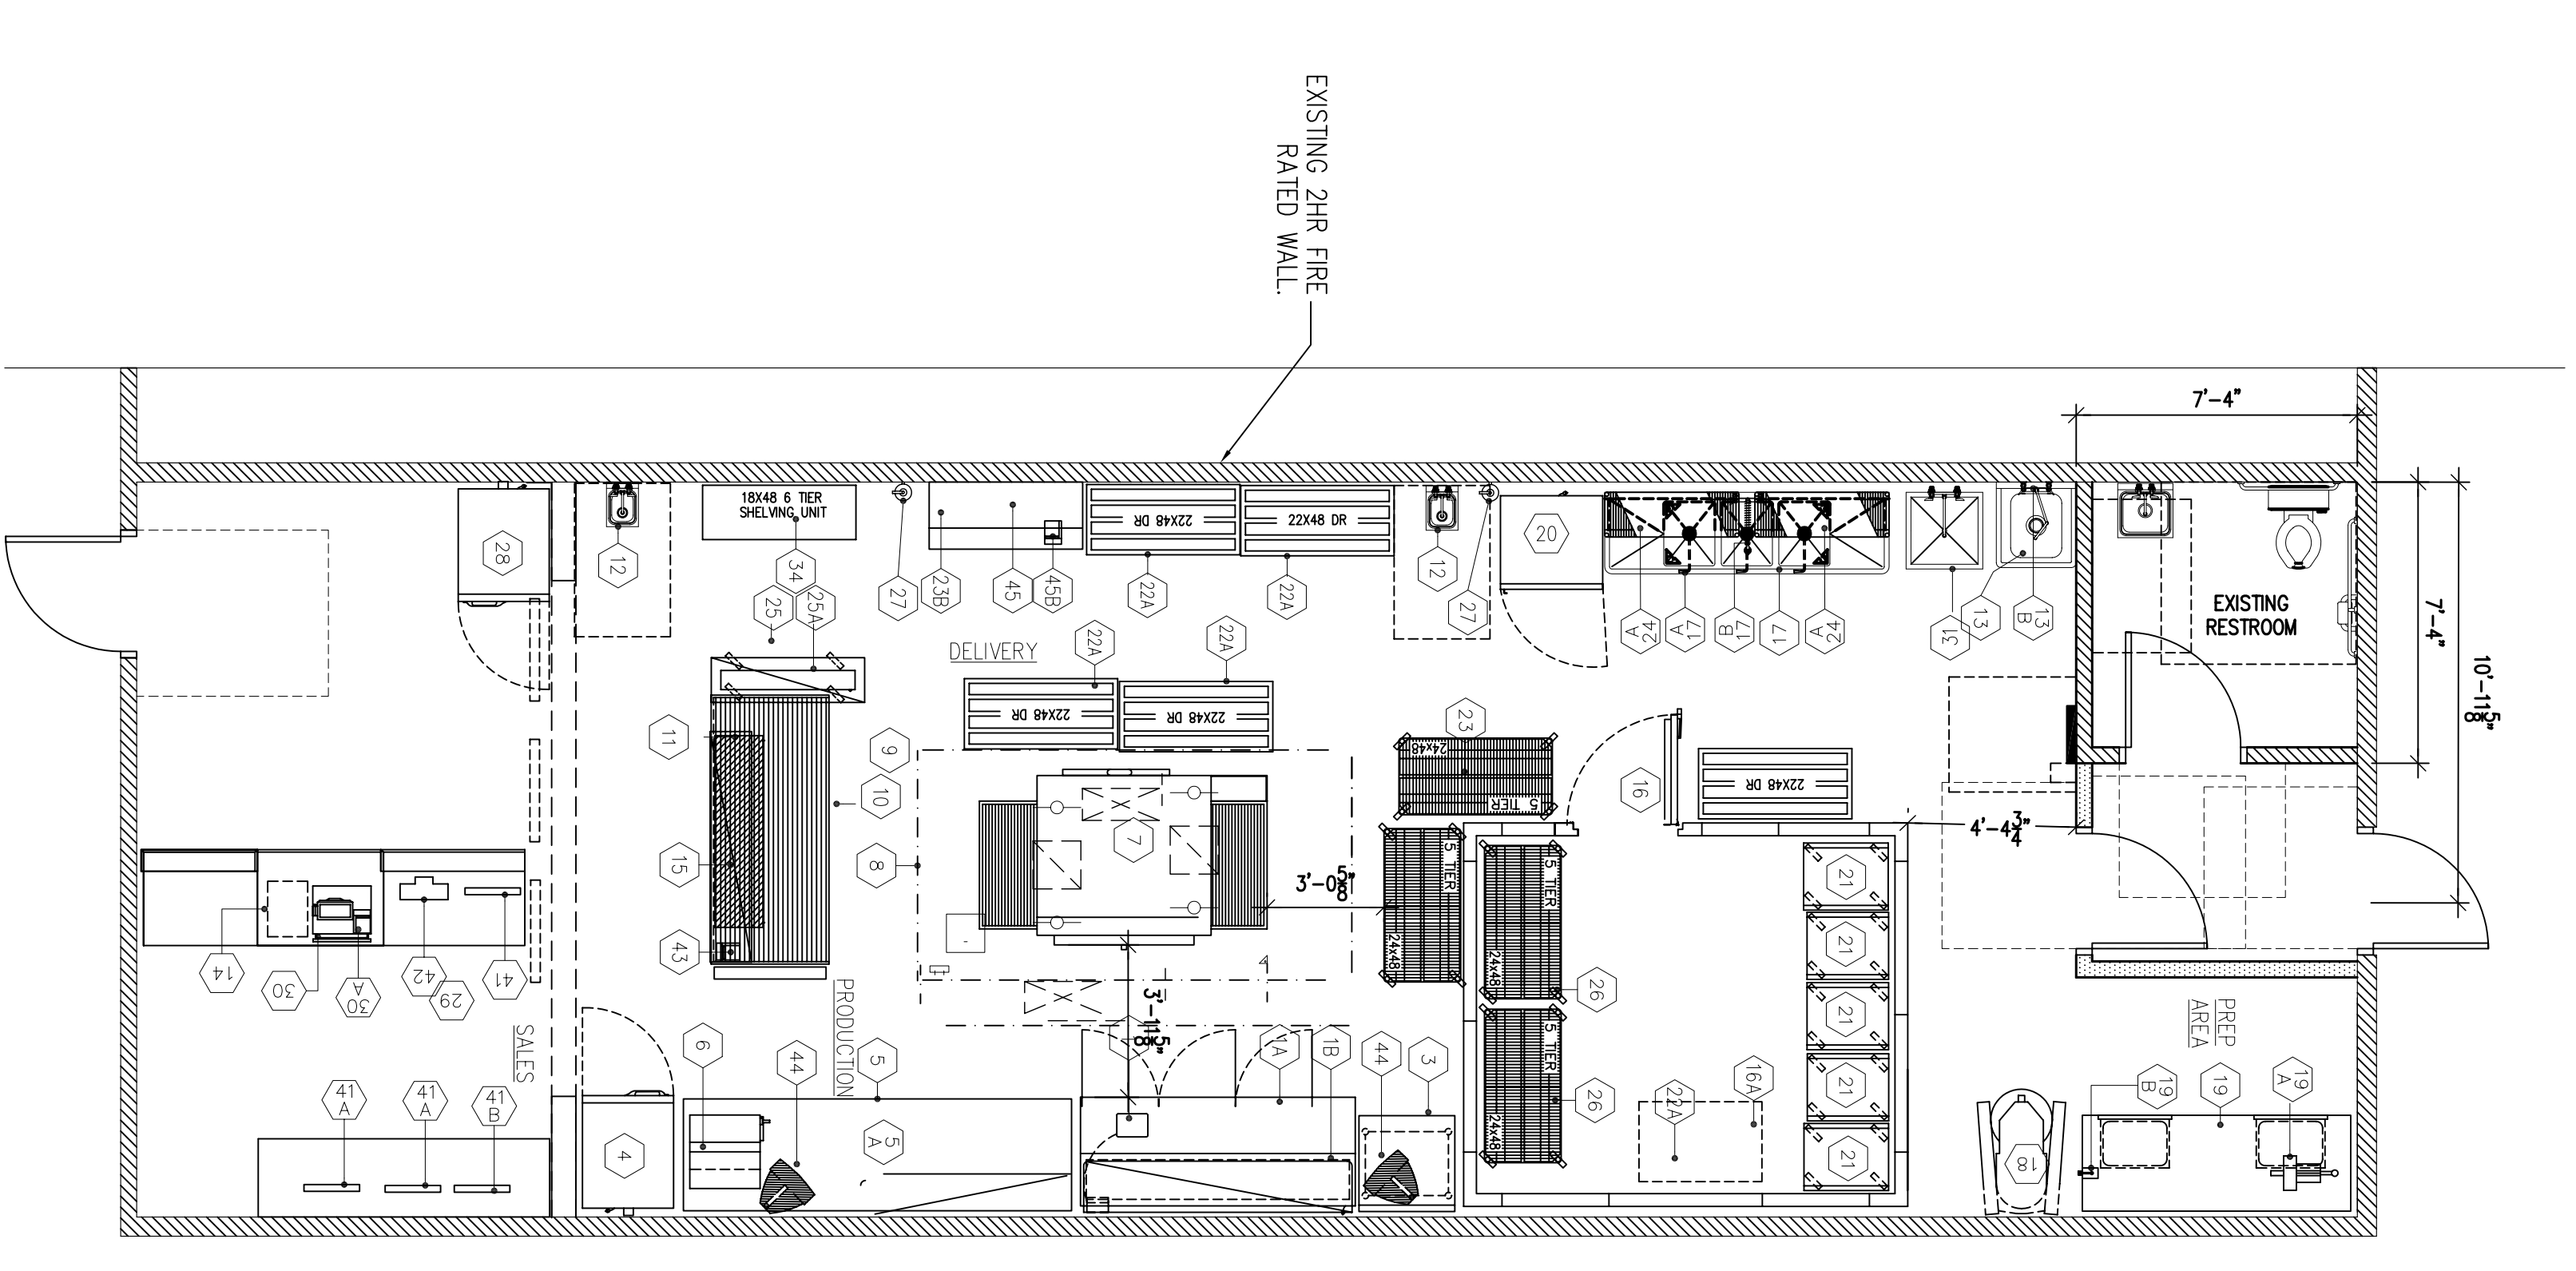

FLOOR PLAN  
SCALE: 1/4" = 1'-0"

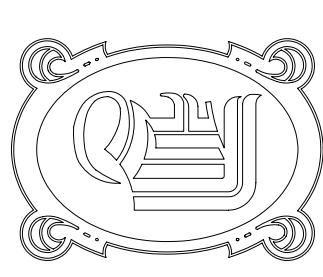

**DAMMON ENGINEERING, INC.**  
EMMETT DAMMON

ARCHITECT  
ROBERT WILTSE

1095 FLORIDA AVENUE  
SLIDELL, LA. 70458  
985-649-5832

WEBSITE:  
WWW.DAMMONENGINEERING.COM  
EMAIL:  
DAMMONENG@BELLSOUTH.NET

ARCHITECTURE  
ENGINEERING  
STUDIES  
PLANNING  
INVESTIGATION  
EXPERT WITNESS

MARCO'S PIZZA  
TENANT BUILDOUT

2349 E. GAUSE BLVD  
SLIDELL, LA  
70458

EQUIPMENT PLAN

SCALE: AS NOTED  
JOB#: 2082  
DATE: 11-1-10  
SHEET 3

A-2

OF 10

NOTE: ARCHITECT/CONTRACTOR TO CALCULATE RATED LOADS & SIZE REQUIRED FOR SERVICE AND PROTECTIVE DEVICES.  
NOT APPROVED FOR CONSTRUCTION