


LEGEND	
	SOIL & WASTE PIPING
	VENT PIPING
	GREASE LINE PIPING
	COLD WATER PIPING
	HOT WATER PIPING
	HOT WATER RETURN PIPING
	BALL VALVE
	VALVE IN C.I. BOXES/SPECS
	CHECK VALVE
	CLEANOUT
	FREEZE PROOF WALL HYDRANT
	VENT THRU ROOF
	FWM
	CO
	HW
	V
	R
	VTR

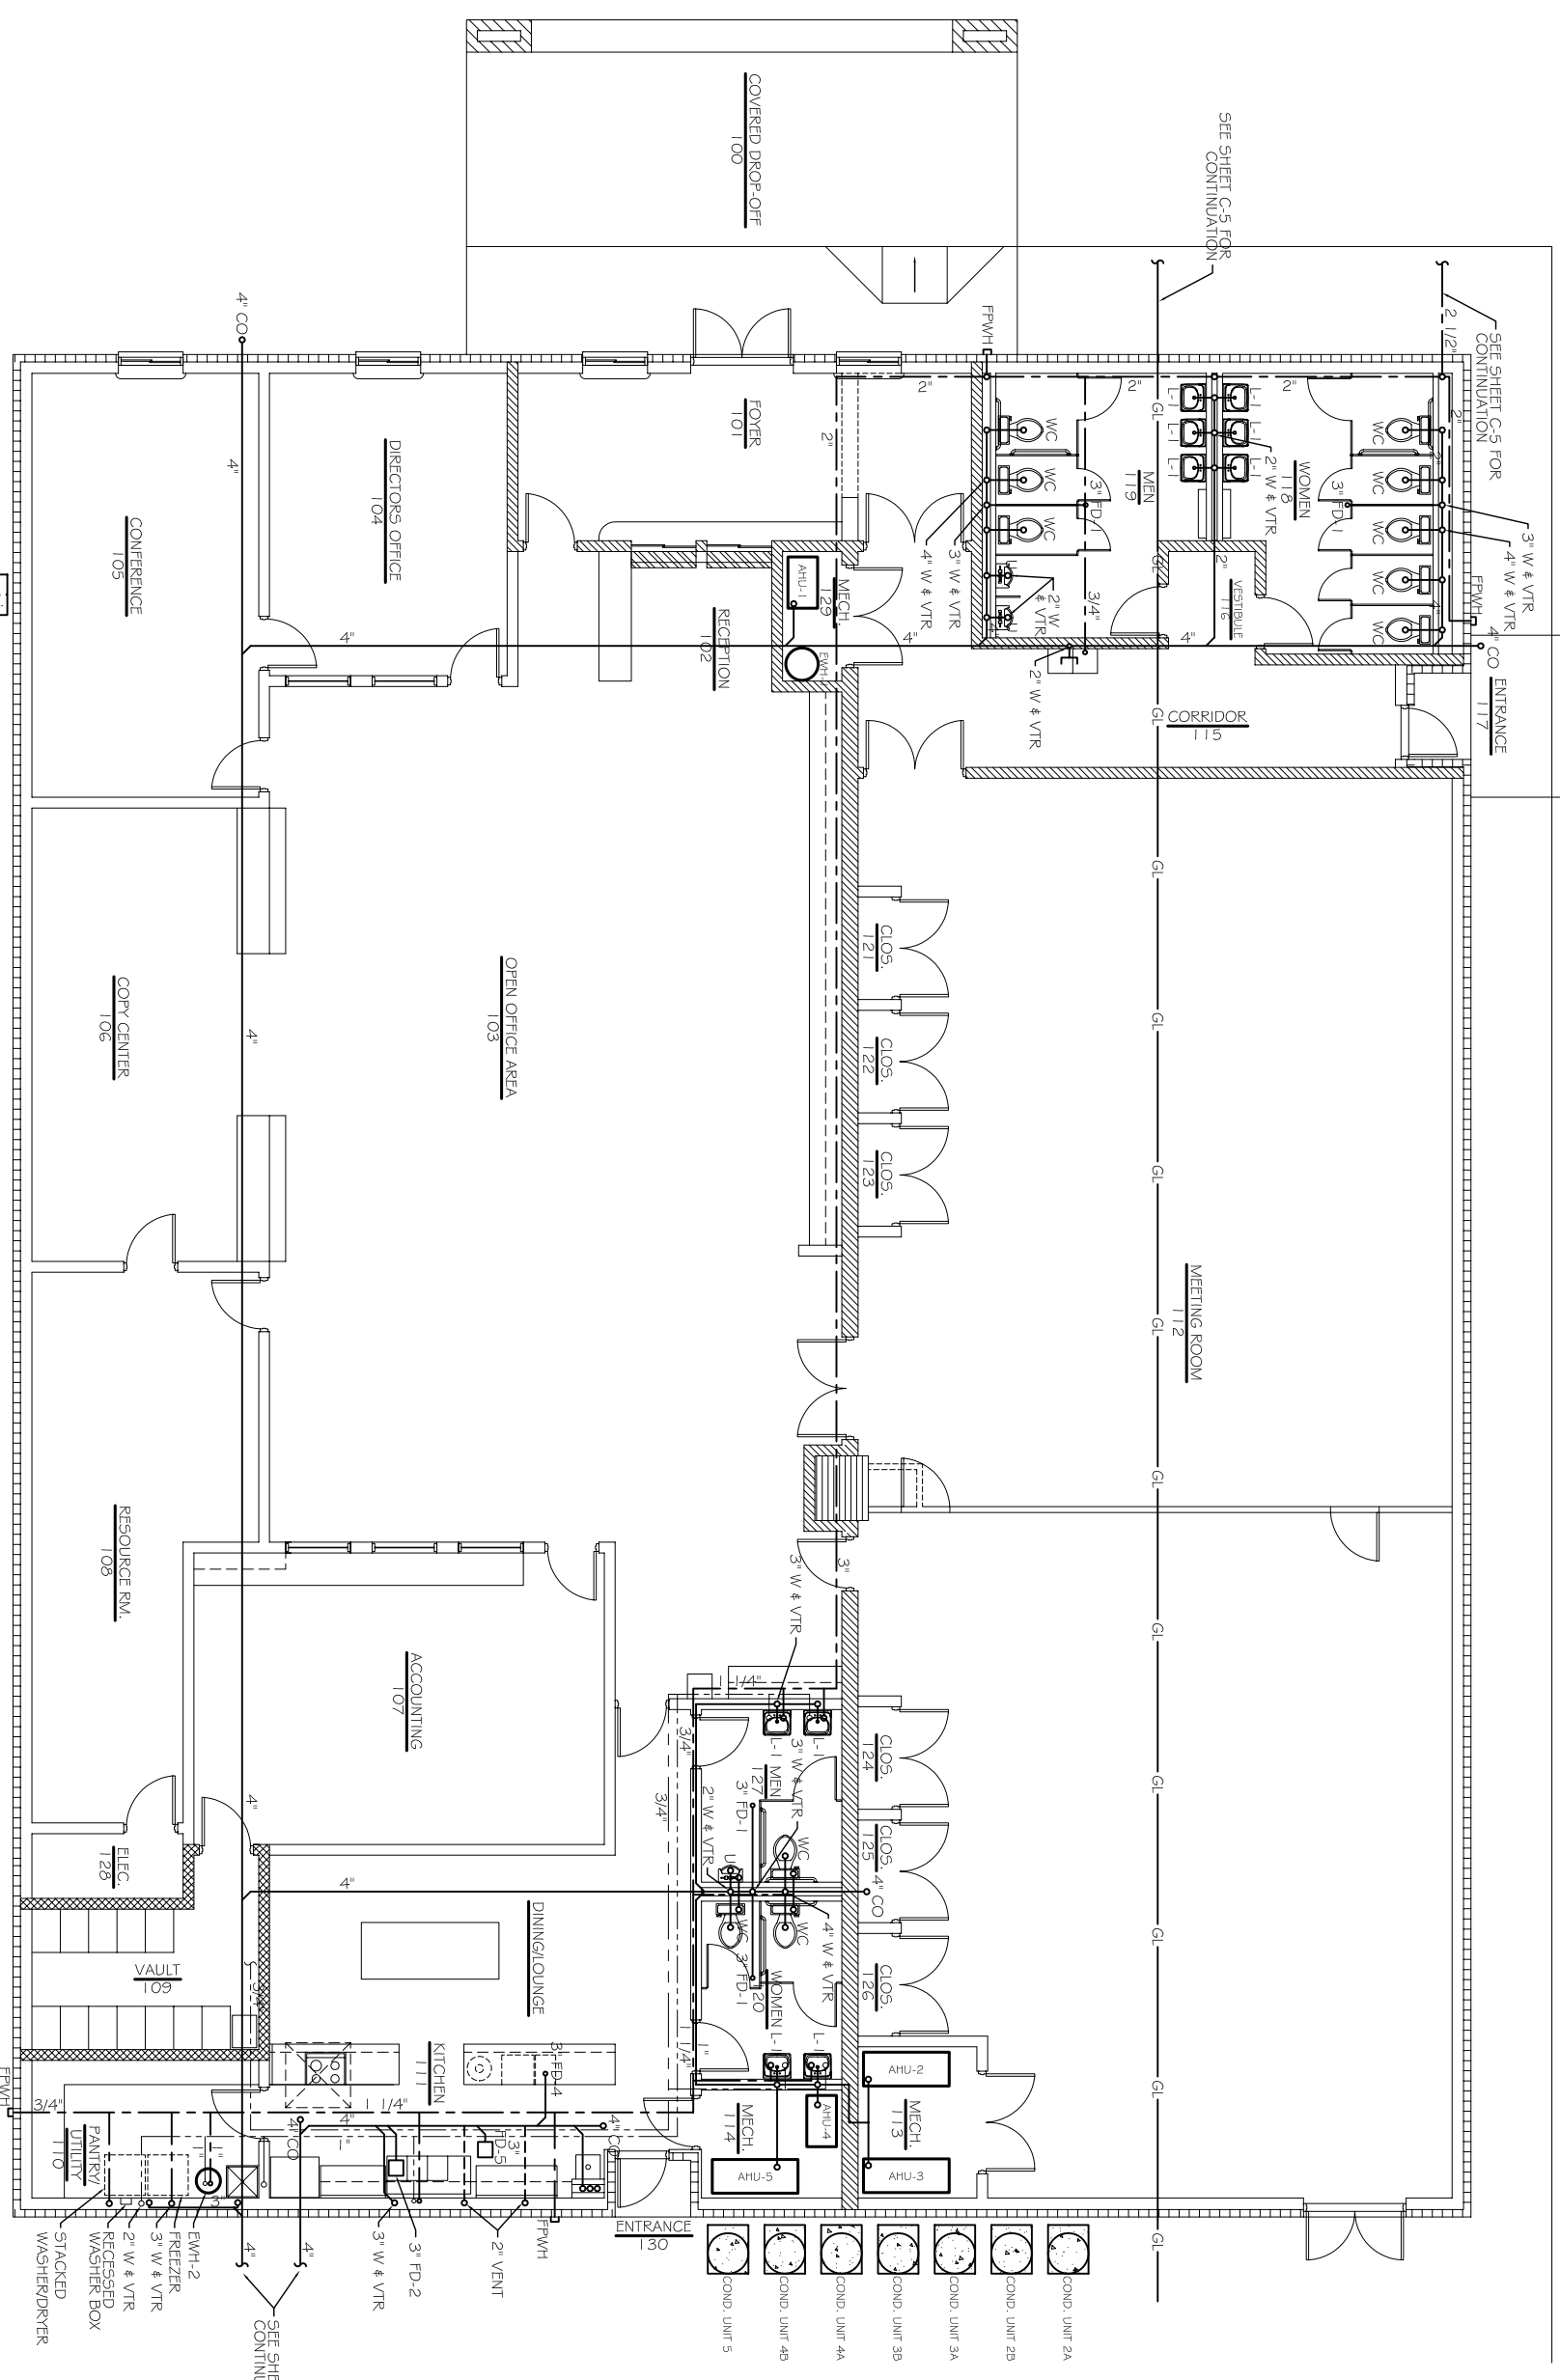

DAMMON
ENGINEERING, INC.

CHIEF ENGINEER
EMMETT
DAMMON, P.E.

CHIEF ARCHITECT
ROBERT
WILTSE

1095 FLORIDA AVENUE
SLIDELL, LA. 70458
OFFICE: 985-649-5832
FAX: 985-641-5950

WEBSITE:
WWW.DAMMONENGINEERING.COM

EMAIL:
DAMMONENR@BLSOUTH.NET

ARCHITECTURE
ENGINEERING
STUDIES
PLANNING
INVESTIGATION
EXPERT WITNESS

CHILD DEVELOPMENT
COUNCIL OF
ACADIANA, INC.
OPELOUSAS, LA

PLUMBING
PLAN

REV:	
SCALE: AS NOTED	
JOB#: 2030	
DATE: 7-13-09	
SHEET	P-2

PLUMBING PLAN
SCALE: 3/16"=1'-0"

