

**DAMMON**  
ENGINEERING, INC.

CHIEF ENGINEER  
EMMETT  
DAMMON, P.E.

CHIEF ARCHITECT  
ROBERT  
WILTSE

1095 FLORIDA AVENUE  
SLIDELL, LA. 70458  
OFFICE: 985-649-5832  
FAX: 985-641-5950

WEBSITE:  
WWW.DAMMONENGINEERING.COM

EMAIL:  
DAMMONENG@BLSOUTH.NET

ARCHITECTURE  
ENGINEERING  
STUDIES  
PLANNING  
INVESTIGATION  
EXPERT WITNESS

NEW OFFICE  
COMPLEX

CHILD DEVELOPMENT  
COUNCIL OF  
ACADIANA, INC.  
OPELOUSAS, LA

PLUMBING  
PLAN

REV: 12-7-09 CONST.

SCALE: AS NOTED

JOB#: 2030


DATE: 10-19-09

SHEET 26

P-2

OF 26

LEGEND	
	SOIL & WASTE PIPING
	VENT PIPING
	GREASE LINE PIPING
	COLD WATER PIPING
	HOT WATER PIPING
	HOT WATER RETURN PIPING
	BALL VALVE
	VALVE IN C.I. BOXES/SPECS
	CHECK VALVE
	CLEANOUT
	FREEZE PROOF WALL HYDRANT
	VENT THRU ROOF
	FWMH
	VENT
	VTR

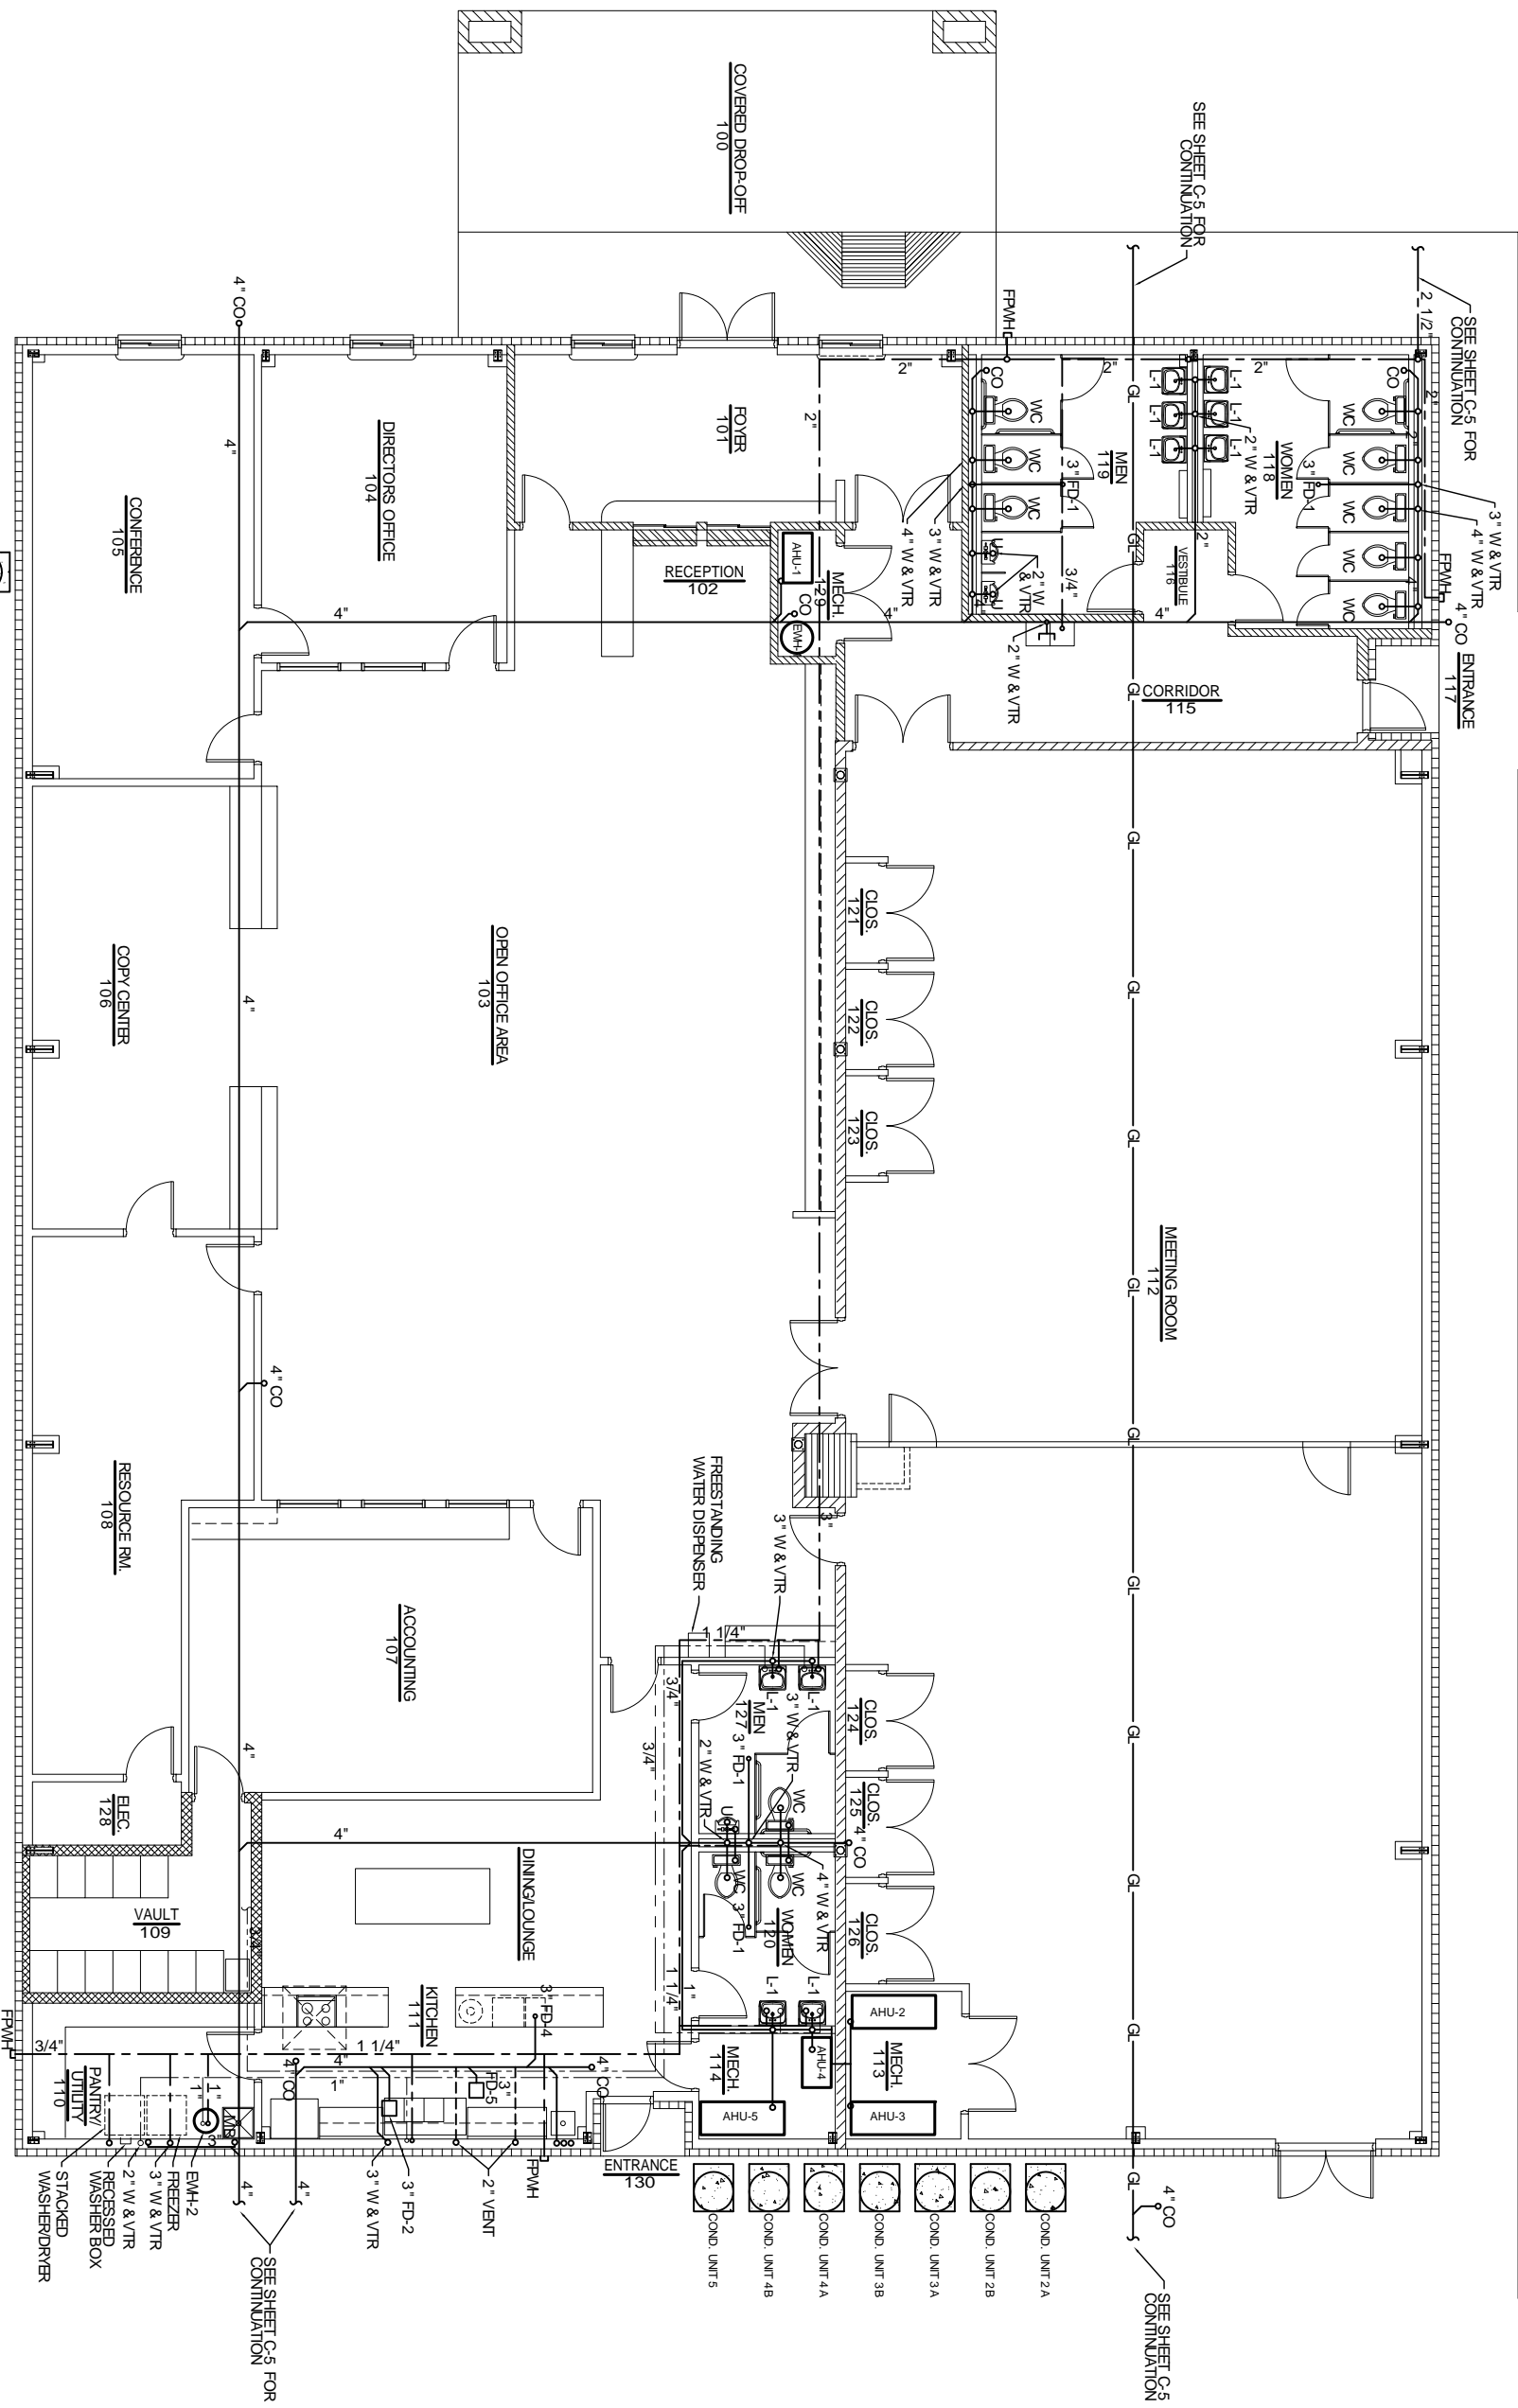

PLUMBING PLAN  
SCALE 3/16" = 1'-0"

