


- LEGEND**
- 1 HR. RATED CONST. (UL...)
 - ROLLING FIRE SHUTTER
 - VAULT CONSTRUCTION

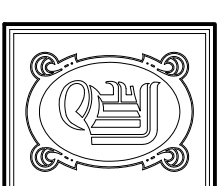

DAMMON
ENGINEERING, INC.

CHIEF ENGINEER
EMMETT
DAMMON, P.E.

CHIEF ARCHITECT
ROBERT
WILTSE

1095 FLORIDA AVENUE
SUITE 100
SUDBELL, LA. 70458
OFFICE: 985-649-5832
FAX: 985-641-5950

WWW.DAMMONENGINEERING.COM
EMAIL: DAMMONENG@BELL-SOUTH.NET

ARCHITECTURE
ENGINEERING
STUDIES
PLANNING
INVESTIGATION
EXPERT WITNESS


NEW OFFICE
COMPLEX

CHILD DEVELOPMENT
COUNCIL OF
ACADIANA, INC.
OPEROUSAS, LA

FLOOR
PLAN

REV:
SCALE AS NOTED
JOB#: 2030
DATE: 5-18-09
SHEET

A-1

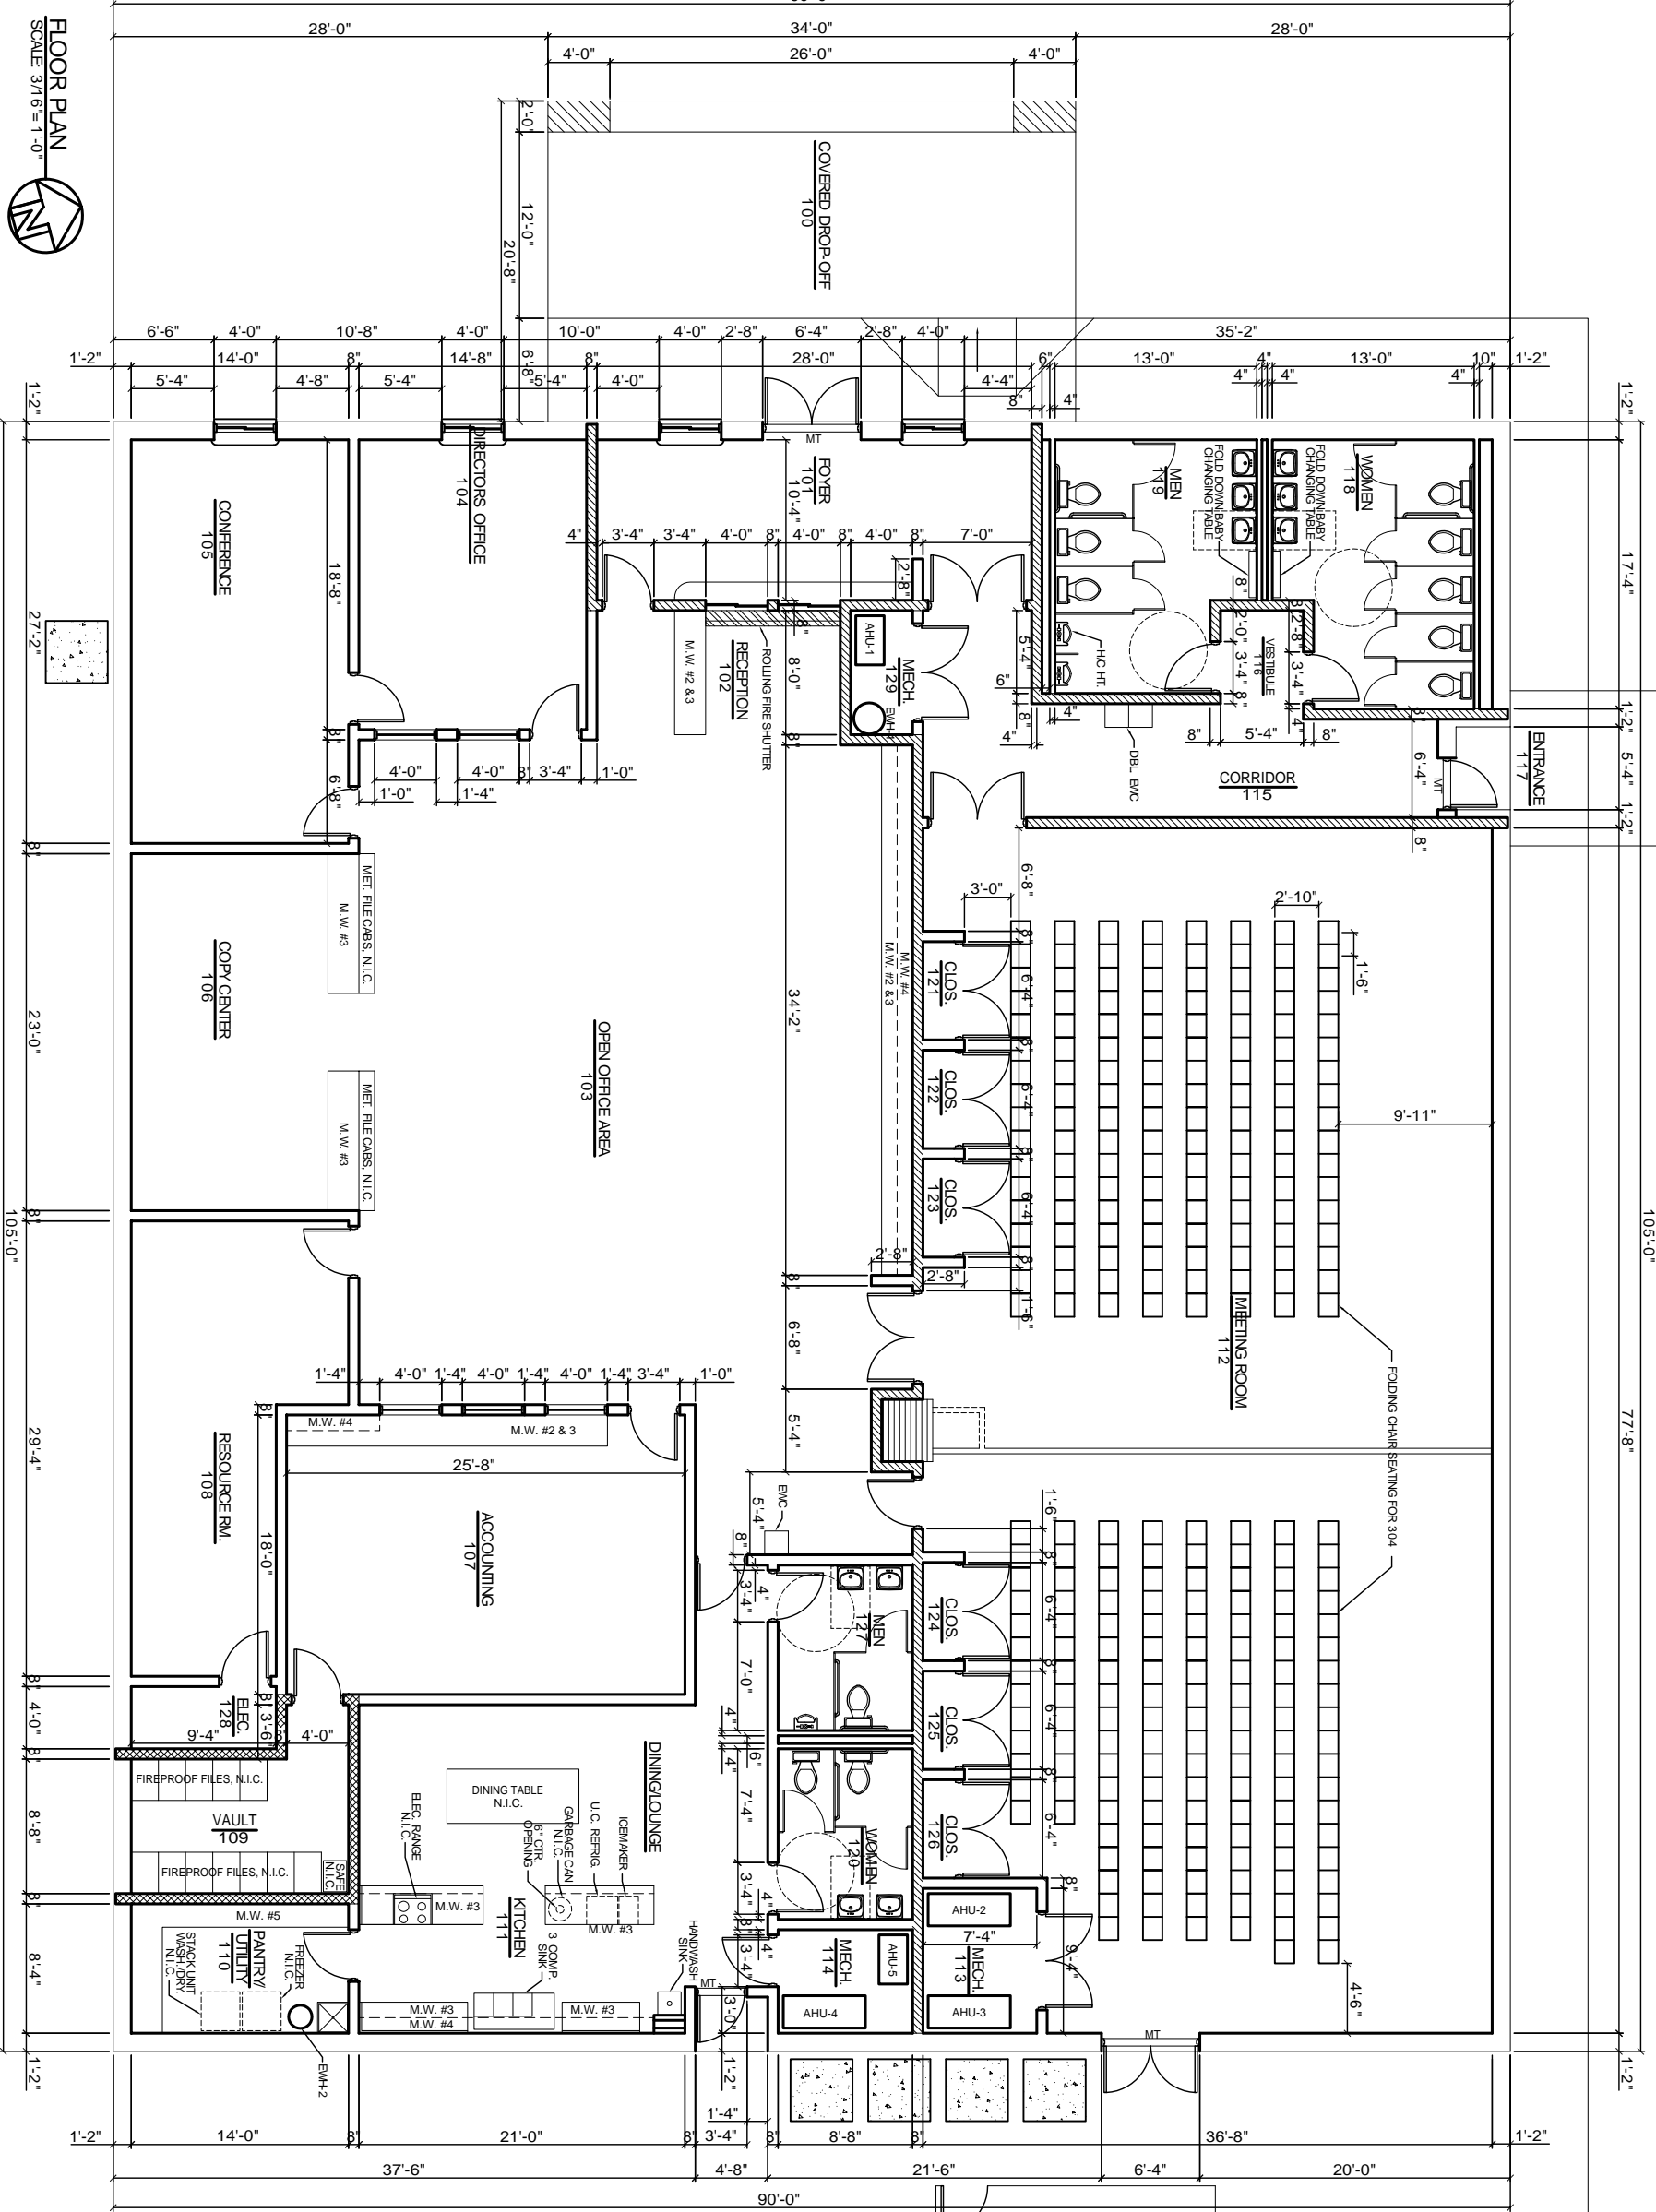

FLOOR PLAN
SCALE 3/16"=1'-0"