

**DAMMON**  
ENGINEERING, INC.

CHIEF ENGINEER  
EMMETT  
DAMMON, P.E.

CHIEF ARCHITECT  
ROBERT  
WILTSE

1095 FLORIDA AVENUE  
SLIDELL, LA. 70458  
OFFICE: 985-649-5832  
FAX: 985-641-5950


WEBSITE:  
WWW.DAMMONENGINEERING.COM

EMAIL:  
DAMMONENG@BELLSOUTH.NET

ARCHITECTURE  
ENGINEERING  
STUDIES  
PLANNING  
INVESTIGATION  
EXPERT WITNESS

PAUL MITCHELL  
SCHOOL  
3321 HESSMER AVE.  
METAIRIE, LA  
70002

SECOND FLOOR  
POWER PLAN

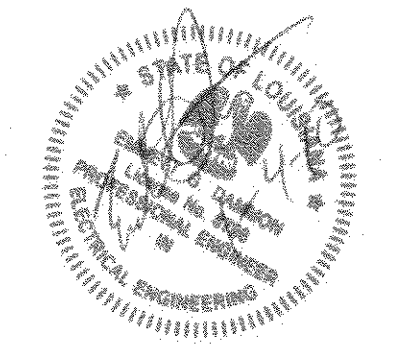

REV:

SCALE: AS NOTED


JOB#: 2051

DATE: XX-XX-08

SHEET

E-2

OF

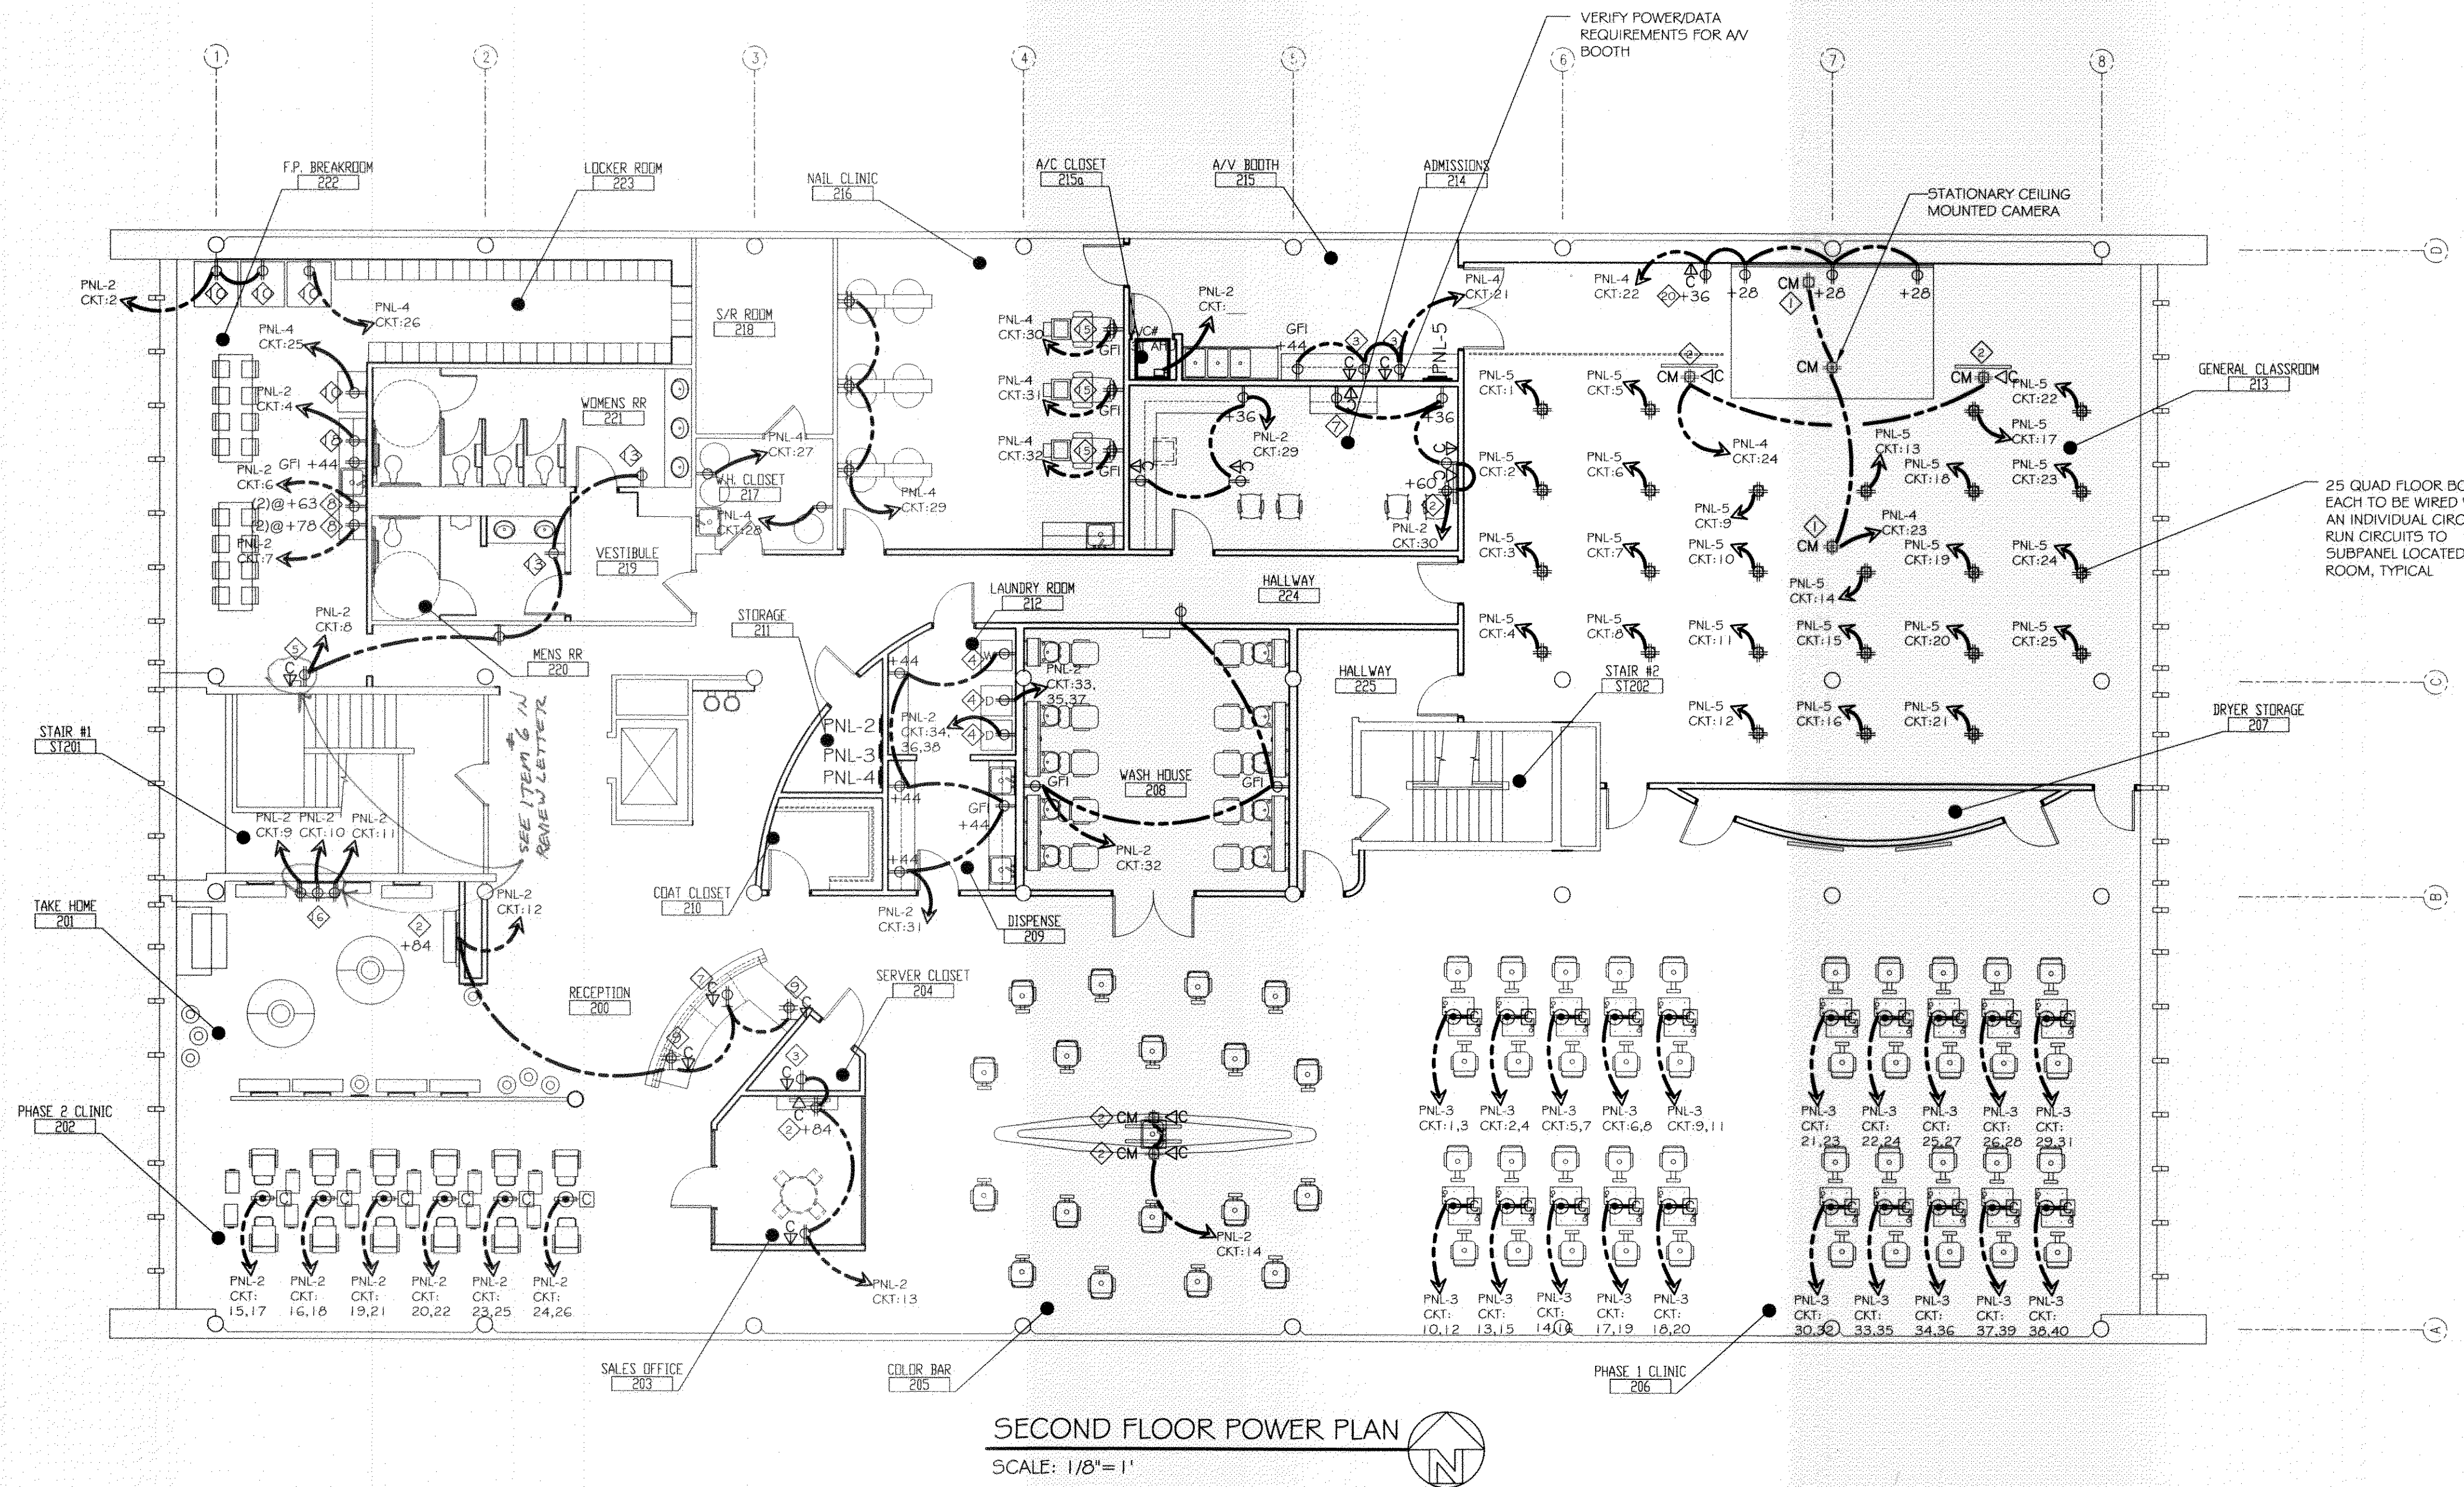

SECOND FLOOR POWER PLAN  
SCALE: 1/8"=1'

**SPECIALTY NOTES**

- |   |  |
|---|--|
| <p>1 CEILING RECEPTACLE PROVIDED WITH AV PROJECTOR CEILING MOUNT PANEL.</p> <p>2 PROVIDE CABLE AND QUAD RECEPTACLE FOR FLATSCREEN TELEVISION, COORDINATE MOUNTING HEIGHT WITH A.V. CONSULTANT</p> <p>3 AV RACK FOR EQUIPMENT LOCATED IN CLOSET, COORDINATE EXACT POWER REQUIREMENT AND LOCATION WITH AV CONSULTANT.</p> <p>4 OWNER PROVIDED WASHER AND DRYER, VERIFY EXACT POWER, GAS, AND PLUMBING REQUIREMENTS WITH MANUFACTURER OF SELECTED UNITS.</p> <p>5 VERIFY POWER AND DATA REQUIREMENTS FOR TIME CLOCK, COODINATE LOCATION WITH OWENER.</p> <p>7 PROVIDE POWER AND NETWORK CONNECTION FOR OWNER PROVIDED COPIER/PRINTER; VERIFY EQUIPMENT WITH OWNER.</p> <p>8 PROVIDE 2 DUPLEX OUTLETS, EACH WITH A DEDICATED CIRCUIT FOR 2 MICROWAVES. COORDINATE HEIGHTS WITH WALL SHELVES FOR MICROWAVES. (2) AT 63" AFF AND (2) AT 78" AFF VERIFY WITH WADSWORTH DESIGN.</p> <p>9 PROVIDE POWER AND NETWORK CONNECTION FLOOR BOXES FOR OWNER PROVIDED COMPUTERS AND POINT OF SALE EQUIPMENT; VERIFY EQUIPMENT WITH OWNER. VERIFY EXACT LOCATION WITH WADSWORTH DESIGN.</p> | <p>10 PROVIDE POWER FOR OWNER PROVIDED REFRIDGERATORS AND VENDING MACHINES; VERIFY EQUIPMENT WITH OWNER.</p> <p>12 GAS HOT WATER HEATERS AND RECIRCULATING PUMP. REFER TO MEP DRAWINGS AND CUT SHEETS FOR REQUIREMENTS</p> <p>13 ELECTRIC HAND DRYER, REFER TO SHEET A401 AND A402 FOR DETAILS.</p> <p>15 PEDICURE STATIONS; PROVIDE GFI WALL OUTLET WITH DEDICATED CIRCUIT FOR EACH UNIT. REFER TO CUT SHEETS FOR DETAILS.</p> <p>16 WALL MOUNTED TOOL BAR BY WADSWORTH DESIGN; 3 OUTLETS WITH DEDICATED CIRCUITS REQ</p> <p>18 PROVIDE POWER FOR OWNER PROVIDED DISHWASHER AS REQUIRED.</p> <p>20 PROVIDE POWER AND DATA FOR LAPTOP OVER RIDE. VERIFY EXACT REQUIREMENTS AND LOCATION WITH AV CONSULTANT. (LOCATE DIRECTLY UNDER LCD SCREEN)</p> |
|---|--|

**POWER LEGEND**

- |  |  |  |   |
|--|--|--|---|
|  | WALL MOUNTED FLUSH J-BOX   |  | FLUSH MOUNTED RECESSED JUNCTION BOX   |
|  | DUPLEX CONVENIENCE OUTLET  |  | CEILING MOUNTED OUTLET  |
|  | GROUND FAULT INDICATOR (GFI) RECEPTICAL.   |  | DATA CONNECTION. VERIFY WITH AV CONSULTANT AND COMPUTER, PHONE PROVIDER.  |
|  | EXTERIOR WALL MOUNTED WATER RESISTANT CONVENIENCE OUTLET. PROVIDE GROUND FAULT INDICATOR (GFI), TYPICAL. |  | (2) CIRCUITS AT EACH STYLING STATION STUBBED THROUGH CONDUIT IN THE FLOOR. INSTALL FOURPLEX RECEPTACLE IN PRE-INSTALLED JUNCTION BOX IN STYLING STATION |
|  | HALF SWITCHED CONVENIENCE OUTLET   |  | ELECTRIC PANEL  |
|  | FOURPLEX CONVENIENCE OUTLET  |  |   |
|  | FLOOR MOUNTED DUPLEX CONVENIENCE OUTLET  |  |   |
|  | FLOOR MOUNTED FOURPLEX CONVENIENCE OUTLET  |  |   |

REVIEWED FOR  
STATE FIRE MARSHAL  
AS PER REVISED LETTER  
BY: ODIS V. HANKE  
*Odys V. Hanke*  
375133