

DAMMON ENGINEERING, INC.

CHIEF ENGINEER
EMMETT
DAMMON, P.E.

CHIEF ARCHITECT
ROBERT
WILTSE

1095 FLORIDA AVENUE
SLIDELL, LA. 70458
OFFICE: 985-649-5832
FAX: 985-641-5950

WEBSITE:
WWW.DAMMONENGINEERING.COM

EMAIL:
DAMMONENG@BELLSOUTH.NET

- ARCHITECTURE
- ENGINEERING
- STUDIES
- PLANNING
- INVESTIGATION
- EXPERT WITNESS

PAUL MITCHELL
SCHOOL
3321 HESSMER AVE.
METAIRIE, LA
70002

**THIRD FLOOR
POWER PLAN**



REV:

SCALE: AS NOTED


JOB#: 2051

DATE: 01-04-10

SHEET

E-3

OF

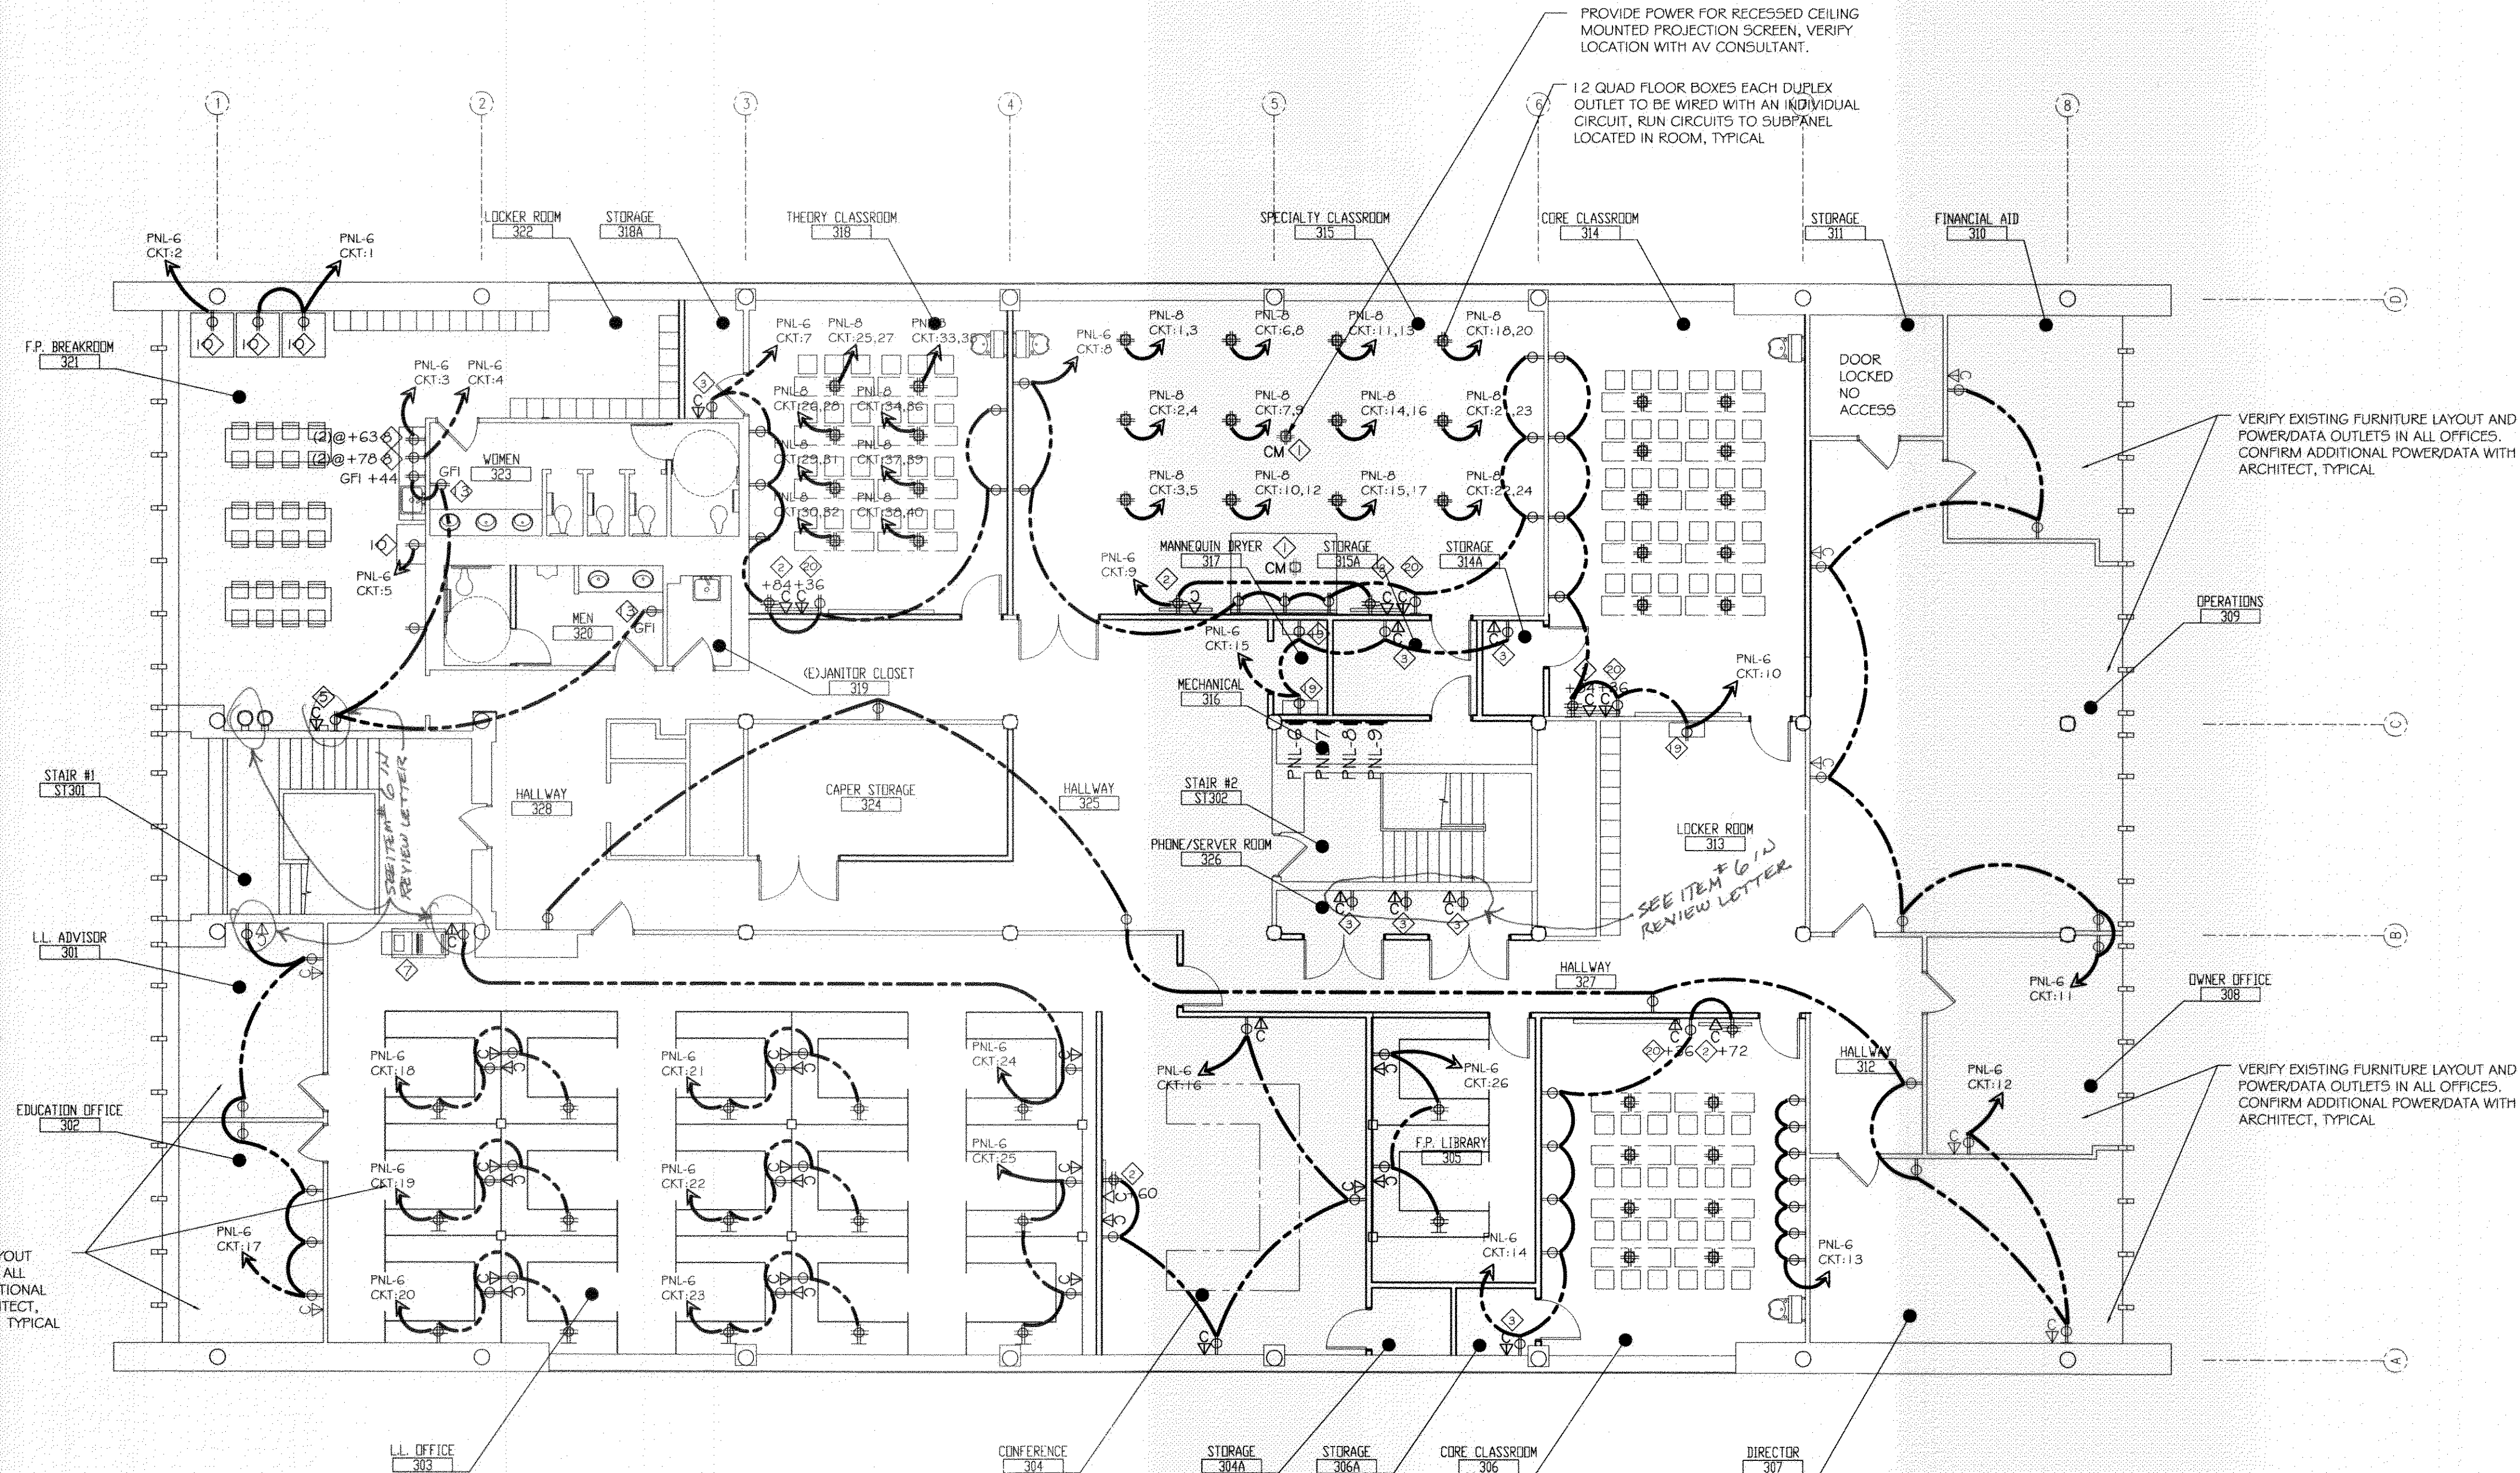

THIRD FLOOR POWER PLAN
SCALE: 1/8" = 1'

SPECIALTY NOTES

- 1 CEILING RECEPTACLE PROVIDED WITH AV PROJECTOR CEILING MOUNT PANEL.
- 2 PROVIDE CABLE AND QUAD RECEPTACLE FOR FLATSCREEN TELEVISION, COORDINATE MOUNTING HEIGHT WITH A.V. CONSULTANT
- 3 AV RACK FOR EQUIPMENT LOCATED IN CLOSET, COORDINATE EXACT POWER REQUIREMENT AND LOCATION WITH AV CONSULTANT.
- 5 VERIFY POWER AND DATA REQUIREMENTS FOR TIME CLOCK, COODINATE LOCATION WITH OWENER.
- 7 PROVIDE POWER AND NETWORK CONNECTION FOR OWNER PROVIDED COPIER/PRINTER; VERIFY EQUIPMENT WITH OWNER.
- 8 PROVIDE 2 DUPLEX OUTLETS, EACH WITH A DEDICATED CIRCUIT FOR 2 MICROWAVES. COORDINATE HEIGHTS WITH WALL SHELVES FOR MICROWAVES. (2) AT 63" AFF AND (2) AT 78" AFF VERIFY WITH WADSWORTH DESIGN.
- 10 PROVIDE POWER FOR OWNER PROVIDED REFRIDGERATORS AND VENDING MACHINES; VERIFY EQUIPMENT WITH OWNER.
- 13 ELECTRIC HAND DRYER, REFER TO SHEET A401 AND A402 FOR DETAILS.
- 19 PROVIDE POWER FOR MANNEQUIN DRYER CABINET; VERIFY EQUIPMENT WITH OWNER.
- 20 PROVIDE POWER AND DATA FOR LAPTOP OVER RIDE. VERIFY EXACT REQUIREMENTS AND LOCATION WITH AV CONSULTANT. (LOCATE DIRECTLY UNDER LCD SCREEN)

POWER LEGEND

- WALL MOUNTED FLUSH J-BOX
- DUPLEX CONVENIENCE OUTLET
- GROUND FAULT INDICATOR (GFI) RECEPTACLE
- EXTERIOR WALL MOUNTED WATER RESISTANT CONVENIENCE OUTLET. PROVIDE GROUND FAULT INDICATOR (GFI), TYPICAL.
- HALF SWITCHED CONVENIENCE OUTLET
- FOURPLEX CONVENIENCE OUTLET
- FLOOR MOUNTED DUPLEX CONVENIENCE OUTLET
- FLOOR MOUNTED FOURPLEX CONVENIENCE OUTLET
- FLUSH MOUNTED RECESSED JUNCTION BOX
- CEILING MOUNTED OUTLET
- DATA CONNECTION. VERIFY WITH AV CONSULTANT AND COMPUTER, PHONE PROVIDER.
- (2) CIRCUITS AT EACH STYLING STATION STUBBED THROUGH CONDUIT IN THE FLOOR. INSTALL FOURPLEX RECEPTACLE IN PRE-INSTALLED JUNCTION BOX IN STYLING STATION
- ELECTRIC PANEL

REVIEWED FOR
STATE FIRE MARSHAL
AS PER REVIEW LETTER
BY O.T.S.V. 6/8/10
375133