
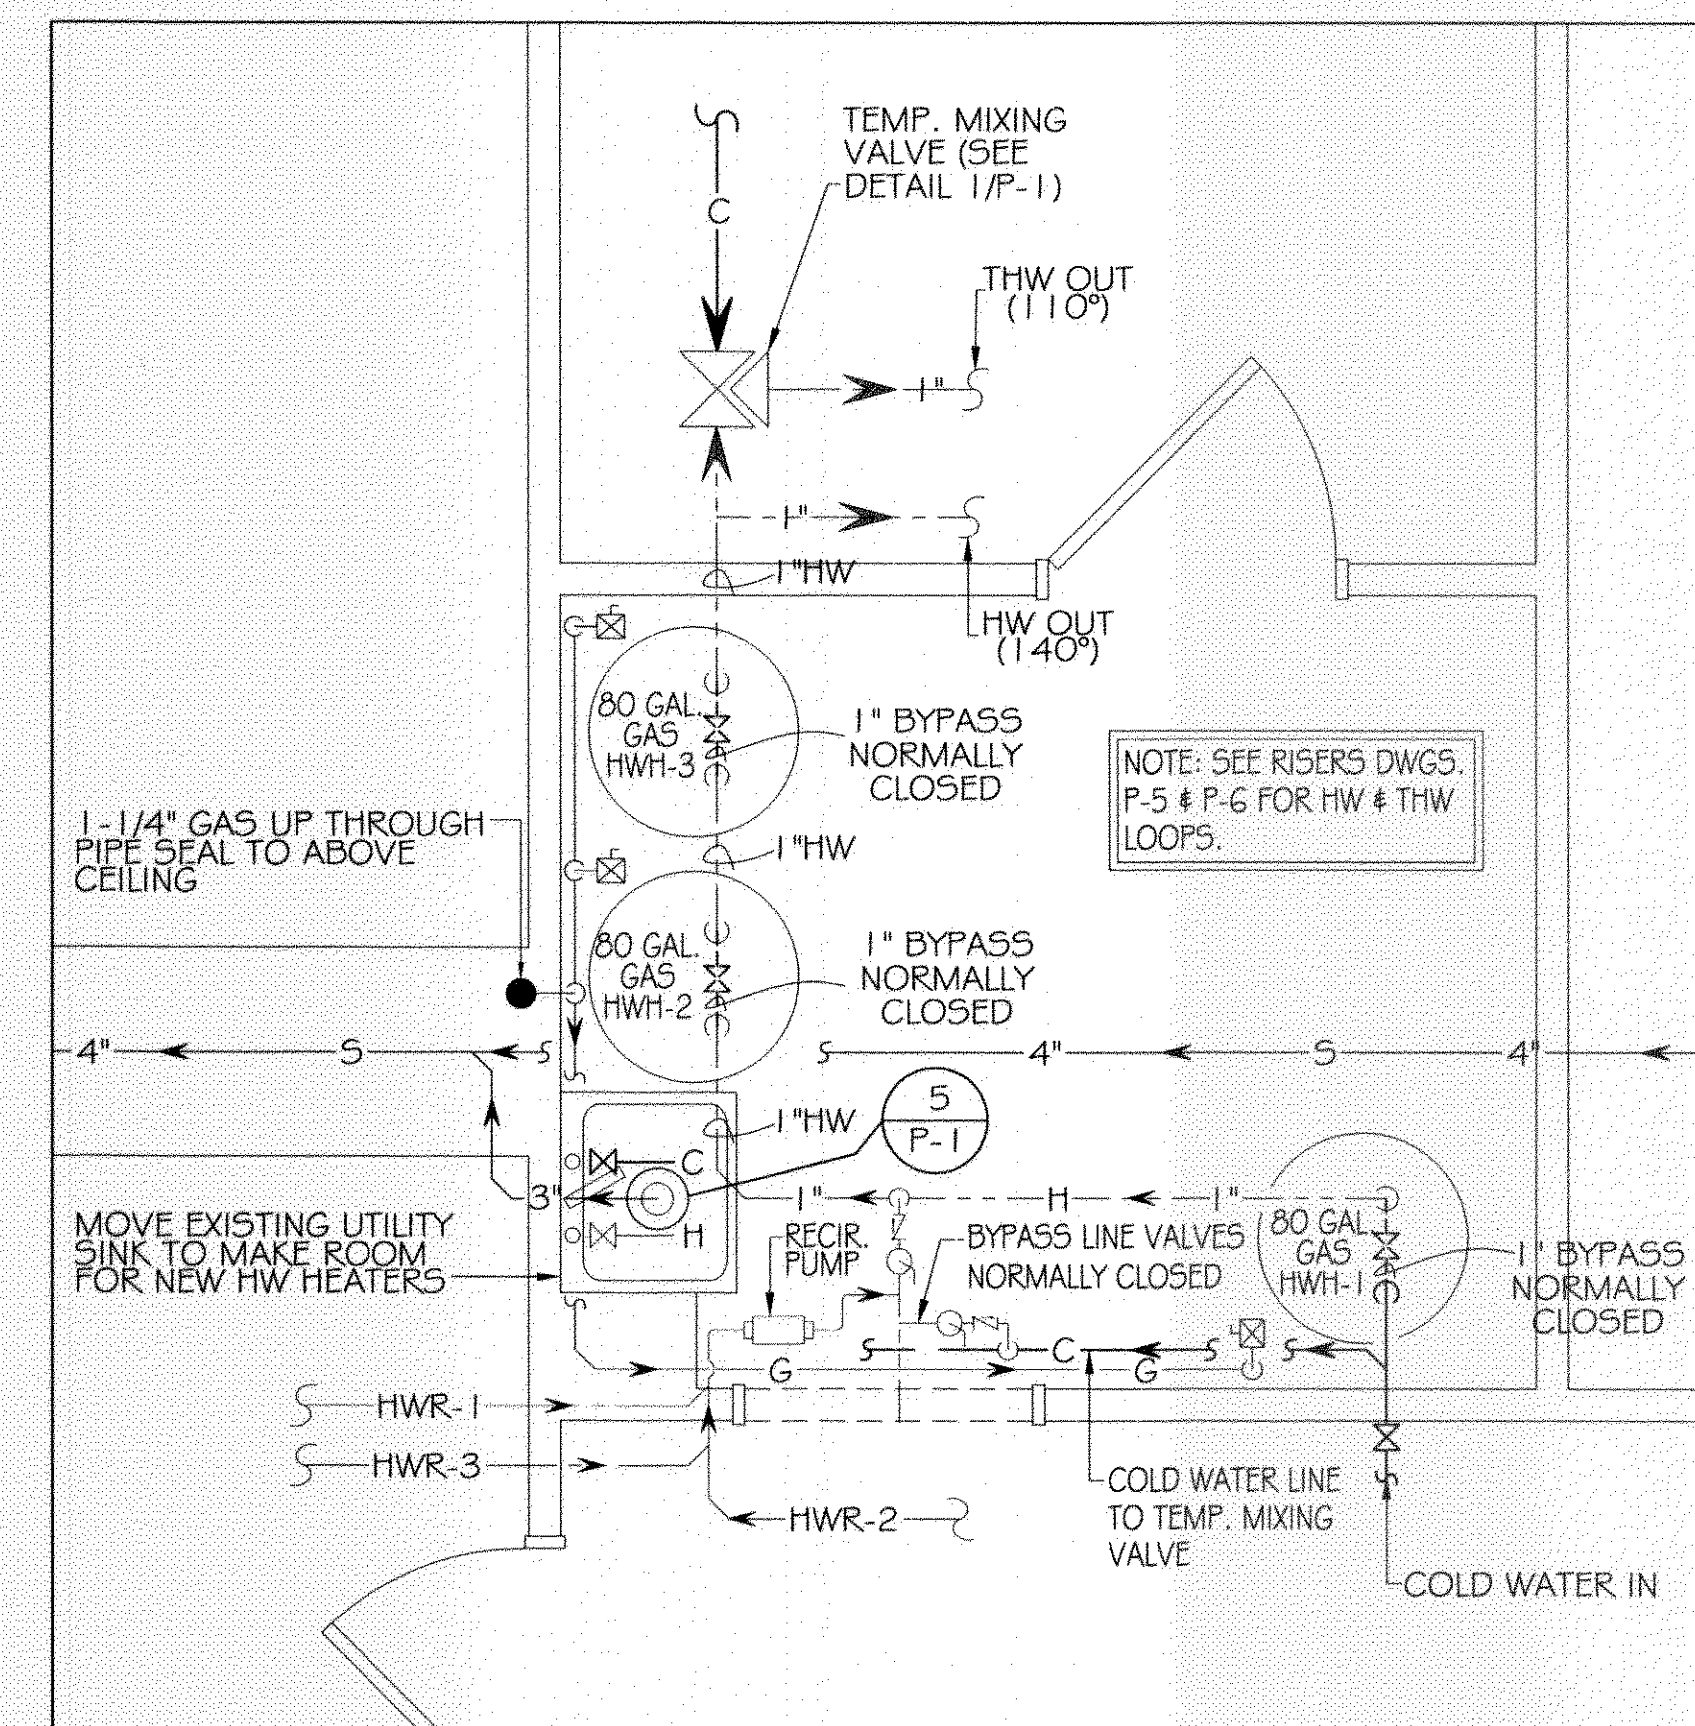


SECOND FLOOR PLUMBING PLAN


SCALE: 1/8"=1'

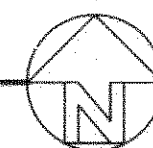

WATER HEATER ROOM LAYOUT PLAN

NOT TO SCALE


PLUMBING LEGEND	
—S—	SANITARY WASTE PIPING
—C—	COLD WATER SUPPLY PIPING
---HWR---	HOT WATER RETURN PIPING
---H---	HOT WATER SUPPLY PIPING (140°)
---THW---	TEMPERED HOT WATER PIPING (110°)
—G—	GAS PIPING
○	BALL VALVE
⊗	GLOBE VALVE
⊗	GAS COCK
⊗	CHECK VALVE
○FD	FLOOR DRAIN
○FCO	CLEAN OUT IN FLOOR
⊥	WALL CLEAN OUT

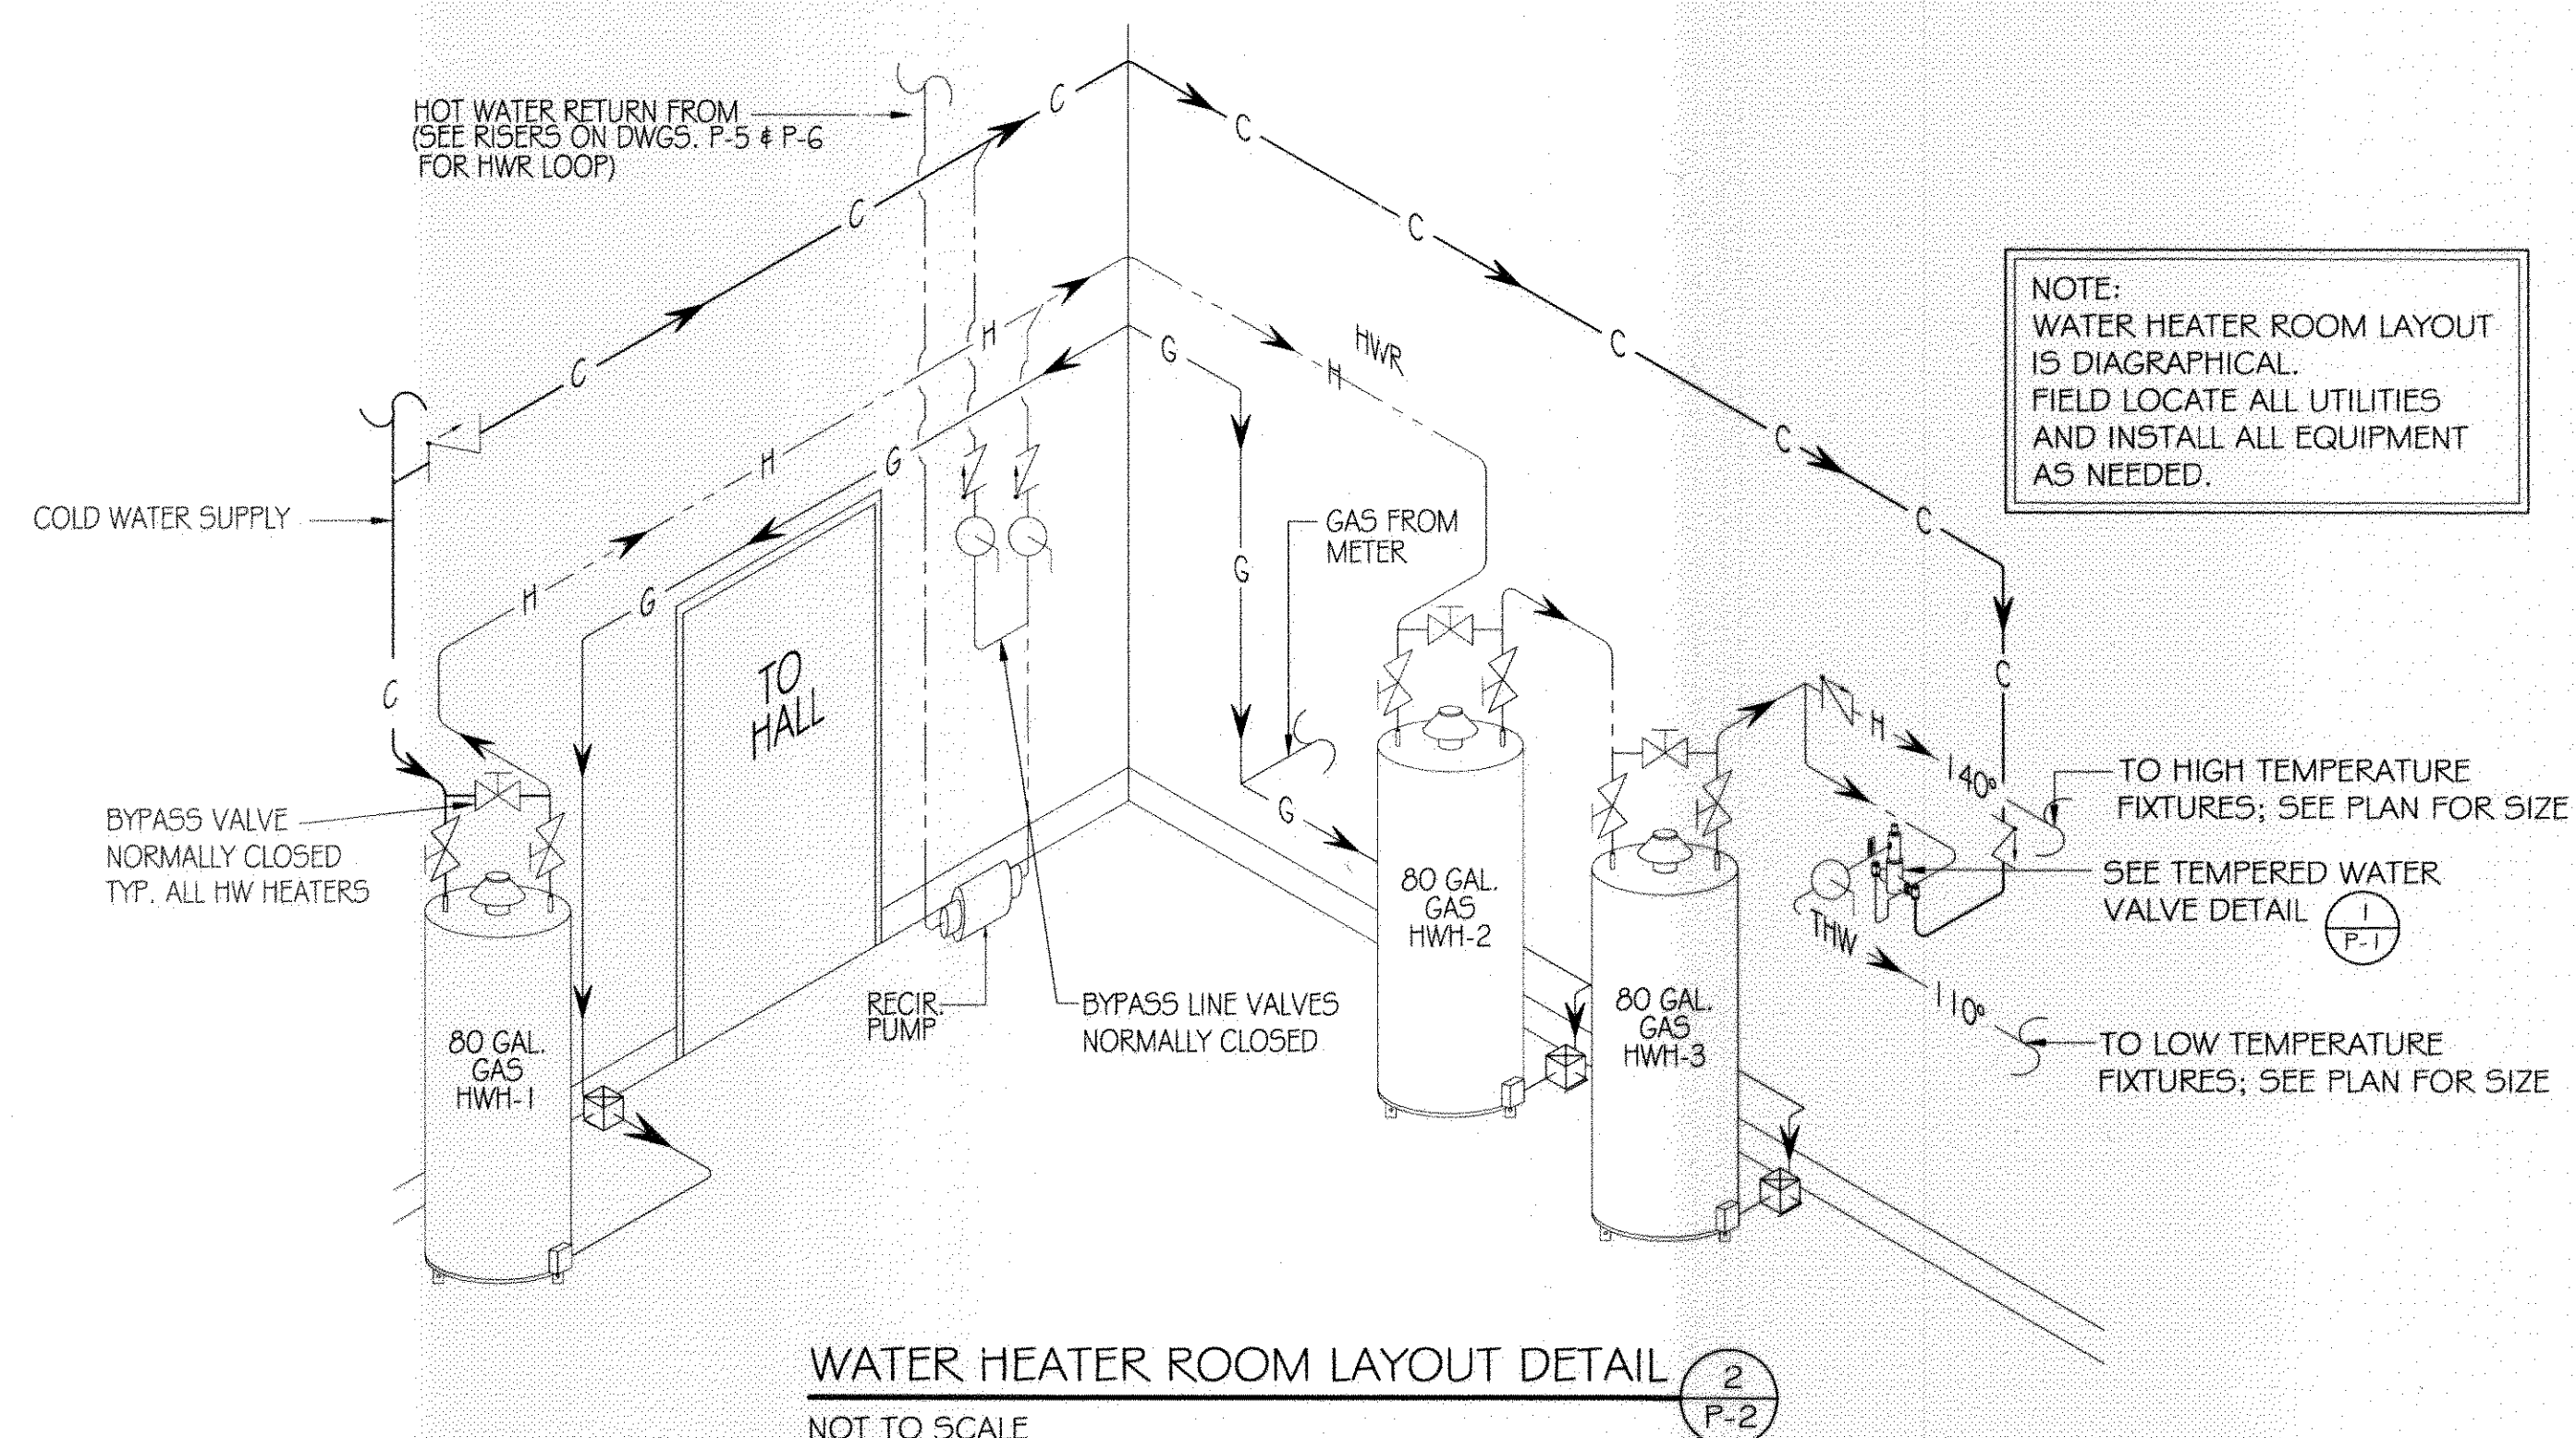

WATER HEATER ROOM LAYOUT DETAIL

NOT TO SCALE

2
P-2

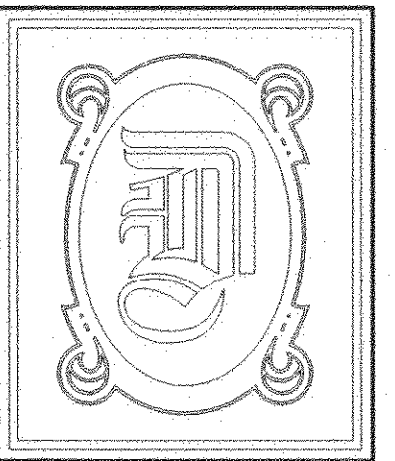

DAMMON ENGINEERING, INC.

CHIEF ENGINEER
EMMETT DAMMON, P.E.

CHIEF ARCHITECT
ROBERT WILTSE

1095 FLORIDA AVENUE
SLIDELL, LA. 70458
OFFICE: 985-649-5832
FAX: 985-641-5950

WEBSITE:
WWW.DAMMONENGINEERING.COM

EMAIL:
DAMMONENG@BELLSOUTH.NET

ARCHITECTURE
ENGINEERING
STUDIES
PLANNING
INVESTIGATION
EXPERT WITNESS

PAUL MITCHELL
SCHOOL
3321 HESSMER AVE.
METAIRIE, LA
70002

SECOND FLOOR
PLUMBING
PLAN



REV:

SCALE: AS NOTED

JOB#: 2051

DATE: 01-04-10

SHEET

P-2

OF

REVIEWED FOR
STATE FIRE MARSHAL
AS PER REVISED LETTER
BY DATE

375133