


1 2 3 4 5 6 7 8

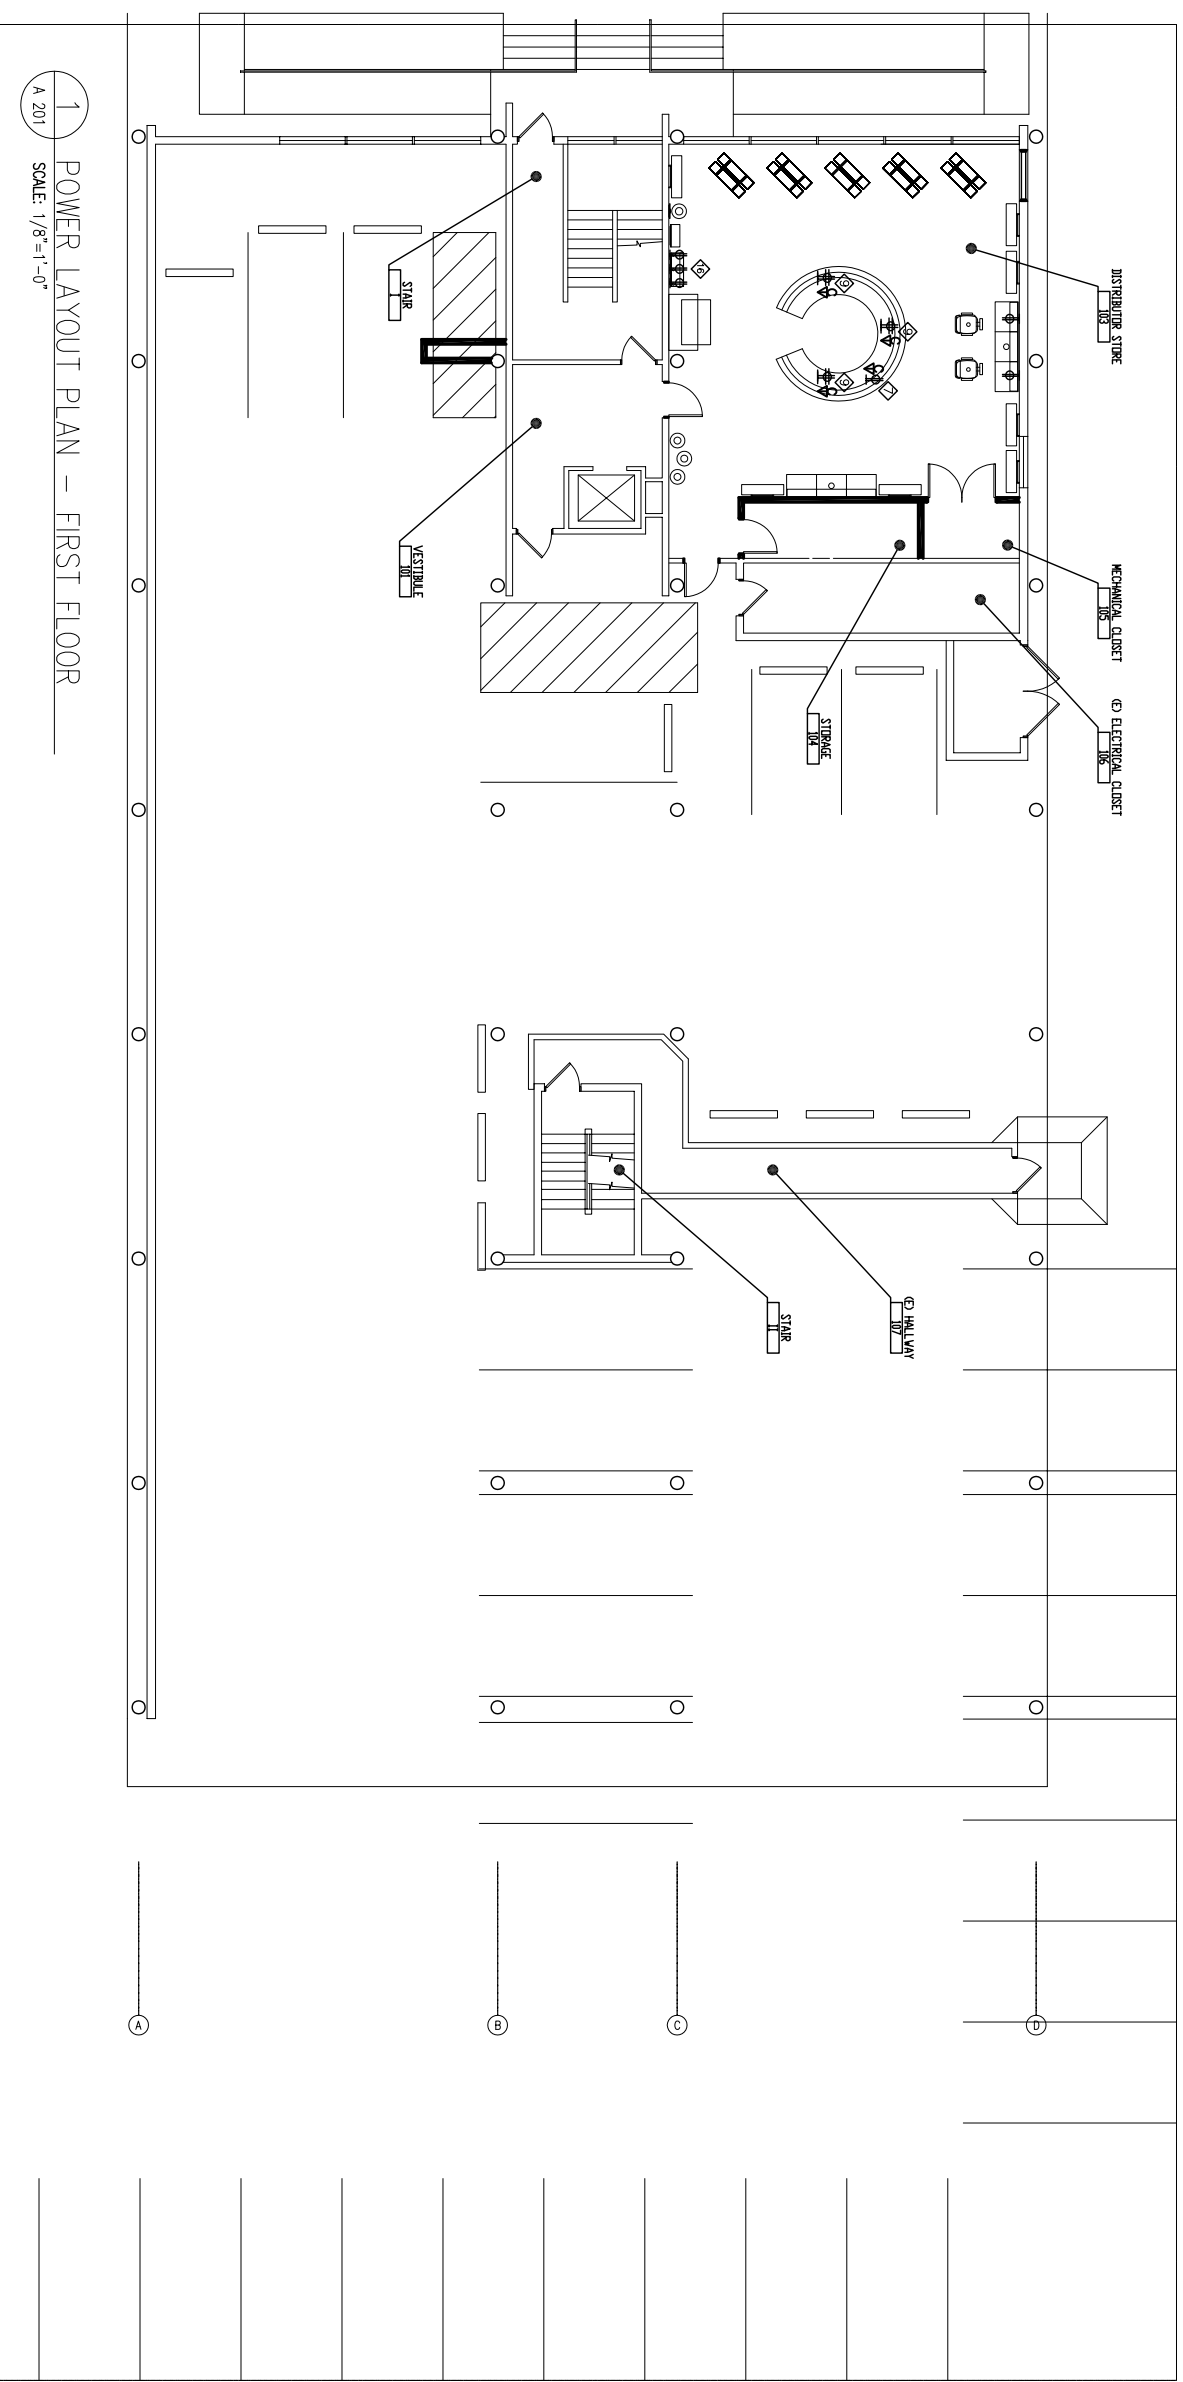

GENERAL NOTES:

1. GENERAL CONTRACTOR TO COORDINATE A PRECONSTRUCTION SITE WALK THROUGH MEETING TO FIELD VERIFY ALL DIMENSIONS AND CONDITIONS WITH OWNER AND ELECTRIC SUBCONTRACTOR PRIOR TO COMMENCING ELECTRICAL WORK AND PURCHASE OF FIXTURES.
2. VERIFY POWER REQUIREMENTS OF ALL APPLIANCES WITH SELECTED APPLIANCE MANUFACTURER.
3. RECESSED LIGHTING FIXTURES RECESSED INTO INSULATED CEILINGS MUST BE APPROVED FOR ZERO CLEARANCE INSULATION COVER (IC) BY UNDERWRITER LABORATORIES OR OTHER TESTING/RATING LABORATORIES RECOGNIZED BY THE INTERNATIONAL CONFERENCE OF BUILDING OFFICIALS (ICBO).
4. EXHAUST FAN TO BE CAPABLE OF PROVIDING 5 FULL VOLUME AIR CHANGES PER HOUR.
5. WIRING DEVICES: SWITCHES AND CONVENIENCE OUTLETS SHALL BE "LEVITON" SPEC. GRADE. COLOR: WHITE. NOT IVORY. INSTALL AT HEIGHTS REQUIRED BY CURRENT CODE, I.N.C.O.
6. EXTENT: COMPLETE WIRING INSTALLATION FOR ALL ROOMS, INCLUDING ALL WIRING AND TELEPHONE CODES. ALL WIRING AND MATERIAL SHALL BE IN FULL ACCORDANCE WITH NATIONAL, STATE AND LOCAL ELECTRICAL CODES INCLUDING TITLE 24.
7. OUTLET HEIGHTS INDICATED ON PLAN ARE TO CENTER OF FIXTURE AND HEIGHT ABOVE THE FINISHED FLOOR ELEVATION. VERIFY CODE COMPLIANCE WITH BUILDING INSPECTOR.
8. OUTLETS AT ALL WADSWORTH DESIGN CUTTING STATIONS SHOULD BE GREY WITH BRUSHED ALUMINUM COVER PLATES AT FLOOR BOX LOCATIONS.
9. ALL COVER PLATES AT FLOOR BOX LOCATIONS SHALL HAVE STAINLESS STEEL COVER PLATES.

POWER LEGEND:

- WALL MOUNTED FLUSH J-BOX
- DUPLEX CONVENIENCE OUTLET
- GROUND FAULT INDICATOR (GFI) RECEPTACLE
- EXTERIOR WALL MOUNTED WATER RESISTANT CONVENIENCE OUTLET, TYPICAL.
- HALF SWITCHED CONVENIENCE OUTLET
- FOURPLEX CONVENIENCE OUTLET
- FLOOR MOUNTED DUPLEX CONVENIENCE OUTLET
- FLOOR MOUNTED FOURPLEX CONVENIENCE OUTLET
- (4) CIRCUITS AT EACH STYLING STATION STUBBED THROUGH CONDUIT IN THE FLOOR. INSTALL FOURPLEX RECEPTACLE IN PRE-INSTALLED JUNCTION BOX IN STYLING STATION
- FLUSH MOUNTED RECESSED JUNCTION BOX
- CEILING MOUNTED OUTLET
- DATA CONNECTION. VERIFY WITH AV CONSULTANT AND COMPUTER, PHONE PROVIDER.

SPECIALTY NOTES:

1. PROVIDE RECEPTACLE PROVIDED WITH AV PROVIDER. SEEING MOUNT WITH AV PROVIDER. SEEING MOUNT WITH AV PROVIDER.
2. PROVIDE CABLE AND QUAD RECEPTACLE FOR FLATSCREEN TELEVISION, COORDINATE MOUNTING HEIGHT WITH AV CONSULTANT.
3. AV RACK FOR EQUIPMENT LOCATED IN GUEST COORDINATE EXACT POWER REQUIREMENT AND LOCATION WITH AV CONSULTANT.
4. OWNER PROVIDED WASHER AND DRYER. VERIFY EXIST POWER GAS AND PLUMBING REQUIREMENTS WITH MANUFACTURER OF SELECTED EQUIPMENT.
5. VERIFY POWER AND DATA REQUIREMENTS FOR THE CLOCK. COORDINATE LOCATION WITH OWNER.
6. PROVIDE 4 DUPLEX OUTLETS. EACH WITH A DEDICATED CIRCUIT FOR 4 MICROWAVES. COORDINATE HEIGHTS WITH WALL SHELVES FOR MICROWAVES. REFERENCE 6/A-2 FOR DETAILS.
7. PROVIDE POWER AND NETWORK CONNECTION FOR OWNER PROVIDED COPIER/PRINTER. VERIFY EQUIPMENT WITH OWNER.
8. PROVIDE 2 DUPLEX OUTLETS. EACH WITH A DEDICATED CIRCUIT FOR 2 MICROWAVES. COORDINATE HEIGHTS WITH WALL SHELVES FOR MICROWAVES.
9. PROVIDE POWER AND NETWORK CONNECTION FOR 2 BENCHTOP COMPUTERS. VERIFY EQUIPMENT WITH OWNER.
10. PROVIDE POWER FOR OWNER PROVIDED REFRIGERATORS AND TENDING MACHINES. VERIFY REQUIREMENTS WITH OWNER.
11. POWER FOR EXTERIOR BACK LIT SIGNAGE. REFER TO EXTERIOR ELEVATIONS FOR DETAILS.
12. PROVIDE WATER HEATERS AND REFRIGERATING EQUIPMENT TO THE DRINKING AND COFFIN SHEETS AND AVOID FOR DETAILS.
13. ELECTRIC AND WATER REFER TO SHEET 401 AND AVOID FOR DETAILS.
14. WATERMETER. VERIFY WATER SUPPLY. GRADE 4" WATERMETER. VERIFY WITH MANUFACTURER.
15. PROVIDE STAIRS. PROVIDE 6" WALL OUTLET WITH DEDICATED CIRCUIT FOR EACH. REFER TO SHEET 401 FOR DETAILS.
16. WALL MOUNTED TOOL BAR BY WADSWORTH DESIGN. 3 OUTLETS WITH DEDICATED CIRCUITS REQ.
17. OWNER PROVIDED SINK, BID. AND MACHINES. VERIFY POWER REQ. WITH CUT SHEETS. PROVIDE DEDICATED CIRCUIT PER REQ.
18. PROVIDE POWER FOR OWNER PROVIDED DRINKING AND REFRIGERATED.
19. PROVIDE POWER FOR MANNEQUIN. OWNER GARNET. REFER TO EQUIPMENT WITH OWNER.
20. PROVIDE POWER AND DATA FOR 2 DESKTOP DESKS. REFER TO EQUIPMENT WITH OWNER. VERIFY EQUIPMENT WITH OWNER. COORDINATE MOUNTING HEIGHT WITH AV CONSULTANT.

NOT FOR CONSTRUCTION: 12.14.09

BRADFORD J. DUDLEY
345 THIRD STREET
LAFAYETTE, LA 70002
T: 987.318.3078 F: 987.318.3078

E:\Project\Graphic Design File\VM PS.dwg
METAIRIE, LA

3321 HESSNER AVENUE
METAIRIE, LA 70002

CLIENT:
MARK AND USA PUEBLO

PROFESSIONAL SEAL:

SIGNATURE _____ DATE _____

SUBMISSION DATE
CONCEPT PLAN 12/01/09
CONSULTANT COORDINATION 12/14/09

PROJECT NO: 0921
SCALE: 1/8" = 1'

POWER
LAYOUT PLAN
FIRST FLOOR
A 201