

BRADFORD J. DUDLEY
 36 THIRD STREET
 LAGUNA BEACH, CALIFORNIA 92653
 T: 949.233.8378
 F: 949.233.8378

E:\Projects\Graphic Design\Plan\VA 05.dwg

METAIRIE, LA

3321 HESSMER AVENUE
 METAIRIE, LA 70002

CLIENT:

MARK AND USA PUEBLO

PROFESSIONAL SEAL:

SIGNATURE _____ DATE _____


SUBMISSION DATE
 CONCEPT PLAN 12/01/09
 CONSULTANT COORDINATION 12/14/09

PROJECT NO: 0921
 SCALE: 1/8" = 1'

**THIRD FLOOR
 REFLECTED
 CEILING
 PLAN**

A 223

NOT FOR CONSTRUCTION: 12.14.09

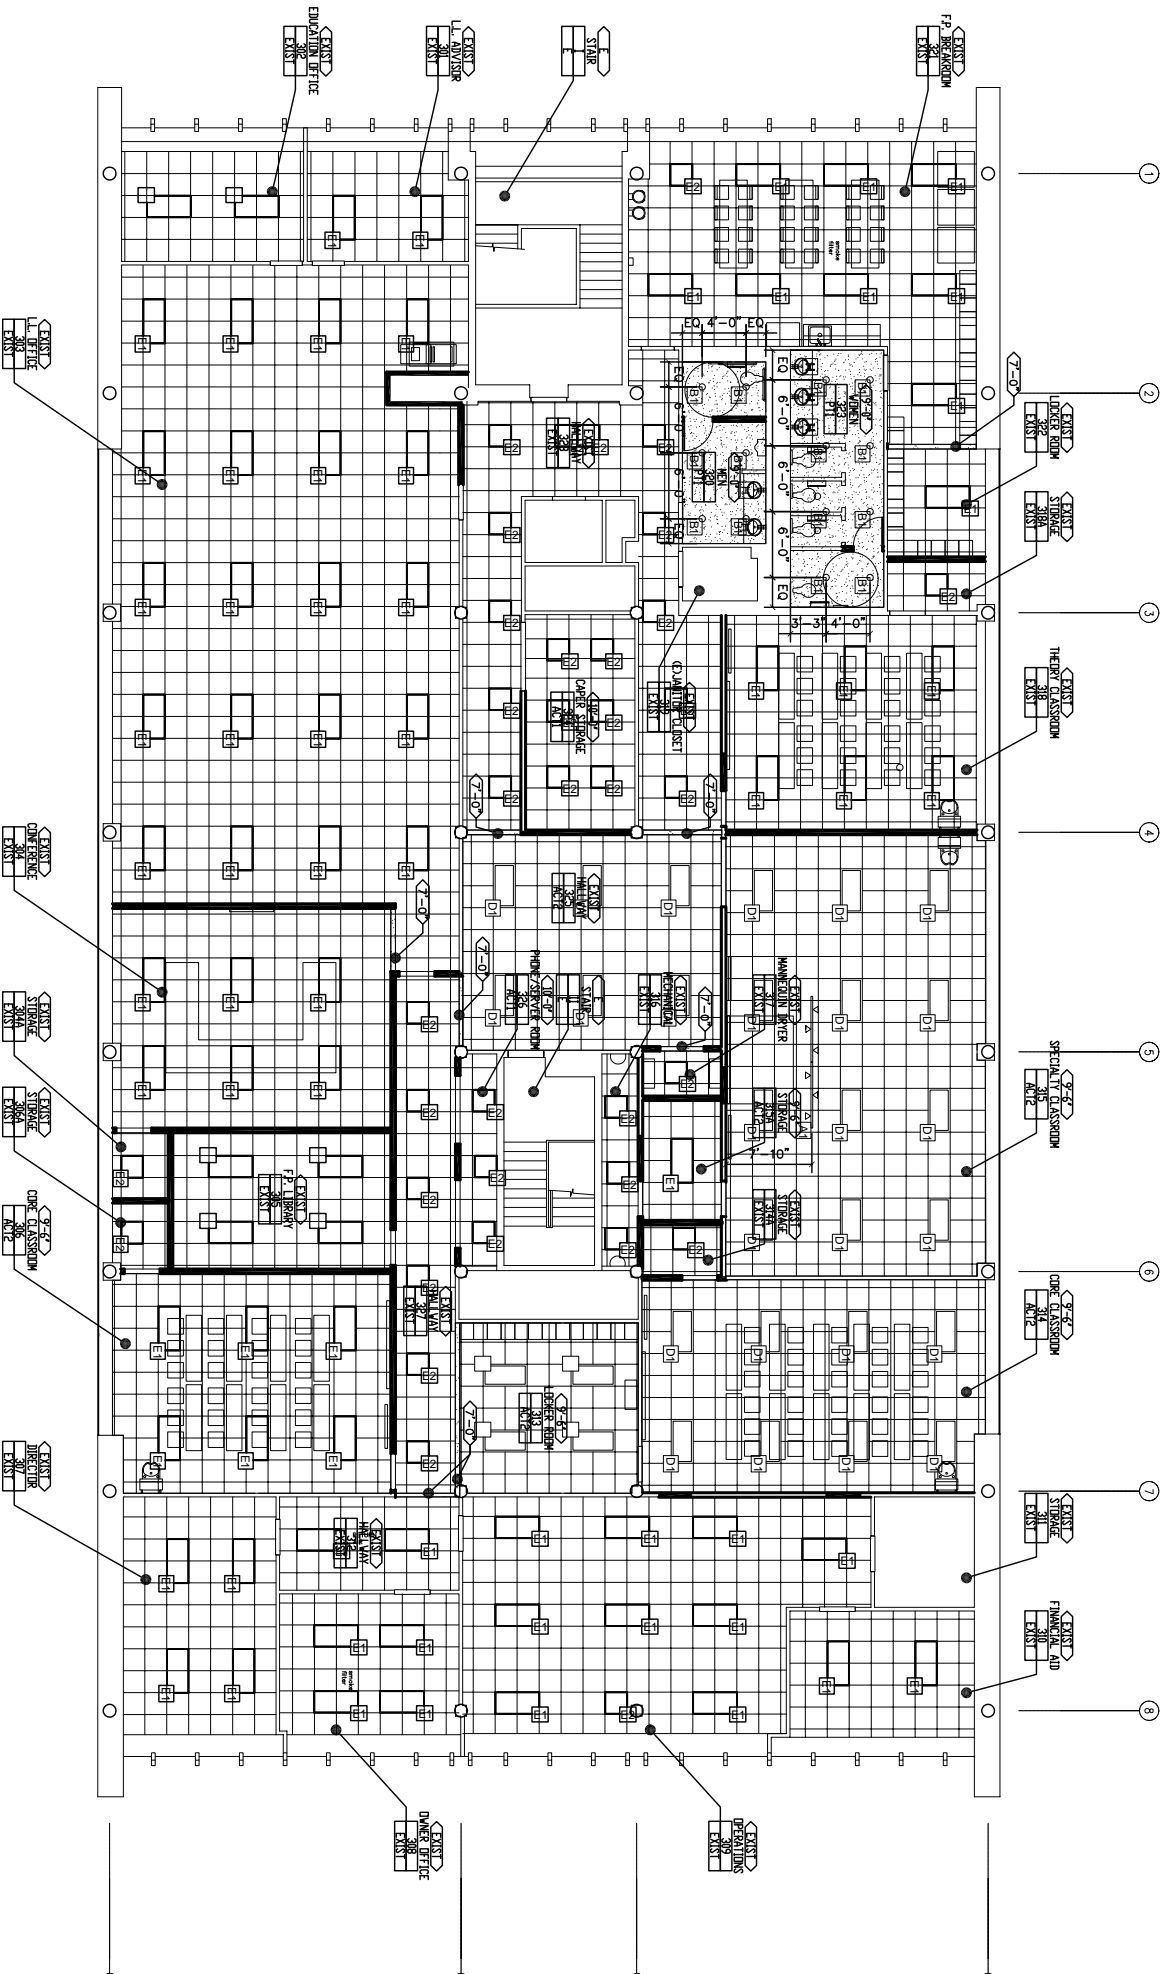

1 LIGHTING PLAN AND RCP - THIRD FLOOR
 A 223 SCALE: 1/8"=1'-0"

- GENERAL NOTES:**
1. GENERAL CONTRACTOR TO COORDINATE A PRE-CONSTRUCTION SITE WALK THROUGH MEETING TO FIELD VERIFY OUTLET AND FIXTURE LOCATIONS AND TYPES WITH ARCHITECT, OWNER AND ELECTRICAL SUBCONTRACTOR PRIOR TO COMMENCING ELECTRICAL WORK AND PURCHASE OF FIXTURES.
 2. VERIFY POWER REQUIREMENTS OF ALL APPLIANCES WITH SELECTED APPLIANCE MANUFACTURER.
 3. RECESSED LIGHTING FIXTURES RECESSED INTO INSULATED CEILING MUST BE APPROVED FOR ZERO CLEARANCE INSULATION COVER (IC) BY UNDERWRITER LABORATORIES OR OTHER TESTING/RATING LABORATORIES RECOGNIZED BY THE INTERNATIONAL CONFERENCE OF BUILDING OFFICIALS (ICBO).
 4. EXHAUST FAN TO BE CAPABLE OF PROVIDING 5 FULL VOLUME AIR CHANGES PER HOUR.
 5. WIRING DEVICES: SWITCHES AND CONVENIENCE OUTLETS SHALL BE "LEVITON" SPEC. GRADE. COLOR: WHITE, NOT IVORY. INSTALL AT HEIGHTS REQUIRED BY CURRENT CODE.
 6. EXTENT: COMPLETE WIRING INSTALLATION FOR POWER, LIGHTING, SIGNAL SYSTEM AND TELEPHONE. CODES: ALL WIRING AND MATERIAL SHALL BE IN FULL ACCORDANCE WITH NATIONAL, STATE AND LOCAL ELECTRICAL CODES INCLUDING TITLE 24.
 7. GENERAL CONTRACTOR TO PROVIDE SUBMITTAL PACKAGE FOR ARCHITECT TO REVIEW PRIOR TO ORDERING ANY LIGHT FIXTURES.

LIGHTING/REFLECTED CEILING PLAN LEGEND:

- CEILING MOUNTED PROJECTOR, VERIFY WITH OWNER
- EXIT SIGN - BACK MOUNTED
- EXIT SIGN - TOP, OR PENDANT MOUNTED SINGLE FACE WITH DIRECTIONAL ARROWS AS INDICATED
- EXIT SIGN - TOP, OR PENDANT MOUNTED DOUBLE FACE WITH DIRECTIONAL ARROWS AS INDICATED
- EMERGENCY LIGHTING UNIT "Y" SEE ELEC. ENG. DRAWINGS
- SMOKE DETECTOR
- BULKHEAD TYPE, SEE SHEET A501
- FIXTURE TYPE, SEE SCHEDULE ON THIS SHEET FOR DETAILS
- HEIGHT ABOVE FINISHED FLOOR BELOW ANNOTATED CEILING
- ROOM NAME ROOM NUMBER CEILING FINISH, SEE FINISH SCHEDULE ON SHEET A 101
- CEILING GRID
- GYPSUM BOARD