

DAMMON
ENGINEERING, INC.

CHIEF ENGINEER
EMMETT
DAMMON, P.E.
CHIEF ARCHITECT
ROBERT
WILTSE

1095 FLORIDA AVENUE
SLIDELL, LA. 70458
OFFICE: 985-649-5832
FAX: 985-641-3950

WWW.DAMMONENGINEERING.COM
EMAIL:
DAMMONENG@BELLSOUTH.NET


ARCHITECTURE
ENGINEERING
STUDIES
PLANNING
INVESTIGATION
EXPERT WITNESSES

PAUL MITCHELL
SCHOOL
3321 HESSMER AVE
METAIRIE, LA
70002

THIRD FLOOR
PLUMBING
PLAN

REV: 04 / 1-28-10
SCALE: AS NOTED
JOB#: 2051
DATE: 01-04-10
SHEET

P-3
OF

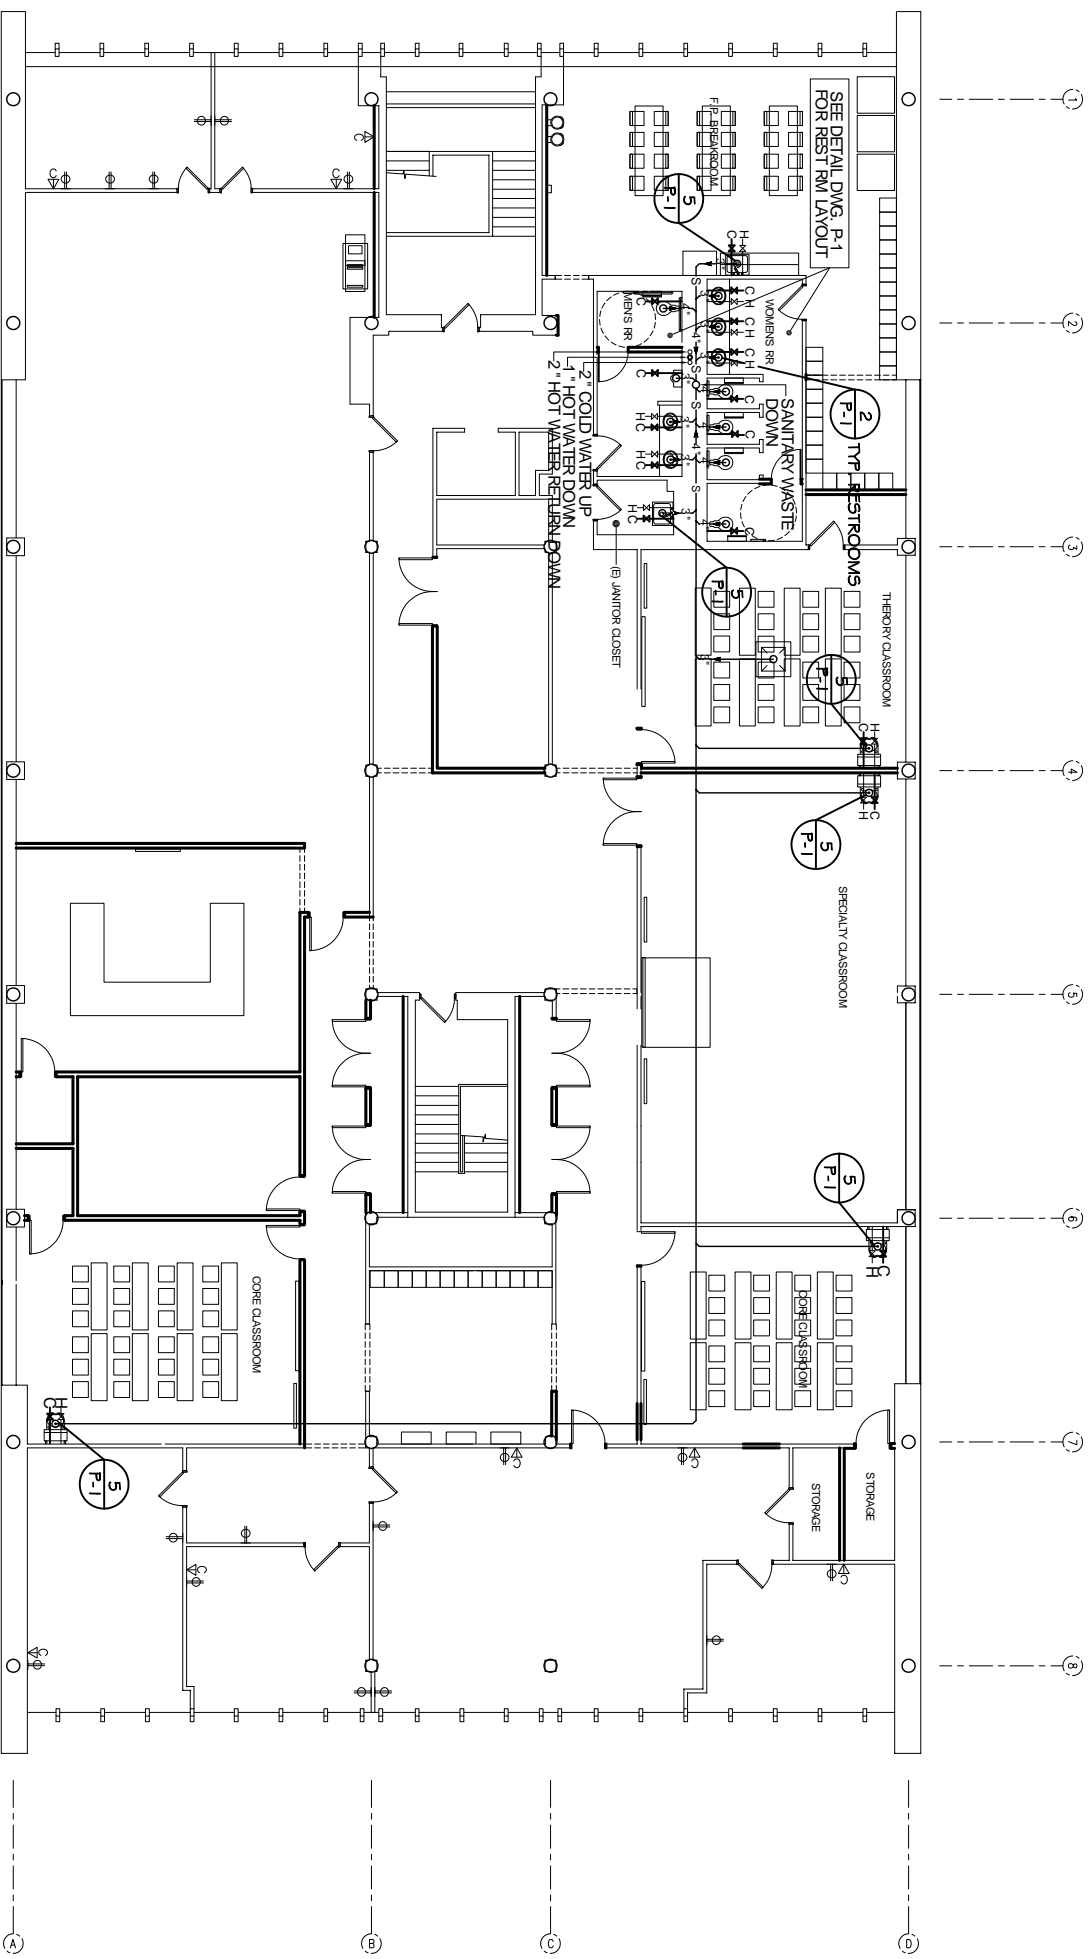

PLUMBING LEGEND

- S ————— SANITARY WASTE PIPING
- C ————— COLD WATER SUPPLY PIPING
- HWR ———— HOT WATER RETURN PIPING
- H ———— HOT WATER SUPPLY PIPING (1.40°)
- THW ———— TEMPERED HOT WATER PIPING (1.10°)
- G ————— GAS PIPING
- Ball Valve Symbol — BALL VALVE
- Globe Valve Symbol — GLOBE VALVE
- Gas Cook Symbol — GAS COOK
- Check Valve Symbol — CHECK VALVE
- Floor Drain Symbol — FLOOR DRAIN
- Floor Drain in Floor Symbol — FLOOR DRAIN IN FLOOR
- Wall Clean Out Symbol — WALL CLEAN OUT

THIRD FLOOR PLUMBING PLAN
SCALE: 1/8" = 1'

