

**DAMMON
ENGINEERING, INC.**

CHIEF ENGINEER
EMMETT
DAMMON, P.E.

CHIEF ARCHITECT
ROBERT
WILTSE

1095 FLORIDA AVENUE
SLIDELL, LA. 70458
OFFICE: 985-649-5832
FAX: 985-641-5950

WEBSITE:
WWW.DAMMONENGINEERING.COM

EMAIL:
DAMMONENG@BELLSOUTH.NET

ARCHITECTURE

ENGINEERING

STUDIES


PLANNING

INVESTIGATION

EXPERT WITNESS

PAUL MITCHELL
SCHOOL
3321 HESSMER AVE
METAIRIE, LA
70002

FIRST FLOOR
POWER PLAN

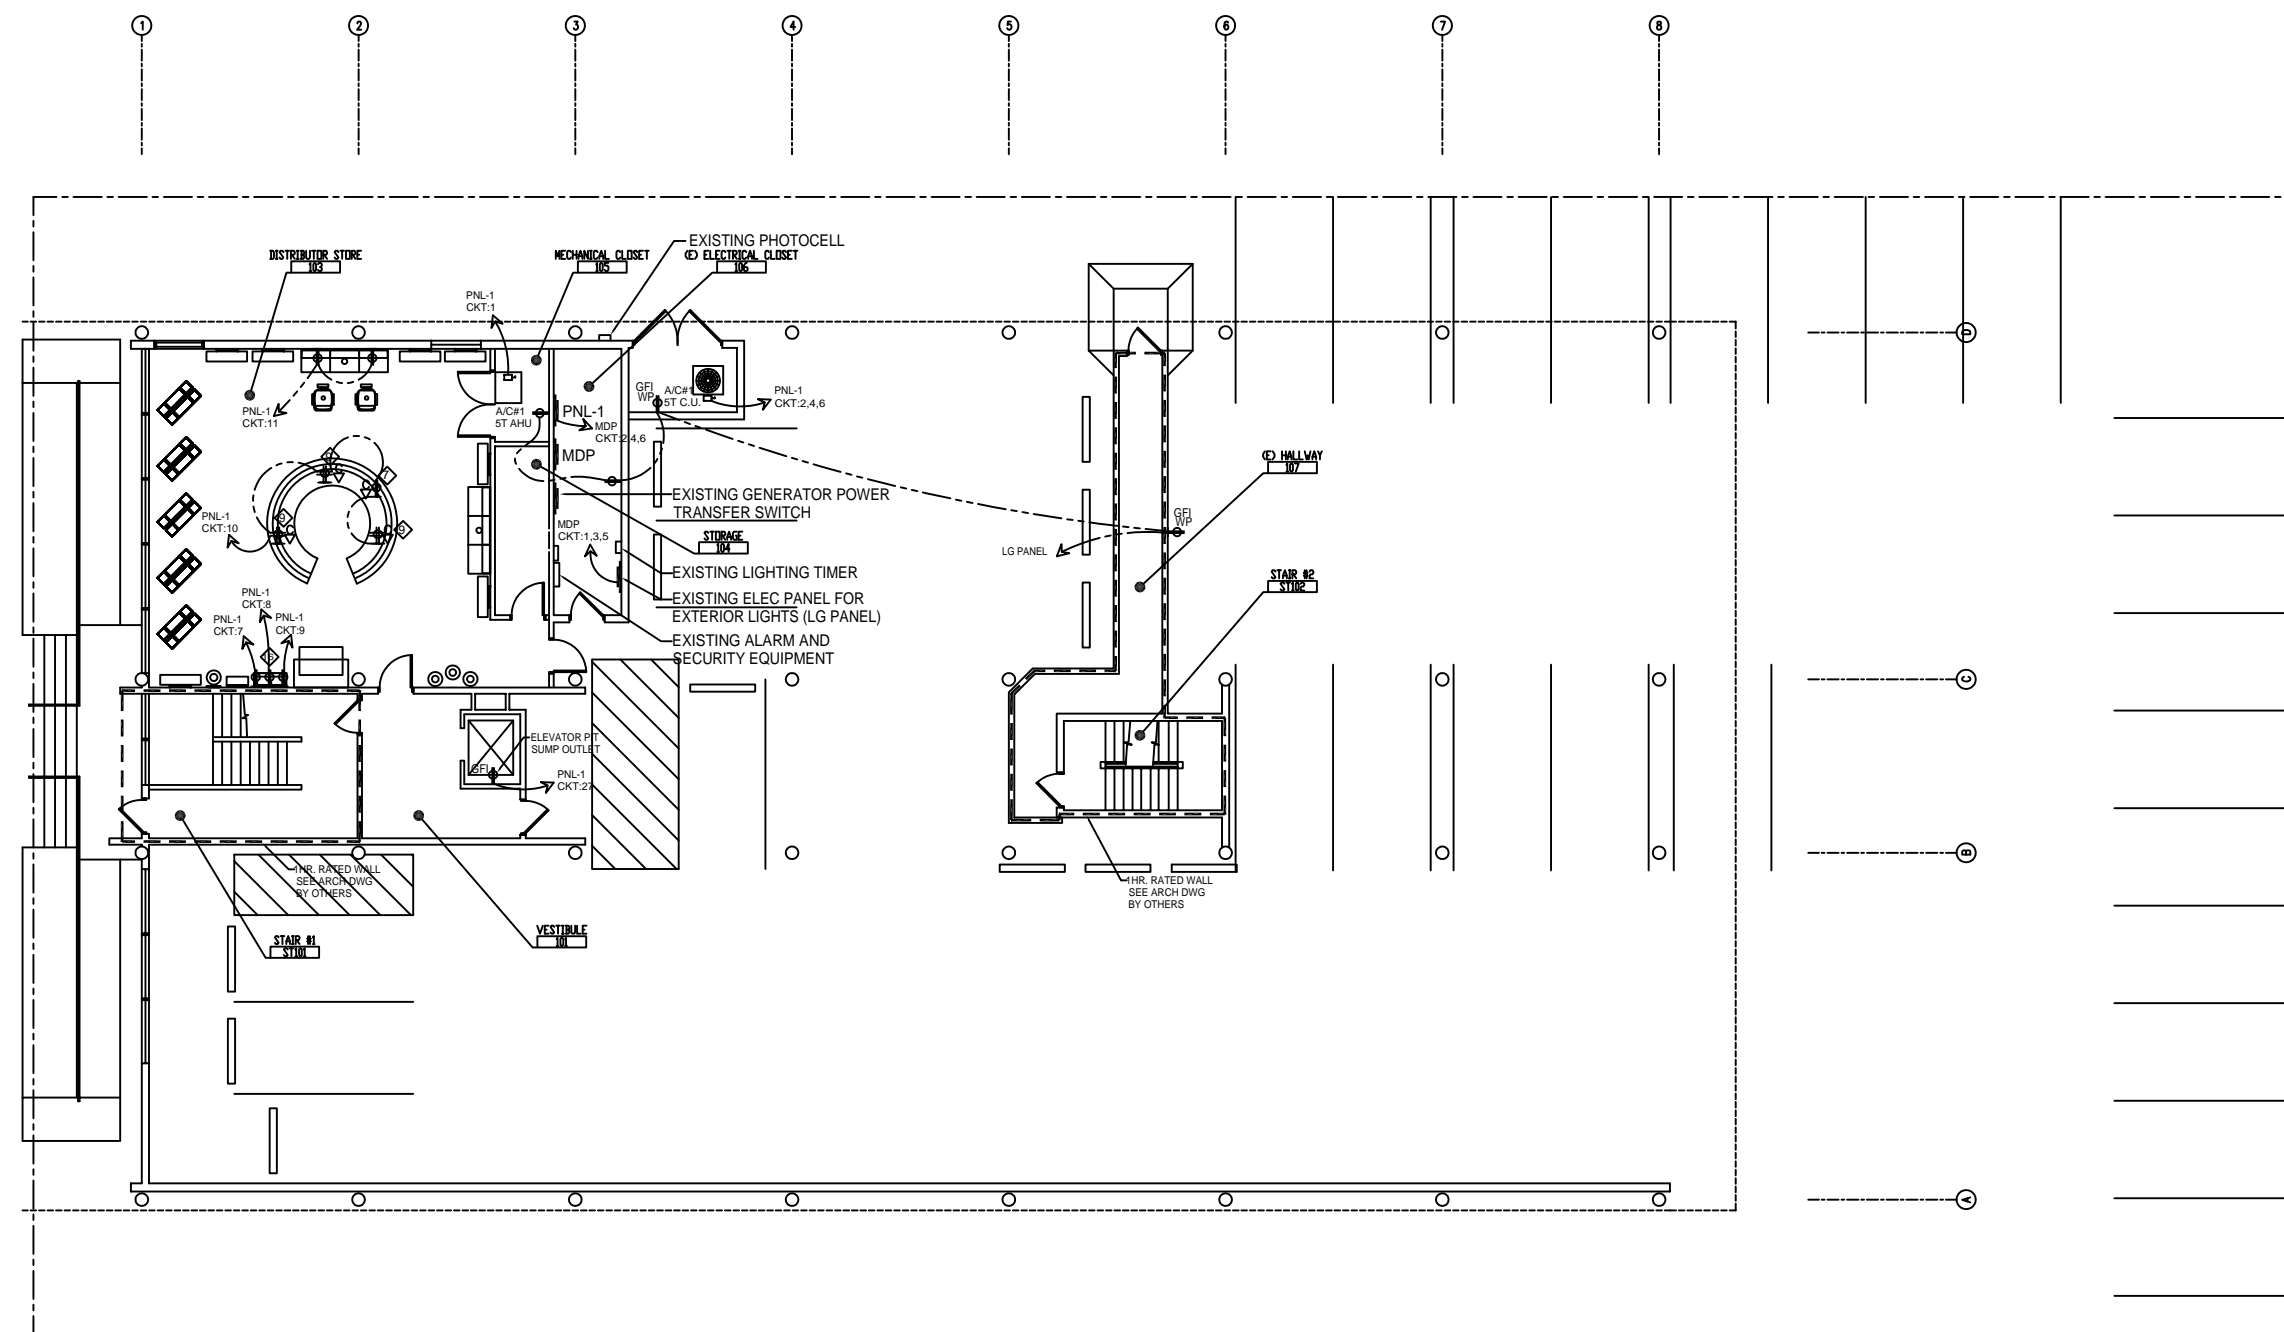

FIRST FLOOR POWER PLAN
SCALE: 1/8"=1'

FOR GENERAL ELECTRIC NOTES SEE SHEET E-9
FOR ELECTRIC PANEL SCHEDULES SEE SHEET E-8

- SPECIALTY NOTES**
- 7 PROVIDE POWER AND NETWORK CONNECTION FOR OWNER PROVIDED COPIER/PRINTER; VERIFY EQUIPMENT WITH OWNER.
 - 9 PROVIDE POWER AND NETWORK CONNECTION FLOOR BOXES FOR OWNER PROVIDED COMPUTERS AND POINT OF SALE EQUIPMENT; VERIFY EQUIPMENT WITH OWNER. VERIFY EXACT LOCATION WITH WADSWORTH DESIGN.
 - 16 WALL MOUNTED TOOL BAR BY WADSWORTH DESIGN; 3 OUTLETS WITH DEDICATED CIRCUITS REQ

POWER LEGEND

	WALL MOUNTED FLUSH J-BOX		FLUSH MOUNTED RECESSED JUNCTION BOX
	DUPLEX CONVENIENCE OUTLET		CEILING MOUNTED OUTLET
	GROUND FAULT INDICATOR (GFI) RECEPTICAL.		DATA CONNECTION. VERIFY WITH AV CONSULTANT AND COMPUTER, PHONE PROVIDER.
	EXTERIOR WALL MOUNTED WATER RESISTANT CONVENIENCE OUTLET. PROVIDE GROUND FAULT INDICATOR (GFI), TYPICAL.		ELECTRIC PANEL
	HALF SWITCHED CONVENIENCE OUTLET		DISCONNECT
	FOURPLEX CONVENIENCE OUTLET		
	FLOOR MOUNTED DUPLEX CONVENIENCE OUTLET		
	FLOOR MOUNTED FOURPLEX CONVENIENCE OUTLET		

REV:
SCALE: AS NOTED
JOB#:2051
DATE: 01-04-10
SHEET

E-1

NOT APPROVED FOR CONSTRUCTION

OF