

**DAMMON ENGINEERING, INC.**

CHIEF ENGINEER  
EMMETT DAMMON, P.E.

CHIEF ARCHITECT  
ROBERT WILTSE

1095 FLORIDA AVENUE  
SLIDELL, LA. 70458  
OFFICE: 985-649-5832  
FAX: 985-641-5950


WEBSITE:  
WWW.DAMMONENGINEERING.COM

EMAIL:  
DAMMONENG@BELLSOUTH.NET

- ARCHITECTURE
- ENGINEERING
- STUDIES
- PLANNING
- INVESTIGATION
- EXPERT WITNESS

PAUL MITCHELL  
SCHOOL  
3321 HESSMER AVE.  
METAIRIE, LA  
70002

**THIRD FLOOR POWER PLAN**

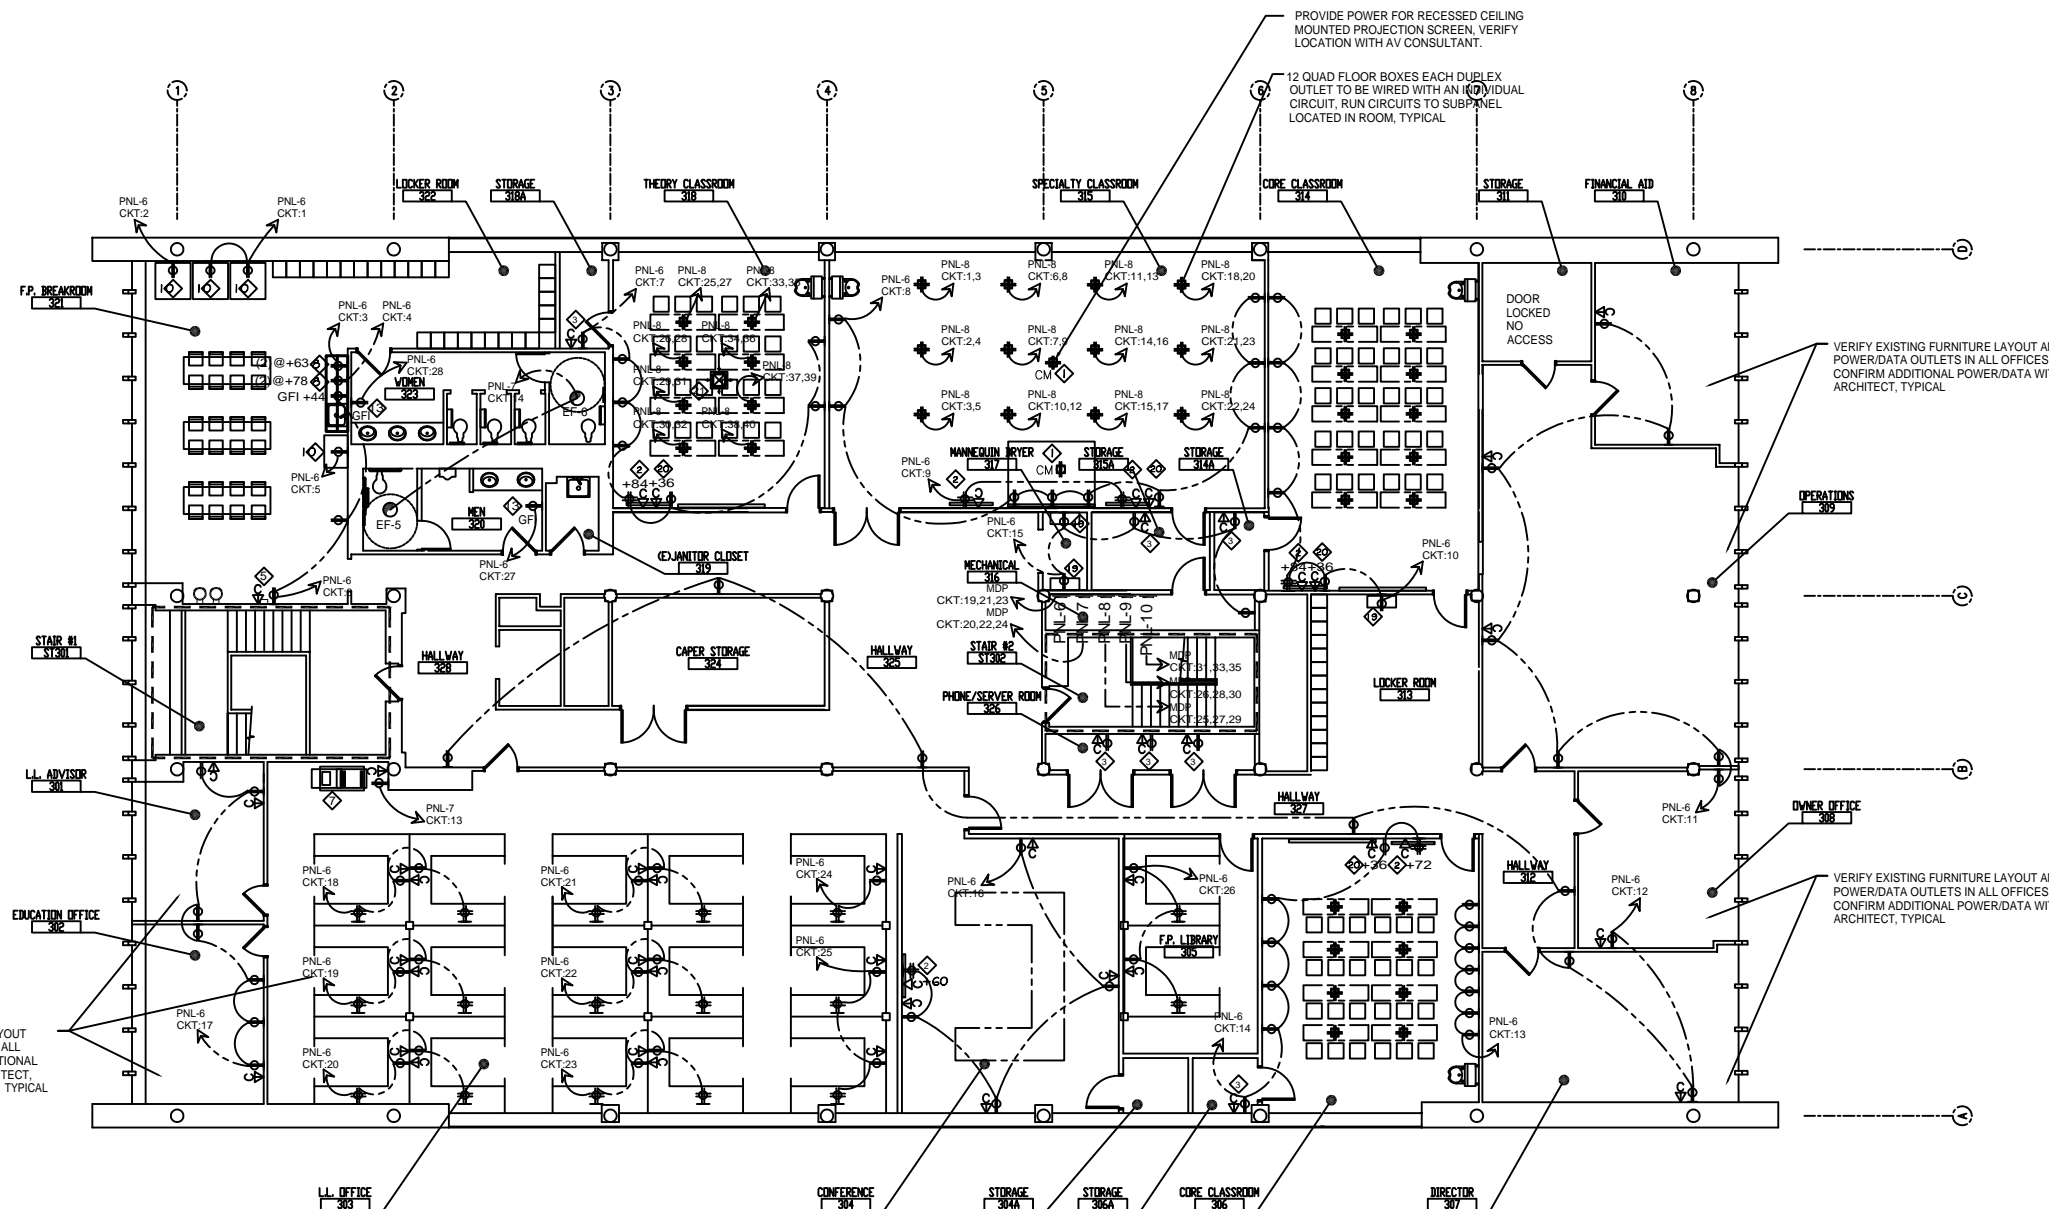

**THIRD FLOOR POWER PLAN**  
SCALE: 1/8"=1'

FOR GENERAL ELECTRIC NOTES SEE SHEET E-9  
FOR ELECTRIC PANEL SCHEDULES SEE SHEET E-8

**SPECIALTY NOTES**

- 1 CEILING RECEPTACLE PROVIDED WITH AV PROJECTOR CEILING MOUNT PANEL.
- 2 PROVIDE CABLE AND QUAD RECEPTACLE FOR FLATSCREEN TELEVISION, COORDINATE MOUNTING HEIGHT WITH A.V. CONSULTANT
- 3 AV RACK FOR EQUIPMENT LOCATED IN CLOSET, COORDINATE EXACT POWER REQUIREMENT AND LOCATION WITH AV CONSULTANT.
- 5 VERIFY POWER AND DATA REQUIREMENTS FOR TIME CLOCK, COORDINATE LOCATION WITH OWENER.
- 7 PROVIDE POWER AND NETWORK CONNECTION FOR OWNER PROVIDED COPIER/PRINTER; VERIFY EQUIPMENT WITH OWNER.
- 8 PROVIDE 2 DUPLEX OUTLETS, EACH WITH A DEDICATED CIRCUIT FOR 2 MICROWAVES. COORDINATE HEIGHTS WITH WALL SHELVES FOR MICROWAVES. (2) AT 63" AFF AND (2) AT 78" AFF VERIFY WITH WADSWORTH DESIGN.
- 10 PROVIDE POWER FOR OWNER PROVIDED REFRIDGERATORS AND VENDING MACHINES; VERIFY EQUIPMENT WITH OWNER.
- 13 ELECTRIC HAND DRYER, REFER TO SHEET A401 AND A402 FOR DETAILS.
- 19 PROVIDE POWER FOR MANNEQUIN DRYER CABINET; VERIFY EQUIPMENT WITH OWNER.
- 20 PROVIDE POWER AND DATA FOR LAPTOP OVER RIDE. VERIFY EXACT REQUIREMENTS AND LOCATION WITH AV CONSULTANT. (LOCATE DIRECTLY UNDER LCD SCREEN)
- 21 PROVIDE POWER FOR DUCTLESS AIR CONDITIONER FROM CONDENSING UNIT LOCATED ON ROOF.

**POWER LEGEND**

	WALL MOUNTED FLUSH J-BOX		FLUSH MOUNTED RECESSED JUNCTION BOX
	DUPLEX CONVENIENCE OUTLET		CEILING MOUNTED OUTLET
	GROUND FAULT INDICATOR (GFI) RECEPTACLE		DATA CONNECTION. VERIFY WITH AV CONSULTANT AND COMPUTER, PHONE PROVIDER.
	EXTERIOR WALL MOUNTED WATER RESISTANT CONVENIENCE OUTLET. PROVIDE GROUND FAULT INDICATOR (GFI), TYPICAL.		(2) CIRCUITS AT EACH STYLING STATION STUBBED THROUGH CONDUIT IN THE FLOOR. INSTALL FOURPLEX RECEPTACLE IN PRE-INSTALLED JUNCTION BOX IN STYLING STATION
	HALF SWITCHED CONVENIENCE OUTLET		ELECTRIC PANEL
	FOURPLEX CONVENIENCE OUTLET		DISCONNECT
	FLOOR MOUNTED DUPLEX CONVENIENCE OUTLET		
	FLOOR MOUNTED FOURPLEX CONVENIENCE OUTLET		

**NOT APPROVED FOR CONSTRUCTION**

REV:

SCALE: AS NOTED

JOB#:2051

DATE: 01-04-10

SHEET

**E-3**

OF