

**DAMMON
ENGINEERING, INC.**

CHIEF ENGINEER
EMMETT
DAMMON, P.E.

CHIEF ARCHITECT
ROBERT
WILTSE

1095 FLORIDA AVENUE
SLIDELL, LA. 70458
OFFICE: 985-649-5832
FAX: 985-641-5950

WEBSITE:
WWW.DAMMONENGINEERING.COM

EMAIL:
DAMMONENG@BELLSOUTH.NET

ARCHITECTURE

ENGINEERING

STUDIES

PLANNING

INVESTIGATION

EXPERT WITNESS

PAUL MITCHELL
SCHOOL
3321 HESSMER AVE.
METAIRIE, LA
70002

POWER PLAN
ROOF

REV:

SCALE: AS NOTED


JOB#:2051

DATE: 01-04-10

SHEET

E-4

OF

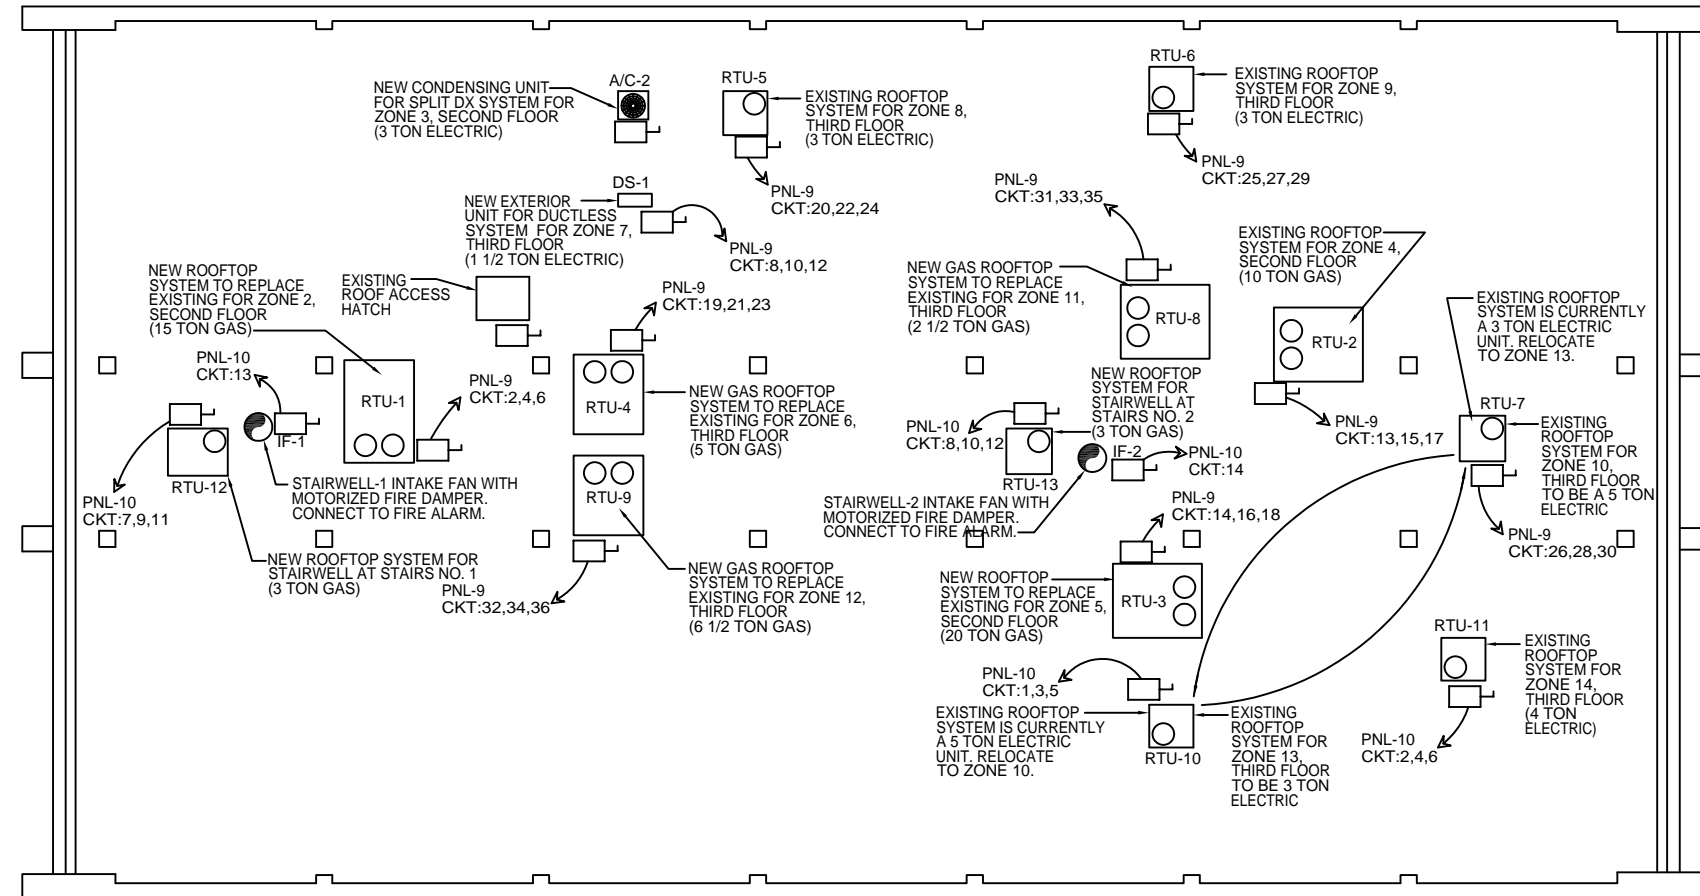

POWER ROOF PLAN

SCALE: 1/8"=1'



FOR GENERAL ELECTRIC NOTES SEE SHEET E-9
FOR ELECTRIC PANEL SCHEDULES SEE SHEET E-8

POWER LEGEND

	WALL MOUNTED FLUSH J-BOX		FLUSH MOUNTED RECESSED JUNCTION BOX
	DUPLEX CONVENIENCE OUTLET		CEILING MOUNTED OUTLET
	GROUND FAULT INDICATOR (GFI) RECEPTICAL		DATA CONNECTION. VERIFY WITH AV CONSULTANT AND COMPUTER, PHONE PROVIDER.
	EXTERIOR WALL MOUNTED WATER RESISTANT CONVENIENCE OUTLET. PROVIDE GROUND FAULT INDICATOR (GFI), TYPICAL.		(2) CIRCUITS AT EACH STYLING STATION STUBBED THROUGH CONDUIT IN THE FLOOR. INSTALL FOURPLEX RECEPTACLE IN PRE-INSTALLED JUNCTION BOX IN STYLING STATION
	HALF SWITCHED CONVENIENCE OUTLET		ELECTRIC PANEL
	FOURPLEX CONVENIENCE OUTLET		DISCONNECT
	FLOOR MOUNTED DUPLEX CONVENIENCE OUTLET		
	FLOOR MOUNTED FOURPLEX CONVENIENCE OUTLET		

NOT APPROVED FOR CONSTRUCTION