
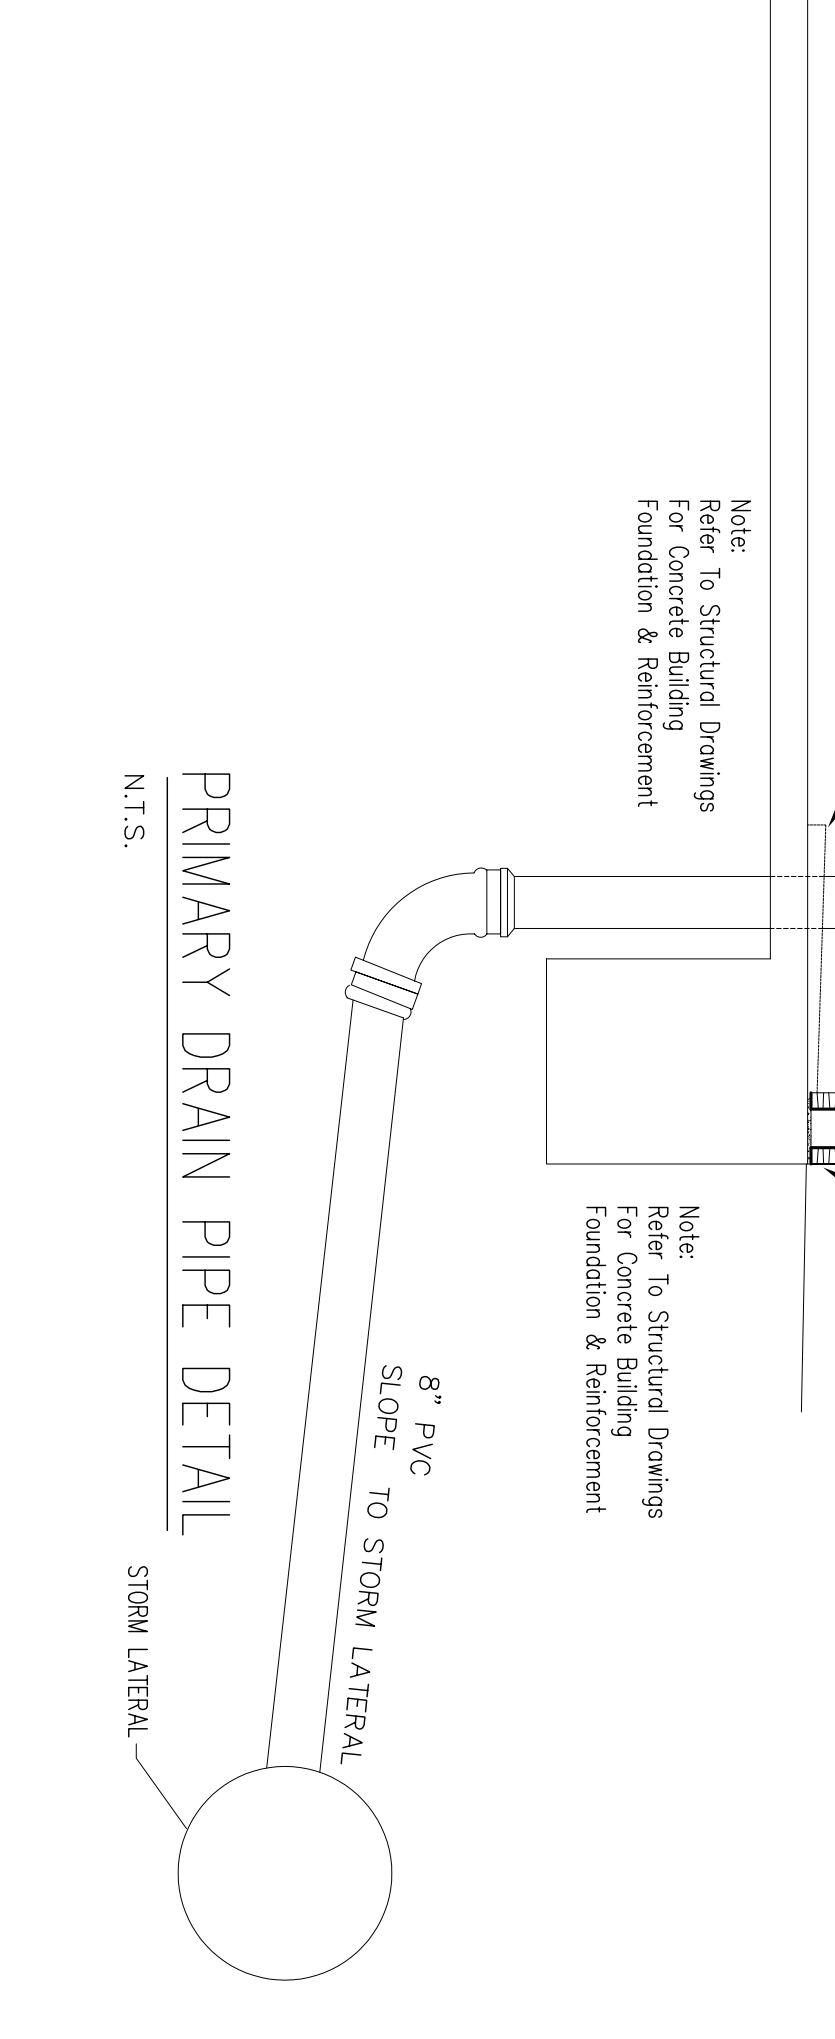
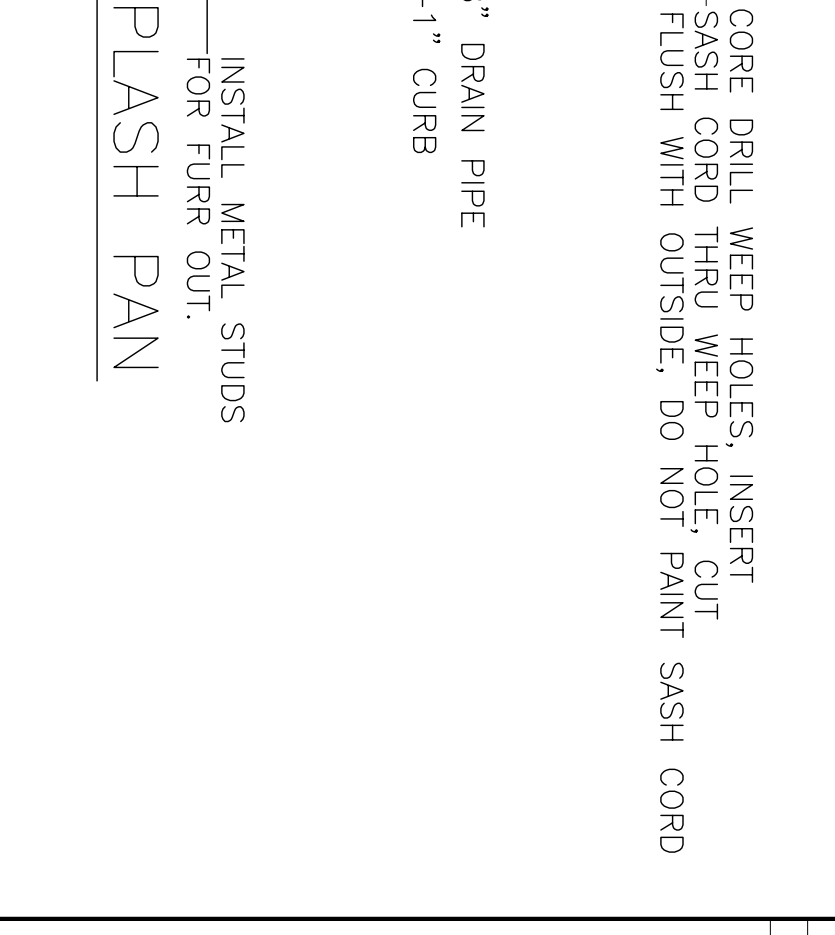
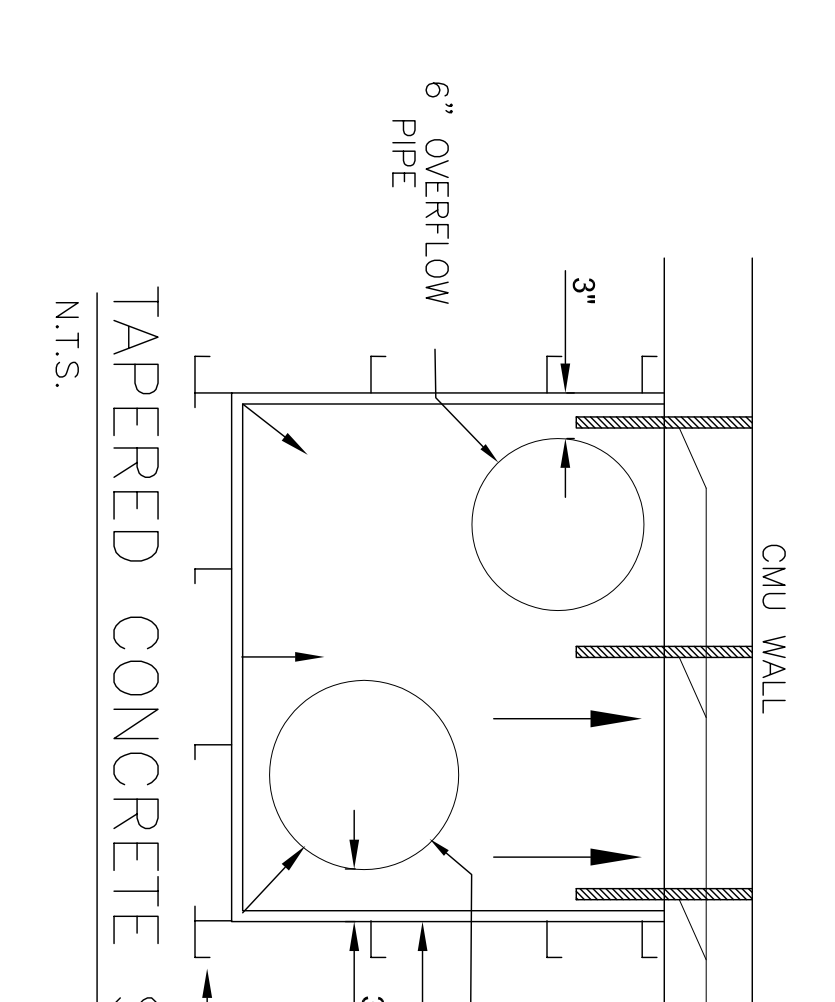
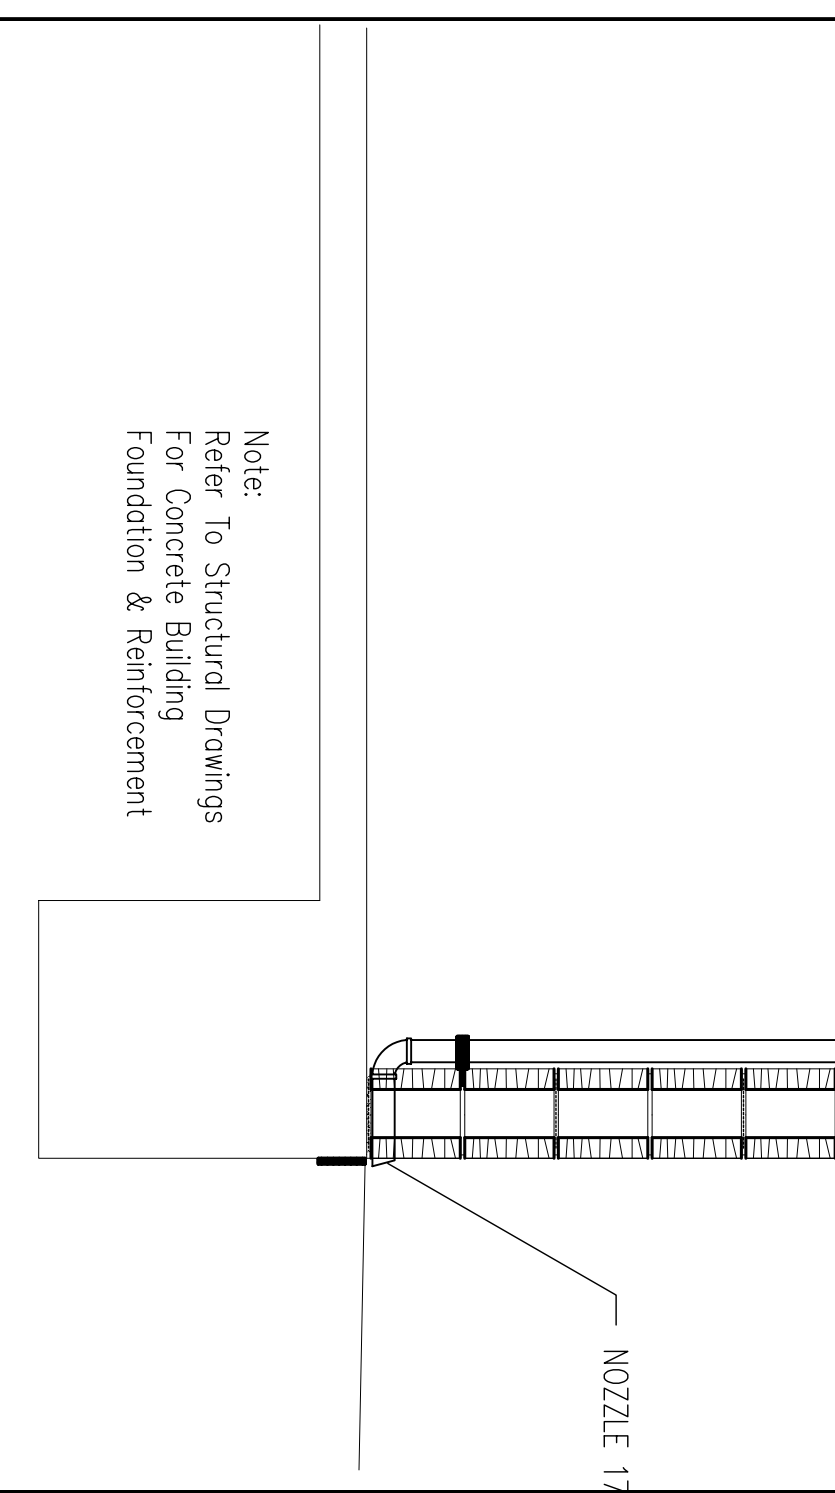
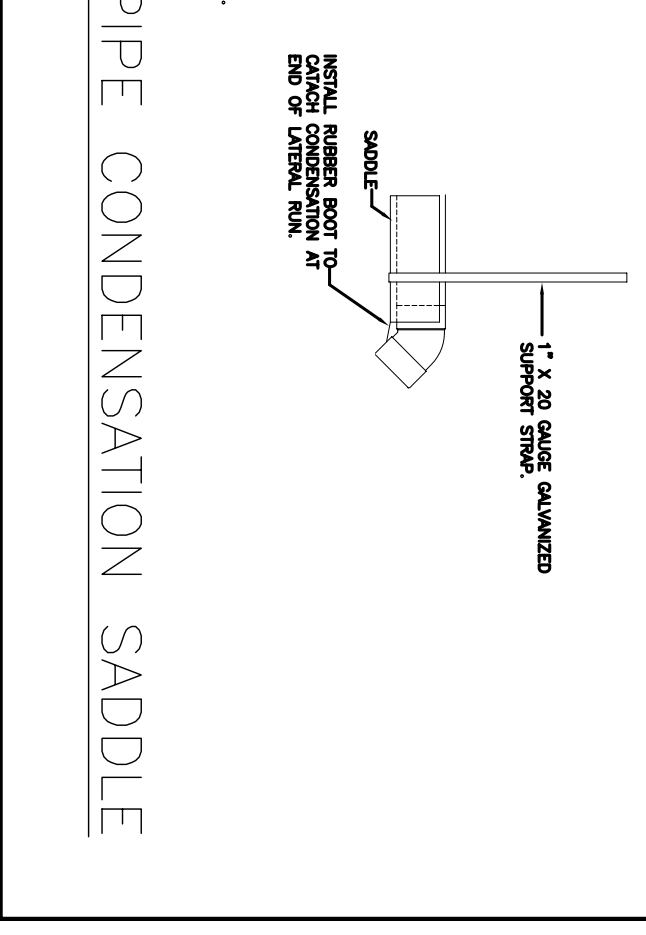
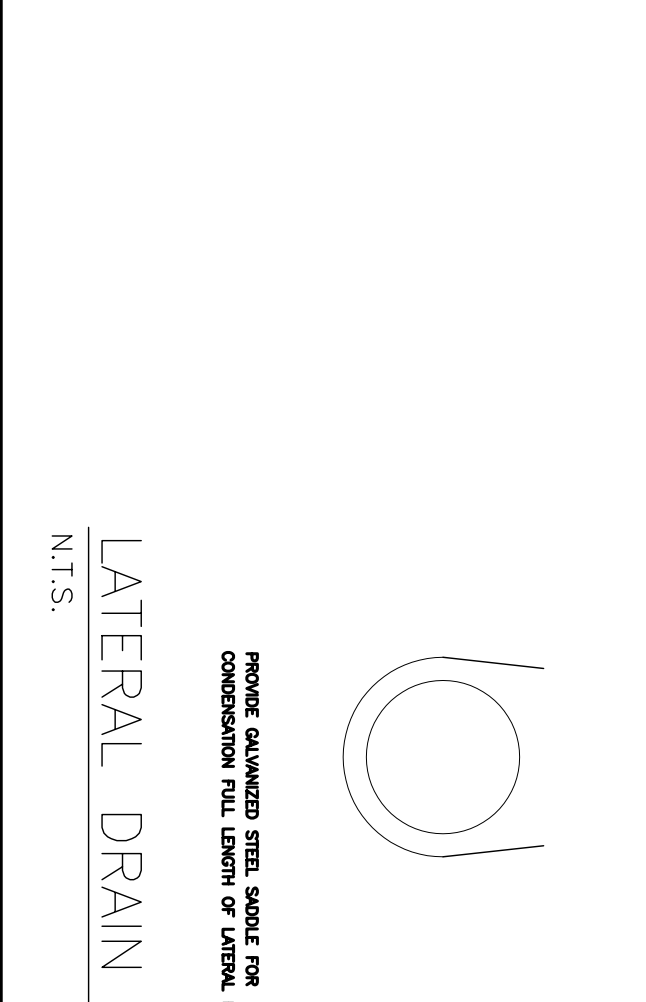
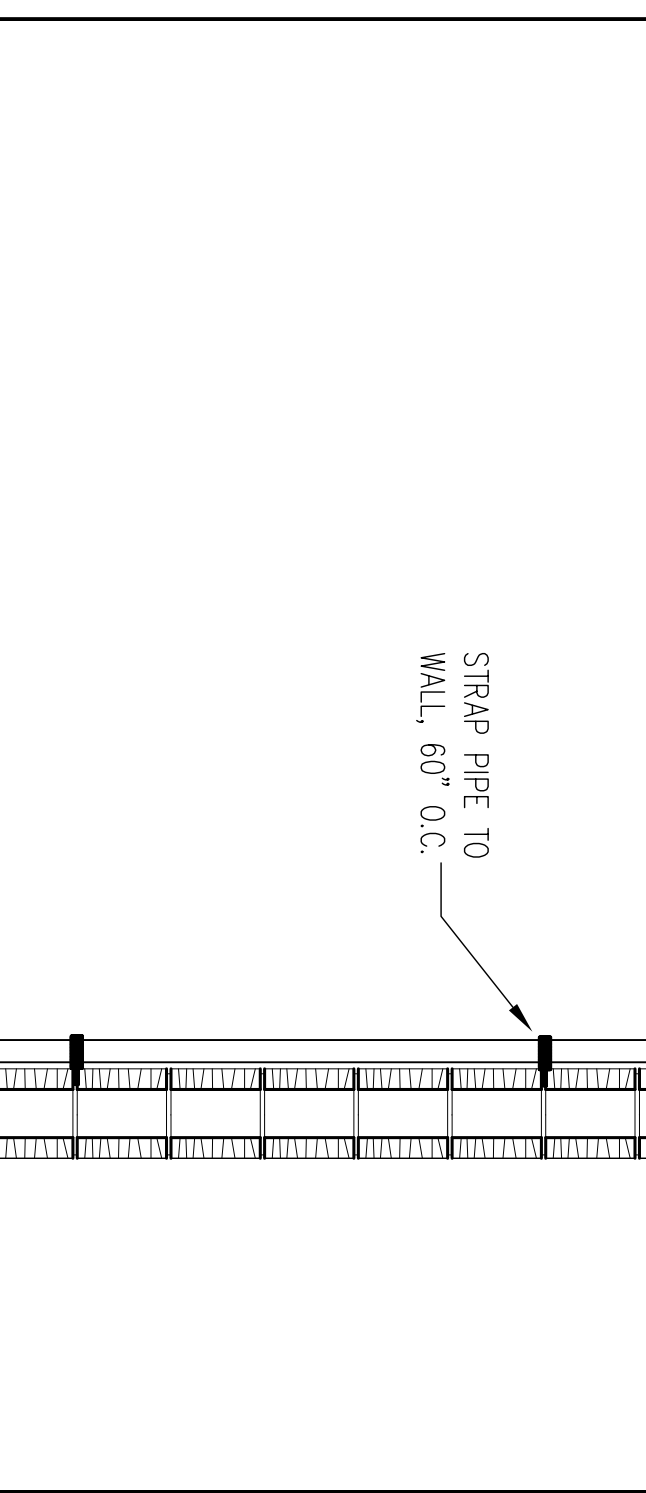
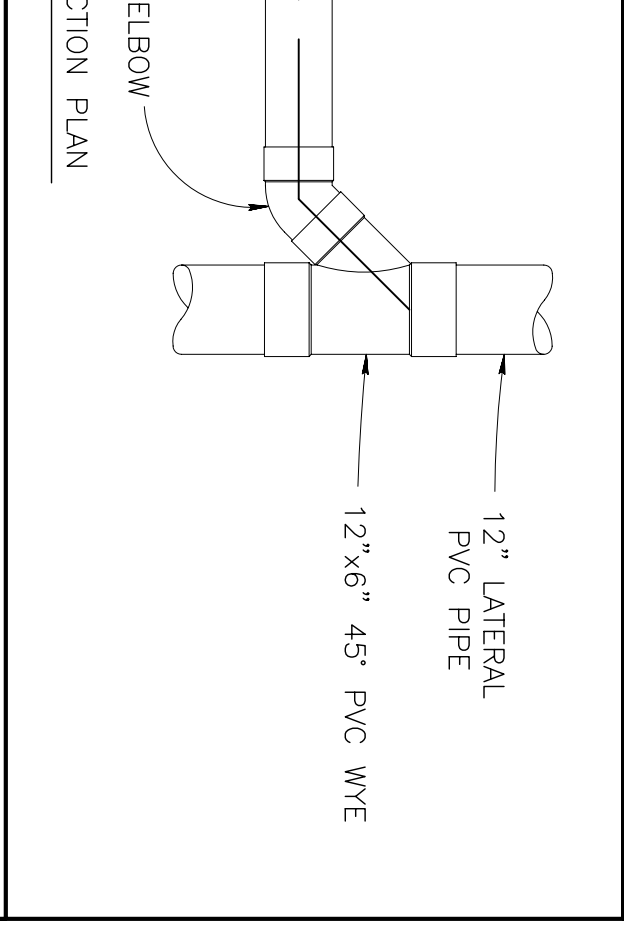
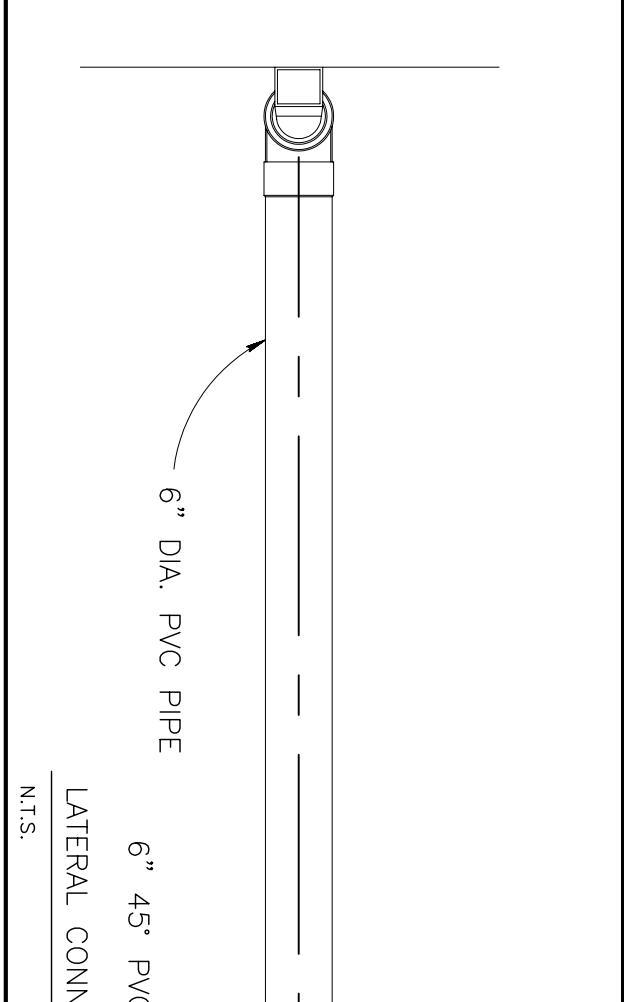
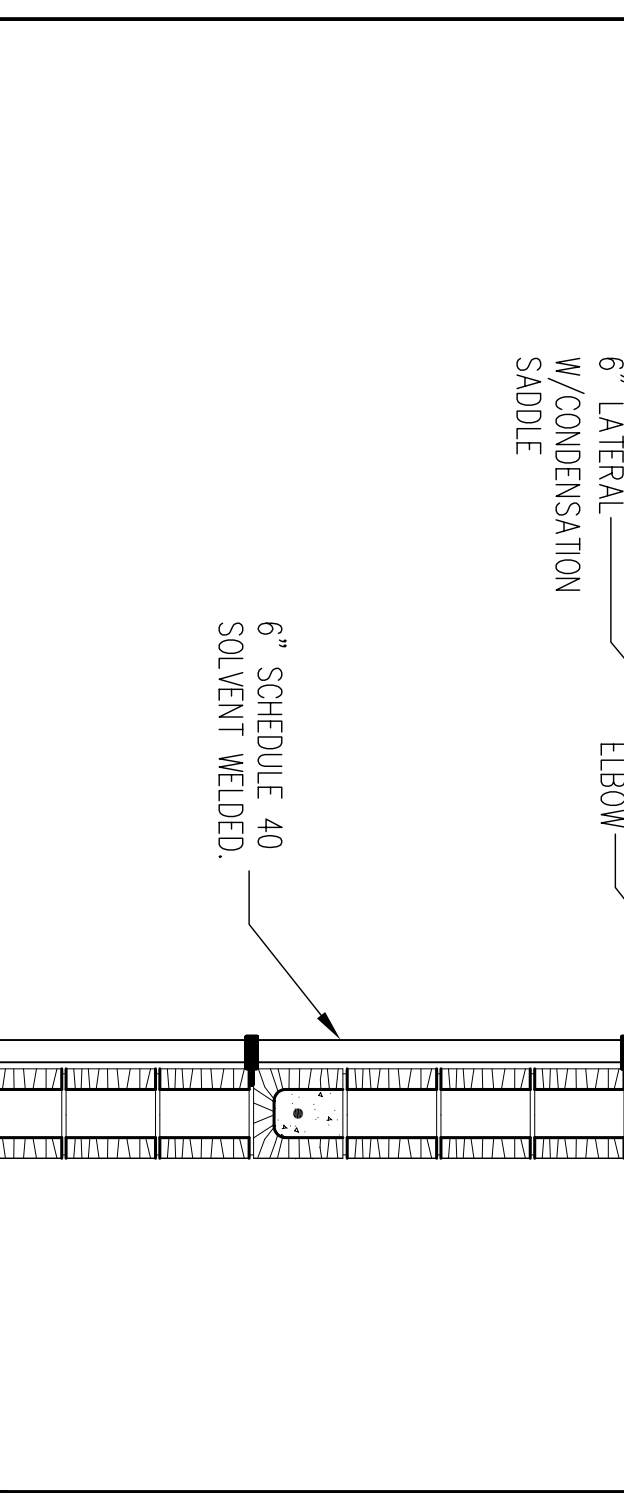
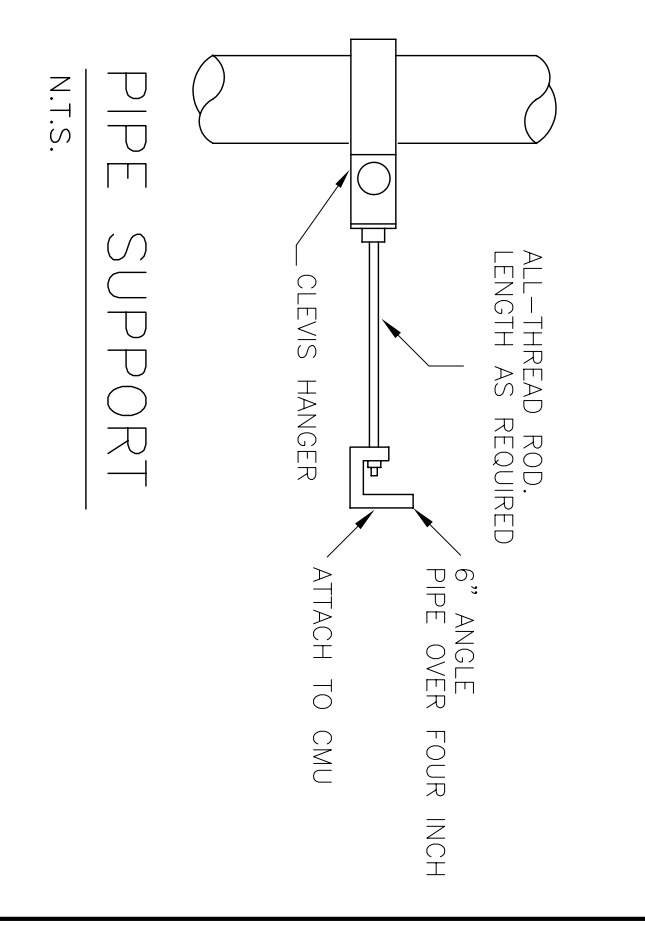
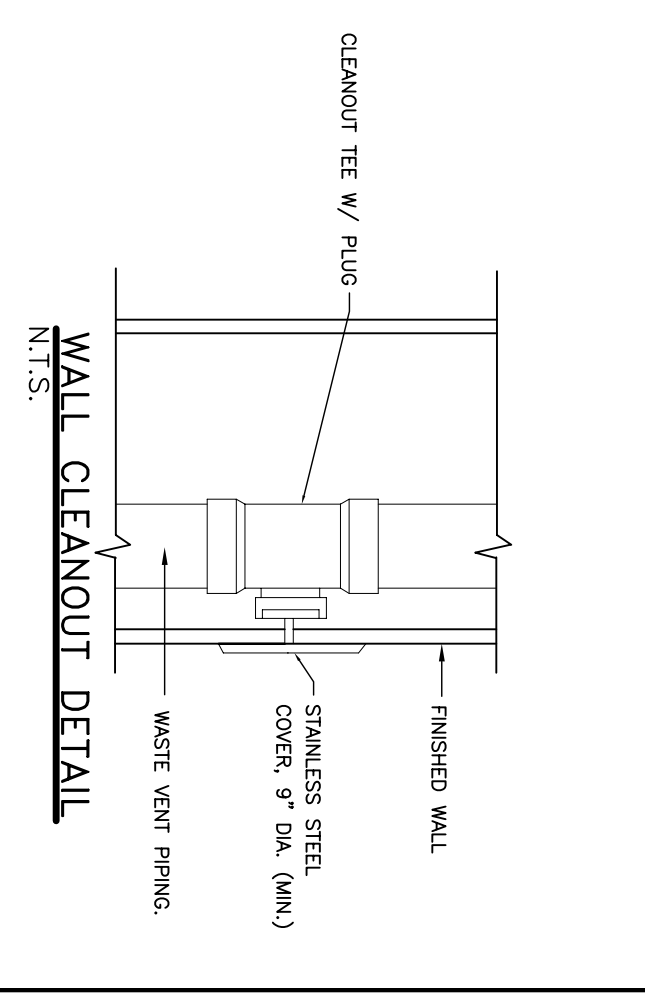


ROOFTOP DRAINAGE PLAN
SCALE: 1/8" = 1'-0"

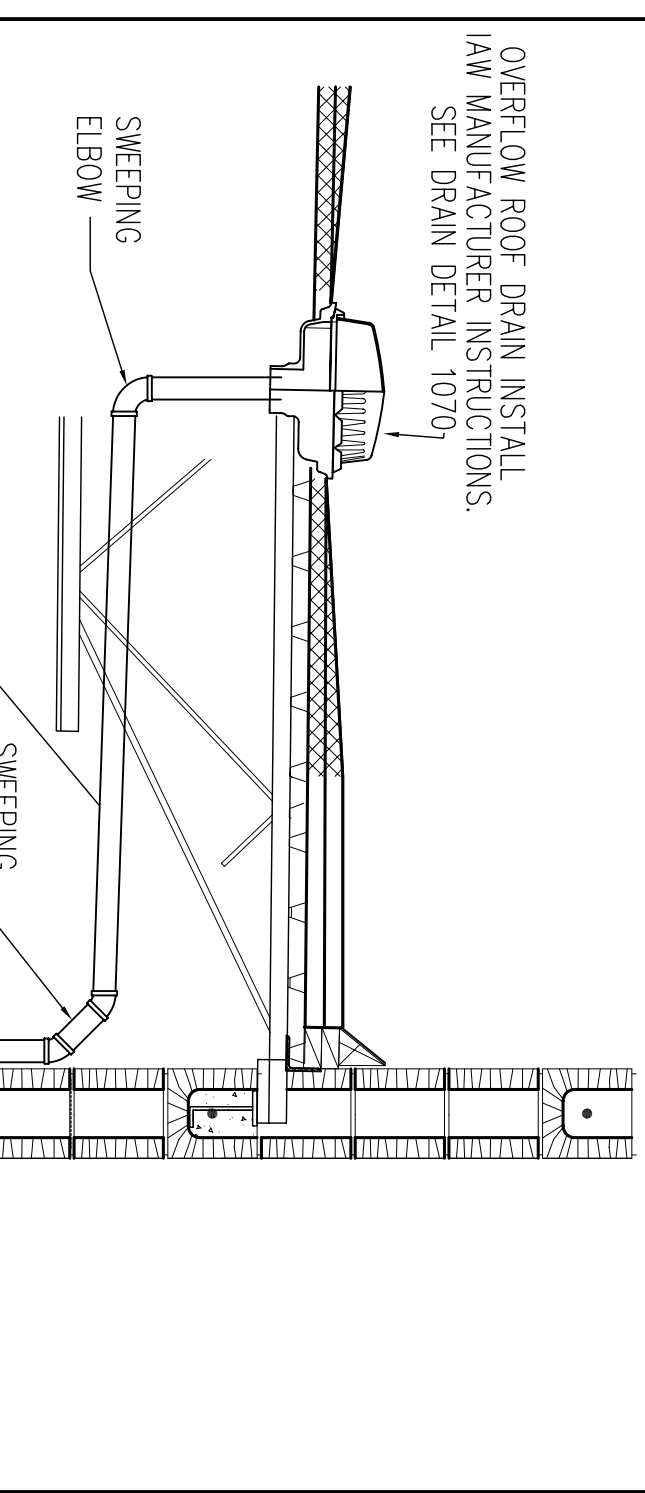

OVERFLOW ROOF DRAIN INSTALL
SEE DRAIN DETAIL 1070

SWEEPING ELBOW

6" LATERAL W/ CONDENSATION SADDLE

6" SCHEDULE 40 SOLVENT WELDED

STRAP PIPE TO WALL, 60" O.C.

NOZZLE 1"

Note:
Refer to Structural Drawings For Concrete Building Foundation & Reinforcement

CLEANOUT TEE W/ PLUG

FINISHED WALL

STAINLESS STEEL COVER, 9" DIA. (MIN.)

WASTE VENT PIPING

WALL CLEANOUT DETAIL
N.T.S.

ALL-THREAD ROD, LENGTH AS REQUIRED

6" ANGLE PIPE OVER FOUR INCH

ATTACH TO CMU

PIPE SUPPORT
N.T.S.

6" DIA. PVC PIPE

6" 45° PVC ELBOW

12"x6" 45° PVC WYE

LATERAL CONNECTION PLAN
N.T.S.

REMOVE GALVANIZED STEEL SADDLE FOR CONDENSATION FULL LENGTH OF LATERAL PIPE

1" & 2" GALVANIZED STEEL SADDLE

INSTALL SASH CORD TO DIA. OF LATERAL PIPE

LATERAL DRAIN PIPE CONDENSATION SADDLE
N.T.S.

CMU WALL

3"

6" OVERFLOW PIPE

8" DRAIN PIPE

1" CURB

3"

TAPERED CONCRETE SPLASH PAN
N.T.S.

INSTALL METAL STUDS FOR FURR CUT.

CORE DRILL WEEP HOLES, INSERT SASH CORD THRU WEEP HOLE, CUT FLUSH WITH OUTSIDE, DO NOT PAINT SASH CORD

PRIMARY ROOF DRAIN INSTALL
SEE DRAIN DETAIL 1020C W/ UNDERDECK CLAMP

8" LATERAL W/ CONDENSATION SADDLE

SWEEPING ELBOW

8" SCHEDULE 40 SOLVENT WELDED

CLEVIS HANGER 3" STANDOFF, 60" O.C.

DRILL WEEP HOLES FOR CONDENSATION

CLEANOUT WITH BRASS THREADED PLUG

CONSTRUCT A TAPERED CONCRETE SPLASH PAN

8" PVC SLOPE TO STORM LATERAL

STORM LATERAL

PRIMARY DRAIN PIPE DETAIL
N.T.S.

Note:
Refer to Structural Drawings For Concrete Building Foundation & Reinforcement

Note:
Refer to Structural Drawings For Concrete Building Foundation & Reinforcement

DAMMON ENGINEERING, INC.
 1095 FLORIDA AVE. OFFICE: (985) 649-5832
 SLIDELL, LA 70458 FAX: (985) 641-5950
 WEBSITE: WWW.DAMMONENGINEERING.COM
 EMAIL: DAMMONENG@BELLSOUTH.NET

ZITO·RUSSELL ARCHITECTS, P.C.
 820 S. UNIVERSITY BLVD. SUITE 2G MOBILE, AL. 36609
 PHONE (251) 343-6161 FAX (251) 343-5505

REVISIONS

DATE

FILE

SHEET

M-2

EMMETT & DAMMON, JR. ARCHITECTS, P.C. 955598 5/12/10

ROWLETT PLAZA
ROWLETT, TEXAS