


McMAIN HEALTH CLINIC RENOVATION AT ELEANOR McMAIN SECONDARY HIGH SCHOOL

5712 SOUTH CLAIBORNE AVENUE
NEW ORLEANS, LOUISIANA 70125
OPSB PROJECT # 2010-0787-0003

SET #22

JAHNCKE & BURNS
ARCHITECTS, LLC
3516 MAGAZINE STREET
NEW ORLEANS, LA 70115
Tel: 504-899-6271
Fax: 504-899-6290

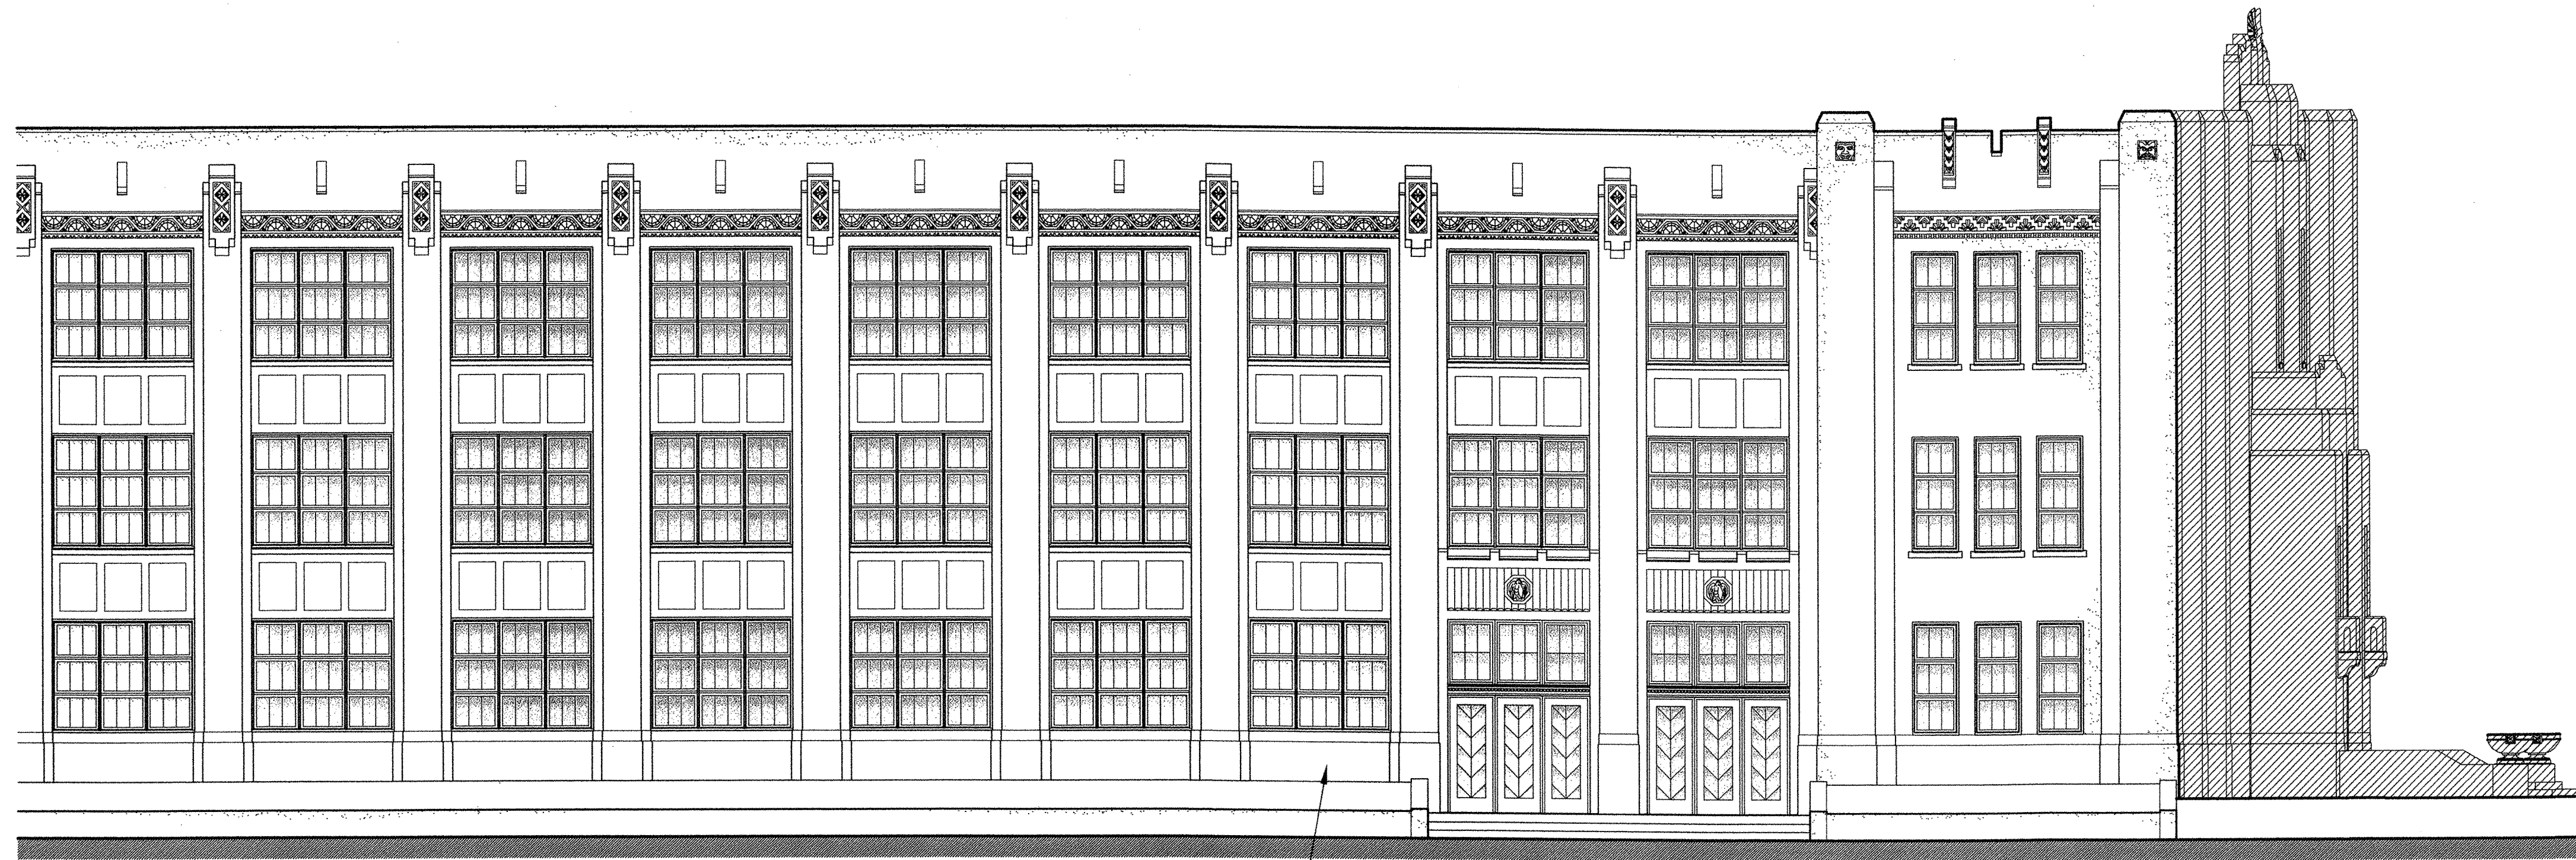

NEW CLINIC (AREA OF WORK INSIDE EXISTING BUILDING)
JOSEPH STREET ELEVATION

ORLEANS PARISH SCHOOL BOARD

IRA H. THOMAS SR. - DISTRICT 1
CYNTHIA CADE - DISTRICT 2
BRETT BONIN - DISTRICT 3
VICE-PRESIDENT, LOURDES MORAN - DISTRICT 4
SETH BLOOM - DISTRICT 5
WOODY KOPPEL - DISTRICT 6
PRESIDENT, THOMAS ROBICHAUX - DISTRICT 7
SUPERINTENDENT - DARRYL C. KILBERT

PROJECT TEAM


ARCHITECT

JAHNCKE & BURNS ARCHITECTS, LLC
3516 MAGAZINE STREET
NEW ORLEANS, LOUISIANA 70115
P: (504) 899 - 6271
F: (504) 899 - 6290
www.jahnckeburns.com

MECHANICAL, ELECTRICAL & PLUMBING ENGINEERS

MOSES ENGINEERS
909 POYDRAS STREET, SUITE 2150
NEW ORLEANS, LOUISIANA 70112
P: (504) 586 - 1725
F: (504) 586 - 1846
www.mosesengineers.com

LOCATION MAP

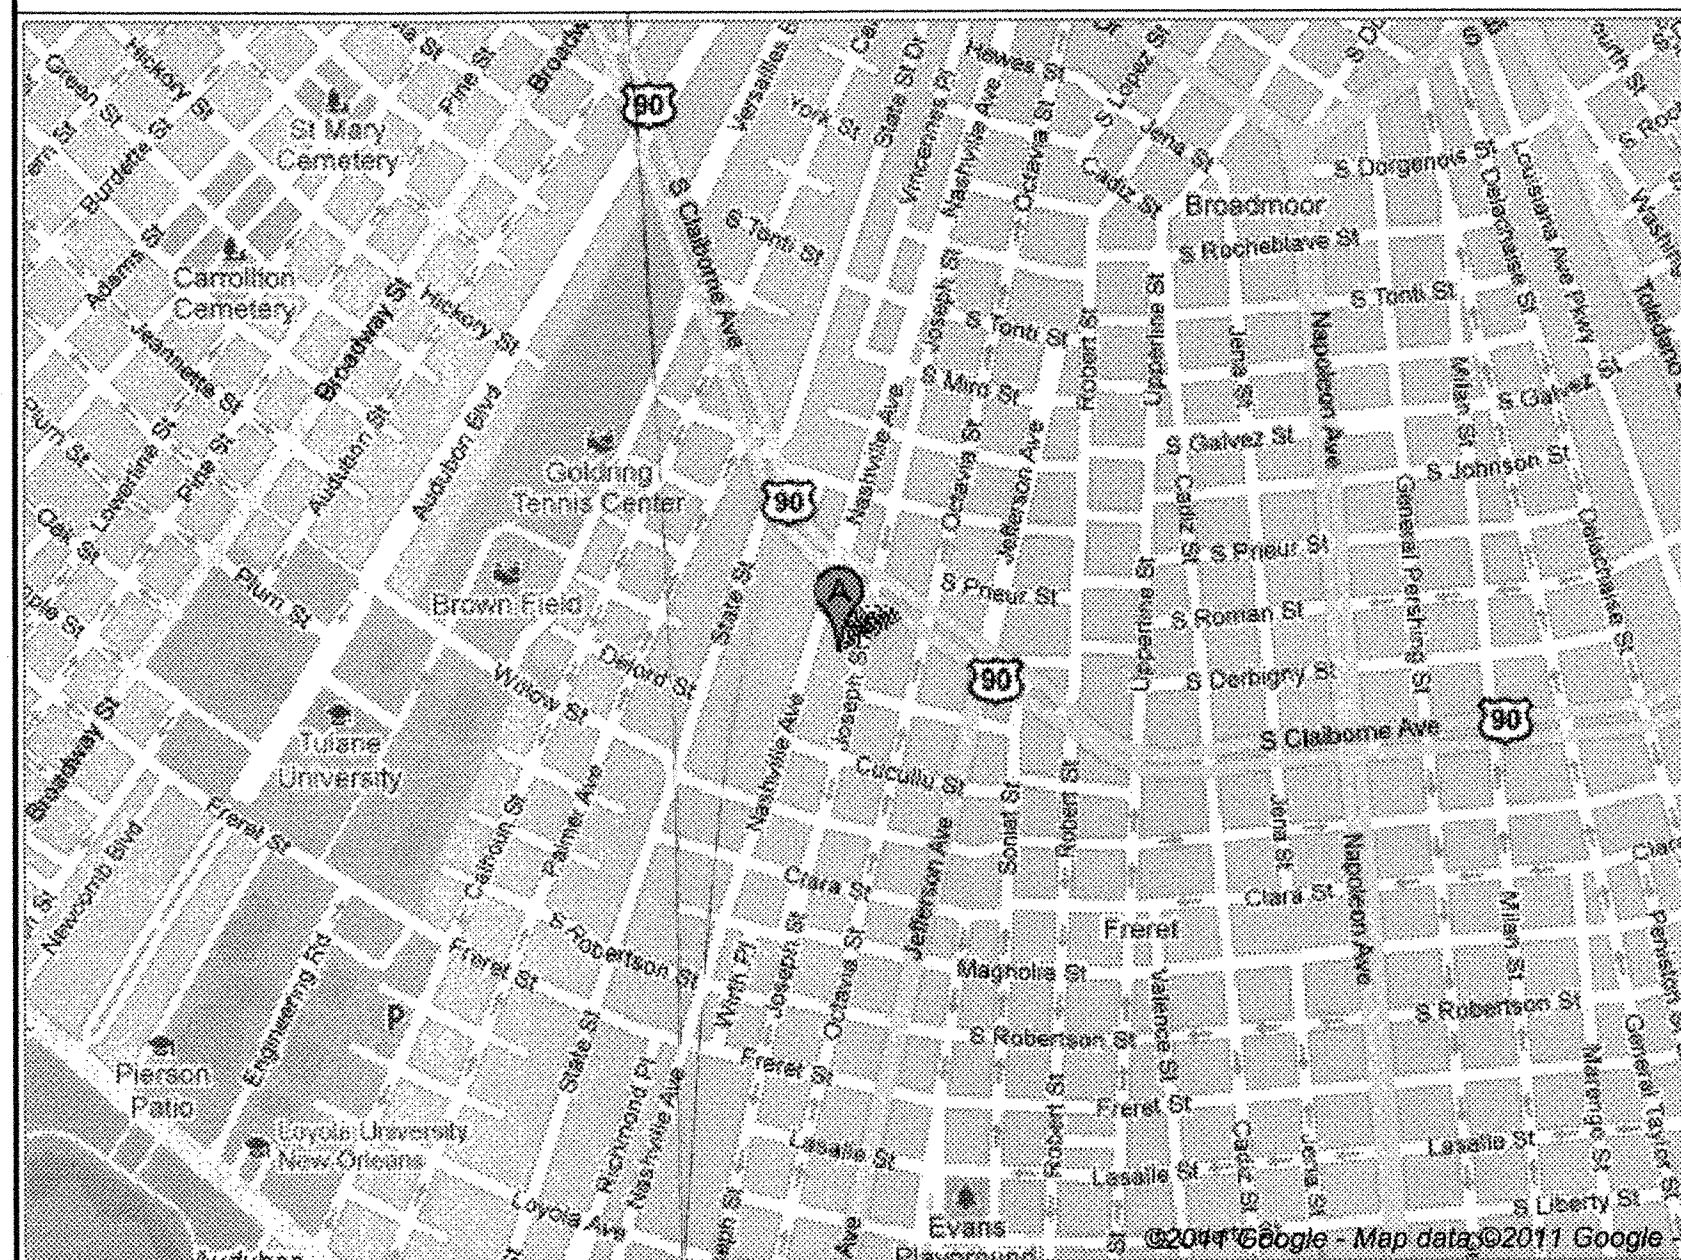

ABBREVIATIONS

#	- POUND OR NUMBER	ELEV	- ELEVATOR	MIN	- MINIMUM	TP	- TOILET PAPER DISPENSER
&	- AND	EPDM	- ETHYLENE PROPYLENE DIENE M-CLASS (ROOFING)	MRGWB	- MOISTURE-RESISTANT GYPSUM WALLBOARD	T/D	- TELEPHONE/DATA
@	- AT	EQ	- EQUAL	MTL	- METAL	TYP	- TYPICAL
ACT	- ACOUSTIC CEILING TILE	EWC	- ELECTRIC WATER COOLER	NIC	- NOT IN CONTRACT	UNO	- UNLESS NOTED OTHERWISE
AD	- AREA DRAIN	EXIST	- EXISTING	NO	- NUMBER	U/S	- UNDERSIDE
AFF	- ABOVE FINISHED FLOOR	EXP JT	- EXPANSION JOINT	NOM	- NOMINAL	VIF	- VERIFY IN FIELD
ALUM	- ALUMINUM	EXT	- EXTERIOR	OC	- ON CENTER	VP	- VISION PANEL
ANOD	- ANODIZED	FD	- FLOOR DRAIN	OH	- OPPOSITE HAND	W/	- WITH
BSMT	- BASEMENT	FEC	- FIRE EXTINGUISHER CABINET	OZ	- OUNCE	WD	- WOOD
BYND	- BEYOND	FIXT	- FIXTURE	PCC	- PRE-CAST CONCRETE	STC	- SOUND TRANSMISSION COEFFICIENT
BOT	- BOTTOM	FLR	- FLOOR	PLUMB	- PLUMBING	STL	- STEEL
CIP	- CAST IN PLACE	FM	- FILLED METAL	PLYD	- PLYWOOD	STRUCT	- STRUCTURAL
CHNL	- CHANNEL	FO	- FACE OF	PT	- PRESSURE TREATED	T&G	- TONGUE AND GROOVE
CJ	- CONTROL JOINT	FND	- FOUNDATION	PNT	- PAINT/PAINTED	TELE	- TELEPHONE
CLG	- CEILING	GA	- GAUGE	PVC	- POLYVINYL CHLORIDE	TLT	- TOILET
CLR	- CLEAR	GALV	- GALVANIZED	RBR	- RUBBER	TO	- TOP OF
CMU	- CONCRETE MASONRY UNIT	GWB	- GYPSUM WALL BOARD	RCP	- REFLECTED CEILING PLAN	TOC	- TOP OF CONCRETE
COL	- COLUMN	HC	- HOLLOW CORE	RD	- ROOF DRAIN	TOS	- TOP OF STEEL
COMPR	- COMPRESSIBLE	HI	- HIGH	REQD	- REQUIRED	TP	- TOILET PAPER DISPENSER
CONC	- CONCRETE	HM	- HOLLOW METAL	RM	- ROOM	T/D	- TELEPHONE/DATA
CONT	- CONTINUOUS	HP	- HIGH POINT	SIM	- SIMILAR	TYP	- TYPICAL
CPT	- CARPET	HR	- HOUR	SPEC	- SPECIFIED OR SPECIFICATION	UNO	- UNLESS NOTED OTHERWISE
CT	- CERAMIC TILE	HVAC	- HEATING, VENTILATING AND AIR CONDITIONING	SPK	- SPRINKLER	U/S	- UNDERSIDE
CTYD	- COURTYARD	IRGWB	- IMPACT RESISTANT GYPSUM WALLBOARD	SSTL	- STAINLESS STEEL	VIF	- VERIFY IN FIELD
DBL	- DOUBLE	ILO	- IN LIEU OF	STC	- SOUND TRANSMISSION COEFFICIENT	VP	- VISION PANEL
DEMO	- DEMOLISH	INSUL	- INSULATED	STL	- STEEL	W/	- WITH
DIA	- DIAMETER	INT	- INTERIOR	STRUCT	- STRUCTURAL	WD	- WOOD
DIMS	- DIMENSIONS	LO	- LOW	T&G	- TONGUE AND GROOVE		
DN	- DOWN	MAX	- MAXIMUM	TELE	- TELEPHONE		
DR	- DOOR	MO	- MASONRY OPENING	TLT	- TOILET		
DWG	- DRAWING	MECH	- MECHANICAL	TO	- TOP OF		
EA	- EACH	MEMBR	- MEMBRANE	TOC	- TOP OF CONCRETE		
EL	- ELEVATION			TOS	- TOP OF STEEL		
ELEC	- ELECTRICAL						

INDEX OF DRAWINGS

ARCHITECTURAL

T-1	TITLE SHEET, INDEX OF DWGS & PROJ INFO
FM-1	CODE COMPLIANCE PLAN
A-1	FLOOR PLAN, DEMO PLAN & WALL SECTIONS
A-2	SCHEDULES & OPENING DETAILS
A-3	REFLECTED CEILING PLAN & DETAILS
A-4	INTERIOR ELEVATIONS & MILLWORK SECTIONS

ELECTRICAL

E-01	ELECTRICAL SYMBOLS
E-02	ELECTRICAL NOTES
E-03	LIGHTING FIXTURE/PANEL SCHEDULES & DETAILS
E-04	ELECTRICAL RISER DIAGRAM
E-05	ENLARGED DATA ROOM
E-06	EXISTING ELECTRICAL PLAN
E-1.00	ELECTRICAL SITE PLAN
E-2.01	LIGHTING PLAN
E-3.01	POWER PLAN
E-4.01	SPECIAL SYSTEMS PLAN
E-5.01	ROOF PLAN


MECHANICAL

M-0.1	SYMBOLS LEGEND, DETAILS & SCHEDULES
M-1.0	PARTIAL FIRST FLOOR PLAN DEMOLITION - HVAC
M-2.0	FIRST FLOOR PLAN - HVAC
M-3.0	PARTIAL LOWER ROOF PLAN - HVAC

PLUMBING


P-0.01	SYMBOLS LEGEND, NOTES, DETAILS, & SCHEDULES
P-0.02	PLUMBING RISERS
P-1.00	SITE PLAN - PLUMBING
P-2.00	UNDER FLOOR-FIRST FLOOR PLAN-PLUMBING
P-2.01	FIRST FLOOR PLAN-PLUMBING

SYMBOLS LEGEND

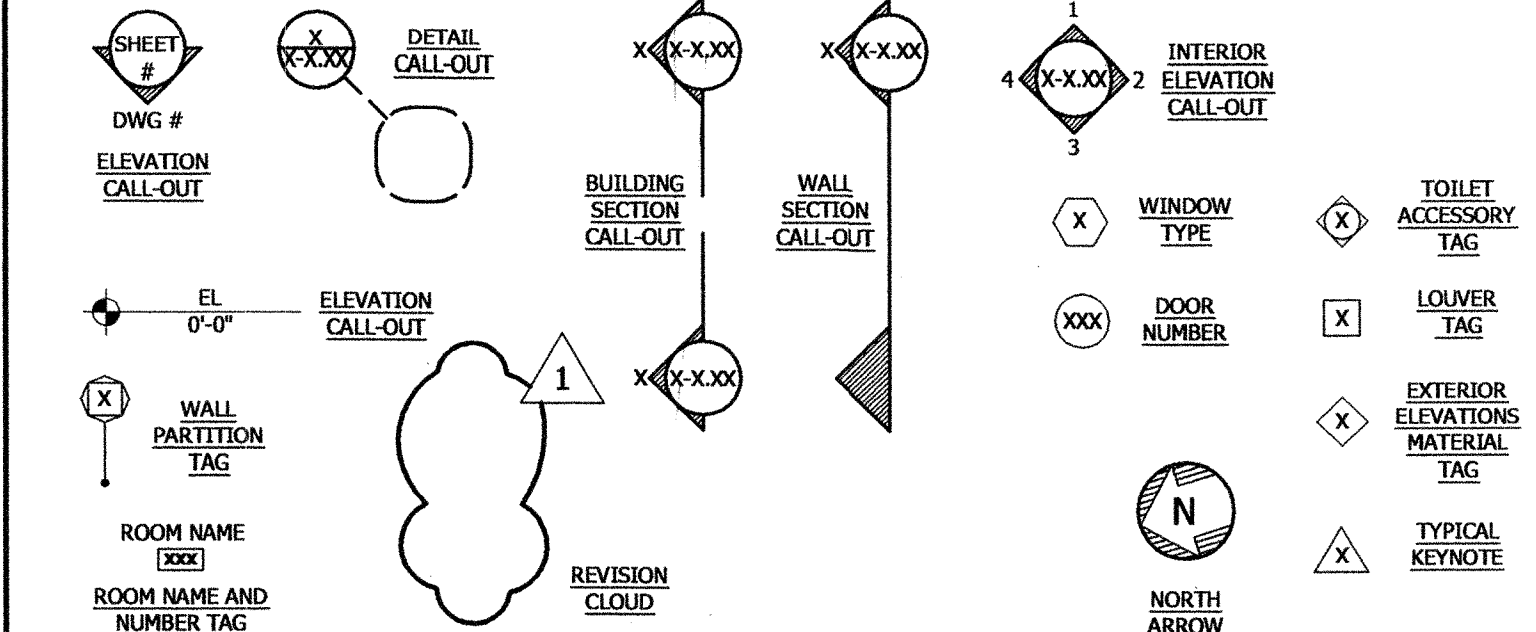

• RSK ROOM SIGNS- SEE SPECS
SEE CODE COMPLIANCE PLAN FOR ADDITIONAL INFORMATION

McMAIN HEALTH CLINIC RENOVATION
AT
ELEANOR McMAIN SECONDARY HIGH SCHOOL
5712 SOUTH CLAIBORNE AVENUE
NEW ORLEANS, LOUISIANA 70125

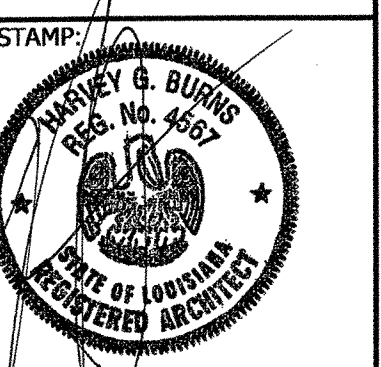

REVISION(S):

DRAWN BY: JTL/SGF

CHECKED BY: HGB DATE: 05/11/12

DATE: 05/11/12

JOB NO: 1007B

SHEET NO: T-1