



GENERAL NOTES (THIS SHEET):
 1. REFER TO M100 FOR ALL GENERAL MECHANICAL NOTES AND MECHANICAL PLAN KEYNOTES.
 2. REFER TO P301 FOR ALL EQUIPMENT LOCATED ON ROOF.

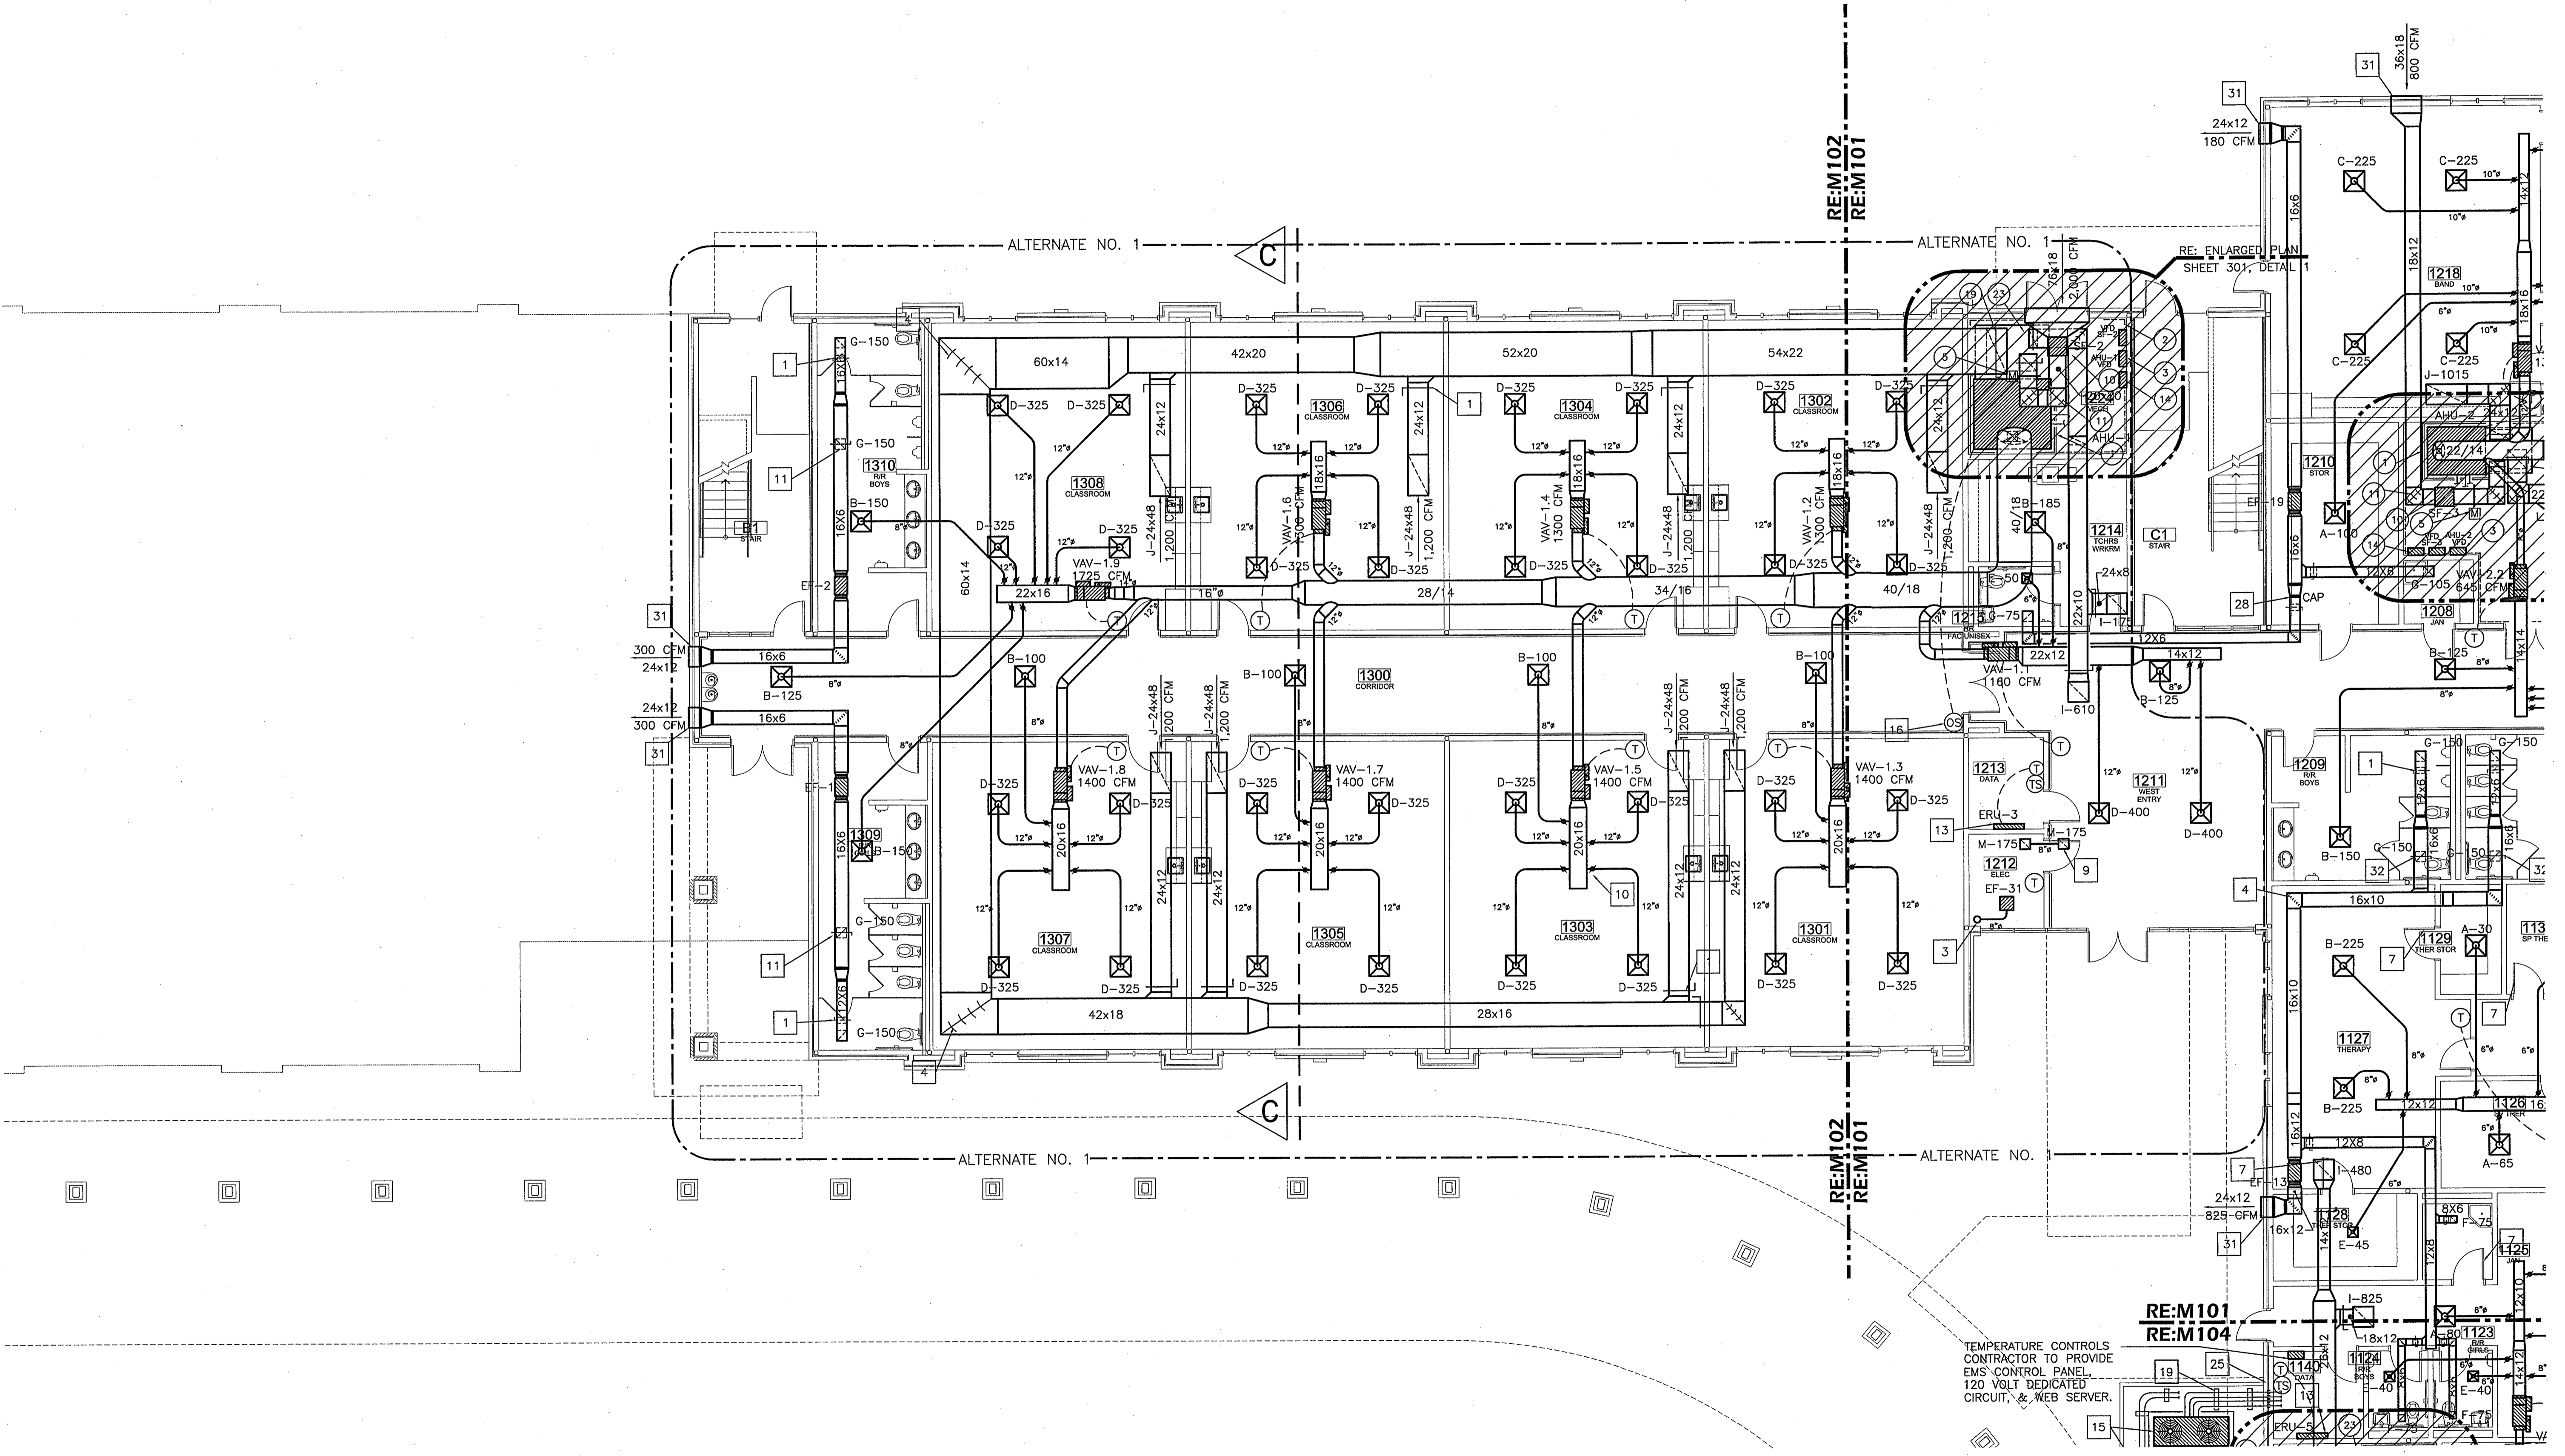

TEMPERATURE CONTROLS CONTRACTOR TO PROVIDE EMS CONTROL PANEL, 120 VOLT DEDICATED CIRCUIT, & WEB SERVER.

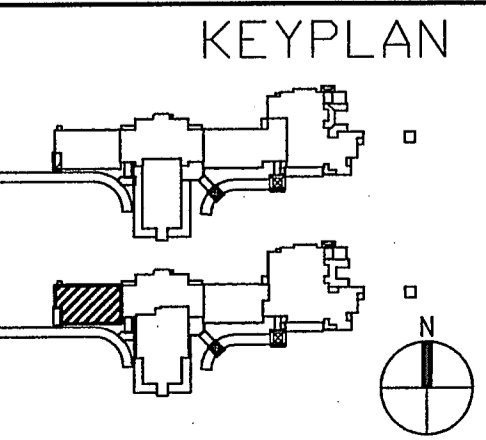


ANDREW GASAWAY, JR., ARCHITECT, AIA, APA
 BRETT GASAWAY, ARCHITECT, AIA, NCARB
 CHRIS BANKSTON, ARCHITECT, AIA, NCARB, LEED AP

GGB
 Gasaway | Bankston
 Architects + Planners
 1007 W. THOMAS ST., SUITE G
 HAMMOND, LA 70401
 985.345.5047
 985.345.5040

**JOSEPH B. LANCASTER
 ELEMENTARY SCHOOL**
 ST. TAMMANY PARISH SCHOOL BOARD
 MADISONVILLE, LOUISIANA
 STPSB PROJECT #0825

THIS DRAWING IS AN INSTRUMENT OF SERVICE, IS AND SHALL REMAIN THE PROPERTY OF THE ARCHITECT AND SHALL NOT BE REPRODUCED, PUBLISHED OR USED IN ANY WAY WITHOUT THE EXPRESS PERMISSION OF THE ARCHITECT.

PROJ. NO. **0825**
 DATE **06.25.09**

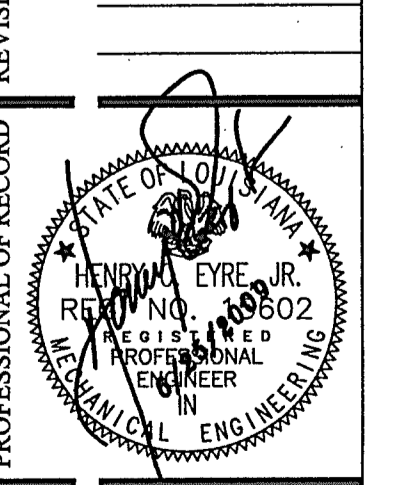

M102

1 PARTIAL 1st FLOOR PLAN - MECHANICAL
 Scale: 1/8"=1'-0"