



HVAC PLAN UNIT 3A  
SCALE: 1/4" = 1'-0"

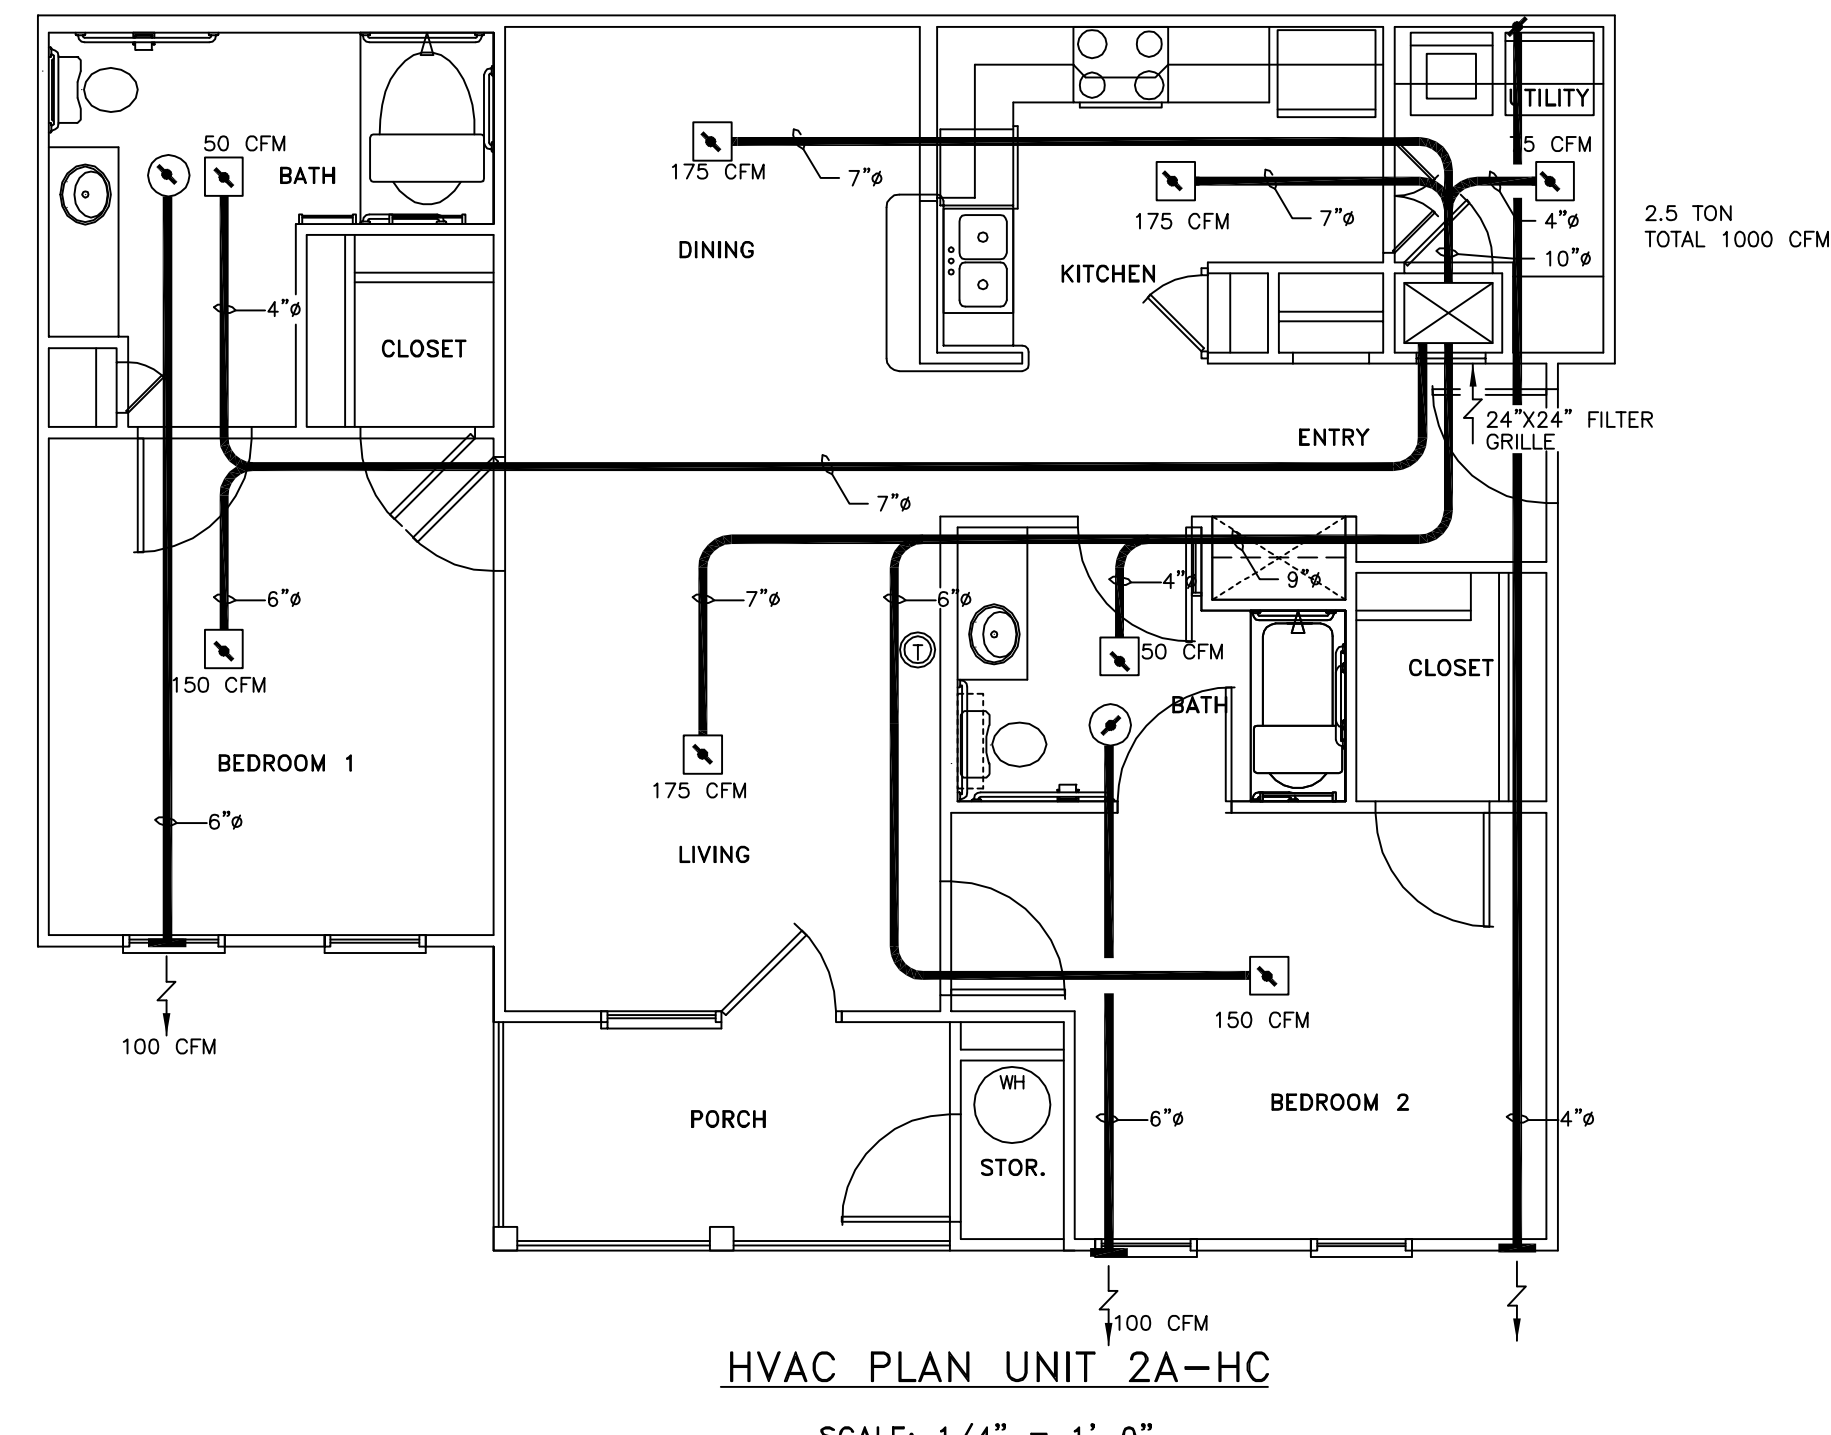

HVAC PLAN UNIT 2A-HC  
SCALE: 1/4" = 1'-0"

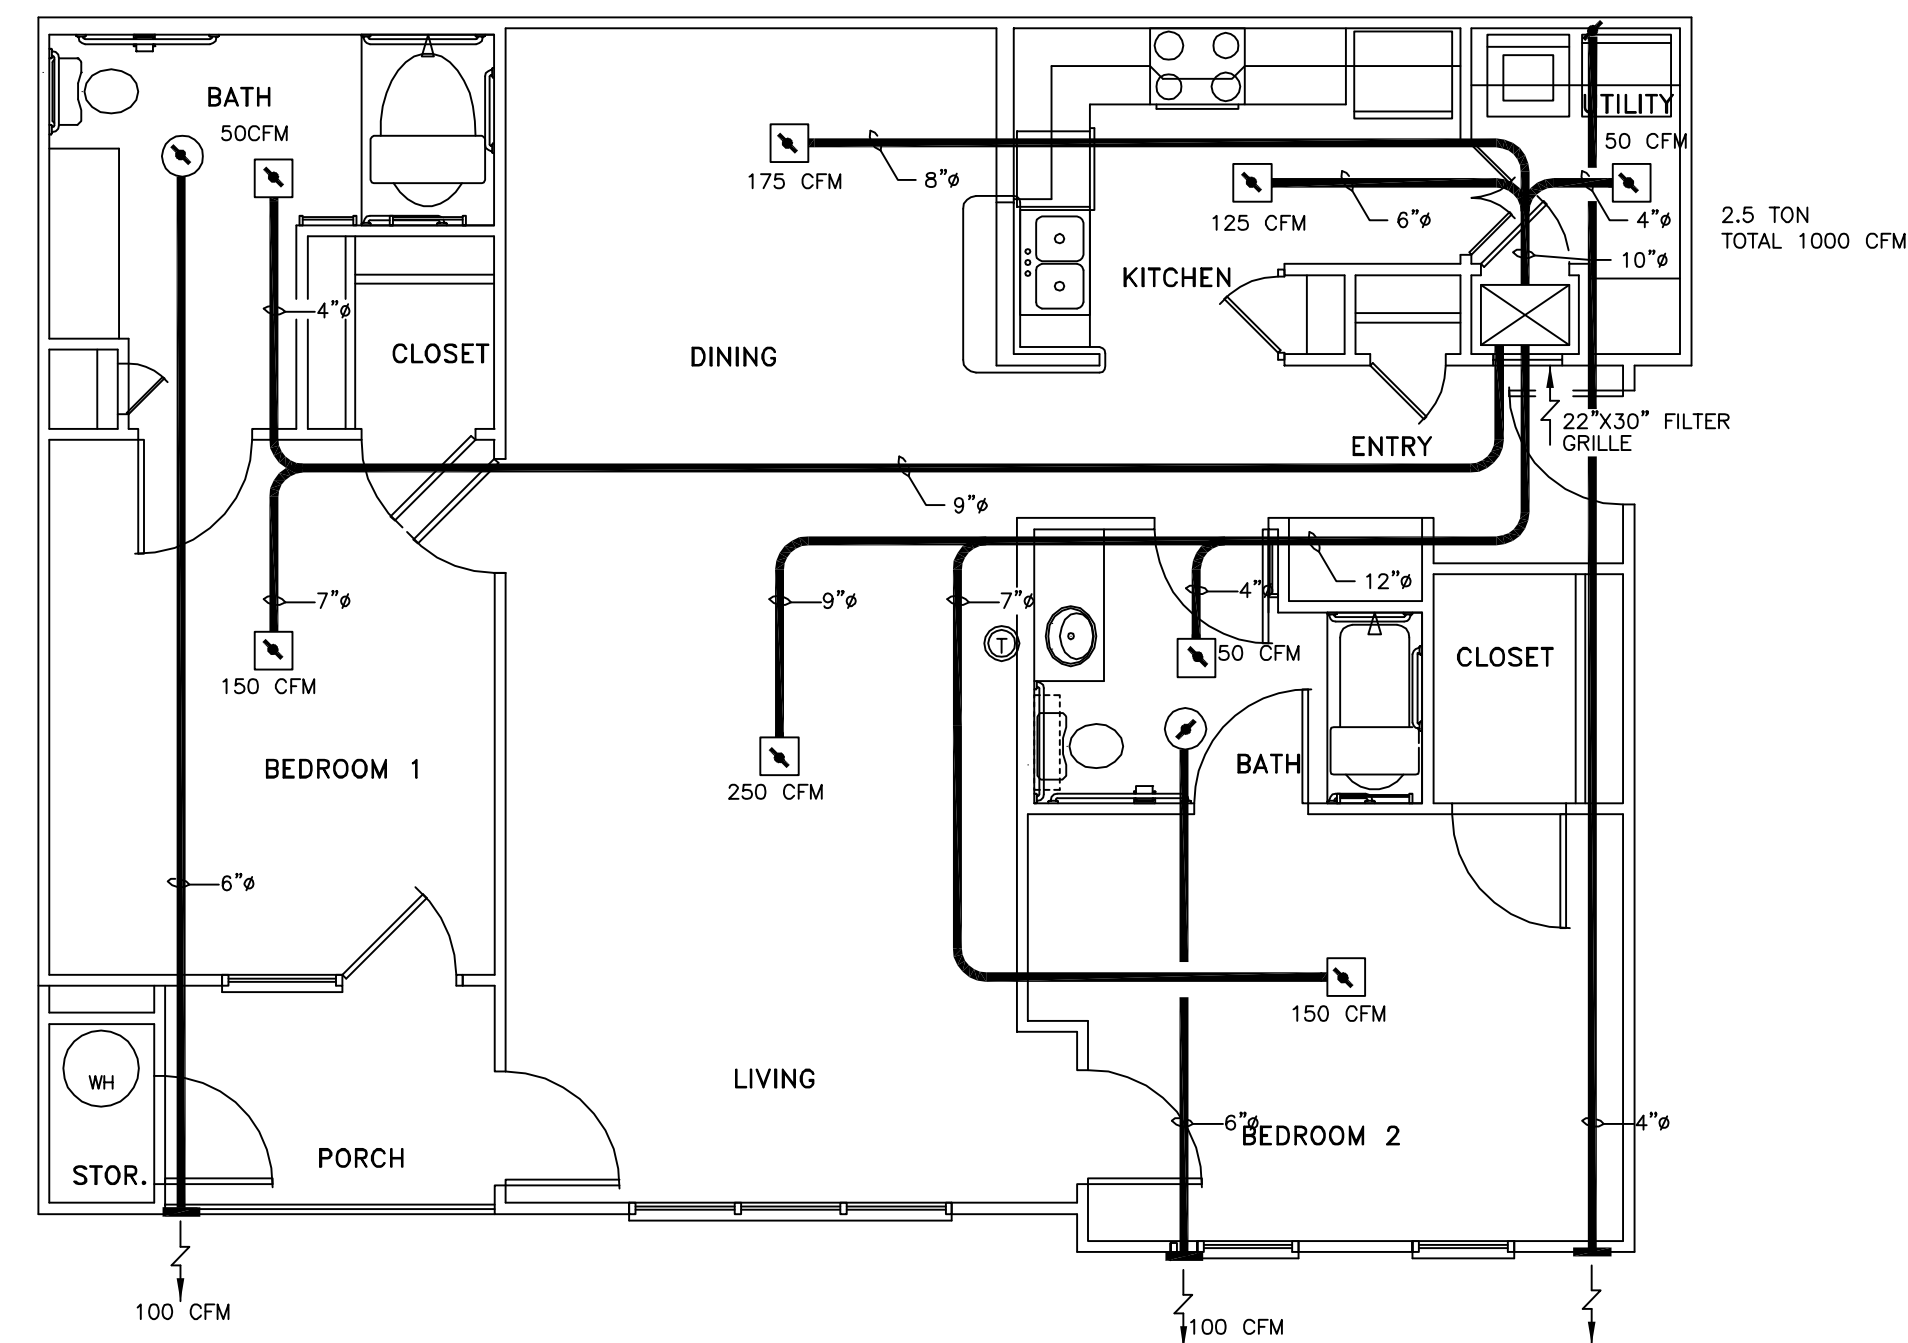

HVAC PLAN UNIT 2B-HC  
SCALE: 1/4" = 1'-0"

LEGEND

- SUPPLY AIR VENT
- ↘ FIRE DAMPER
- BATHROOM EXHAUST
- ⊕ THERMOSTAT

MECHANICAL SPECIFICATIONS  
2.5 TON HEAT PUMP

EQUIPMENT SELECTIONS	
INDOOR HEAT PUMP	ADP_BU30210
AIR FLOW	1000 CFM
ELECTRICAL SPECIFICATIONS	240V-1ϕ
UNIT M.C.A. (INCLUDING HEAT)	56.0 AMPS
REV. CYCLE HEAT CAPACITY	34120 BTUH
AUX. HEAT CAPACITY	10.0 KW (41.6A)
OUTDOOR HEAT PUMP	DUCANE_HP10B30
ELECTRICAL SPECIFICATIONS	240V-1ϕ
UNIT M.C.A.	21.4 MCA
COOLING CAPACITY	30,000 BTUH S.E.E.R. 10.0

MECHANICAL SPECIFICATIONS  
3 TON HEAT PUMP

EQUIPMENT SELECTIONS	
INDOOR HEAT PUMP	ADP_BU3610
AIR FLOW	1200 CFM
ELECTRICAL SPECIFICATIONS	240V-1ϕ
UNIT M.C.A. (INCLUDING HEAT)	60.0 AMPS
REV. CYCLE HEAT CAPACITY	34120 BTUH
AUX. HEAT CAPACITY	10.0 KW
OUTDOOR HEAT PUMP	DUCANE_HP10B36
ELECTRICAL SPECIFICATIONS	240V-1ϕ
UNIT M.C.A.	23.9 MCA
COOLING CAPACITY	34,400 BTUH S.E.E.R. 10.0

THE BRYAN COMPANY  
ISLAND PARK  
APARTMENT COMMUNITY  
SHREVEPORT, LA.

ISLAND PARK  
DAMMON ENGINEERING INC  
ARCHITECTS - ENGINEERS  
SLIDELL, LA. 70458  
819 ROBERT ROAD

SCALE: AS NOTED

FILE: -

JOB No.: -

DATE: 03-29-04

SHEET

M-4

OF -