




PLUMBING PLAN UNIT 2A-HC  
SCALE: 1/4" = 1'-0"

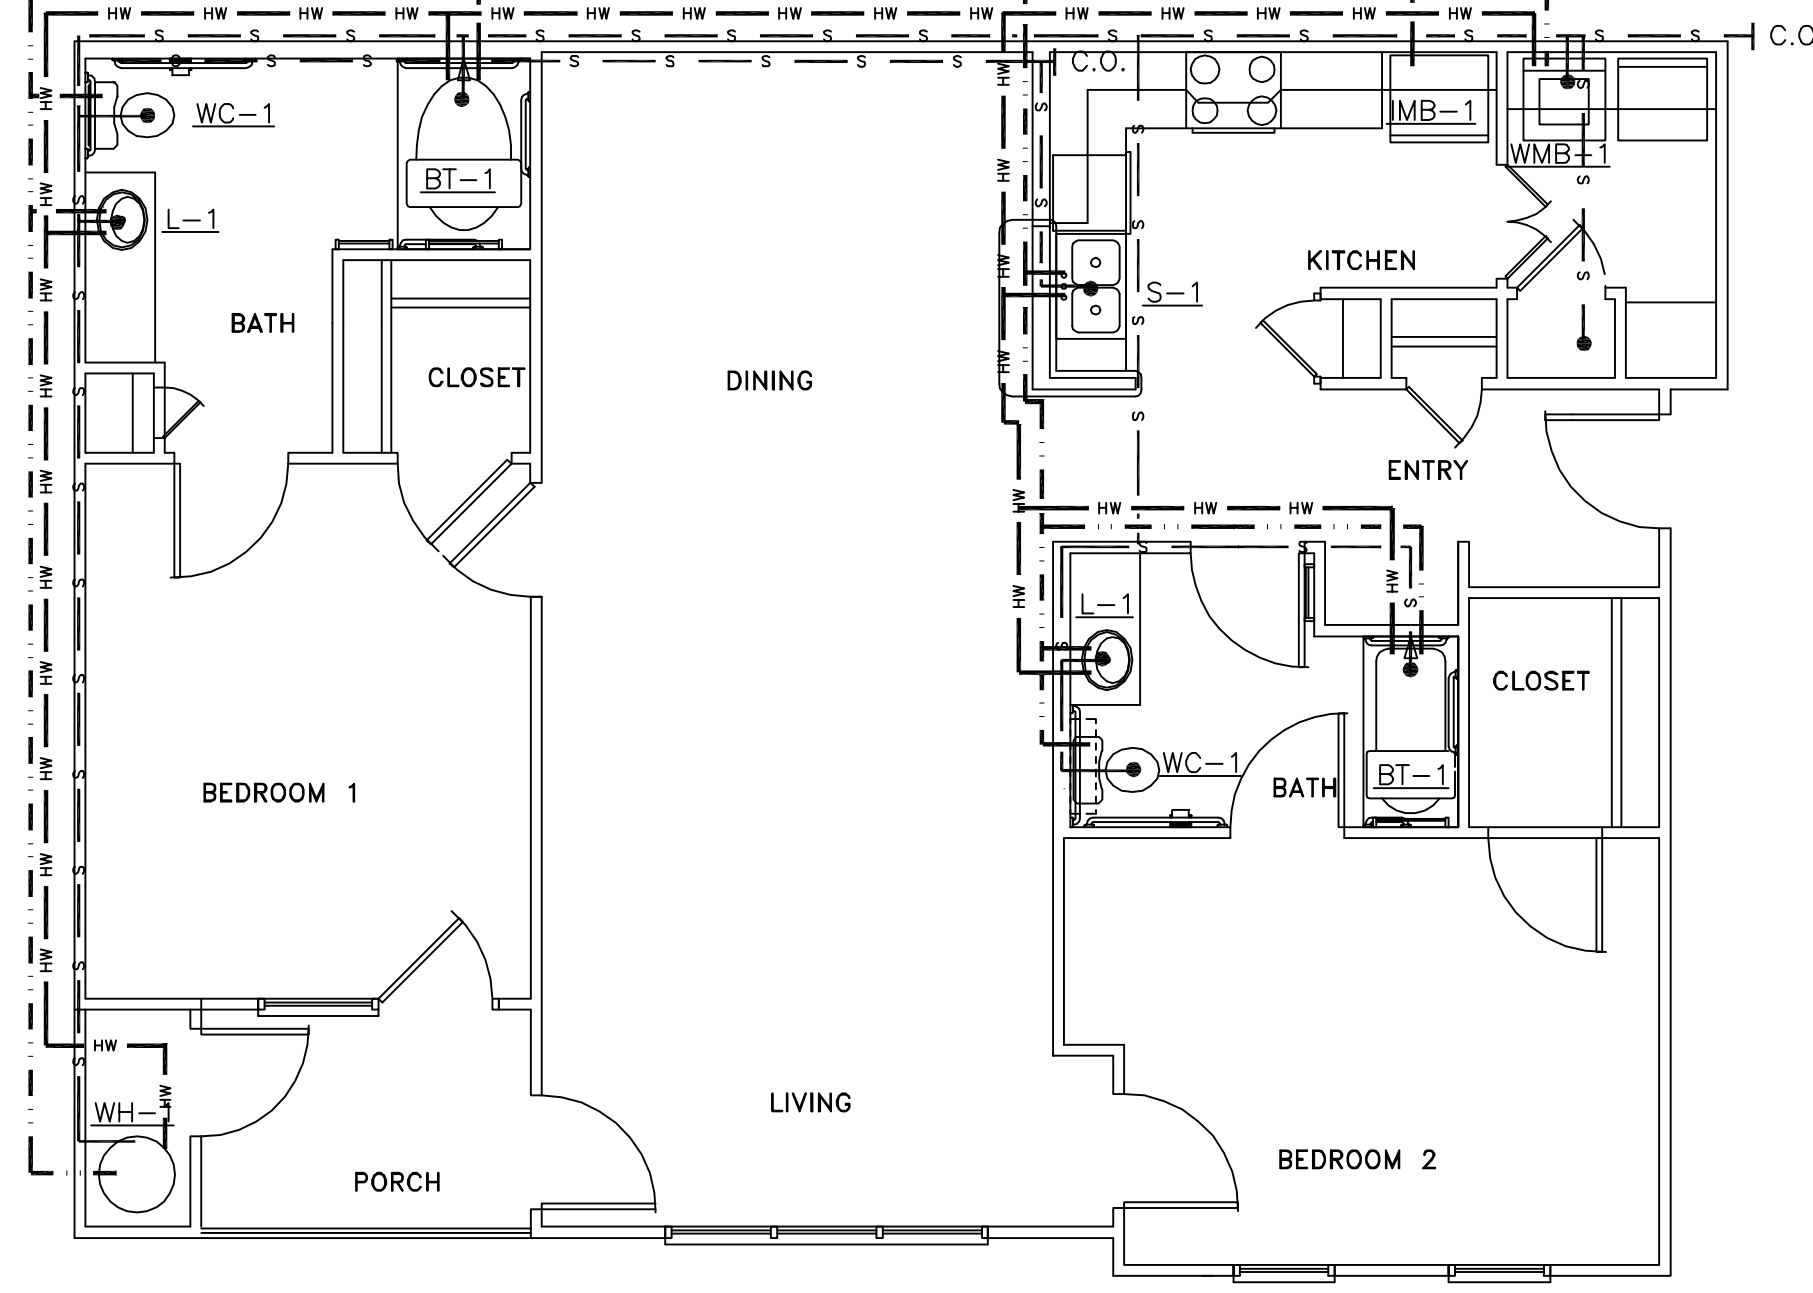

PLUMBING PLAN UNIT 2B-HC  
SCALE: 1/4" = 1'-0"

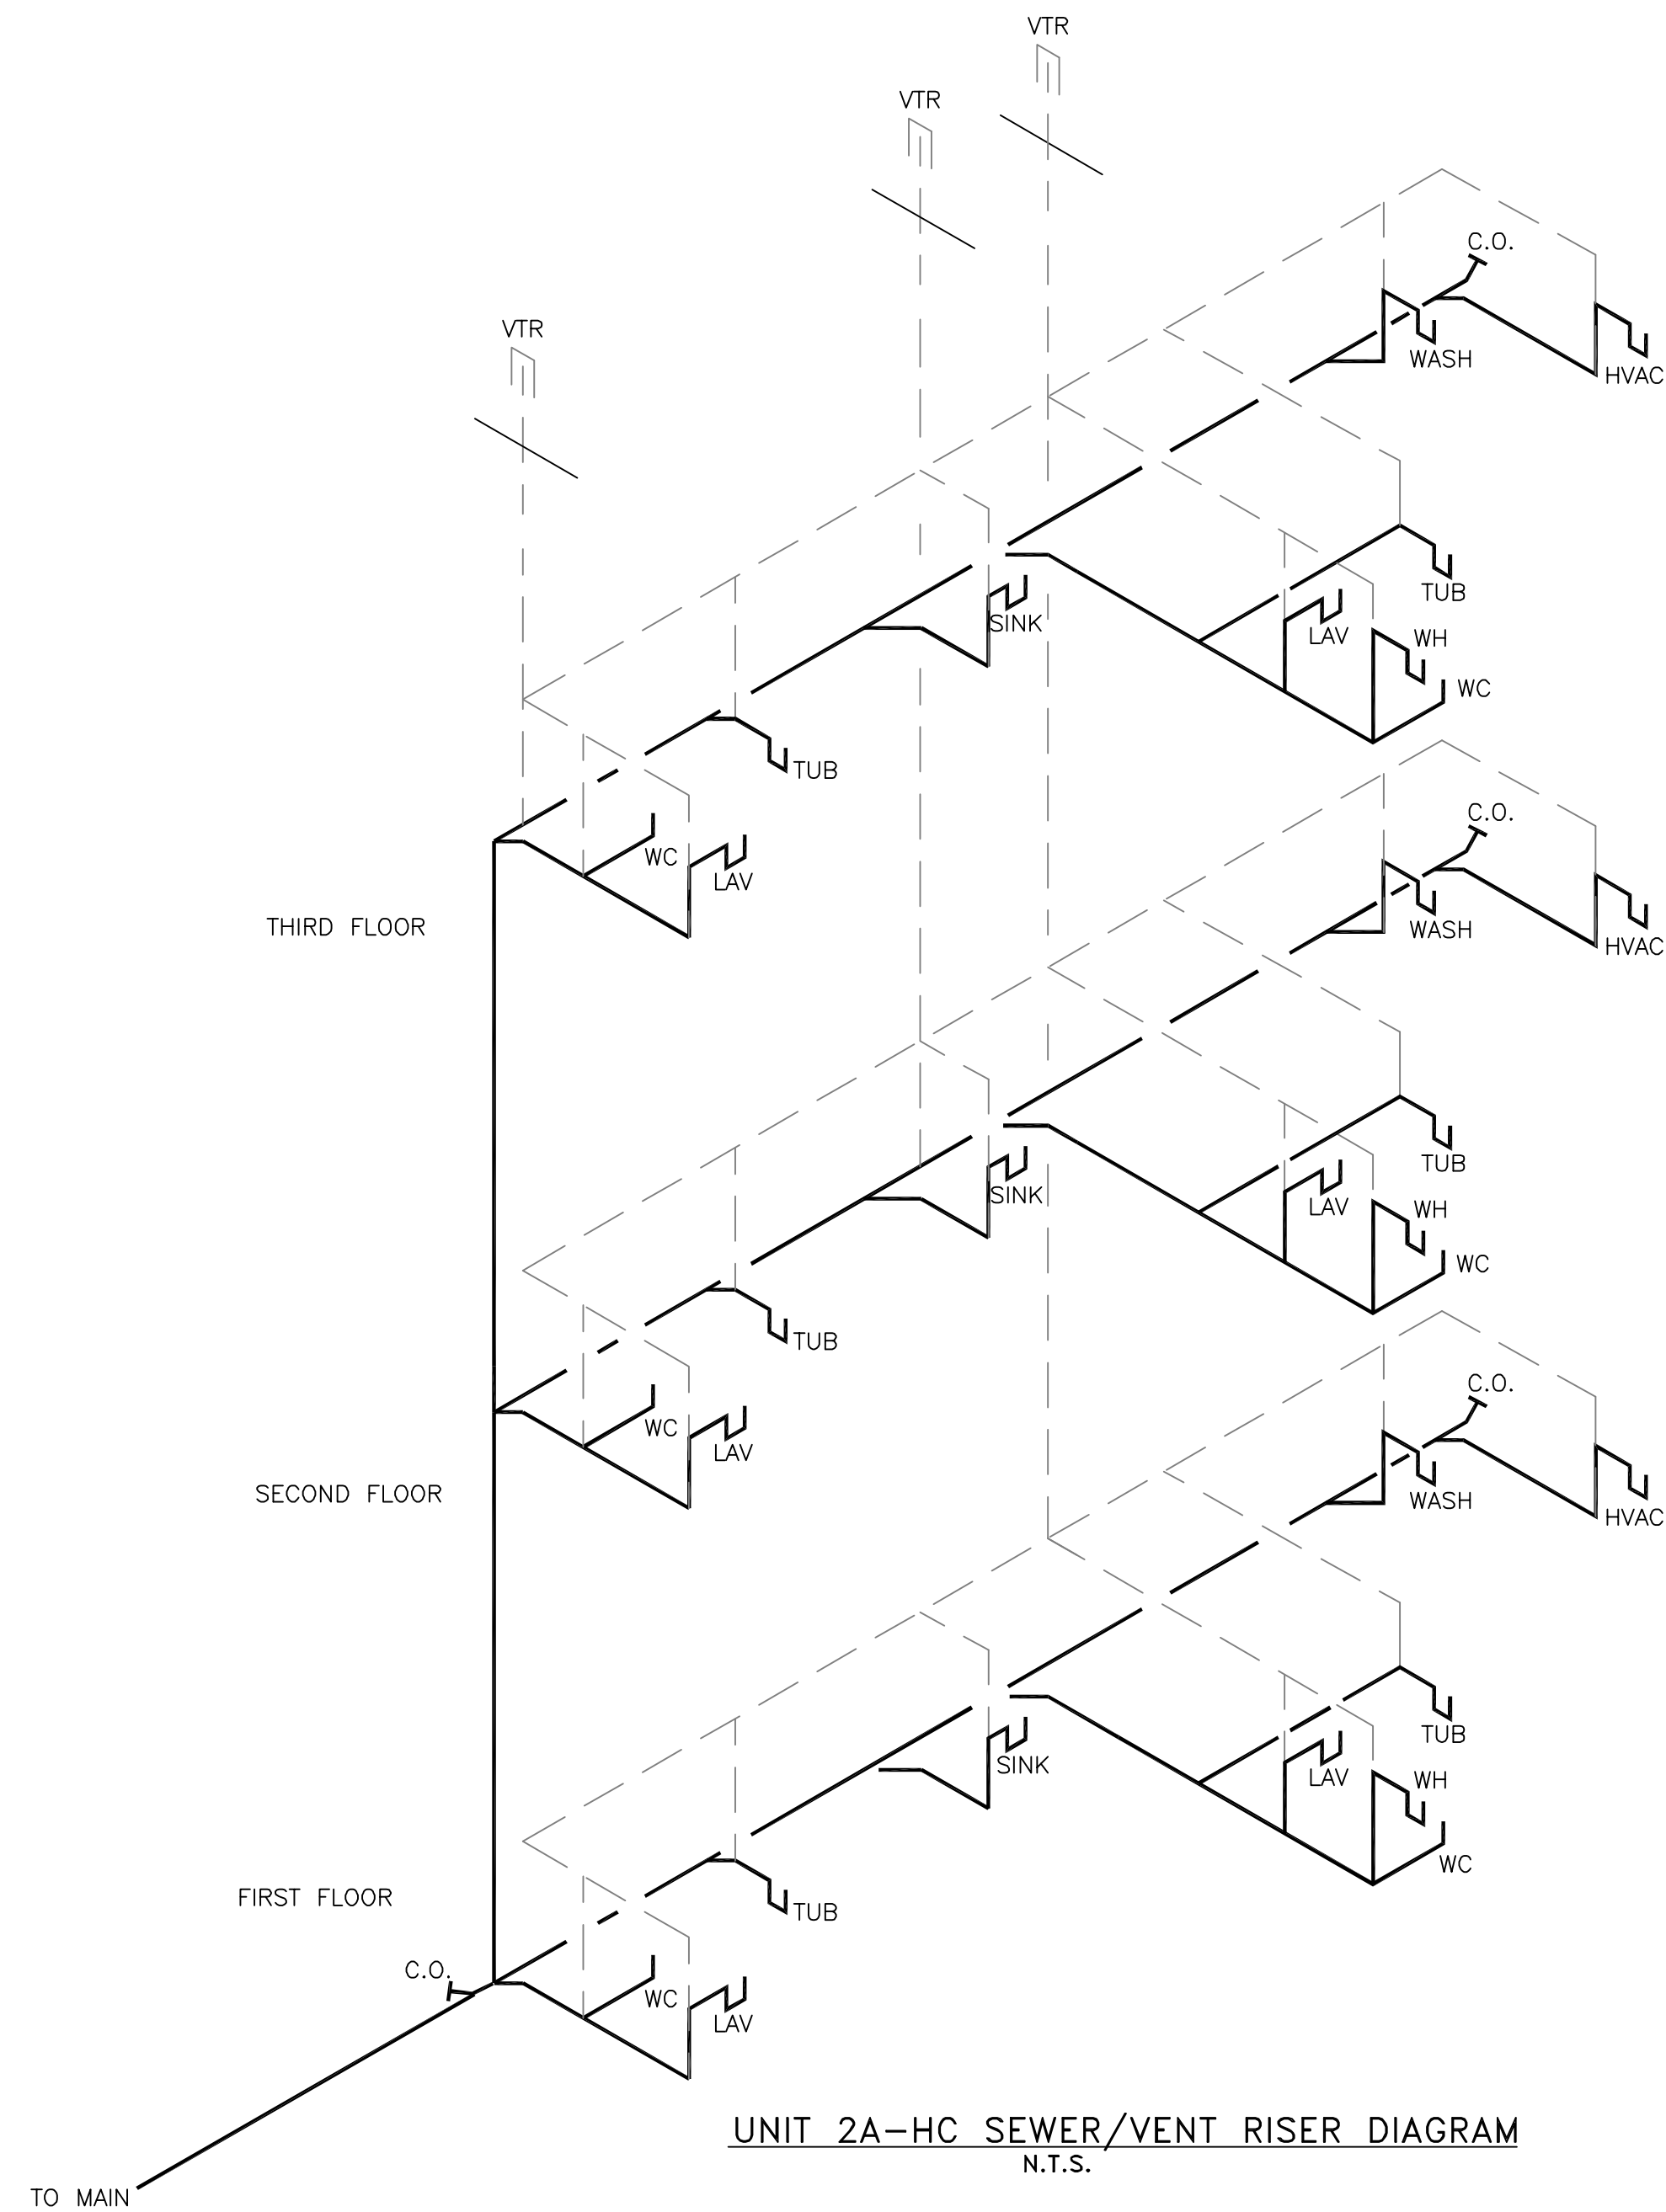

UNIT 2A-HC SEWER/VENT RISER DIAGRAM  
N.T.S.

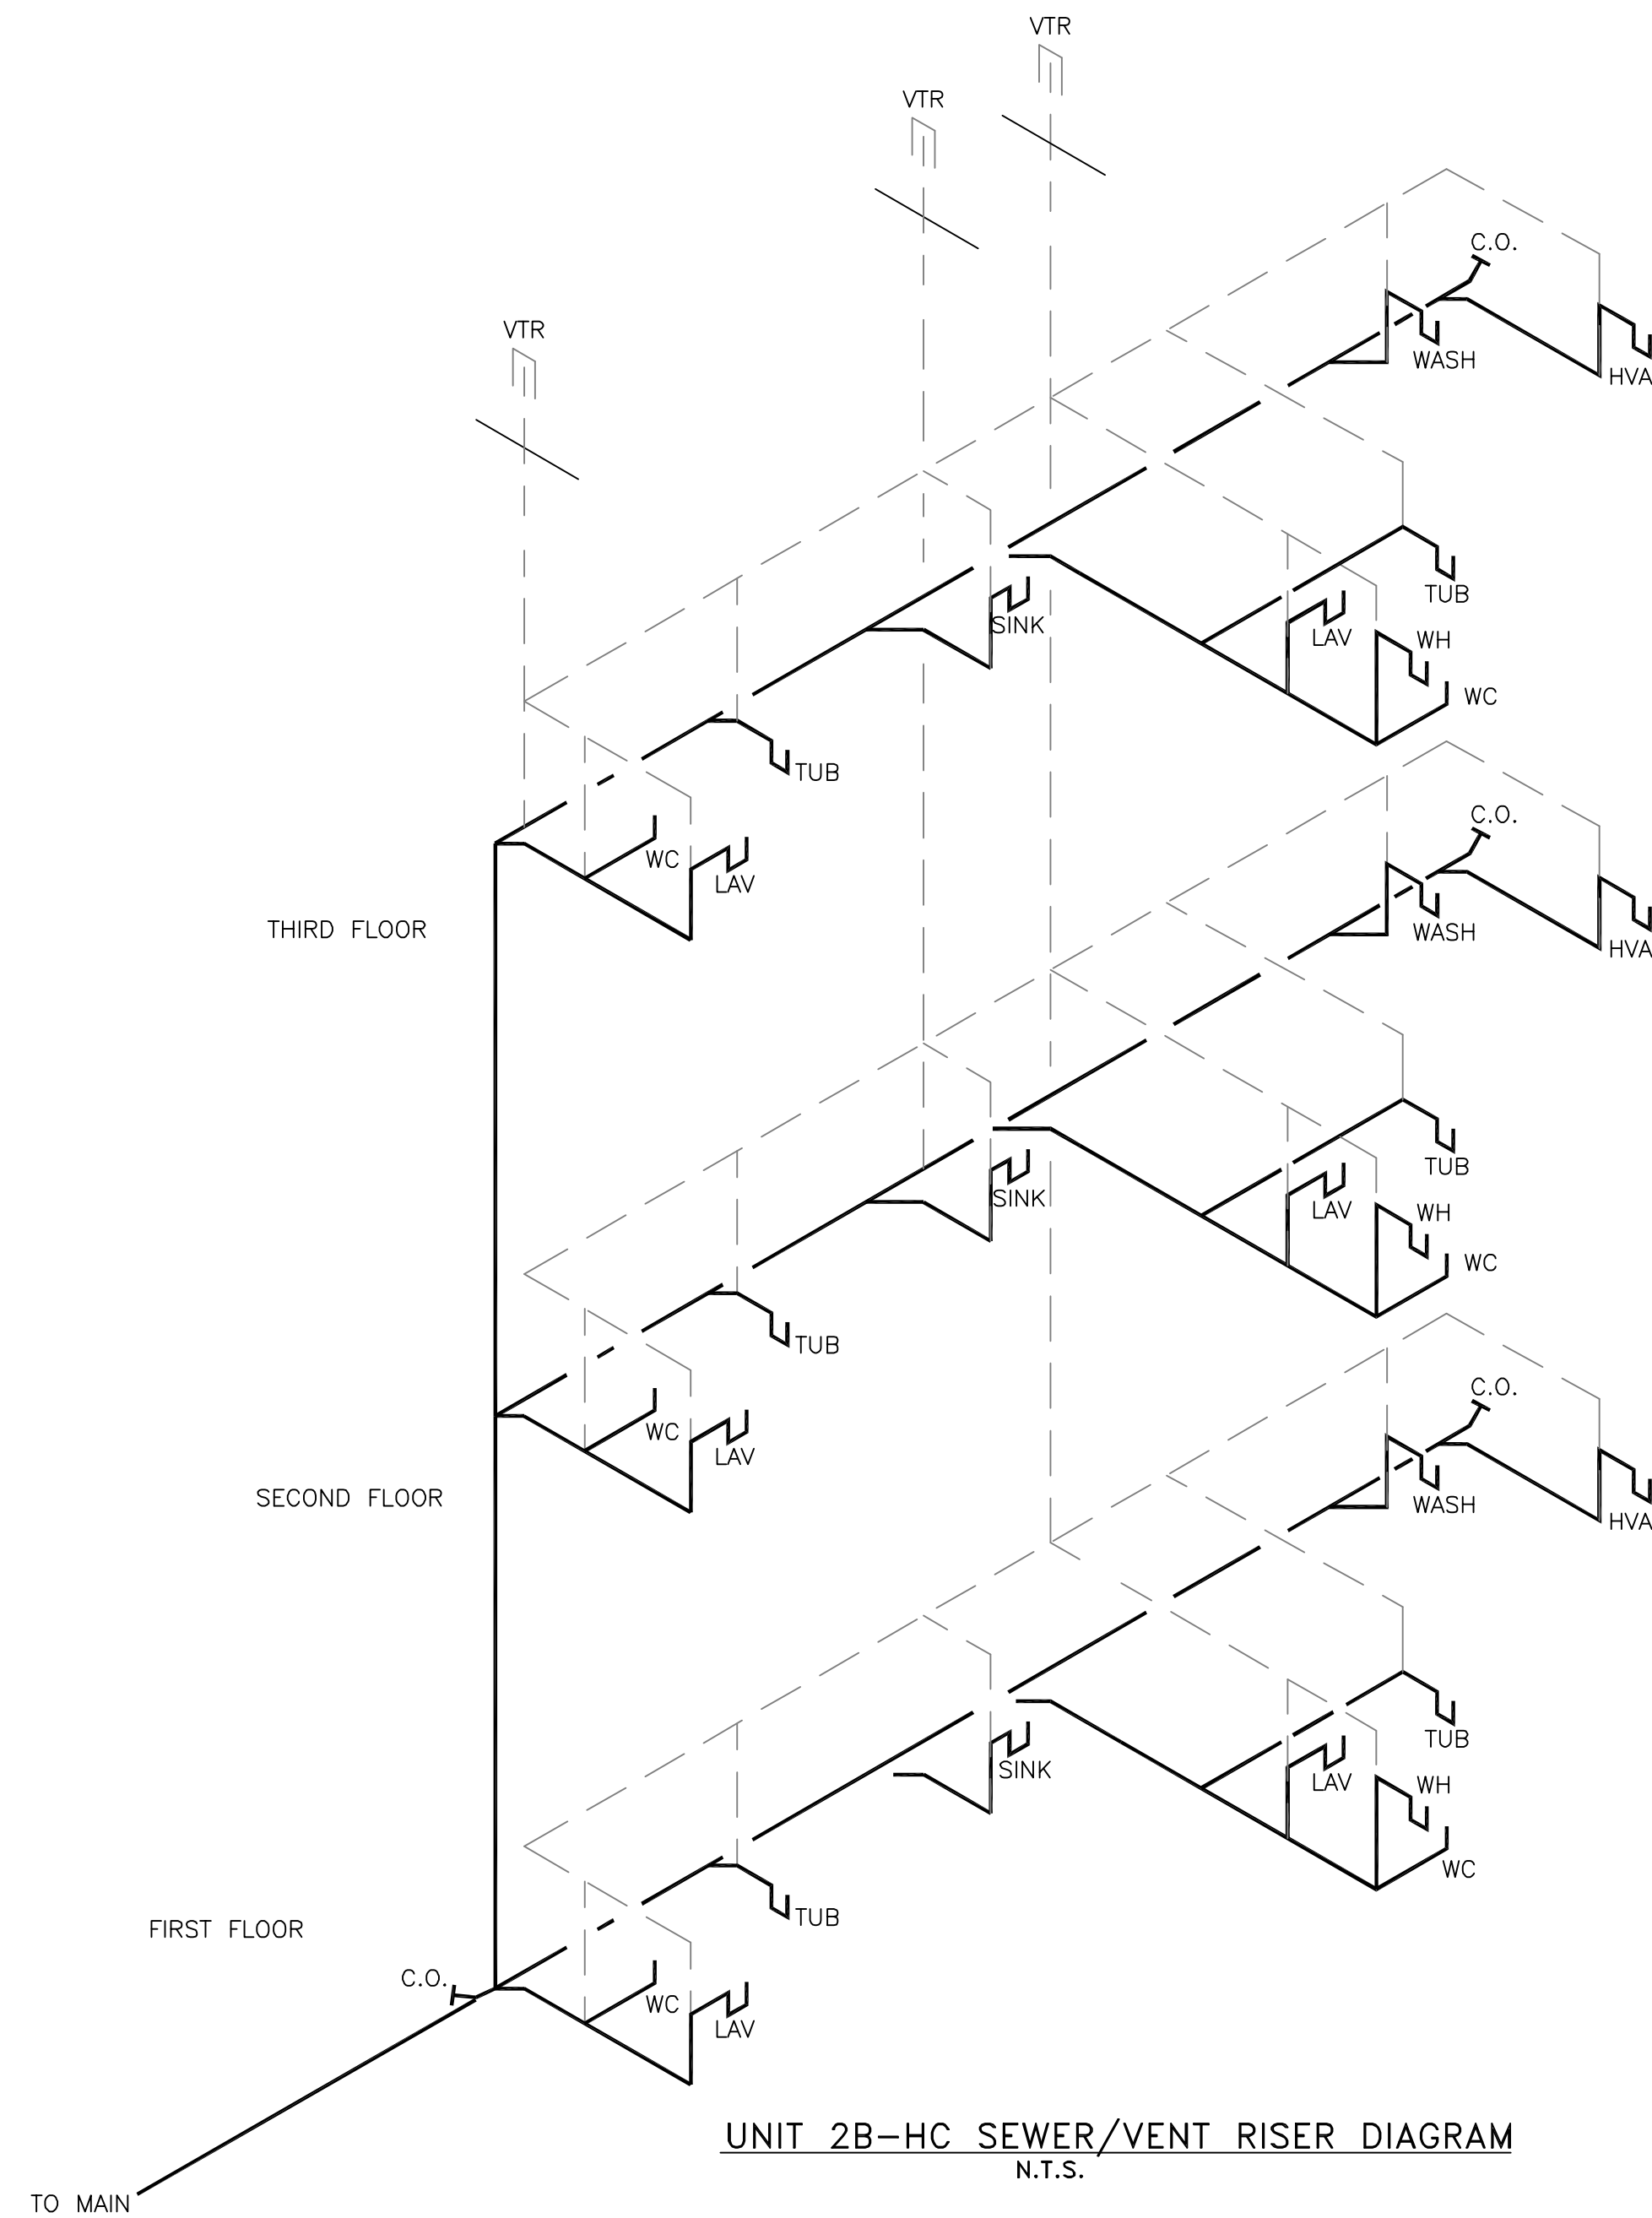

UNIT 2B-HC SEWER/VENT RISER DIAGRAM  
N.T.S.

MARK	DESCRIPTION	ROUGH-IN-SIZES			REMARKS
		CW	H.W.	WASTE VENT	
WC-1	WATER CLOSET, FLR. MTD.	1/2"	4"	4"	
L-1	COUNTER MOUNTED LAVATORY	1/2"	1/2"	2"	
BT-1	TUB / SHOWER/SURROUND	1/2"	1/2"	2"	W/ PRESSURE BALANCING VALVE.
S-1	KITCHEN SINK - 2 COMPARTMENT	1/2"	1/2"	2"	PROVIDE PIPING TO DISHWASHER.
WMB-1	WASHING MACHINE BOX	1/2"	1/2"	2"	
IMB-1	ICE MAKER BOX	1/2"	-	-	
WH-1	40 GAL WATER HEATER	-	-	-	
VTR	VENT TO ROOF	-	-	4"	

LEGEND

- H W — H W — H W — HOT WATER
- - - - - POTABLE WATER
- s - s - s - SANITARY SEWER
- - - - - PLUMBING VENT

THE BRYAN COMPANY  
ISLAND PARK  
APARTMENT COMMUNITY  
SHREVEPORT, LA.

ISLAND PARK  
**DAMMON ENGINEERING, INC.**  
ARCHITECTS - ENGINEERS  
819 ROBERT ROAD  
SLIDELL, LA. 70458

SCALE: AS NOTED  
FILE: -  
JOB No.: -  
DATE: 03-29-04  
SHEET  
P-10  
OF -