



SITE PLAN
SCALE: 1" = 80'

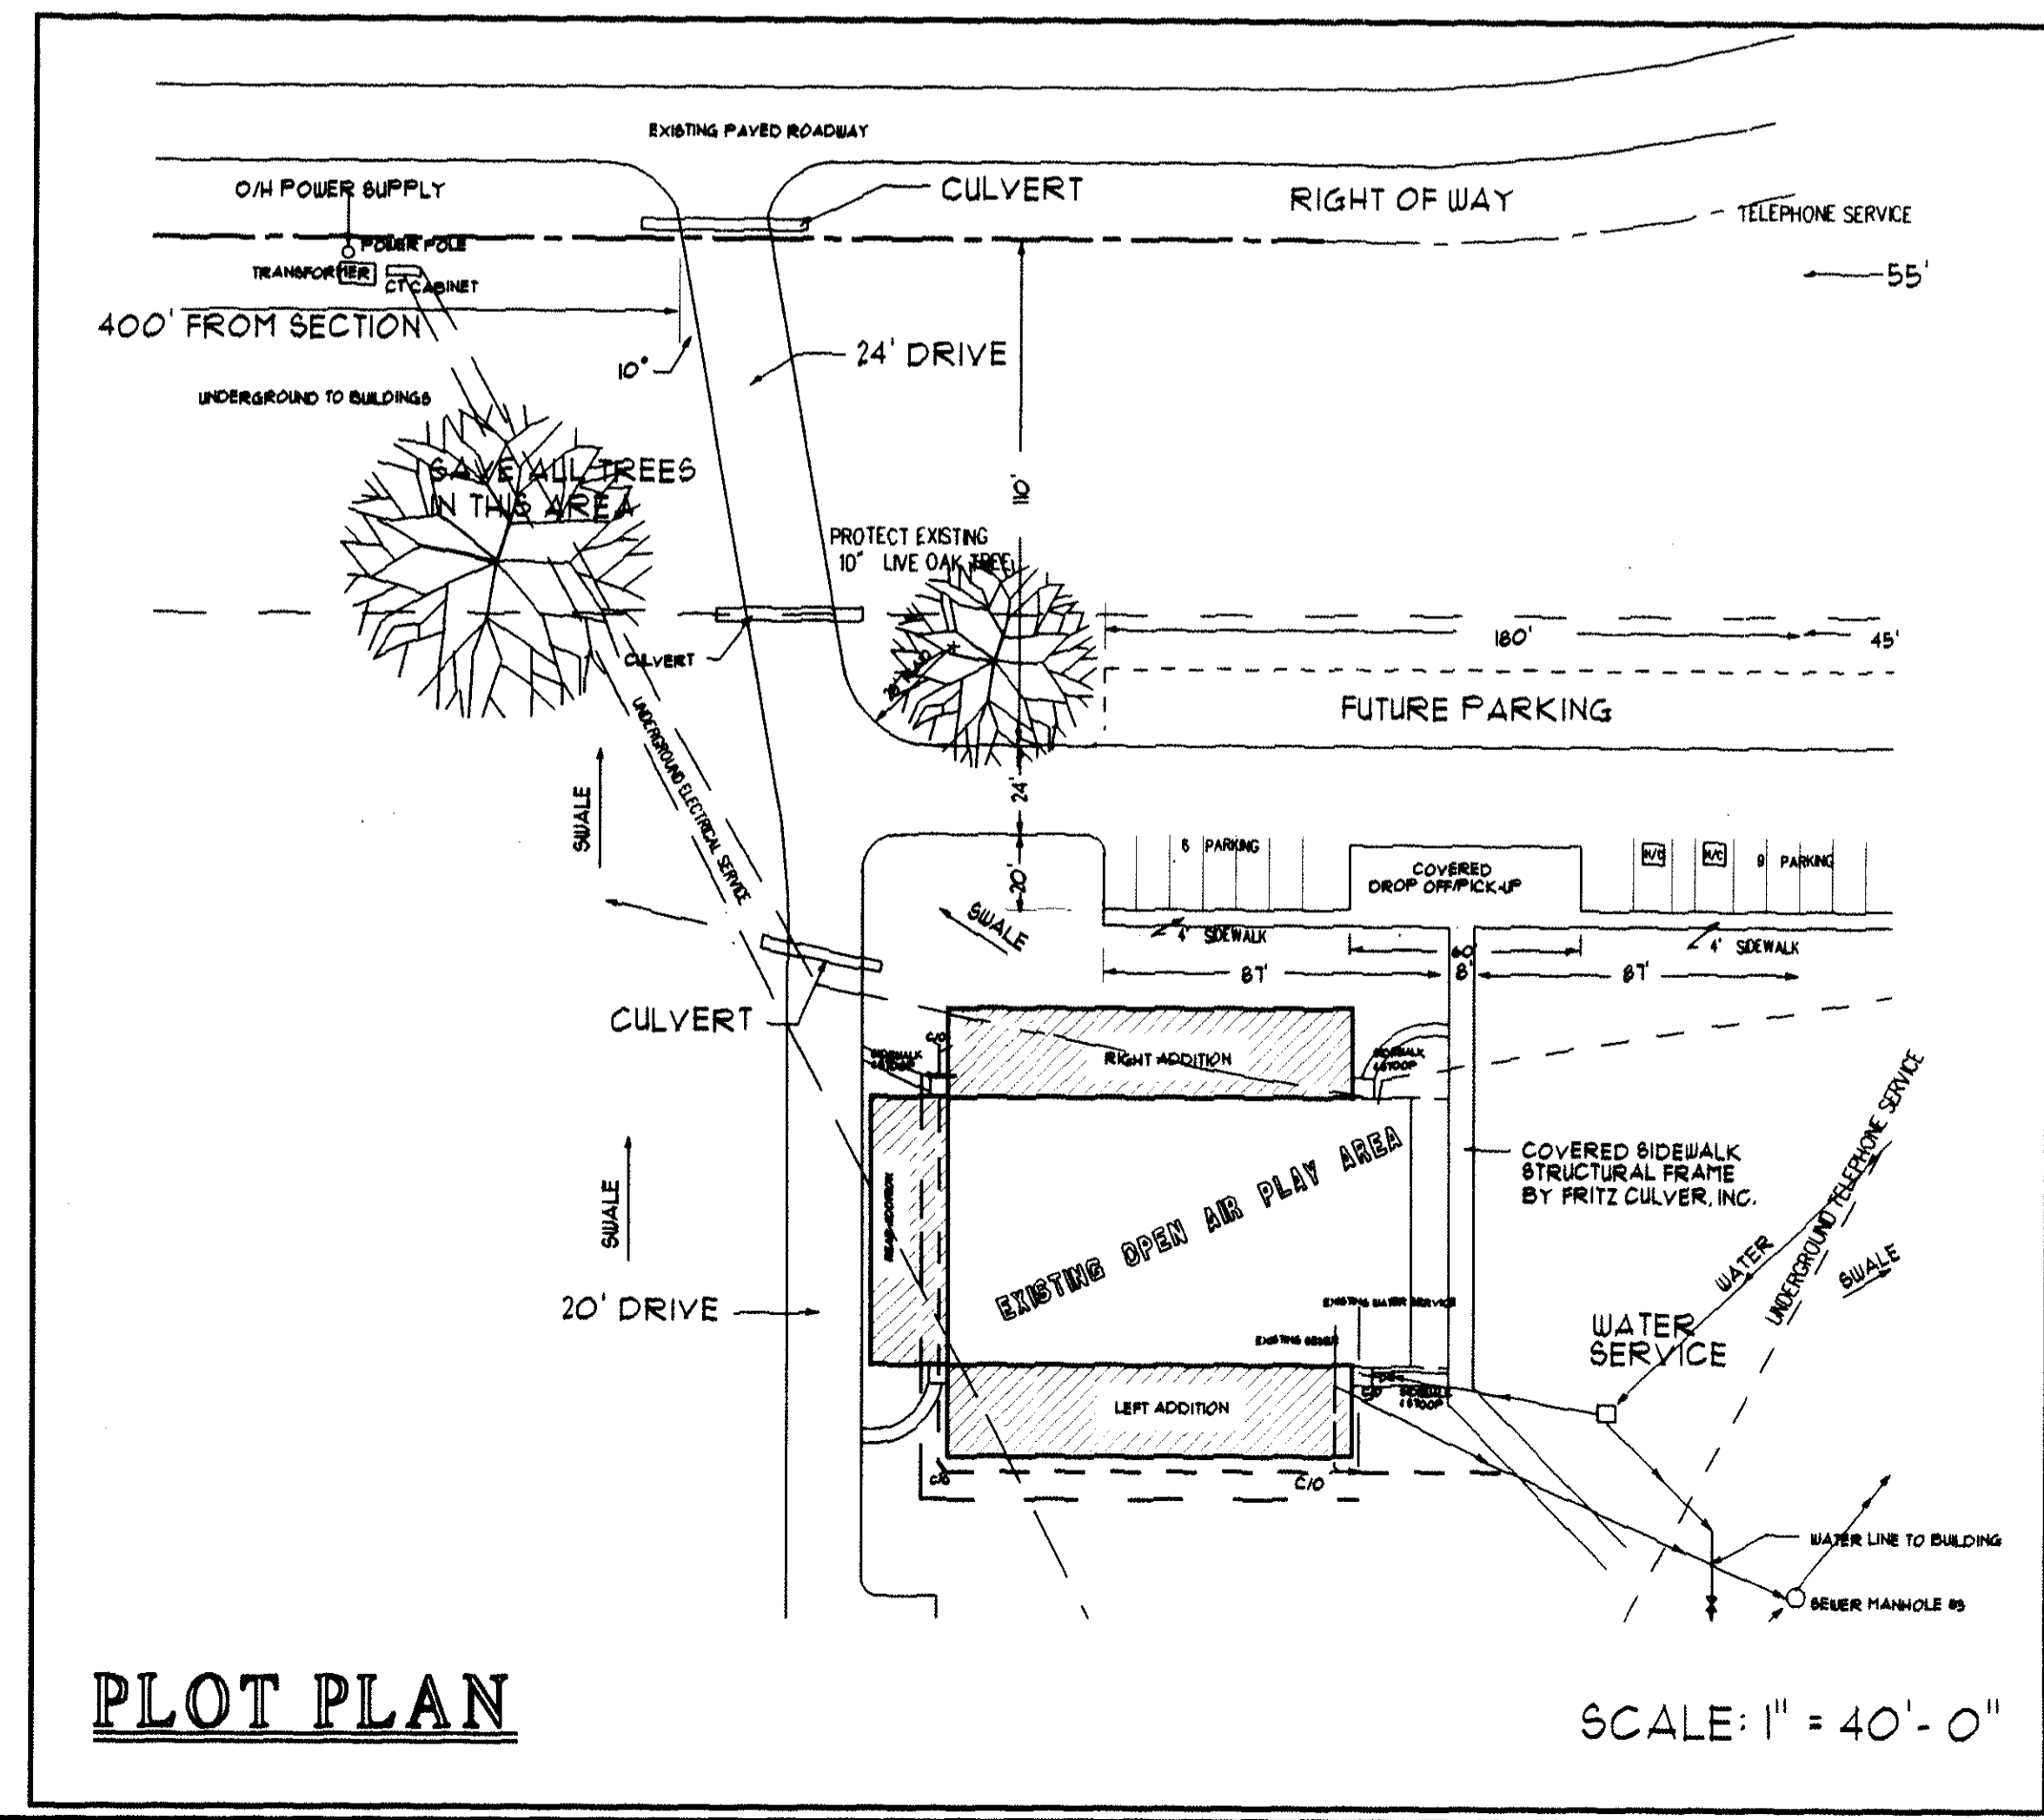

PLOT PLAN

SCALE: 1" = 40'-0"

INDEX	
SHEET	
1	SITE PLAN, VICINITY, & INDEX
2	PLOT PLAN
3	FLOOR PLAN
4	RIGHT ADDITION
5	LEFT ADDITION
6	REAR ADDITION
7	FRONT & LEFT SIDE VIEW
8	REAR & RIGHT SIDE VIEW
9	CROSS SECTIONS
10	ELECTRICAL PLAN
11	MECHANICAL PLAN
12	STRUCTURAL
13	DETAILS
14	FOUNDATION
15	SPECIFICATION

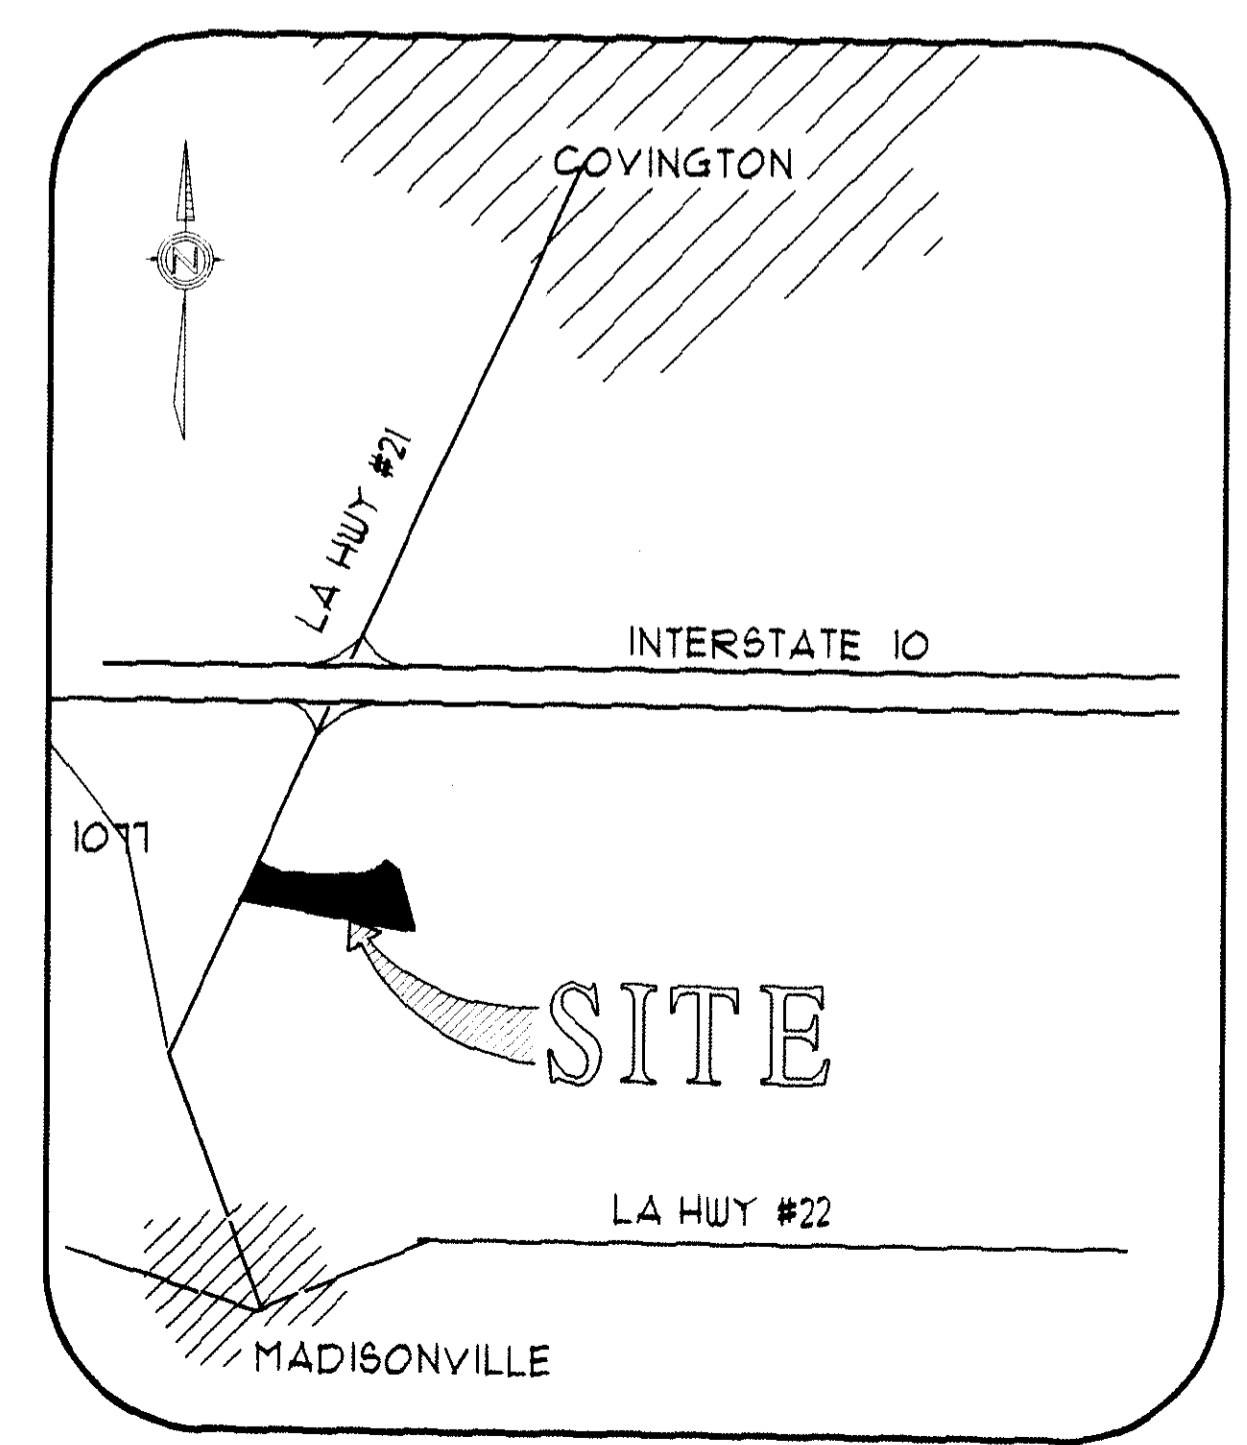

VICINITY MAP

DON MCMATH CONSTRUCTION
2990 GAUSE BLVD EAST
SL IDELL
LOUISIANA
504-641-4070



**CHRIST EPISCOPAL SCHOOL
GYM EXPANSION**
LA HWY #21 & CHRISTWOOD BLVD
COVINGTON, LOUISIANA

SQUARE FOOTAGE	
AREAS OF EXPANSION	
- Right Expansion	2,496
- Left Expansion	2,496
- Rear Expansion	1,820
TOTAL EXPANSION	6,812

DATE: 1 APRIL 00

JOB NO. CO-18

SHEET

1

OF