


**FLOOR PLAN**

SCALE: 1/4" = 1'-0"

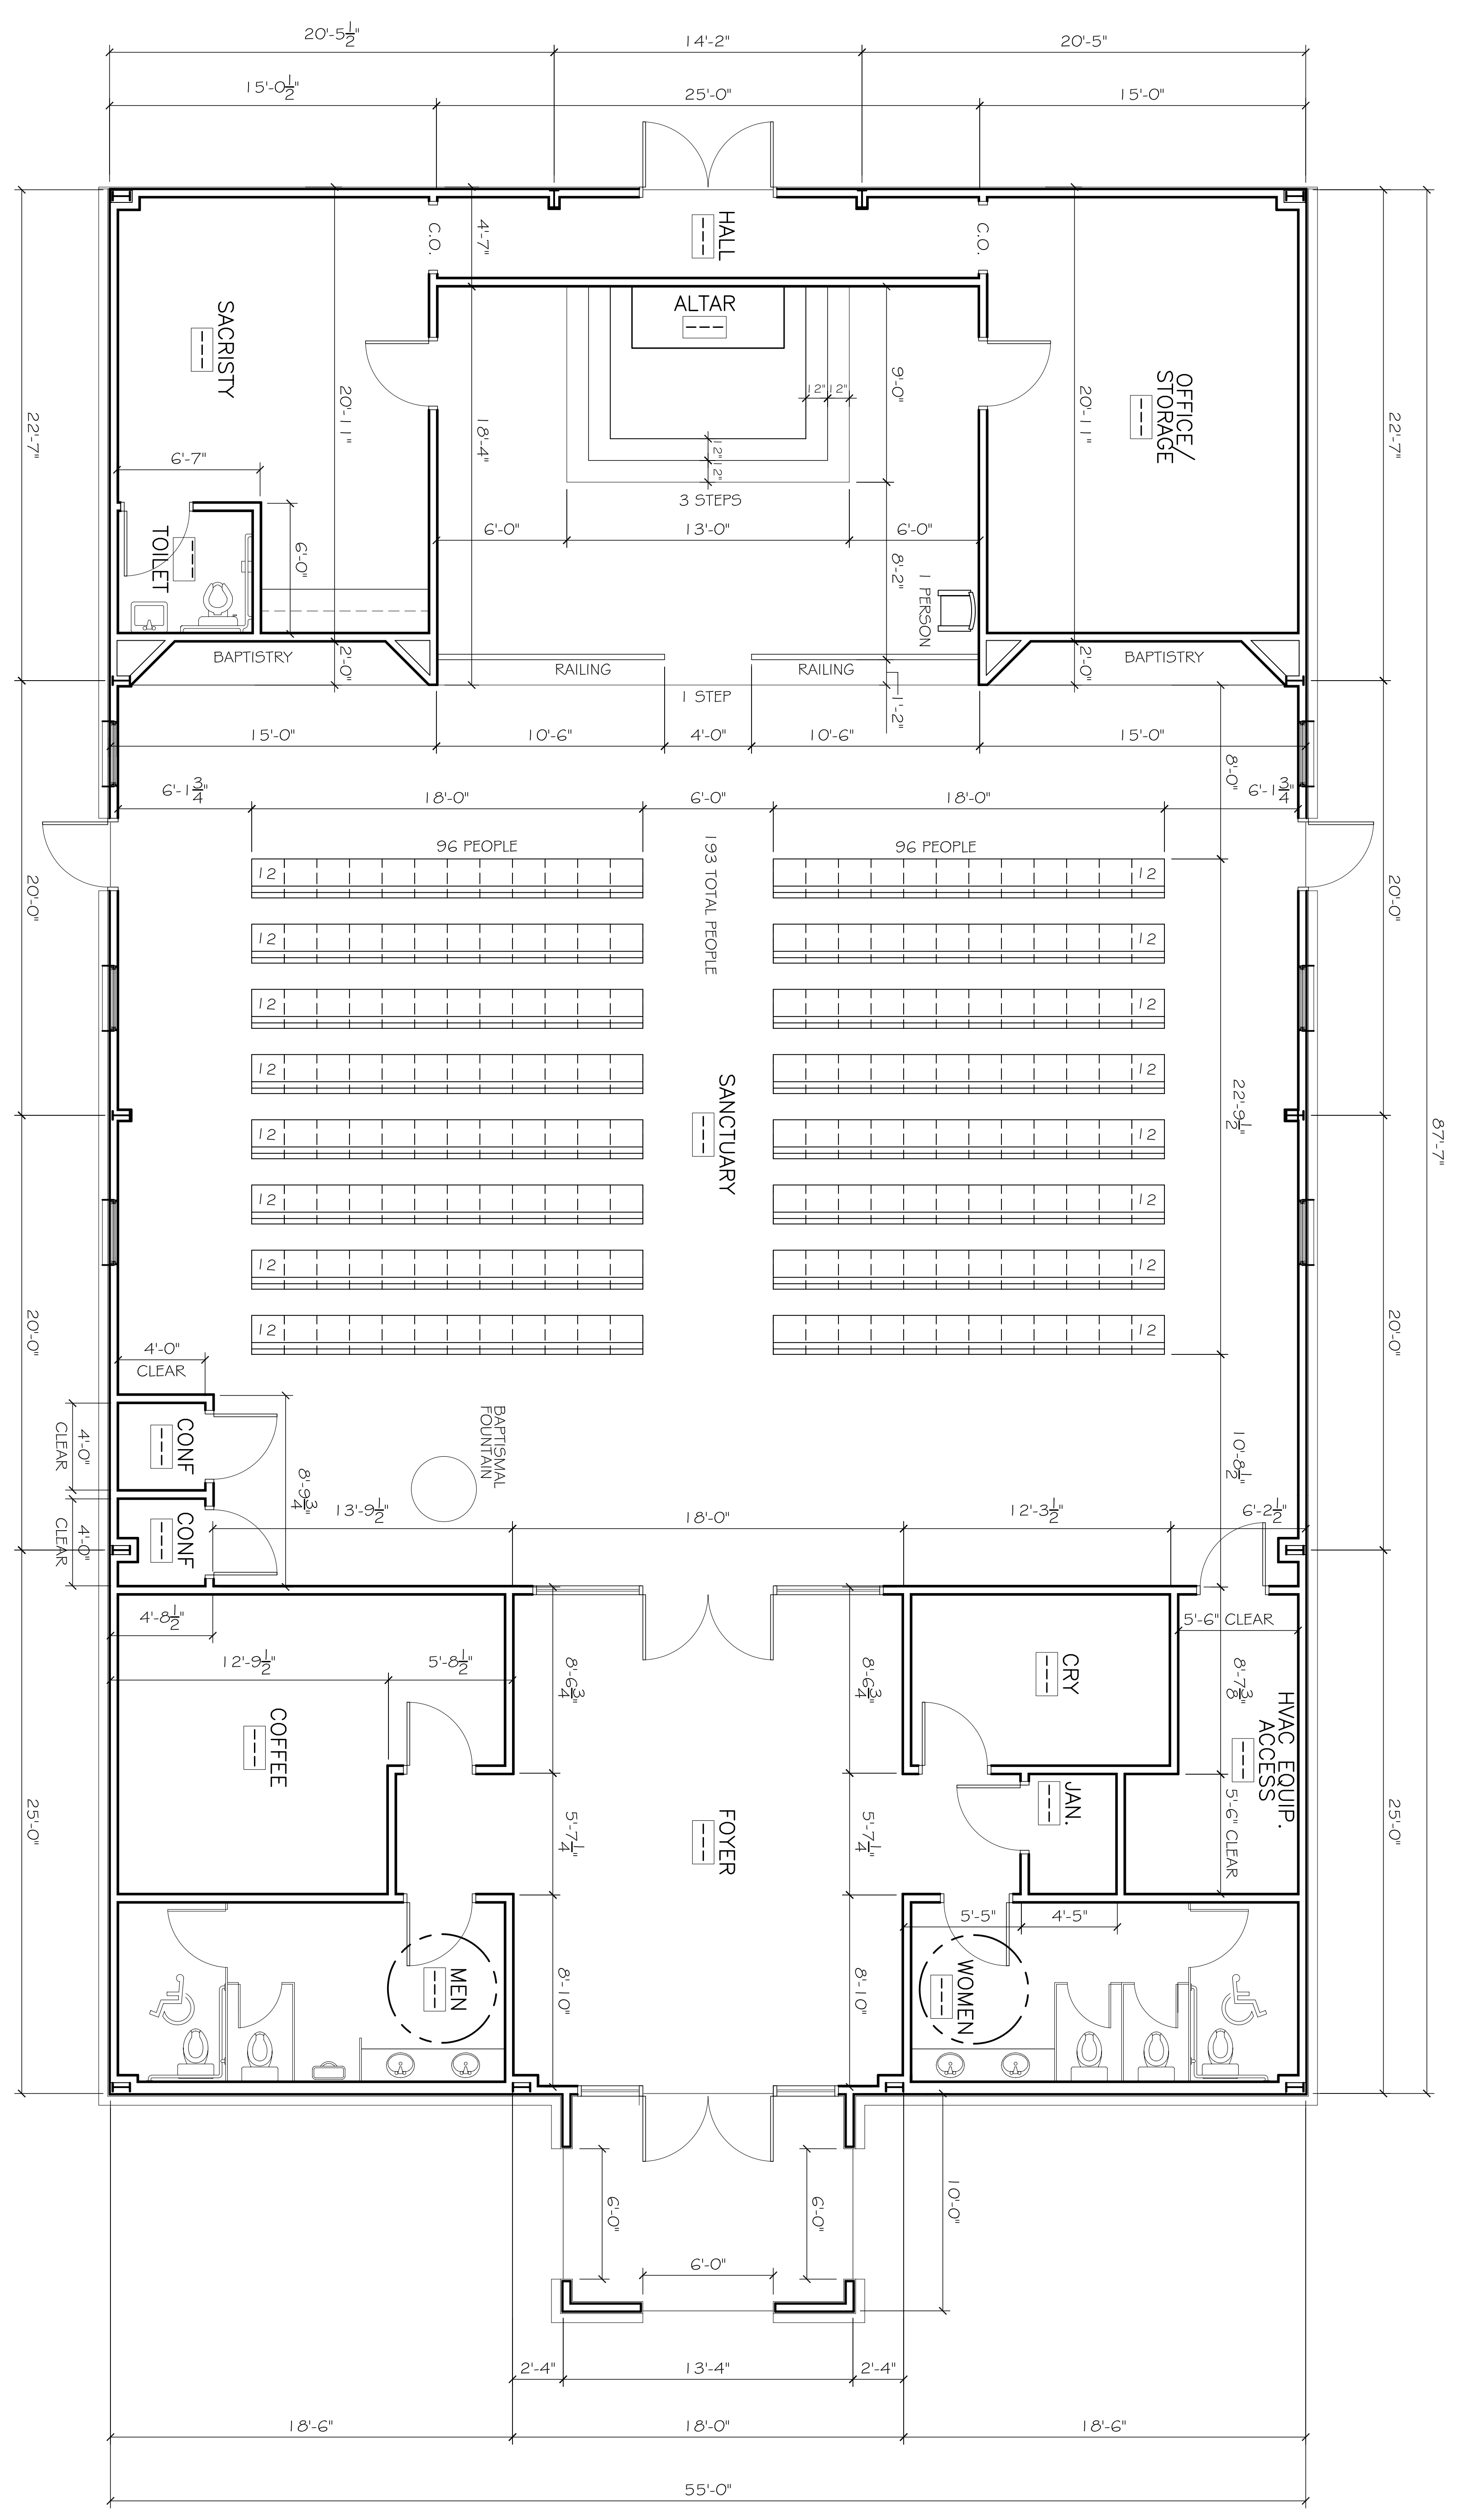

SHEET NO. **A101**

DRAWING NUMBER: **FLOOR PLAN**

**A NEW CATHOLIC CHURCH FOR THE ARCHDIOCESE OF NEW ORLEANS**  
 LACOMBE, LOUISIANA  
 JOB No: 2250 DATE: JULY 2015  
 DRAWN BY: JTL CHECKED BY: CKD

REVISIONS		DATE
#	DESCRIPTION	

**DAMMON ENGINEERING, INC.**  
 Architects & Engineers

Chief Architect: Kevin J. Kinchen, NCARB  
 Chief Engineer: Brian Mistich, PE  
 554 Old Spanish Trail  
 Slidell, LA 70458

www.dammonengineering.com  
 info@dammonengineering.com  
 PH: 985.649.5832  
 F: 985.641.5950