


NOTE A: LAVATORIES FOR TYPE "L3" LAVS SHALL BE FURNISHED AND INSTALLED BY THE PLUMBING CONTRACTOR, SHALL BE EQUAL TO CONCEPT SERIES BY HOME CREST CORP. COLONADE MODEL AVAILABLE THRU R.J. MARCHANT; # Y8836D - 21" DEEP, WITH CULTURED MARBLE TOP WITH 4" INTEGRALLY FORMED BACK AND END SPLASHES, AND LAV WITH ALL FITTINGS. FRONTS OF CABINETS MUST BE SMOOTH, NO MOLDINGS.


NOTE: ALL SPLAYED WALLS ARE AT A 45° ANGLE.
TYPICAL DIMENSIONS 11'-2"

ATRIUM [134]


KEY PLAN

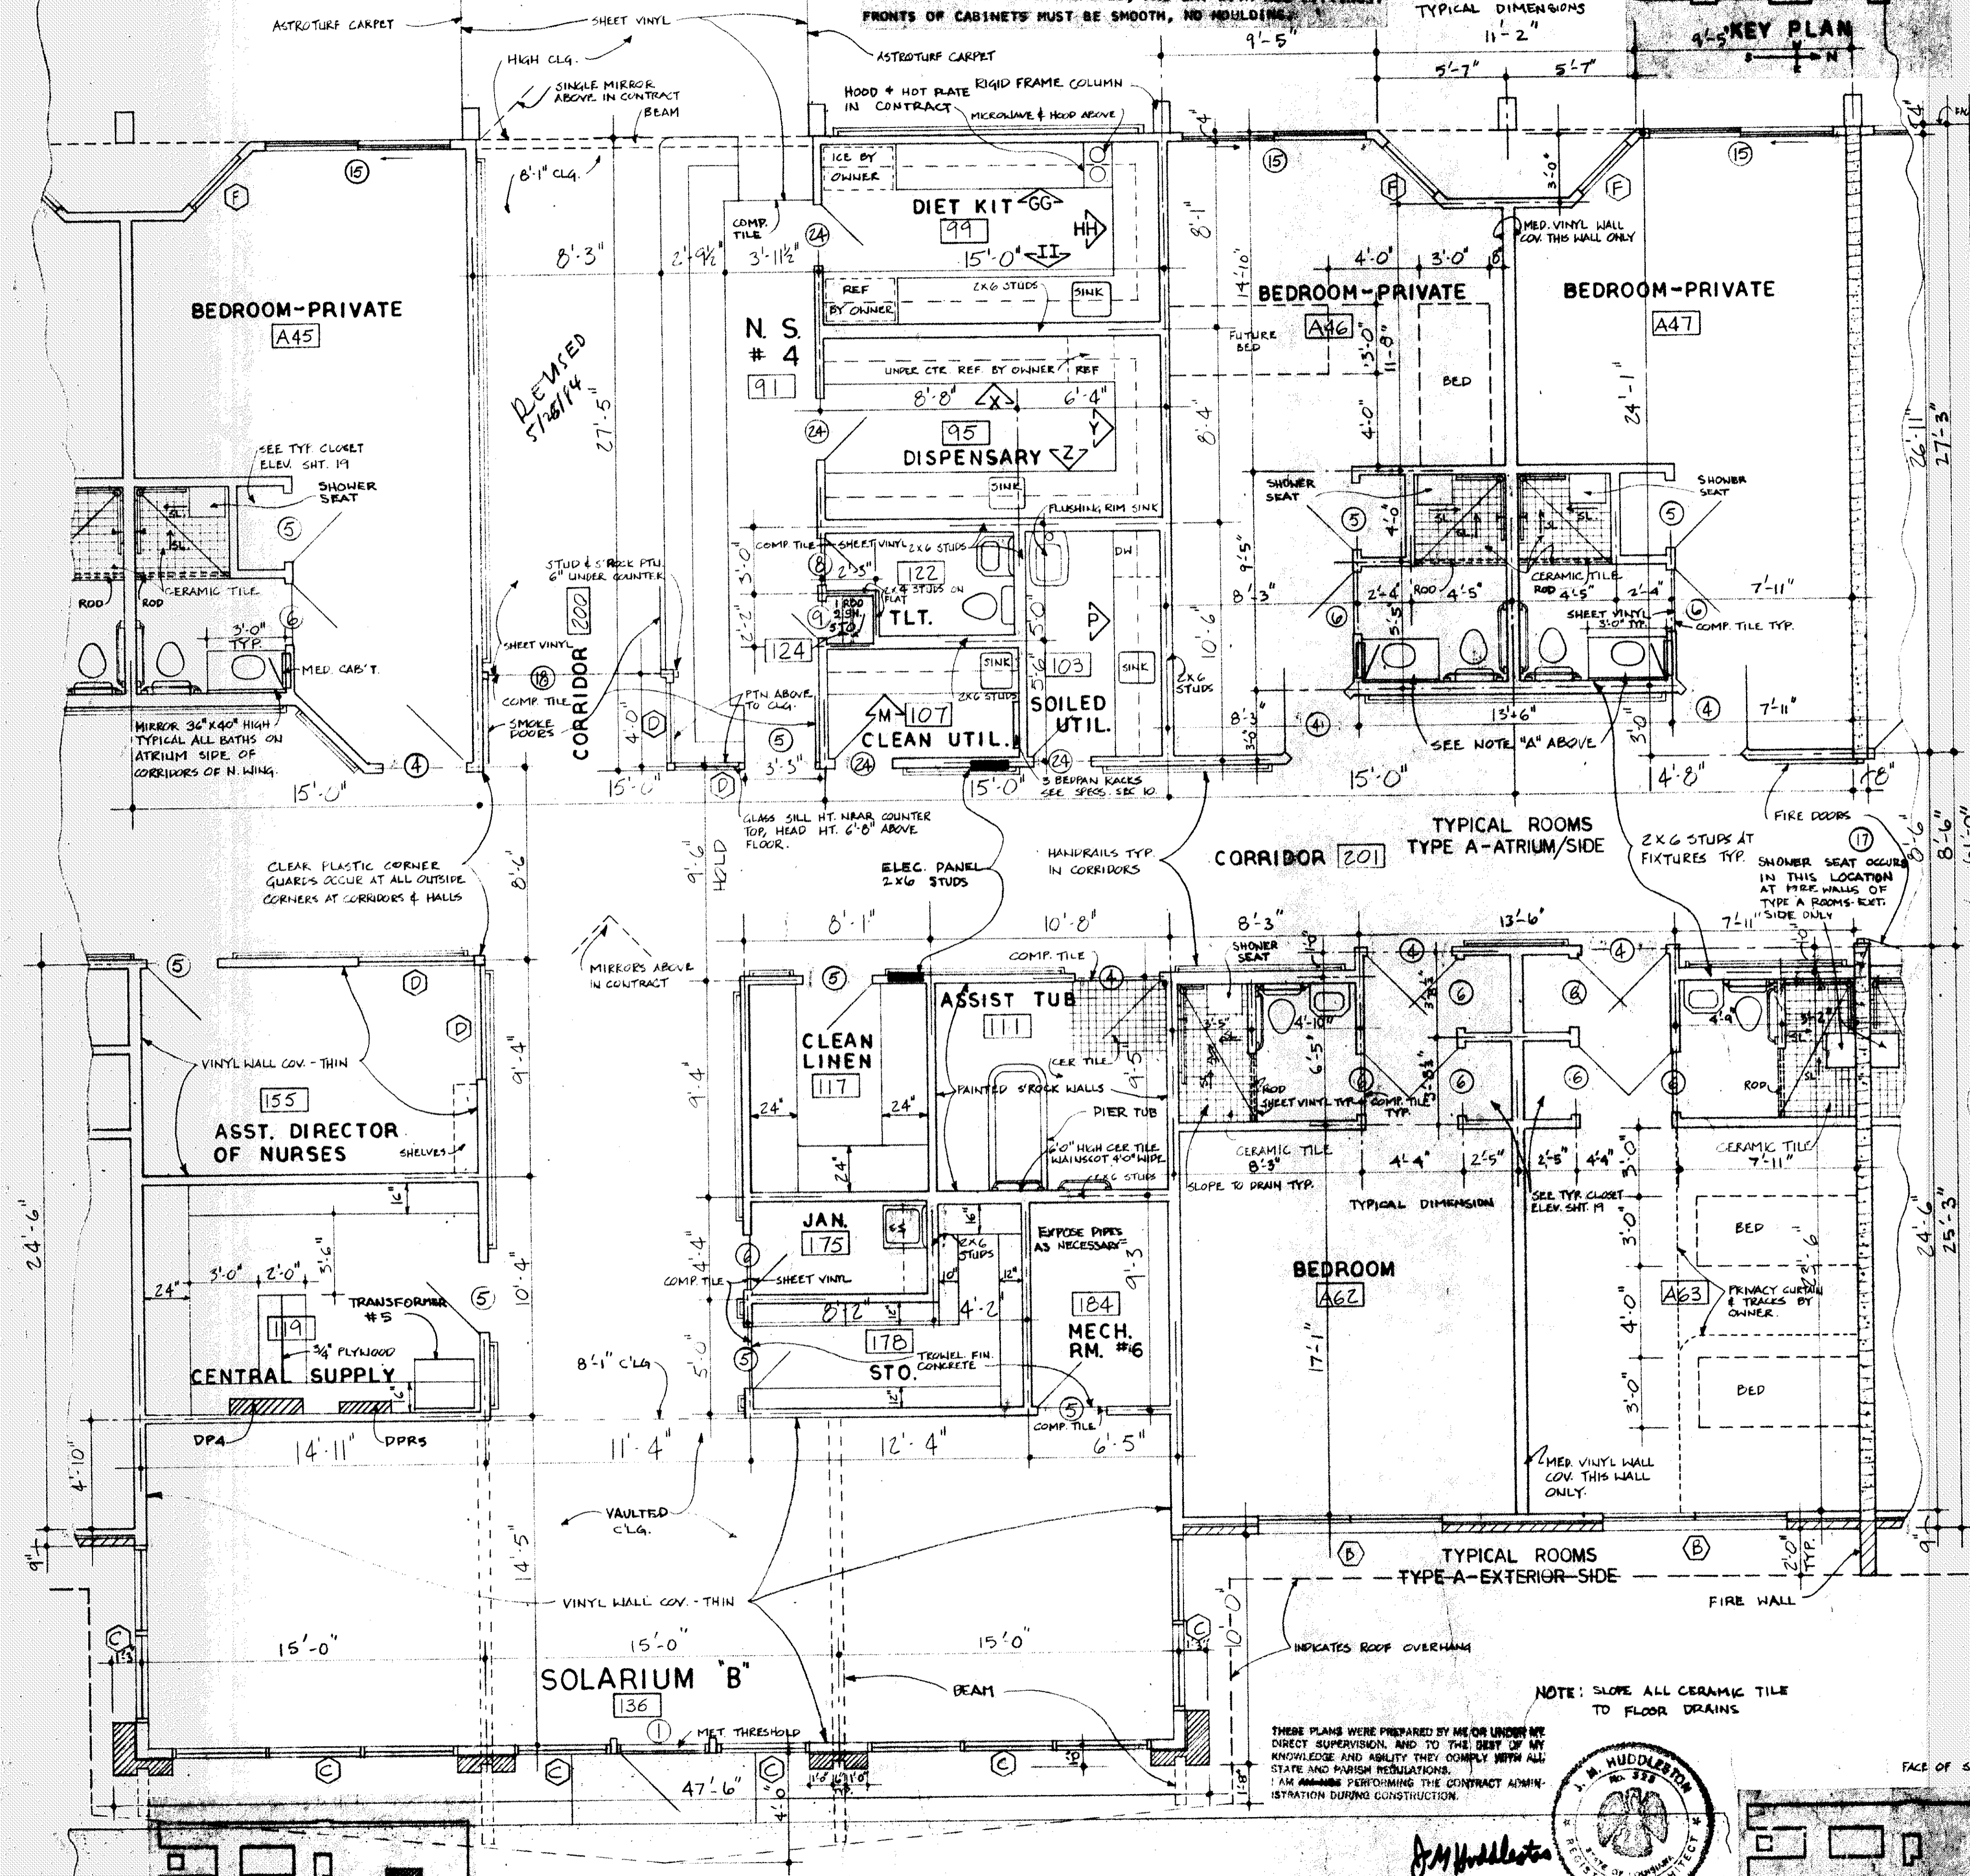

Nurses Station #4 Core Plan
SCALE 1/8" = 1'-0"

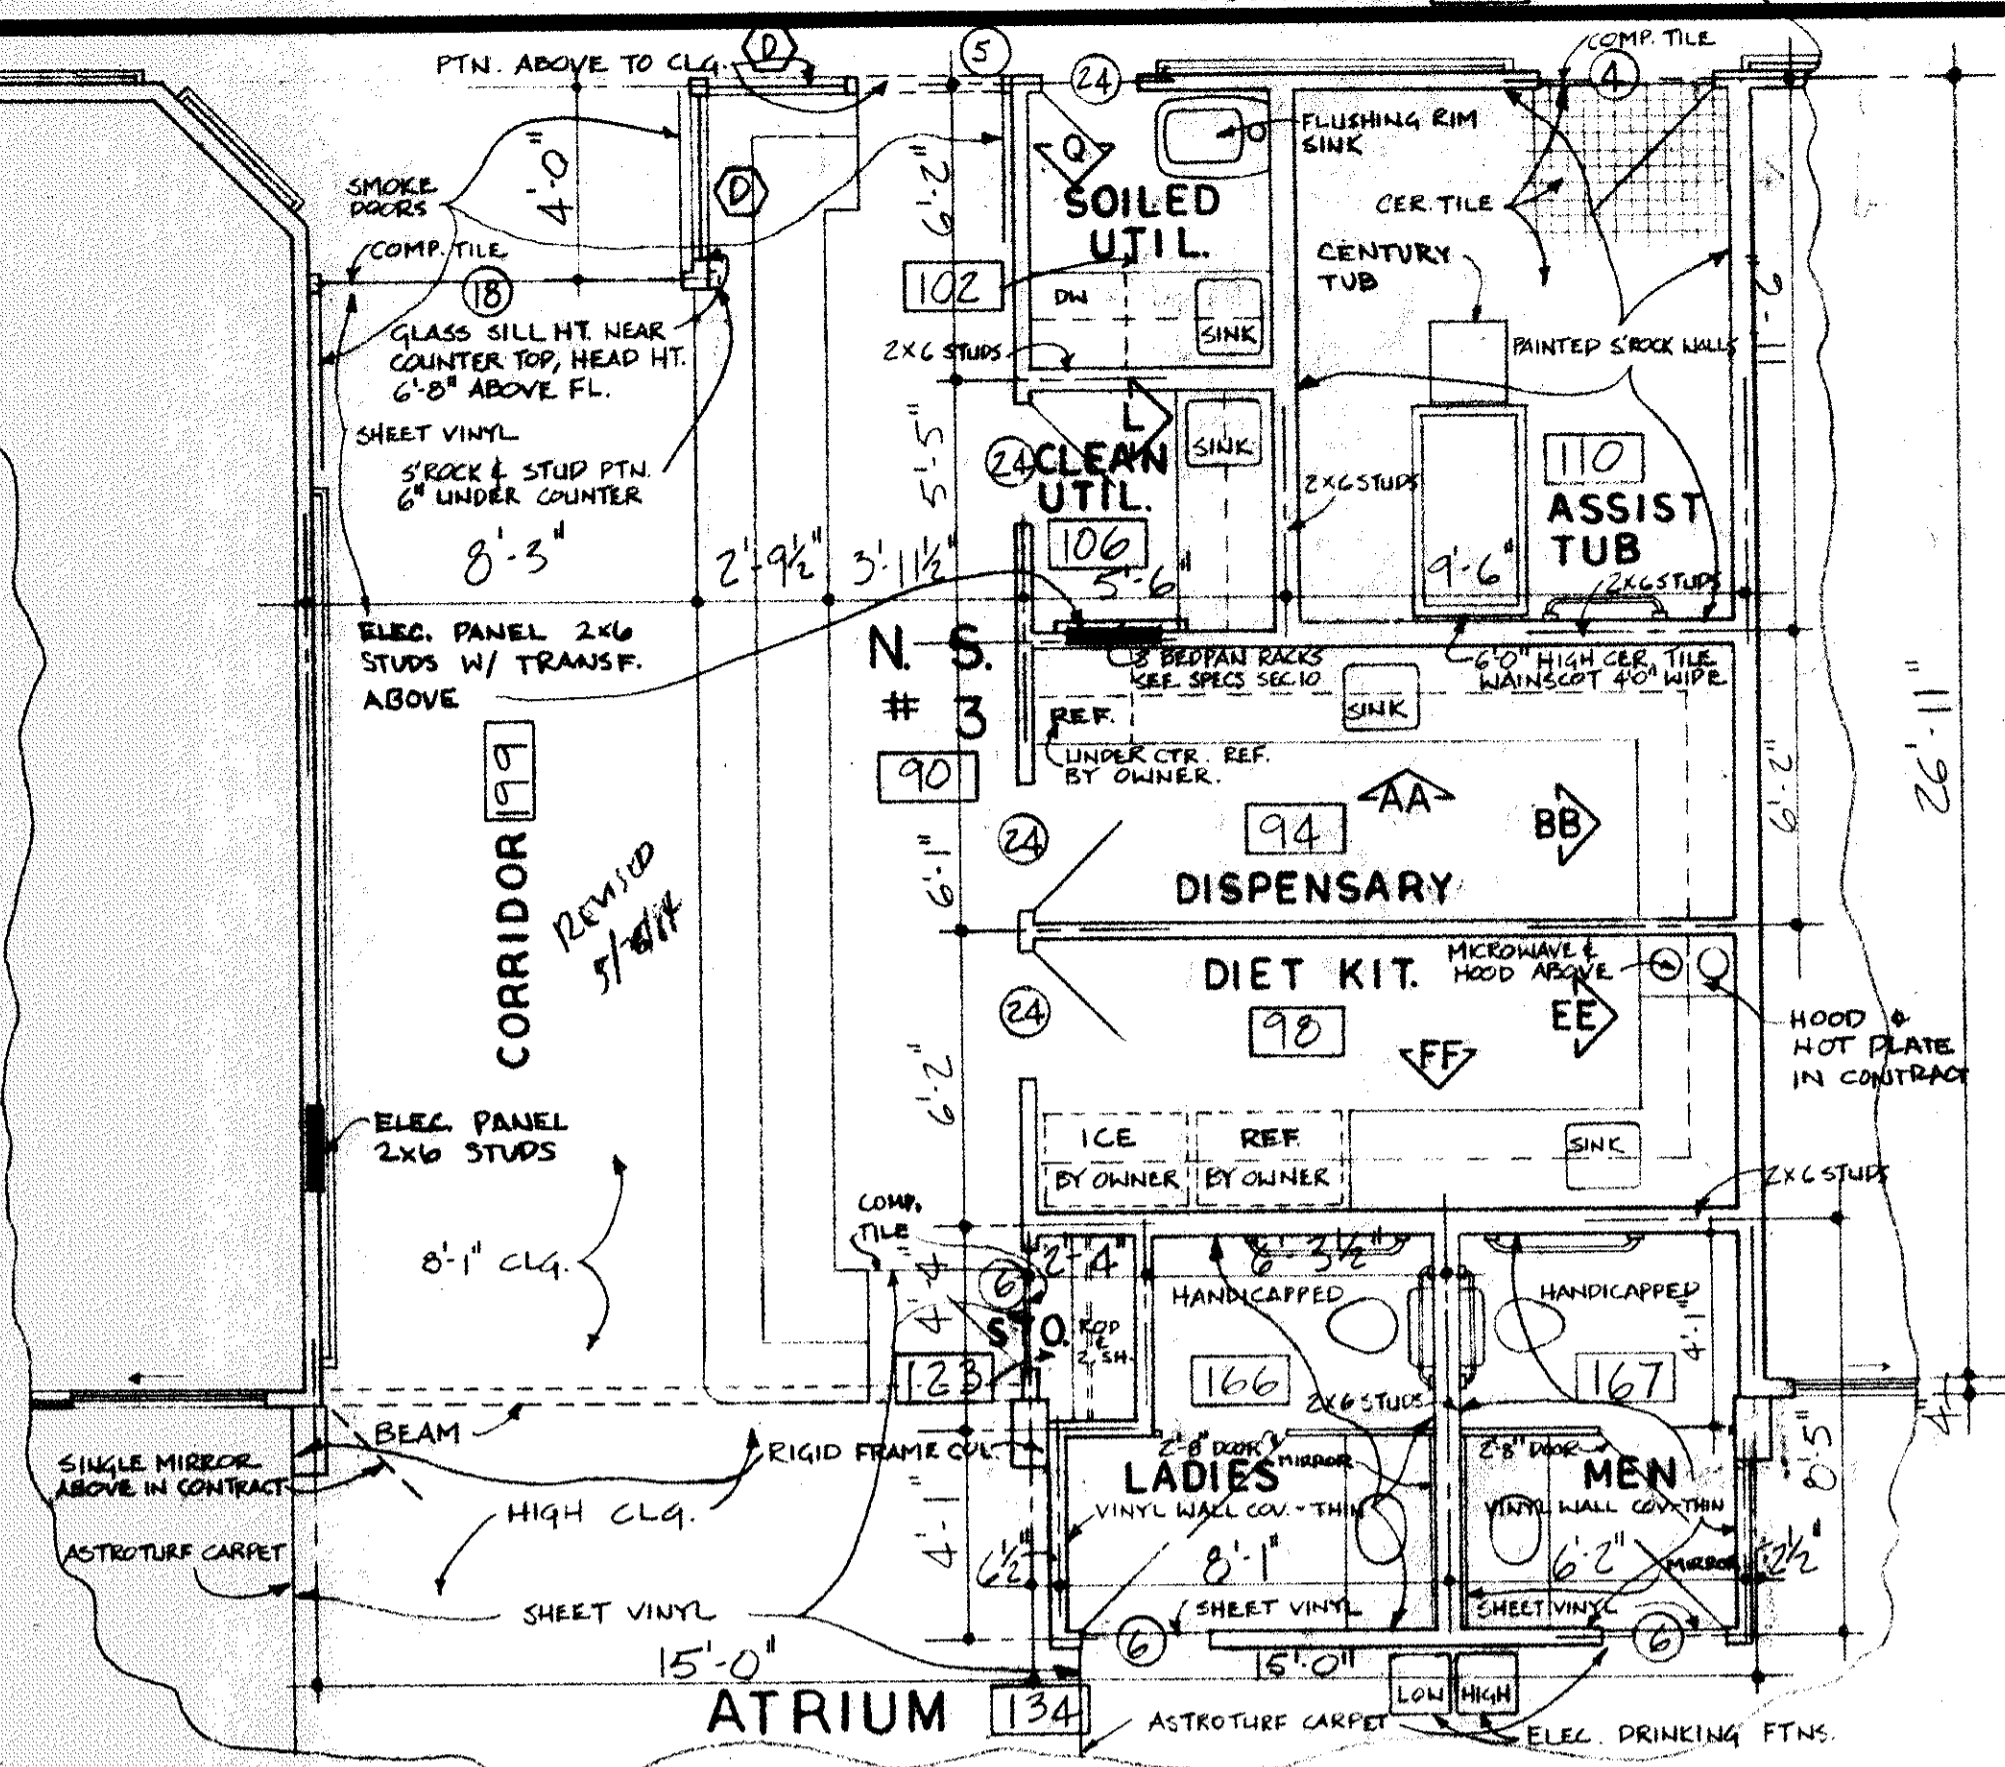

Nurses Station #3 Core Plan
SCALE 1/4" = 1'-0"

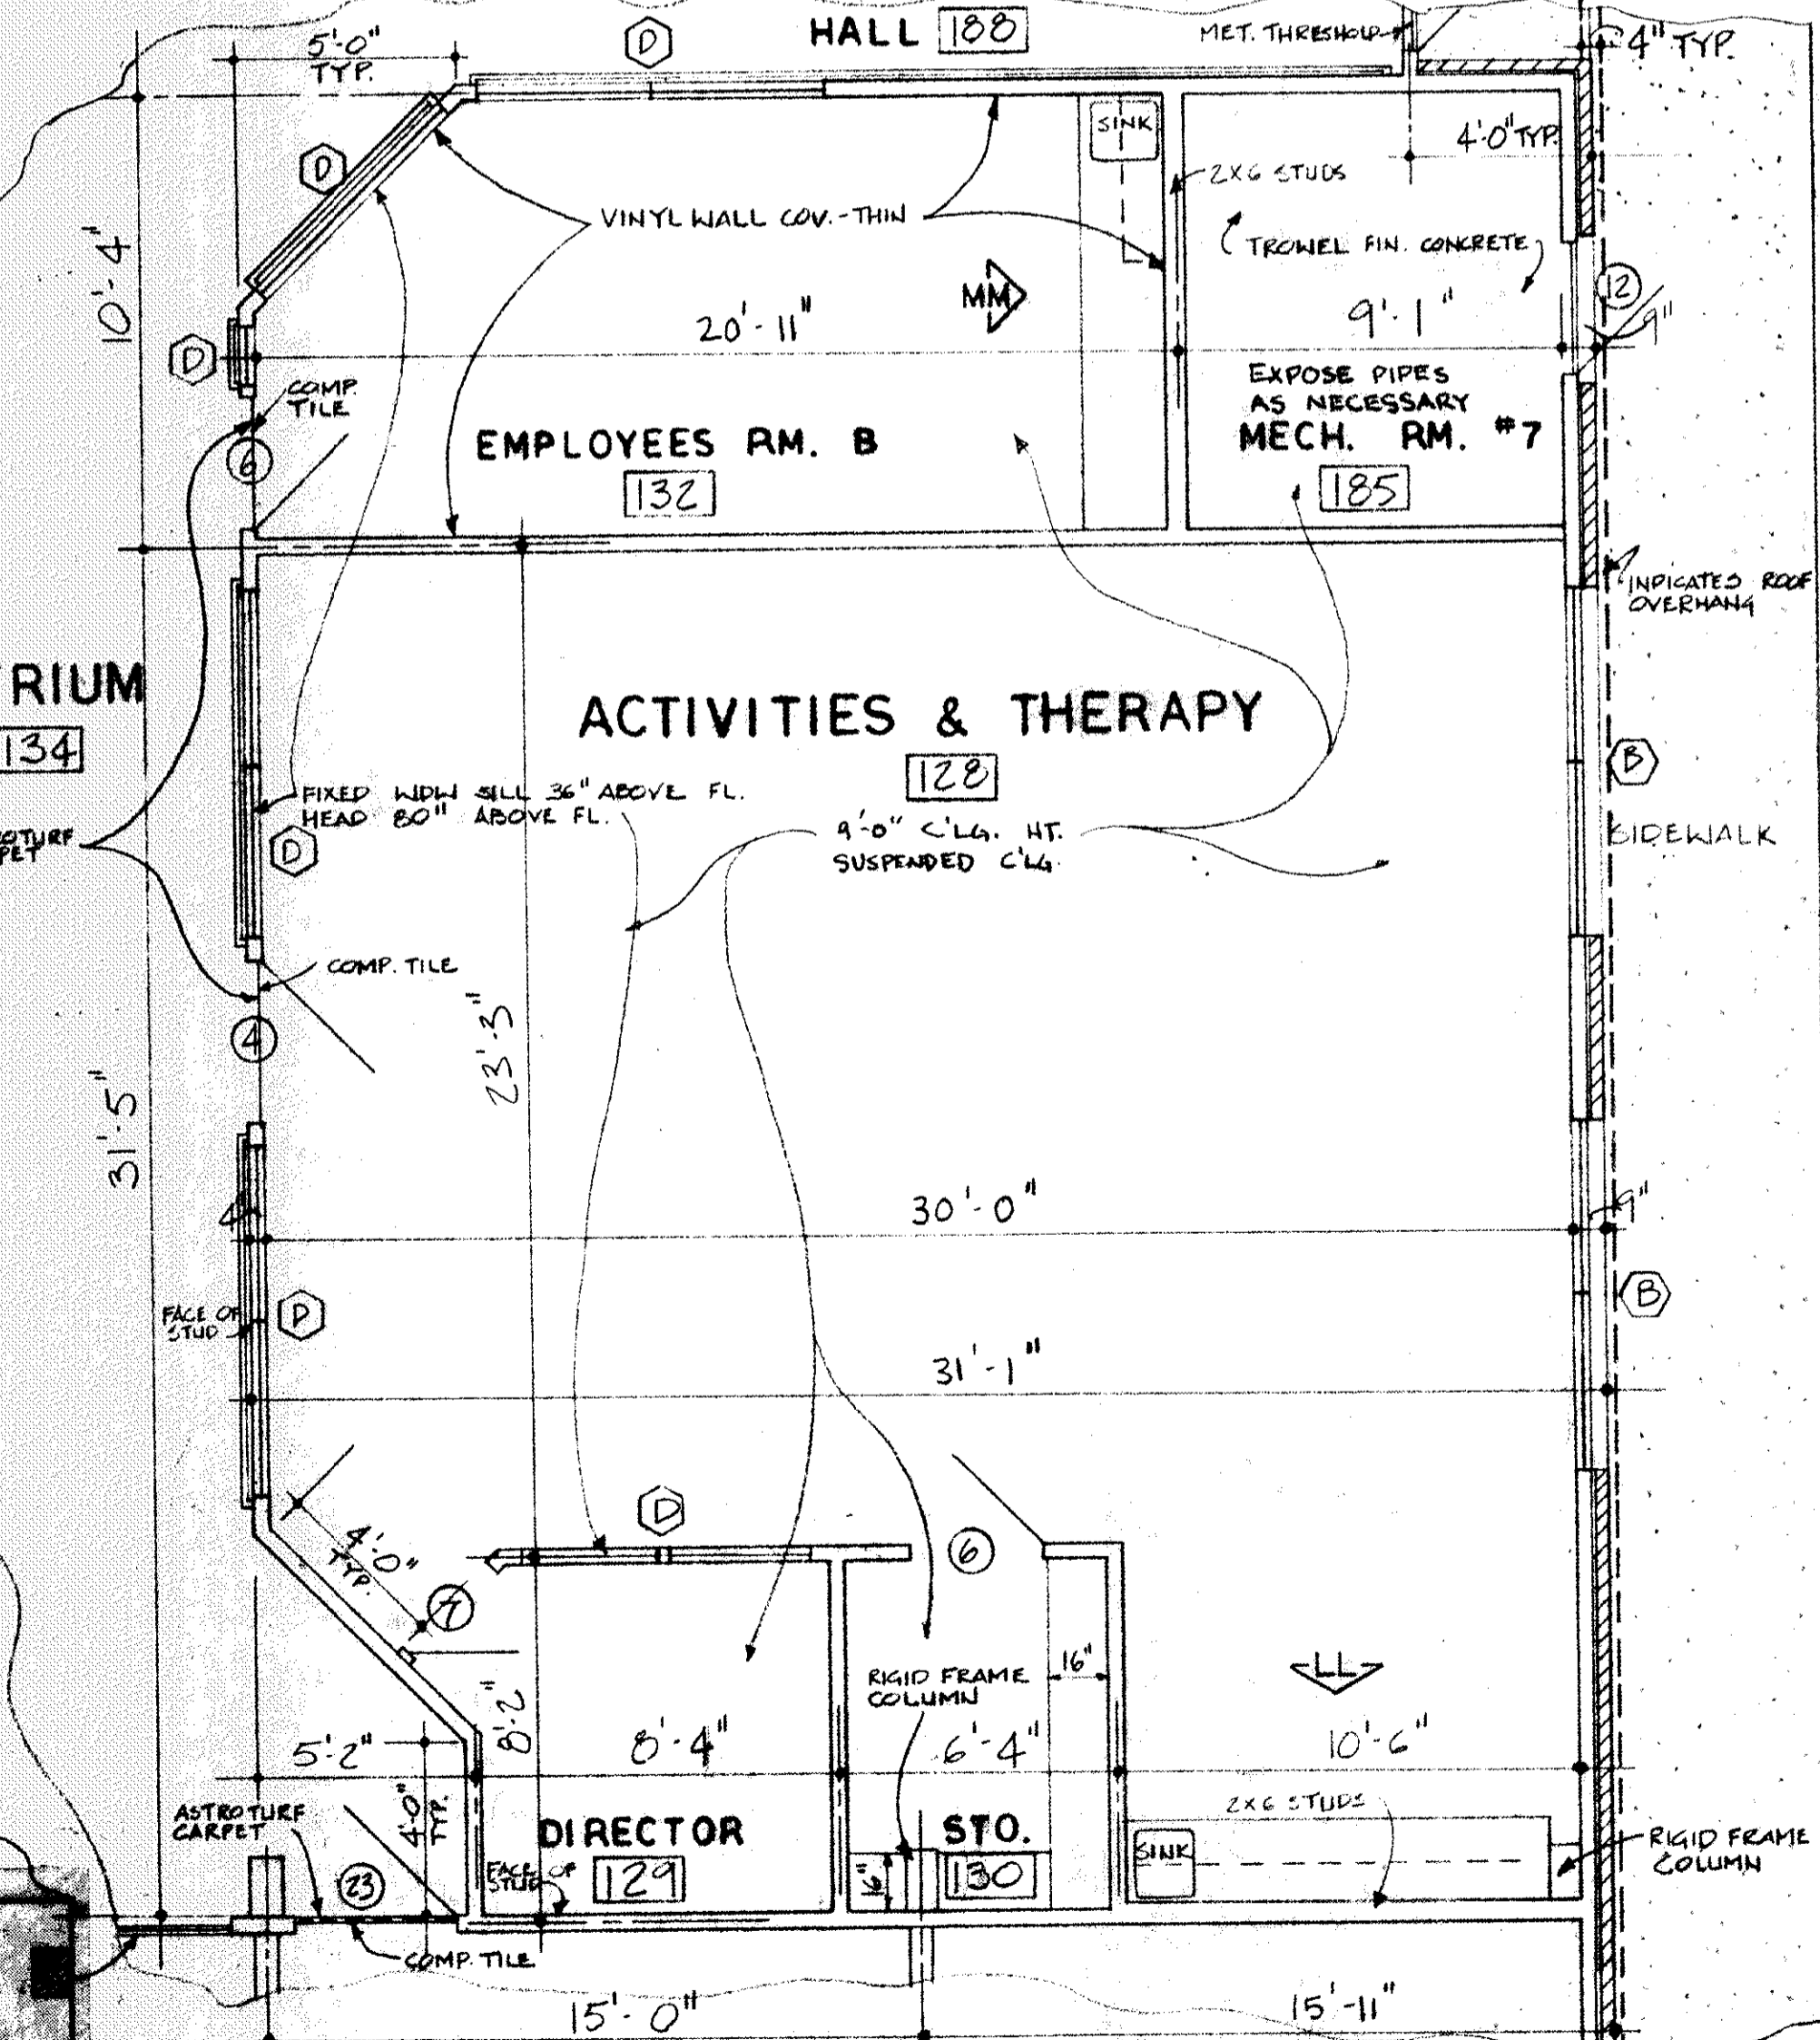

Activities & Therapy Floor Plan
SCALE 1/4" = 1'-0"

HUDDLESTON & WHITE ARCHITECTS - ENGINEERS
2001 N. HALLEN ST. METairie, LA 70002
J. M. HUDDLESTON, AIA (504) 887-5250
WILLIAM H. WHITE, P.E. (504) 394-4618

DATE: 9/15/03
SHEET NO. 9
OF 64 SHEETS