

**DAMMON ENGINEERING, INC.**

CHIEF ENGINEER  
EMMETT  
DAMMON, P.E.

CHIEF ARCHITECT  
ROBERT  
WILTSE

554 OLD SPANISH TRAIL  
SLIDELL, LA. 70458  
OFFICE: 985-649-5832  
FAX: 985-641-5950

WEBSITE:  
WWW.DAMMONENGINEERING.COM

EMAIL:  
DAMMONENG@BELLSOUTH.NET

ARCHITECTURE  
ENGINEERING  
STUDIES  
PLANNING  
INVESTIGATION  
EXPERT WITNESS

NEW  
RESIDENTIAL  
COMMUNITY  
HOME

STARC WEST  
1705 VIOLA ST  
MANDEVILLE, LA

POWER  
PLAN

REV: *Robert Wiltse*

SCALE: AS NOTED

JOB#: 2081

DATE: 04-08-2011

SHEET 14


E-1

OF 17

ELECTRICAL LEGEND		
SYM.	DESCRIPTION	NOTE NO.
⊕	STANDARD 120V DUPLEX RECEPT. @ 18" AFF (UNLESS NOTED)	
⊕D	DEDICATED RECEPTACLE SEE PNL SCHEDULE FOR CIRCUIT SIZE	
⊕GFI	GFI 120V DUPLEX RECEPTACLE @ 18" A.F.F. (UNLESS NOTED)	
⊕WP	WEATHER PROOF 120V DUPLEX RECEPT. @ 30" A.F.F. (UNLESS NOTED)	
⊕C	STANDARD 120V DUPLEX RECEPT. @ COUNTER HEIGHT	
⊕	FUSED POWER DISCONNECT	
▶	DUAL CAT.5 JACK WITH FACEPLATE NETWORKING CONNECTION	
(WH)	ELEC WATER HTR INSTALLED ON DECK ABOVE LOCATION INDICATED	
⊕	AIR CONDITIONING CONDENSOR UNIT SEE MECH SHEETS FOR UNIT DETAILS	
⊕	CEILING MTD MECHANICAL EXHAUST FAN	
⊕	ELECTRIC PANEL SEE SHEET E-3 FOR PANEL SCHEDULE	
⊕SD	SMOKE DETECTOR, U.L. LISTED, PHOTOELECTRIC, DIGITAL, INTELLIGENT	1

**EQUIPMENT NOTES:**

1. SMOKE AND HEAT DETECTORS SHALL NOT BE INSTALLED CLOSER THAN 1'-0" TO A LIGHT FIXTURE OR WITHIN 3'-0" FROM A HVAC AHU/RTU AIR SUPPLY DIFFUSER.

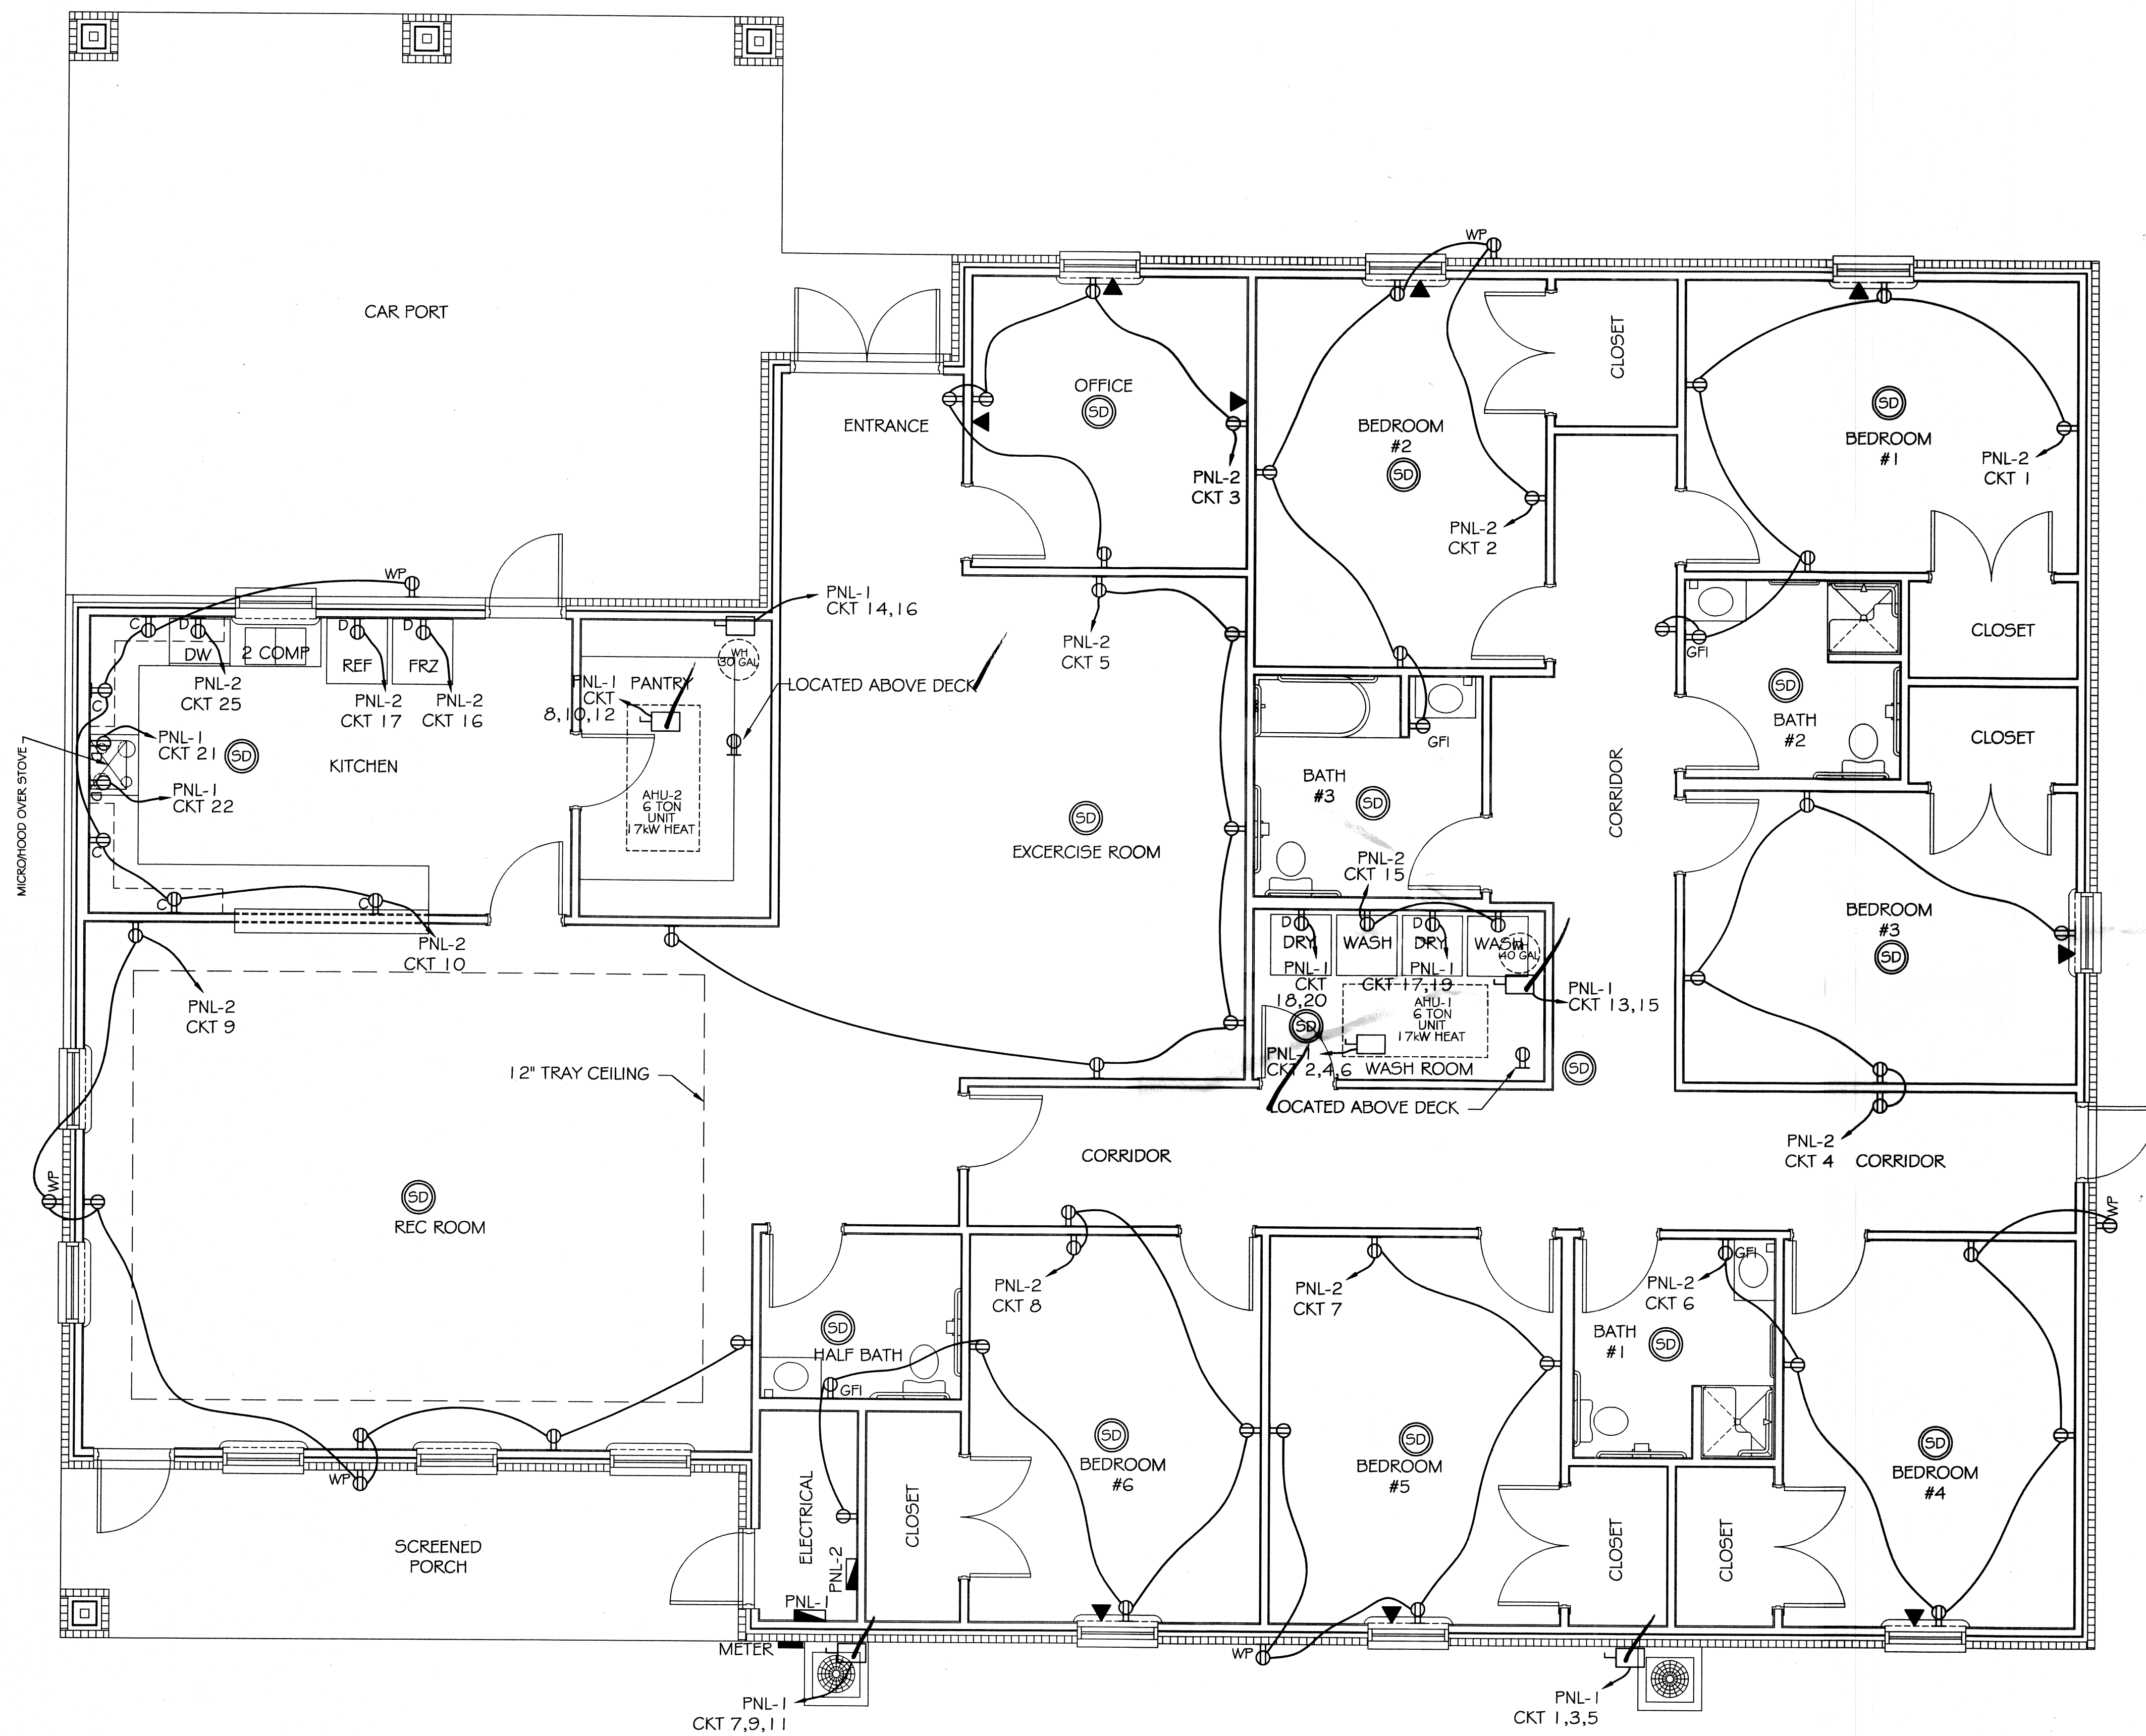

**POWER PLAN**  
SCALE: 1/4"=1'