

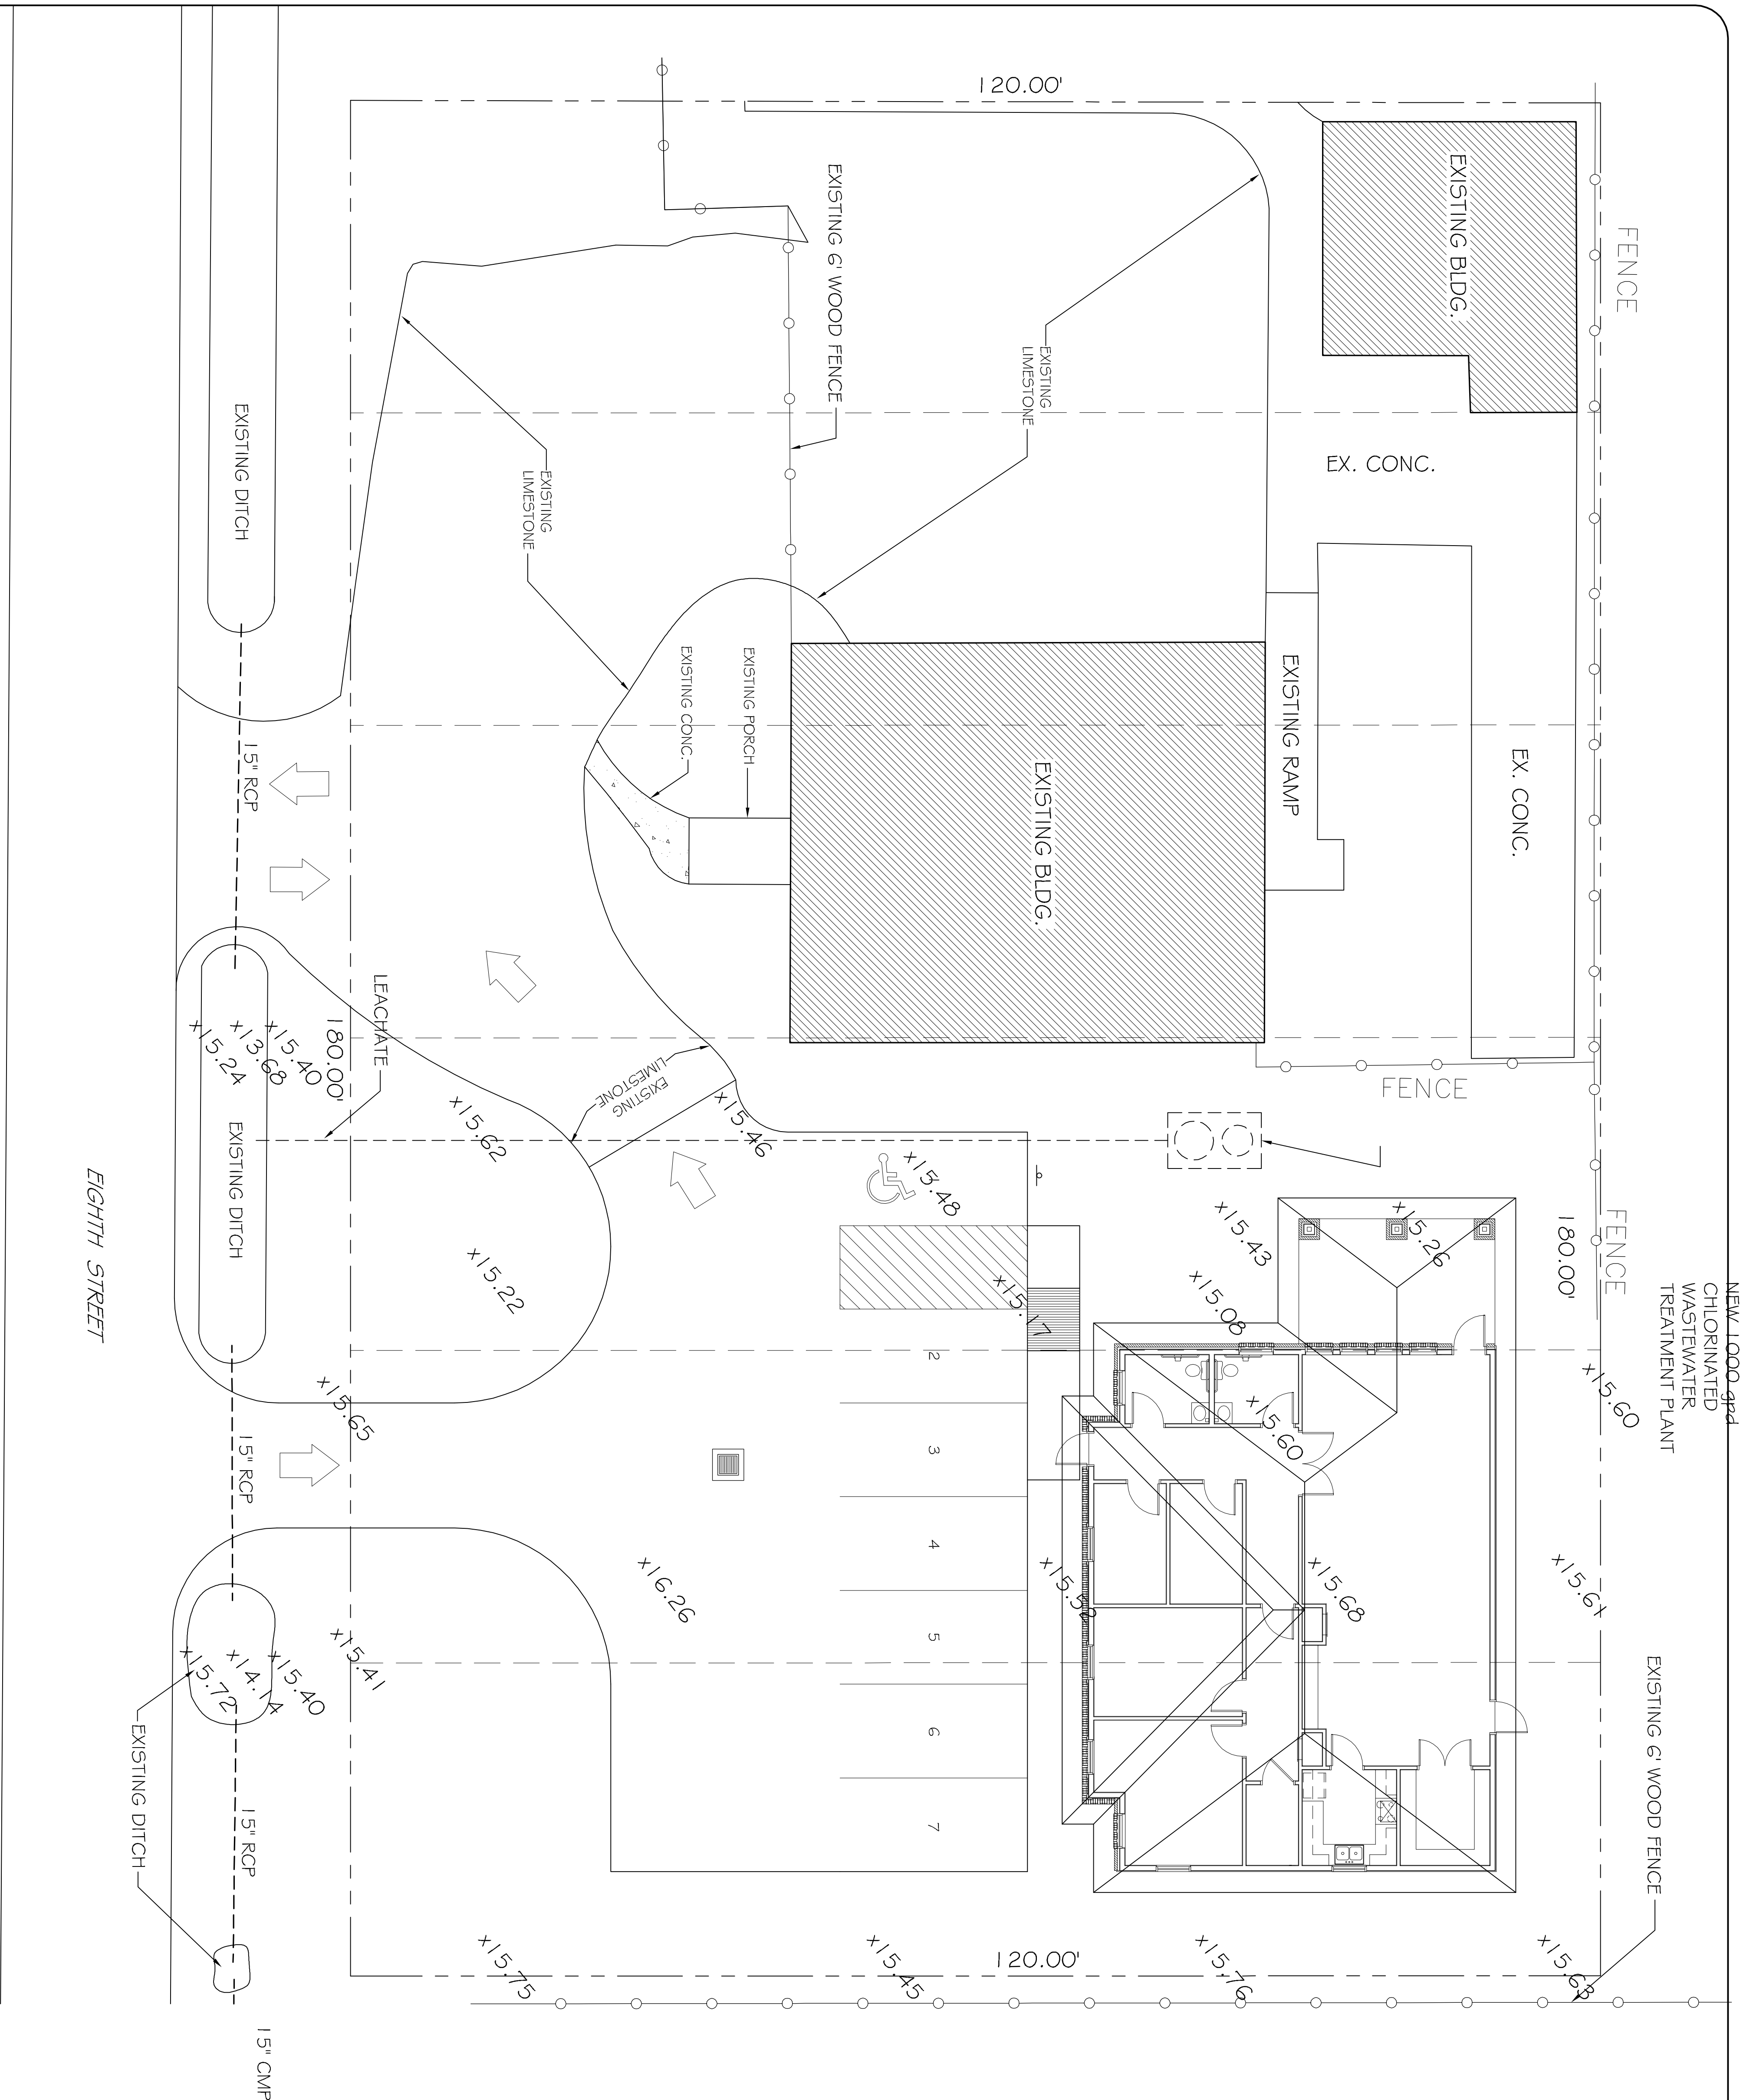


NEW 1000-gpd  
CHLORINATED  
WASTEWATER  
TREATMENT PLANT

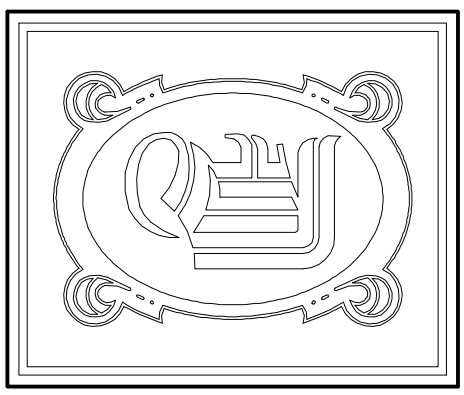

SITE PLAN  
SCALE: 1/8" = 1'-0"

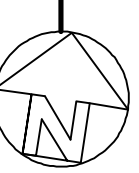

**DAMMON**  
ENGINEERING, INC.

CHIEF ENGINEER  
EMMETT  
DAMMON, P.E.  
CHIEF ARCHITECT  
ROBERT  
WILTSE

554 OLD SPANISH TRAIL  
SLIDELL, LA, 70458  
OFFICE: 985-649-5632  
FAX: 985-641-5950

WEBSITE:  
WWW.DAMMONENGINEERING.COM  
EMAIL:  
DAMMONENG@BELL.SOUTH.NET

ARCHITECTURE  
ENGINEERING  
STUDIES  
PLANNING  
INVESTIGATION  
EXPERT WITNESSES

PAUL REES  
OFFICE BUILDING  
2275 8TH. ST.  
MANDVILLE, LA  
70471

SITE  
PLAN

REV:  
SCALE: AS NOTED  
JOB#: 2104  
DATE: 03-29-11  
SHEET

C-2

OF