

POWER PLAN LEGEND	
SYMBOL	DESCRIPTION
⊖	STANDARD 120V BULKHEAD RECEPTACLE @ 2' AFF WALLS/RECEPTACLES
⊖	GROUNDING RECEPTACLE @ 2' AFF WALLS/RECEPTACLES
⊖	RECEPTACLE @ 6' AFF WALLS/RECEPTACLES
⊖	RECEPTACLE @ 8' AFF WALLS/RECEPTACLES
⊖	RECEPTACLE @ 10' AFF WALLS/RECEPTACLES
⊖	RECEPTACLE @ 12' AFF WALLS/RECEPTACLES
⊖	RECEPTACLE @ 14' AFF WALLS/RECEPTACLES
⊖	RECEPTACLE @ 16' AFF WALLS/RECEPTACLES
⊖	RECEPTACLE @ 18' AFF WALLS/RECEPTACLES
⊖	RECEPTACLE @ 20' AFF WALLS/RECEPTACLES
⊖	RECEPTACLE @ 22' AFF WALLS/RECEPTACLES
⊖	RECEPTACLE @ 24' AFF WALLS/RECEPTACLES
⊖	RECEPTACLE @ 26' AFF WALLS/RECEPTACLES
⊖	RECEPTACLE @ 28' AFF WALLS/RECEPTACLES
⊖	RECEPTACLE @ 30' AFF WALLS/RECEPTACLES
⊖	RECEPTACLE @ 32' AFF WALLS/RECEPTACLES
⊖	RECEPTACLE @ 34' AFF WALLS/RECEPTACLES
⊖	RECEPTACLE @ 36' AFF WALLS/RECEPTACLES
⊖	RECEPTACLE @ 38' AFF WALLS/RECEPTACLES
⊖	RECEPTACLE @ 40' AFF WALLS/RECEPTACLES
⊖	RECEPTACLE @ 42' AFF WALLS/RECEPTACLES
⊖	RECEPTACLE @ 44' AFF WALLS/RECEPTACLES
⊖	RECEPTACLE @ 46' AFF WALLS/RECEPTACLES
⊖	RECEPTACLE @ 48' AFF WALLS/RECEPTACLES
⊖	RECEPTACLE @ 50' AFF WALLS/RECEPTACLES
⊖	RECEPTACLE @ 52' AFF WALLS/RECEPTACLES
⊖	RECEPTACLE @ 54' AFF WALLS/RECEPTACLES
⊖	RECEPTACLE @ 56' AFF WALLS/RECEPTACLES
⊖	RECEPTACLE @ 58' AFF WALLS/RECEPTACLES
⊖	RECEPTACLE @ 60' AFF WALLS/RECEPTACLES
⊖	RECEPTACLE @ 62' AFF WALLS/RECEPTACLES
⊖	RECEPTACLE @ 64' AFF WALLS/RECEPTACLES
⊖	RECEPTACLE @ 66' AFF WALLS/RECEPTACLES
⊖	RECEPTACLE @ 68' AFF WALLS/RECEPTACLES
⊖	RECEPTACLE @ 70' AFF WALLS/RECEPTACLES
⊖	RECEPTACLE @ 72' AFF WALLS/RECEPTACLES
⊖	RECEPTACLE @ 74' AFF WALLS/RECEPTACLES
⊖	RECEPTACLE @ 76' AFF WALLS/RECEPTACLES
⊖	RECEPTACLE @ 78' AFF WALLS/RECEPTACLES
⊖	RECEPTACLE @ 80' AFF WALLS/RECEPTACLES
⊖	RECEPTACLE @ 82' AFF WALLS/RECEPTACLES
⊖	RECEPTACLE @ 84' AFF WALLS/RECEPTACLES
⊖	RECEPTACLE @ 86' AFF WALLS/RECEPTACLES
⊖	RECEPTACLE @ 88' AFF WALLS/RECEPTACLES
⊖	RECEPTACLE @ 90' AFF WALLS/RECEPTACLES
⊖	RECEPTACLE @ 92' AFF WALLS/RECEPTACLES
⊖	RECEPTACLE @ 94' AFF WALLS/RECEPTACLES
⊖	RECEPTACLE @ 96' AFF WALLS/RECEPTACLES
⊖	RECEPTACLE @ 98' AFF WALLS/RECEPTACLES
⊖	RECEPTACLE @ 100' AFF WALLS/RECEPTACLES


EQUIPMENT NOTES:

1. EQUIPMENT LAYOUT, ELECTRICAL AND MECHANICAL DETAILS ARE BASED ON THE INFORMATION PROVIDED BY THE OWNER. CONTRACTOR TO VERIFY ALL INFORMATION AND ELECTRICAL REQUIREMENTS WITH THE OWNER.
2. CONTRACTOR TO COORDINATE EQUIPMENT REQUIREMENTS WITH ARCHITECTURAL AND MECHANICAL CONTRACTORS.
3. SMALL DEVICES SHALL NOT BE INSTALLED UNDER DESKTOPS, UNDER COUNTERS OR IN THE 3'-0" FROM A WALL/CEILING AREA UNLESS SPECIFICALLY NOTED.
4. MECHANICAL CONTRACTOR SHALL PROVIDE ALL NECESSARY MECHANICAL CONTRACTOR WORK AND SHALL BE RESPONSIBLE FOR THE PROTECTION OF ALL MECHANICAL CONTRACTOR WORK.
5. CONTRACTOR SHALL VERIFY THE LOCATION, TYPE AND SIZE OF ALL MECHANICAL CONTRACTOR WORK.
6. CONTRACTOR SHALL VERIFY THE LOCATION, TYPE AND SIZE OF ALL MECHANICAL CONTRACTOR WORK.
7. CONTRACTOR SHALL VERIFY THE LOCATION, TYPE AND SIZE OF ALL MECHANICAL CONTRACTOR WORK.
8. CONTRACTOR SHALL VERIFY THE LOCATION, TYPE AND SIZE OF ALL MECHANICAL CONTRACTOR WORK.
9. CONTRACTOR SHALL VERIFY THE LOCATION, TYPE AND SIZE OF ALL MECHANICAL CONTRACTOR WORK.
10. CONTRACTOR SHALL VERIFY THE LOCATION, TYPE AND SIZE OF ALL MECHANICAL CONTRACTOR WORK.
11. CONTRACTOR SHALL VERIFY THE LOCATION, TYPE AND SIZE OF ALL MECHANICAL CONTRACTOR WORK.
12. CONTRACTOR SHALL VERIFY THE LOCATION, TYPE AND SIZE OF ALL MECHANICAL CONTRACTOR WORK.
13. CONTRACTOR SHALL VERIFY THE LOCATION, TYPE AND SIZE OF ALL MECHANICAL CONTRACTOR WORK.
14. CONTRACTOR SHALL VERIFY THE LOCATION, TYPE AND SIZE OF ALL MECHANICAL CONTRACTOR WORK.
15. CONTRACTOR SHALL VERIFY THE LOCATION, TYPE AND SIZE OF ALL MECHANICAL CONTRACTOR WORK.
16. CONTRACTOR SHALL VERIFY THE LOCATION, TYPE AND SIZE OF ALL MECHANICAL CONTRACTOR WORK.
17. CONTRACTOR SHALL VERIFY THE LOCATION, TYPE AND SIZE OF ALL MECHANICAL CONTRACTOR WORK.
18. CONTRACTOR SHALL VERIFY THE LOCATION, TYPE AND SIZE OF ALL MECHANICAL CONTRACTOR WORK.
19. CONTRACTOR SHALL VERIFY THE LOCATION, TYPE AND SIZE OF ALL MECHANICAL CONTRACTOR WORK.
20. CONTRACTOR SHALL VERIFY THE LOCATION, TYPE AND SIZE OF ALL MECHANICAL CONTRACTOR WORK.

ELECTRICAL NOTES:

1. ALL WORK SHALL CONFORM TO THE LATEST EDITION OF THE NATIONAL ELECTRICAL CODE AND ALL OTHER APPLICABLE CODES AND REGULATIONS.
2. THE DRAWINGS INDICATE SIZE AND GENERAL LOCATION OF WORK. SMALL DIMENSIONS SHALL NOT BE USED. THE EXACT LOCATION AND SIZE OF WORK SHALL BE DETERMINED BY THE CONTRACTOR.
3. CONTRACTOR SHALL VERIFY THE LOCATION, TYPE AND SIZE OF ALL MECHANICAL CONTRACTOR WORK.
4. CONTRACTOR SHALL VERIFY THE LOCATION, TYPE AND SIZE OF ALL MECHANICAL CONTRACTOR WORK.
5. CONTRACTOR SHALL VERIFY THE LOCATION, TYPE AND SIZE OF ALL MECHANICAL CONTRACTOR WORK.
6. CONTRACTOR SHALL VERIFY THE LOCATION, TYPE AND SIZE OF ALL MECHANICAL CONTRACTOR WORK.
7. CONTRACTOR SHALL VERIFY THE LOCATION, TYPE AND SIZE OF ALL MECHANICAL CONTRACTOR WORK.
8. CONTRACTOR SHALL VERIFY THE LOCATION, TYPE AND SIZE OF ALL MECHANICAL CONTRACTOR WORK.
9. CONTRACTOR SHALL VERIFY THE LOCATION, TYPE AND SIZE OF ALL MECHANICAL CONTRACTOR WORK.
10. CONTRACTOR SHALL VERIFY THE LOCATION, TYPE AND SIZE OF ALL MECHANICAL CONTRACTOR WORK.
11. CONTRACTOR SHALL VERIFY THE LOCATION, TYPE AND SIZE OF ALL MECHANICAL CONTRACTOR WORK.
12. CONTRACTOR SHALL VERIFY THE LOCATION, TYPE AND SIZE OF ALL MECHANICAL CONTRACTOR WORK.
13. CONTRACTOR SHALL VERIFY THE LOCATION, TYPE AND SIZE OF ALL MECHANICAL CONTRACTOR WORK.
14. CONTRACTOR SHALL VERIFY THE LOCATION, TYPE AND SIZE OF ALL MECHANICAL CONTRACTOR WORK.
15. CONTRACTOR SHALL VERIFY THE LOCATION, TYPE AND SIZE OF ALL MECHANICAL CONTRACTOR WORK.
16. CONTRACTOR SHALL VERIFY THE LOCATION, TYPE AND SIZE OF ALL MECHANICAL CONTRACTOR WORK.
17. CONTRACTOR SHALL VERIFY THE LOCATION, TYPE AND SIZE OF ALL MECHANICAL CONTRACTOR WORK.
18. CONTRACTOR SHALL VERIFY THE LOCATION, TYPE AND SIZE OF ALL MECHANICAL CONTRACTOR WORK.
19. CONTRACTOR SHALL VERIFY THE LOCATION, TYPE AND SIZE OF ALL MECHANICAL CONTRACTOR WORK.
20. CONTRACTOR SHALL VERIFY THE LOCATION, TYPE AND SIZE OF ALL MECHANICAL CONTRACTOR WORK.

PANEL, PNL-1 LOCATION: ELECTRICAL ROOM FEEDER SOURCE: CLECO		VOLTAGE: 120/208V, 150A, 3Φ, 4W ENCLOSURE: WALL MOUNTED W/EQUIPMENT GND BAR SQUARE D TYPE OO LOAD CENTER, 22000 A.C. W/ MAIN BRKR					
NO.	LOAD DESCRIPTION	AMF	LOAD (VA)	NO.	LOAD DESCRIPTION	AMF	LOAD (VA)
1	4-0 #12 THHN CONDUIT	40	2120	17	TABLE/WALL OUTLET	20	1000
2	4-0 #12 THHN CONDUIT	40	2120	18	TABLE/WALL OUTLET	20	1000
3	4-0 #12 THHN CONDUIT	40	2120	19	TABLE/WALL OUTLET	20	1000
84	4-0 #12 THHN CONDUIT	40	2120	100	TABLE/WALL OUTLET	20	1000

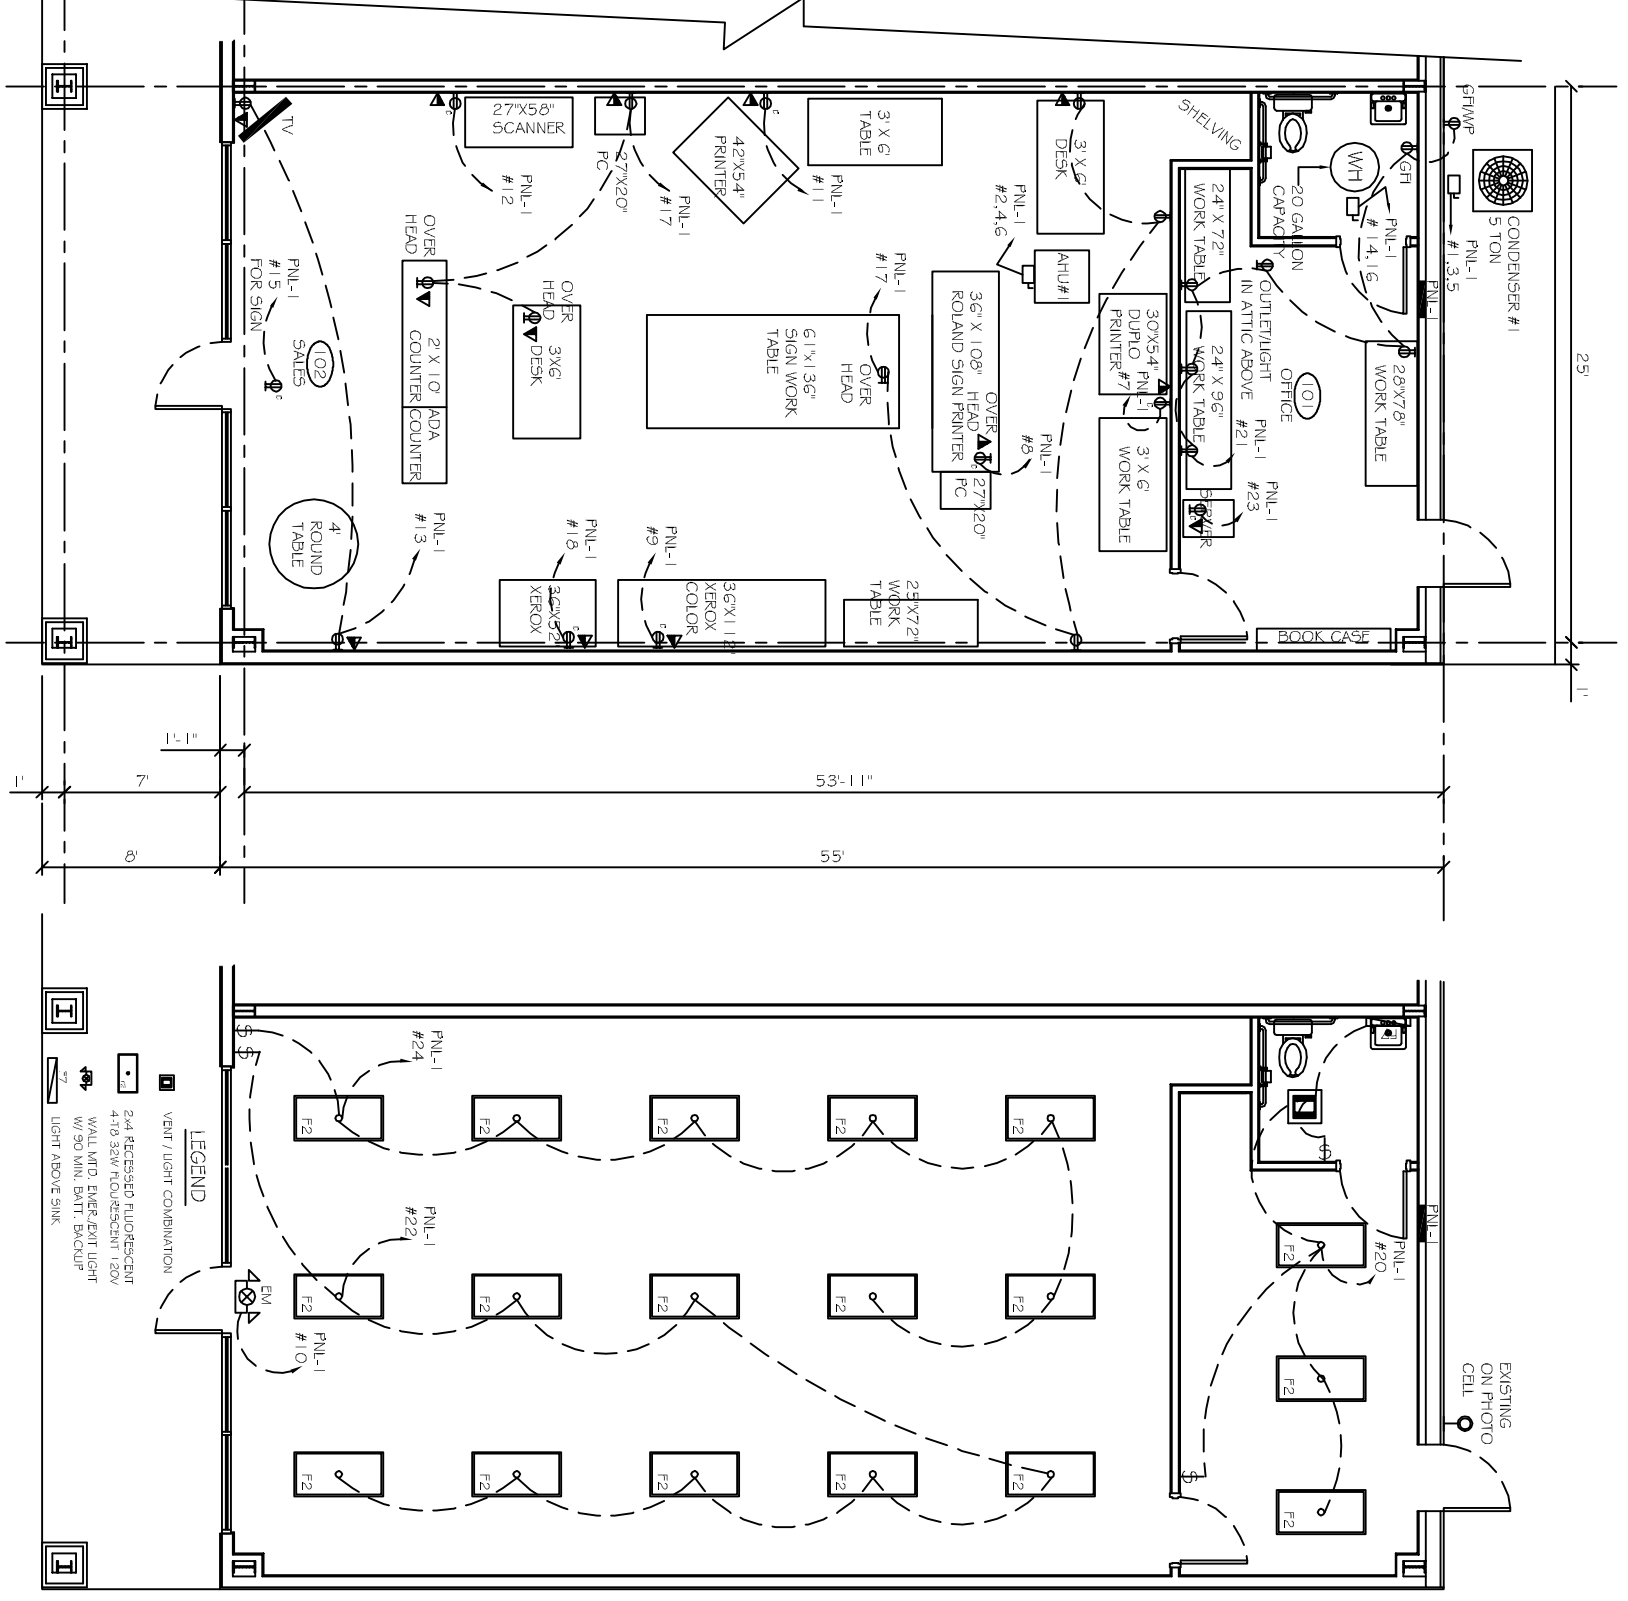

POWER PLAN
SCALE: 1/4" = 1'-0"

LIGHTING PLAN
SCALE: 1/4" = 1'-0"

<p>POWER & LIGHTING PLAN</p> <p>SHEET No: 4 OF 4</p> <p>E-1</p>	<p>REVISIONS</p> <table border="1"> <thead> <tr> <th>#</th> <th>DESCRIPTION</th> <th>DATE</th> </tr> </thead> <tbody> <tr> <td> </td> <td> </td> <td> </td> </tr> </tbody> </table>	#	DESCRIPTION	DATE				<p>DUDLEY SMITH PRINTING</p> <p>TYLER SQUARE 584 G5 TYLER STREET SUITE #1 SUDELL, LA</p> <p>JOB No: 2152 DATE: 10-3-12</p> <p>DRAWN BY: BSN CHECKED BY: BSN</p>	<p>DAMMON ENGINEERING, INC. Architects & Engineers</p> <p>CHIEF ENGINEER: ENNETT DAMMON, P.E. CHIEF ARCHITECT: ROBERT WILTISE 554 OLD SPANISH TRAIL SUDELL, LA 70450</p> <p>dammoneng@msn.com dammoneng@bellsouth.net PHONE: 905-649-5832 FAX: 905-641-5950</p>
	#	DESCRIPTION	DATE						