

1 POWER PLAN
SCALE: 3/32" = 1'-0"

KEYED NOTES

- LIGHTING CONTROL PANEL "LCP" 1 POLE RELAY PANEL CONTROLLED BY PHOTOCELL ON ROOF.
- PROVIDE 120/208V, 3 PHASE, 300 AMP PANEL BOARD FOR POOL EQUIPMENT. POOL EQUIPMENT TO BE INSTALLED BY POOL SUPPLIER.

DAMMON
ENGINEERING, INC.
LOUISIANA & MISSISSIPPI

Chief Engineer: Brian Witsch, PE
2017 Old Spanish Trail
Baton Rouge, LA 70802
www.dammonengineering.com
info@dammonengineering.com

#	DESCRIPTION	REVISIONS	DATE

NEW ATHLETIC CLUB
PRESTIGE FITNESS CLUB AND SPA

4422 KALANI DRIVE
HANGOCK COUNTY, MISSISSIPPI
JOB NO: 2304 DATE: DECEMBER 08, 2011

SHEET TITLE:
POWER PLAN


DRAWING NUMBER:
E101

SHEET No: 45 of 5

KEYED NOTES

1. TO "LCP" LIGHTING CONTROL PANEL IN EQUIPMENT ROOM

2. PROVIDE CONNECTION TO UN-SWITCHED LIGHTING CIRCUIT IN SAME ROOM

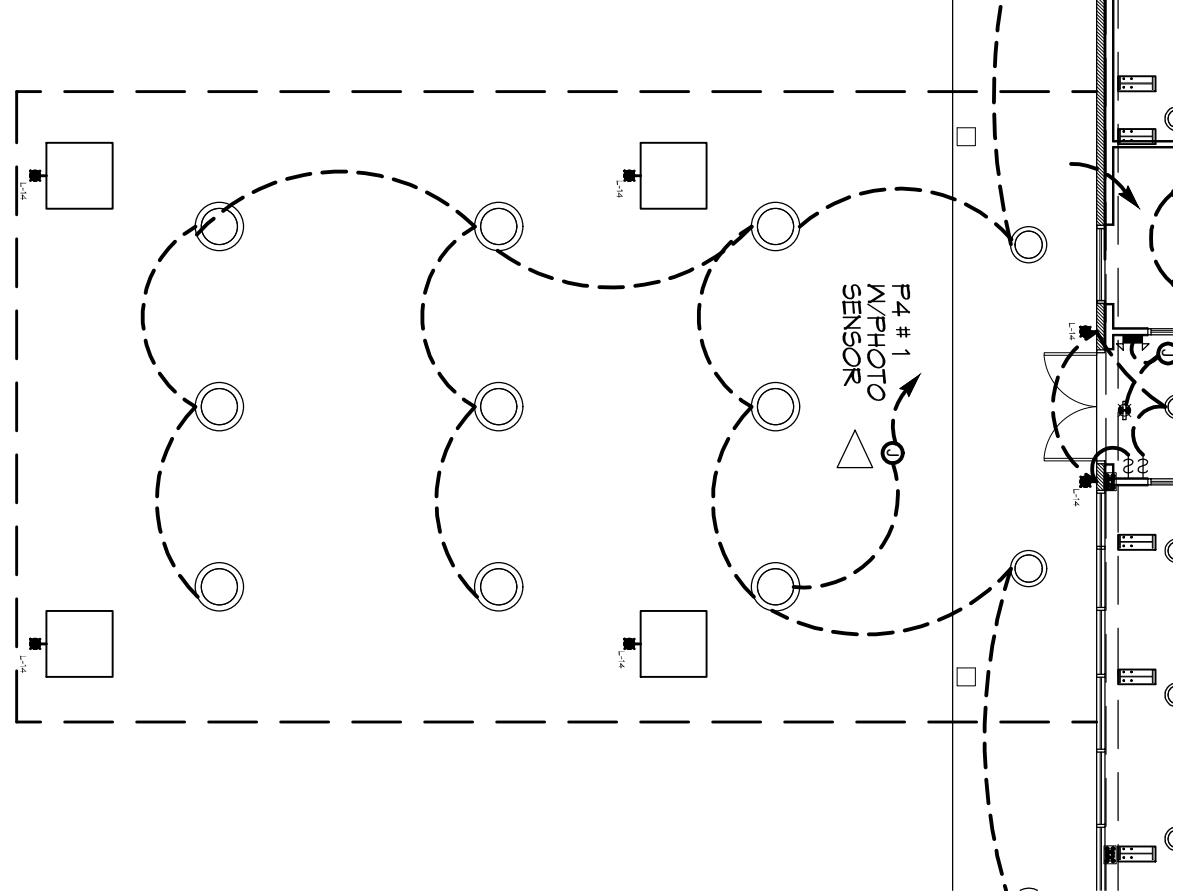


LIGHTING LEGEND

L-1	□	LINEAR FLUORESCENT FIXTURE
L-2	○	PENDANT LIGHT
L-3	▣	2X2 FLUORESCENT FIXTURE
L-4	⊗	CEILING FAN
L-5	⊗	CHANDELIER
L-6	⊗	CHANDELIER
L-7	◻	WALL SCONCE
L-8	◻	WALL SCONCE
L-9	◻	WALL SCONCE
L-10	◻	WALL SCONCE
L-11	—	LIGHTED MIRROR
L-12	◻	PENDANT FIXTURE
L-13	◻	WALL SCONCE
L-14	◻	WALL SCONCE
L-15	◻	RECESSED FIXTURE
L-16	◻	PENDANT FIXTURE
L-17	---	COVE LIGHTING
L-18	○	EXTERIOR FIXTURE
L-19	◻	WALL MOUNTED N/90 MINUTE BACK UP

L-11	—	LIGHTED MIRROR
L-12	◻	PENDANT FIXTURE
L-13	◻	WALL SCONCE
L-14	◻	WALL SCONCE
L-15	◻	RECESSED FIXTURE
L-16	◻	PENDANT FIXTURE
L-17	---	COVE LIGHTING
L-18	○	EXTERIOR FIXTURE
L-19	◻	WALL MOUNTED N/90 MINUTE BACK UP

2 DRIVE THRU PLAN
SCALE: 1/8" = 1'-0"

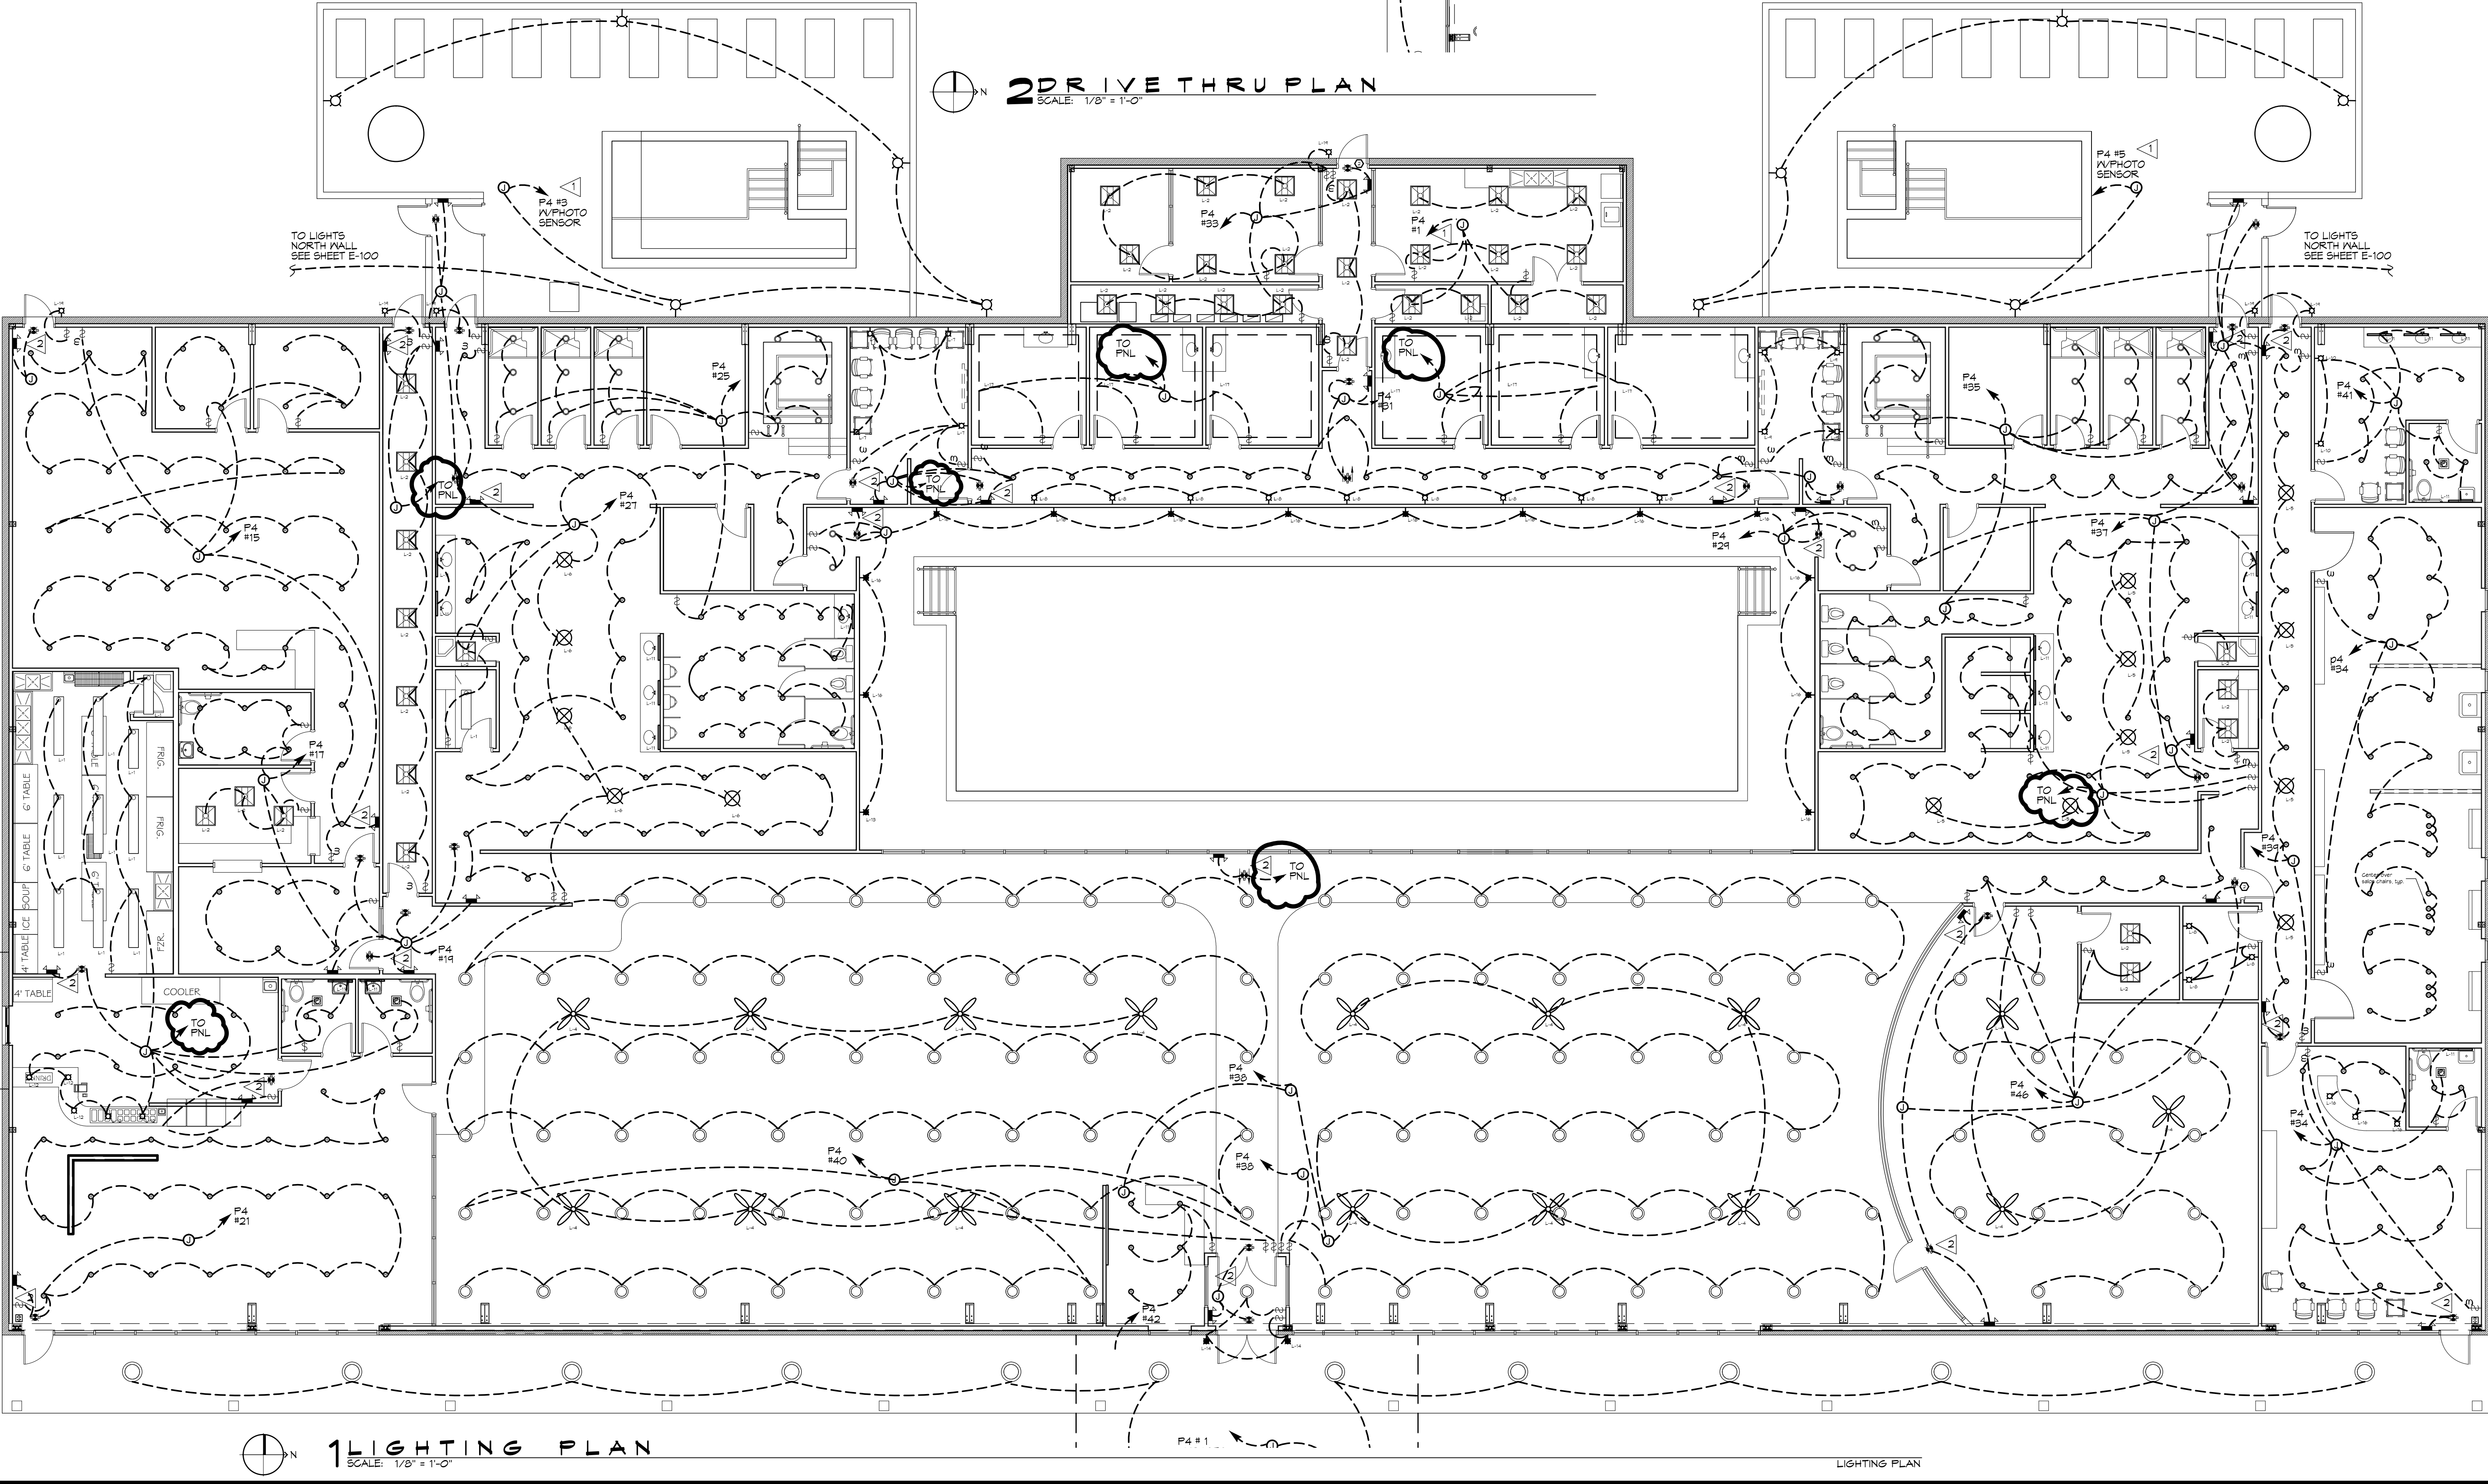

1 LIGHTING PLAN
SCALE: 1/8" = 1'-0"

DAMMON
ENGINEERING, INC.
LOUISIANA & MISSISSIPPI

Chief Engineer: Brian Witsch, PE
www.dammonengineering.com
info@dammonengineering.com

#	DESCRIPTION	REVISIONS	DATE

NEW ATHLETIC CLUB
PRESTIGE FITNESS CLUB AND SPA

4422 KALANI DRIVE
HANCOCK COUNTY, MISSISSIPPI
JOB NO: 2304 DATE: DECEMBER 08, 2011

SHEET TITLE:
LIGHTING PLAN

DRAWING NUMBER:
E102

SHEET No: 21 of 2