



LEGEND	
SYMBOL	DESCRIPTION
—S—S—S—	SANITARY SEWER
—V—V—V—	VENT PIPE
->FD	FLOOR DRAIN
— CO	LINE CLEAN OUT
— MCO	MALL CLEAN OUT

PLUMBING ABBREVIATIONS	
MCO	MALL CLEAN OUT
CO	CLEAN OUT
CO	CLEAN OUT
VTR	VENT THROUGH ROOF
TD	TROUGH DRAIN
WC	WATER CLOSET
LAV	LAVATORY IN COUNTER
AV	AVAILABILITY
SMK	SINK
EN	EMERGENCY FIRE WASH
EV	EVAPORATOR
FD	FLOOR DRAIN
UR	URINAL
EDF	ELECTRIC DRINKING FOUNTAIN
DFF	DOWN TO FIRST FLOOR
RTU	ROOF TOP UNIT
TRP	TO ROOF PIT
FRP	FROM ROOF PIT
WF	WATER FOUNTAIN

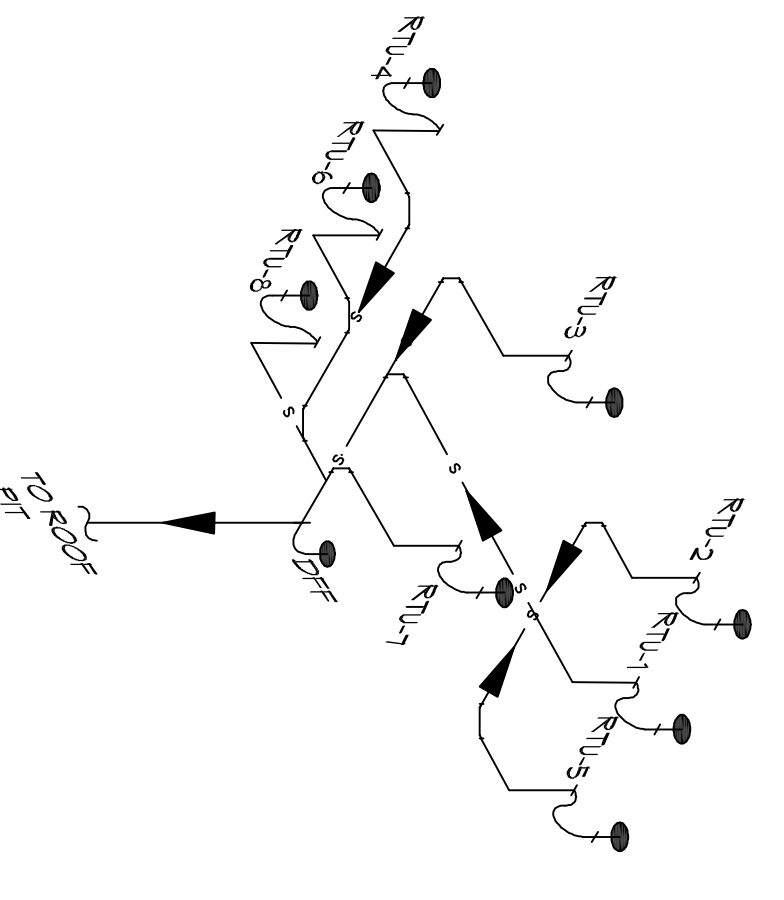

2 PLUMBING ROOF PIT RISER PLAN
SCALE: 1/8" = 1'-0"

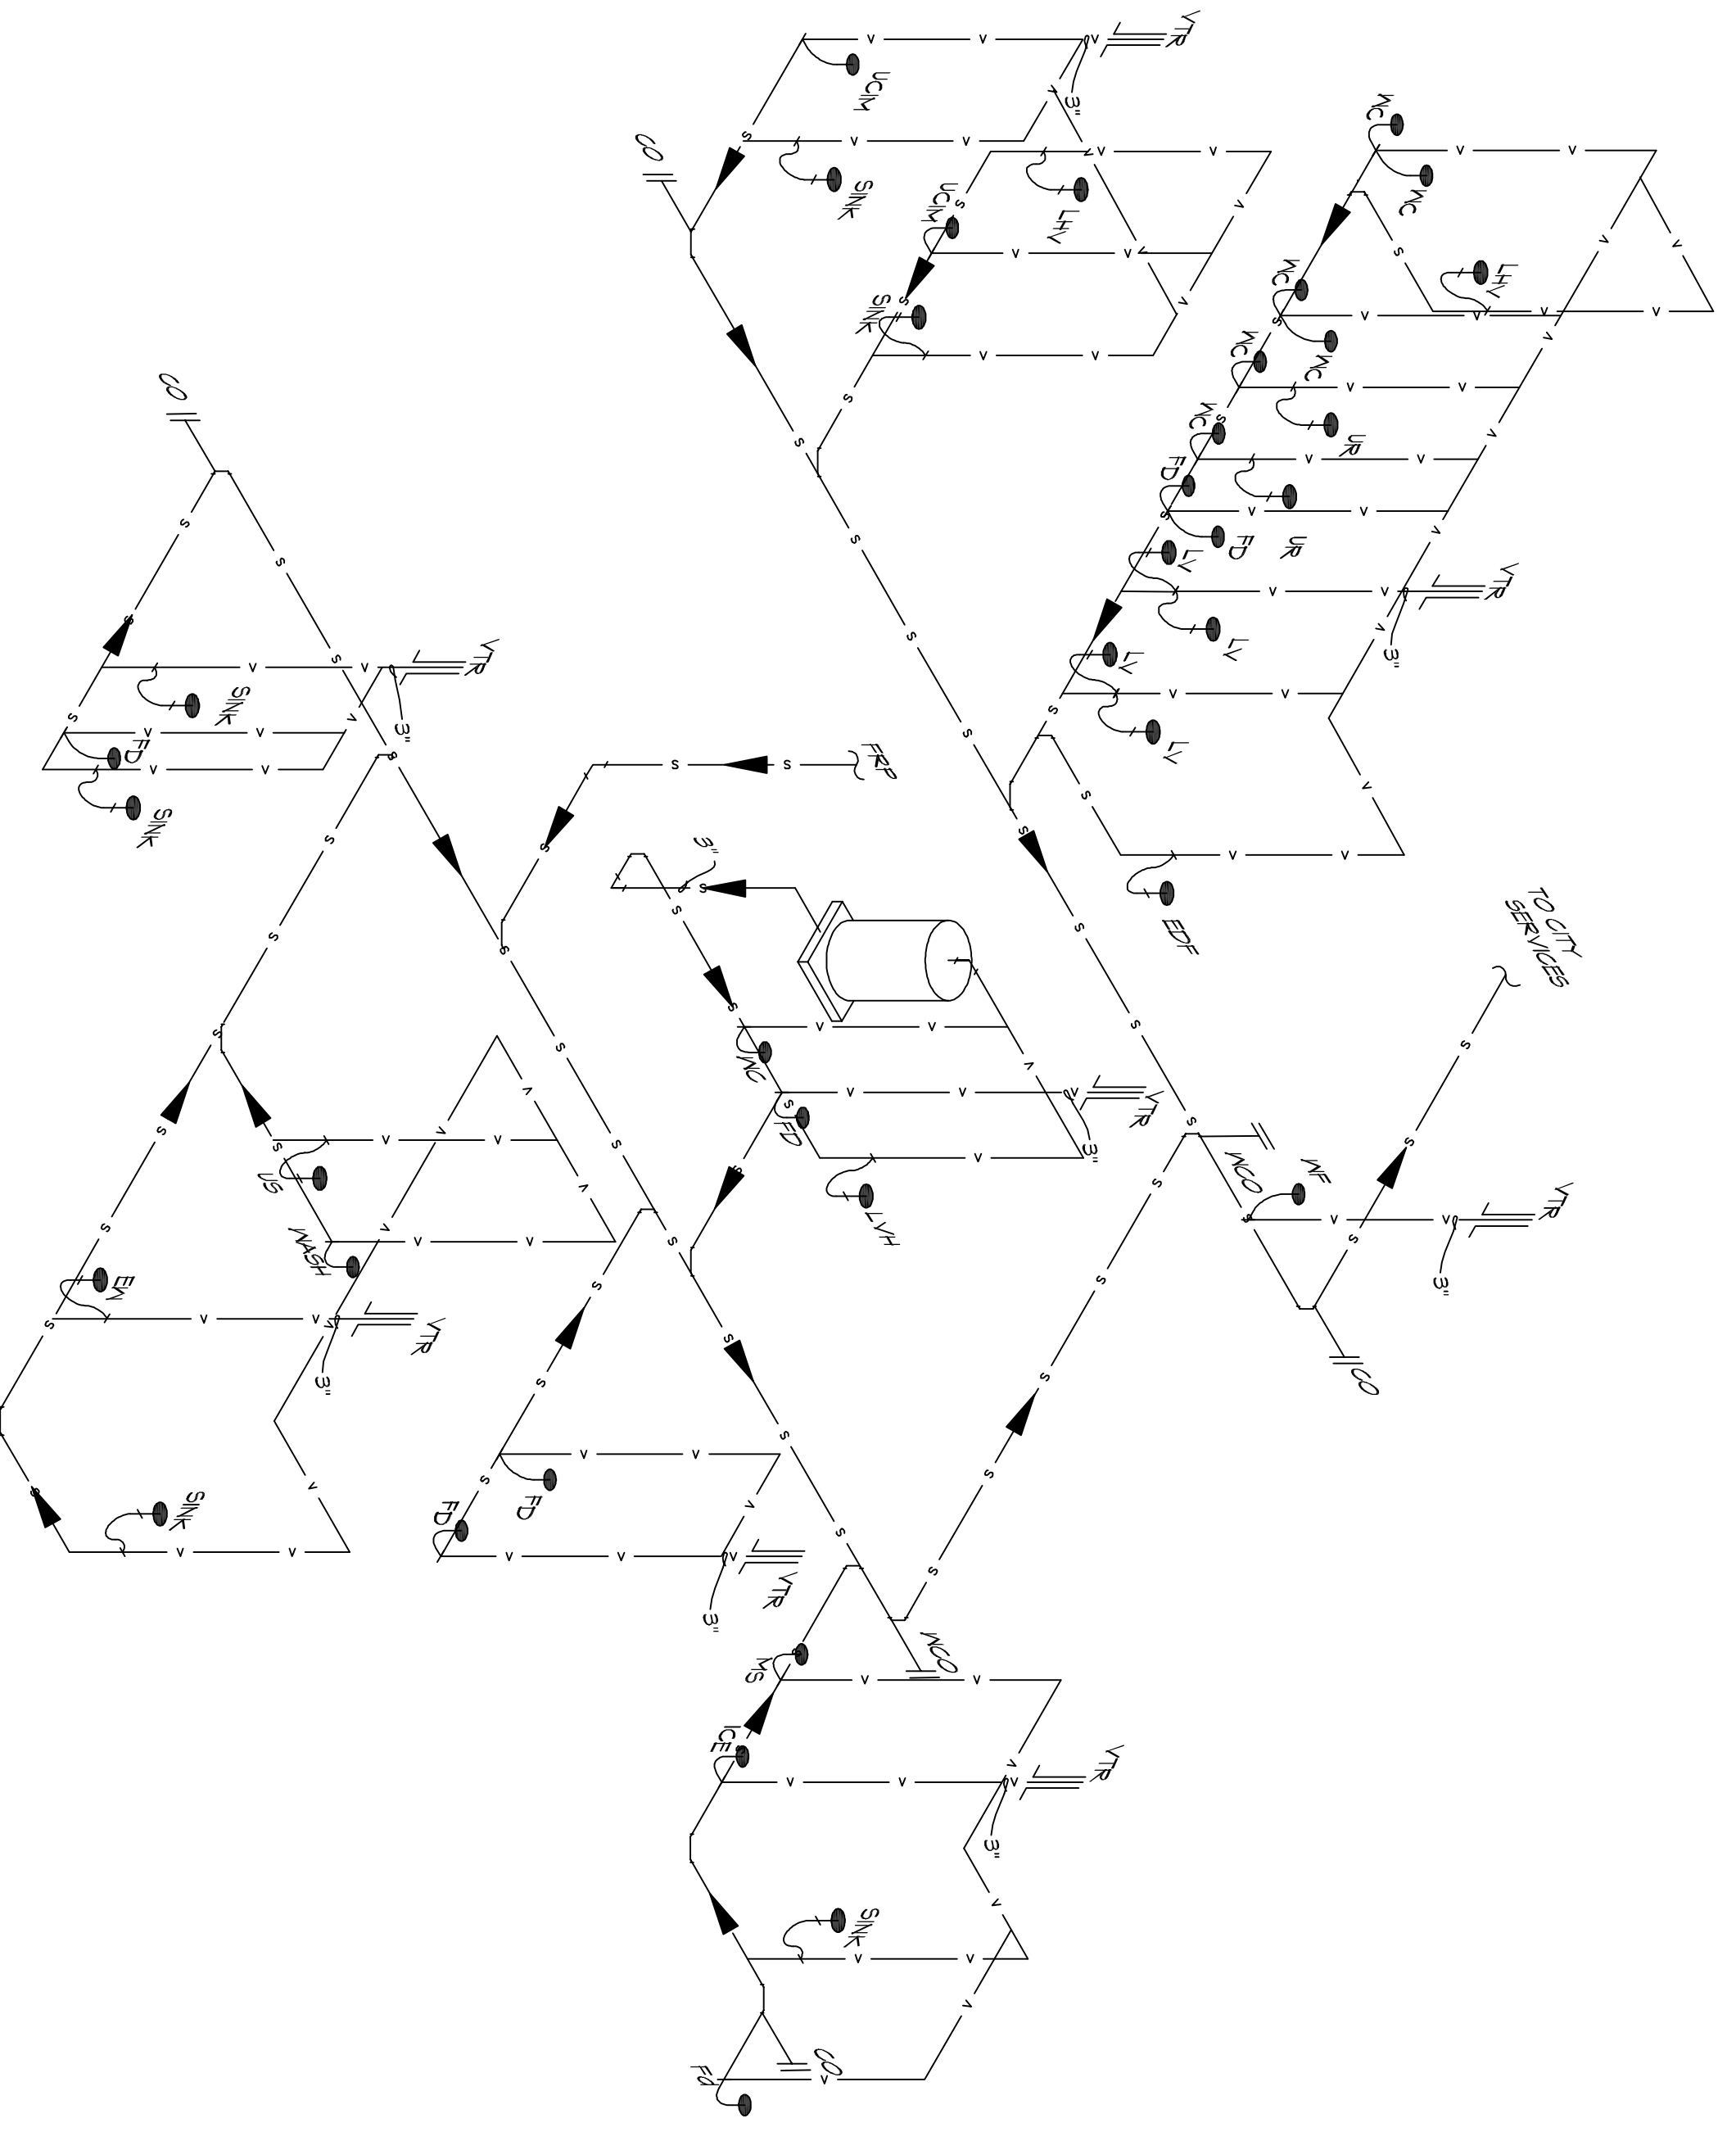

1 PLUMBING FIRST FLOOR RISER DIAGRAM
SCALE: N.T.S.

REVISIONS		
#	DESCRIPTION	DATE

DAMMON
ENGINEERING, INC.
LOUISIANA & MISSISSIPPI

Chief Engineer: Brian Mistich, PE
554 Old Spanish Trail
Slidell, LA 70458
www.dammonengineering.com
info@dammonengineering.com
PH: 985.649.5832

LAZARUS ENGINEERING
2081 GAUSE BLVD E
SLIDELL, LA 70461

JOB No: 2360 DATE: 09-19-2018
DRAWN BY: [Signature] CHECKED BY: [Signature]

The client, drafter, and specifications, design and construction represent the client. The drafter shall remain the property of Lazarus Engineering, Inc. and shall not be used for other projects without the express written consent of Lazarus Engineering, Inc. The client shall remain responsible for the accuracy of the information provided. The client shall remain responsible for the accuracy of the information provided.

SHEET TITLE:
PLUMBING RISER PLAN

DRAWING NUMBER:
P102

SHEET NO:
11 of 11