


29 SECOND FLOOR LIGHTING PLAN
SCALE: 3/16" = 1'-0"

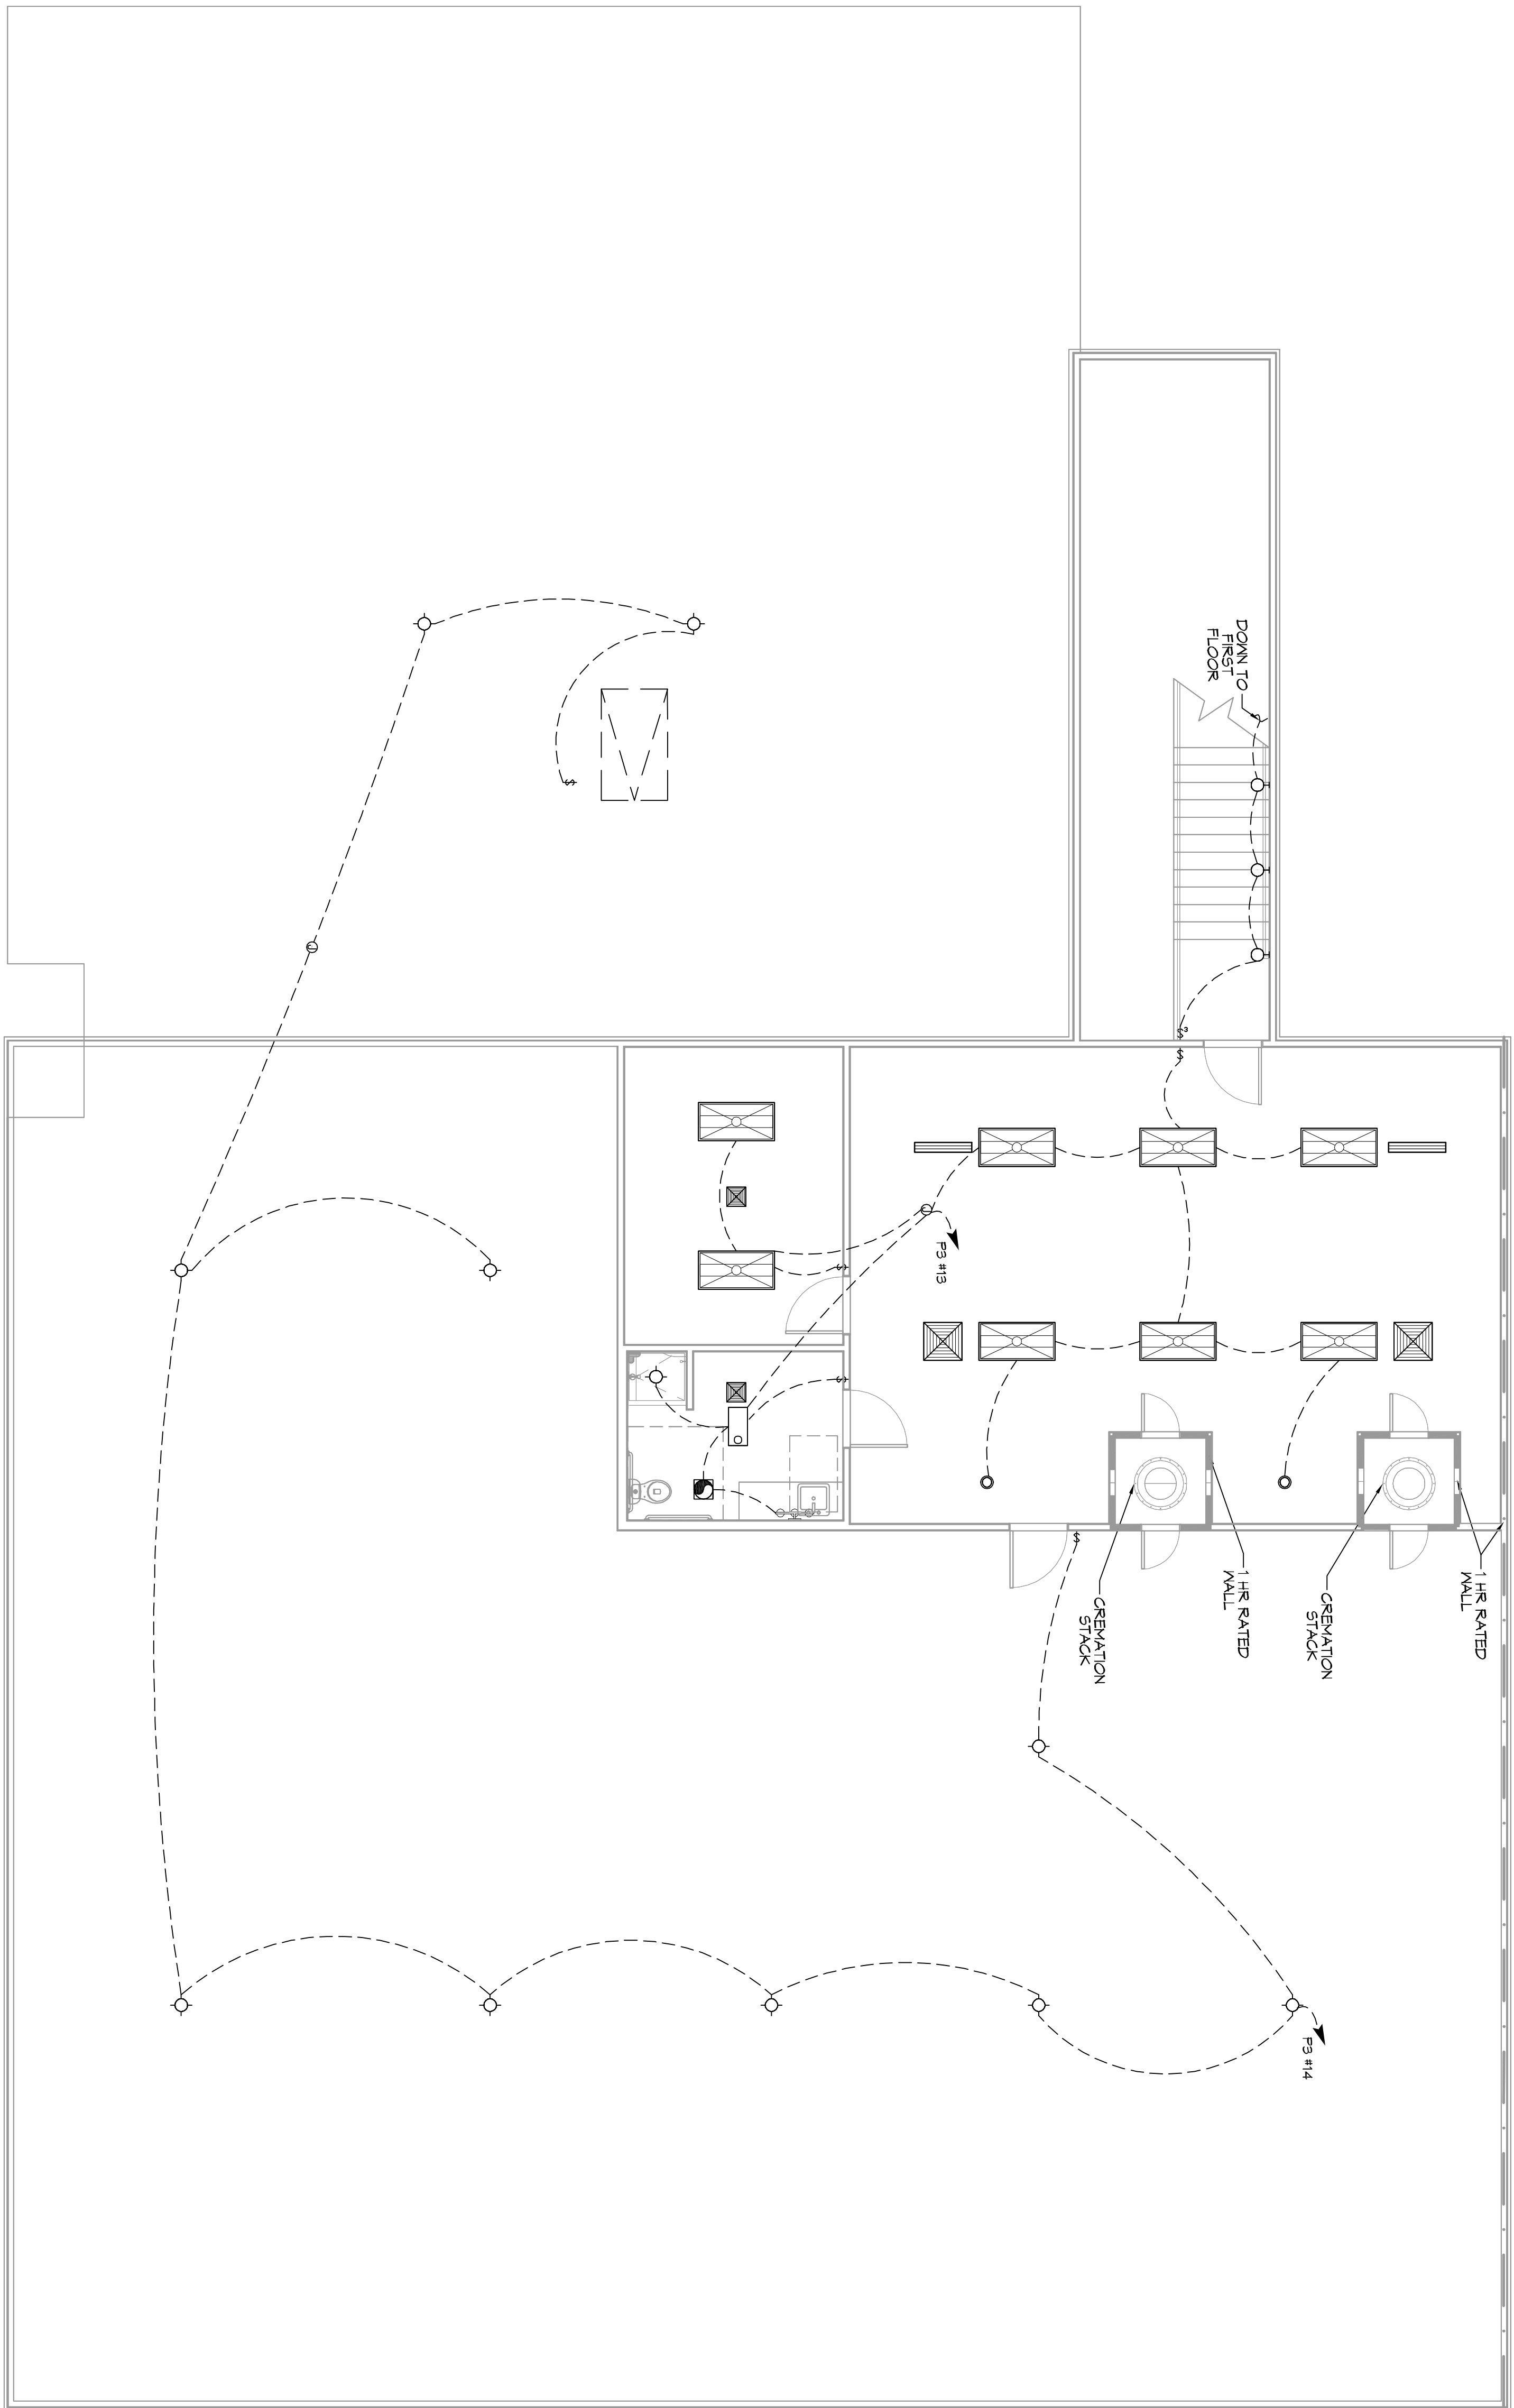

SHEET NO: **E104**
DRAWING NUMBER:

SHEET TITLE:
SECOND FLOOR LIGHTING PLAN

NEW FUNERAL HOME
BOYD FAMILY FUNERAL HOME
4800 DOWNMAN ROAD
NEW ORLEANS, LA

JOB No: 2398 DATE: 09-03-2019
DRAWN BY: JAGMM CHECKED BY: CKD



REVISIONS	
#	DESCRIPTION

DAMMON ENGINEERING, INC.
LOUISIANA & MISSISSIPPI

Chief Engineer: Brian Mistich, PE
554 Old Spanish Trail
Slidell, LA 70458

www.dammonengineering.com
info@dammonengineering.com
PH: 985.649.5832