


 


 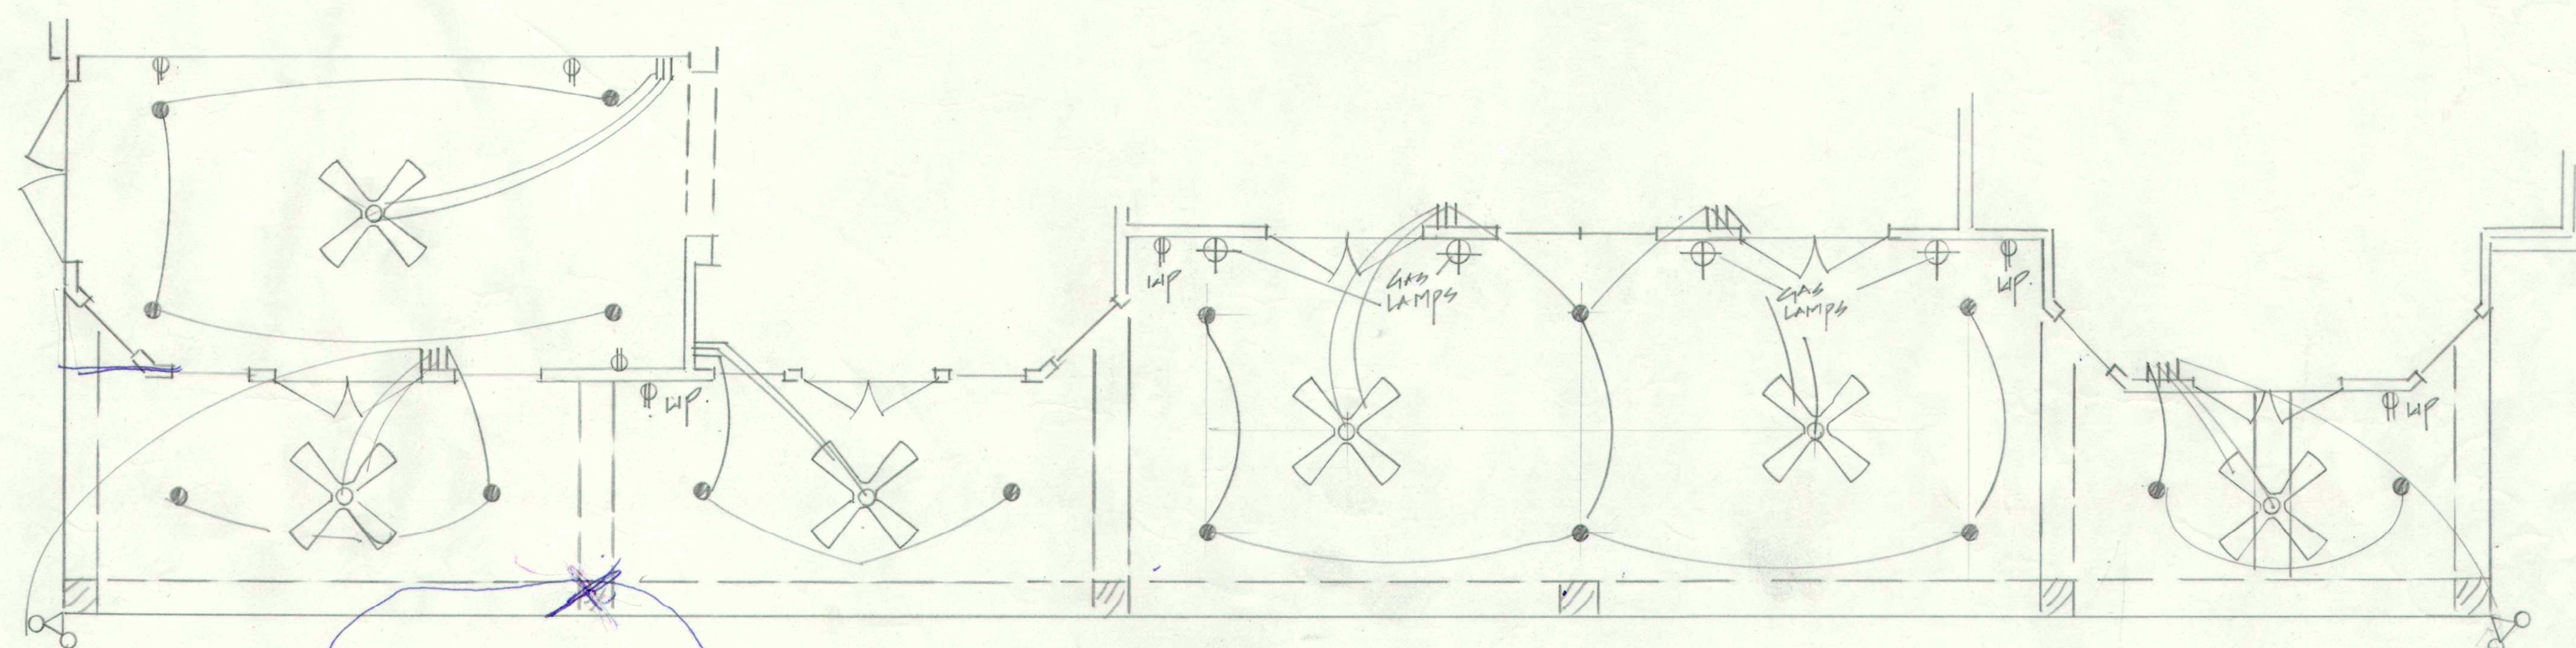



FRONT ELEVATION
1/8" = 1'-0"

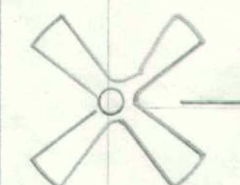

ELECTRICAL PLAN 1/4" = 1'-0"

LEGEND

-  FAN & LIGHT KIT
-  RECESSED LIGHT
-  FLOOD LIGHT
-  110V OUTLET
-  110V WATERPROOF OUTLET
-  GAS LAMPS

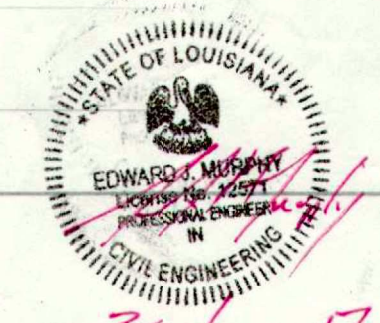

30 June 17

ELECTRICAL ELEVATIONS		
SCALE: AS SHOWN	APPROVED BY: ROBERT BOLIN	DRAWN BY:
DATE: 7-10-17	REVISER:	REVISION:
501 BEAU CHENE DRIVE MANDEVILLE LA		
RALPH M. DEBARTER 721-3525		DRAWING NUMBER: 20F4