


LEGEND

- SSFM — SEWER FORCE MAIN
- SS — GRAVITY SEWER
- - - STORM WATER DRAINAGE
- W — WATER (SHOWN BUT NOT VERIFIED)
- GAS — NATURAL GAS
- ○ SEWER CLEAN-OUT
- ⊕ EXISTING MANHOLE
- ⊞ BLDG NUMBER

SCALE IN FEET
0 25 50

1447.70
N

SITE PLAN
SCALE: 1/64" = 1'-0"

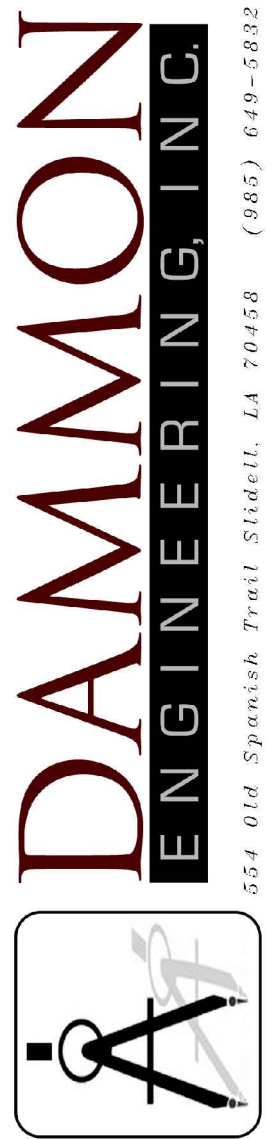

www.dammonengineering.com
554 Old Spanish Trail
Stidell, LA 70098
Chief Engineer: Brian Mistich, PE
554 Old Spanish Trail
Stidell, LA 70098
PH: 985.646.5632

AS-BUILT

SEAL:

SEWER SYSTEM RENOVATION;
PROJECT NUMBERS: 08-408-11-01 PART 1 &
08-408-04B-01, PART 20 & 01-107-06B-11, PART U7
BRIDGE CITY CENTER FOR YOUTH
3225 RIVER ROAD
BRIDGE CITY, LA 70094
JOB NO.: 2156 DATE: 9/26/2018
DRAWN BY: PFD CHECKED BY: BAC

SHEET TITLE:
SITE PLAN

DRAWING NUMBER:

C-1