


EXISTING FIRE SERVICE MAIN  
PING UNDERGROUND, BELOW  
INITIARY SEWER LATERAL.

ABANDONED  
MANHOLE

**LEGEND**

- SSFM SEWER FORCEMAIN
- SS GRAVITY SEWER
- STORM WATER DRAINAGE
- W WATER (SHOWN BUT NOT VERIFIED)
- GAS NATURAL GAS
- CO SEWER CLEAN-OUT
- MH EXISTING MANHOLE
- 09 BLDG NUMBER

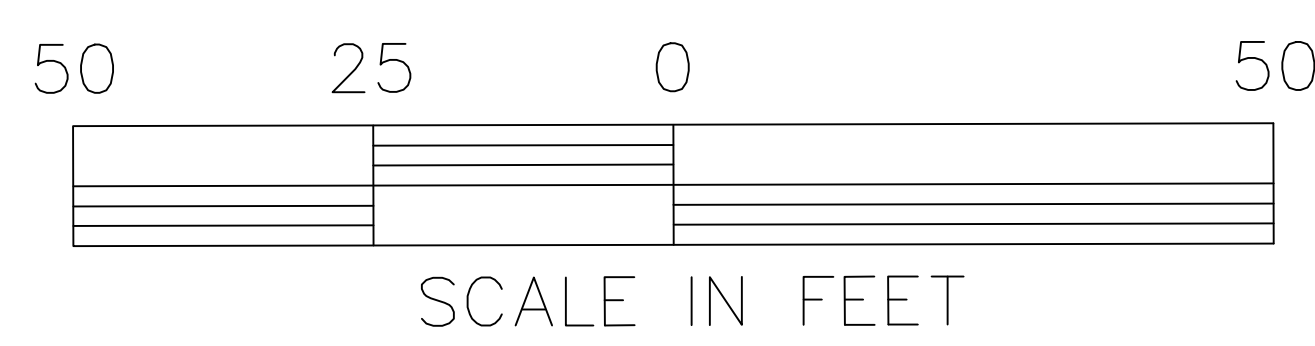

**PARTIAL SITE PLAN**  
SCALE: 1/16" = 1'-0"

**DAMMON ENGINEERING, INC.**  
554 Old Spanish Trail, Suite 101, Metairie, LA 70002  
www.dammonengineering.com  
info@dammonengineering.com  
PH: 985.646.5832

Chief Engineer: Brian Mistich, PE  
554 Old Spanish Trail  
Suite 101, Metairie, LA 70002

**AS-BUILT**

SEAL:

SEWER SYSTEM RENOVATION;  
PROJECT NUMBERS: 08-408-11-01 PART 1 &  
08-408-04B-01, PART 20 & 01-107-06B-11, PART U7

**BRIDGE CITY CENTER FOR YOUTH**

3225 RIVER ROAD  
BRIDGE CITY, LA 70094

JOB NO: 2156 DATE: 9/28/2018  
DRAWN BY: BAC  
PFD CHECKED BY:

SHEET TITLE:  
SITE PLAN

DRAWING NUMBER:  
**C-1.6**

SHEET No: 5 of 14