

STING FIRE SERVICE MAIN  
 NG UNDERGROUND, BELOW  
 ITARY SEWER LATERAL.


ABANDONED  
 MANHOLE

EXISTING FORCE MAIN FROM  
 BUILDING 32 TO 6" PVC LINE.

1447.40  
 S 26°50'13"E

**LEGEND**

	SSFM	SEWER FORCEMAIN
	SS	GRAVITY SEWER
		STORM WATER DRAINAGE
	W	WATER (SHOWN BUT NOT VERIFIED)
	GAS	NATURAL GAS
	CO	SEWER CLEAN-OUT
	MH	EXISTING MANHOLE
	09	BLDG NUMBER

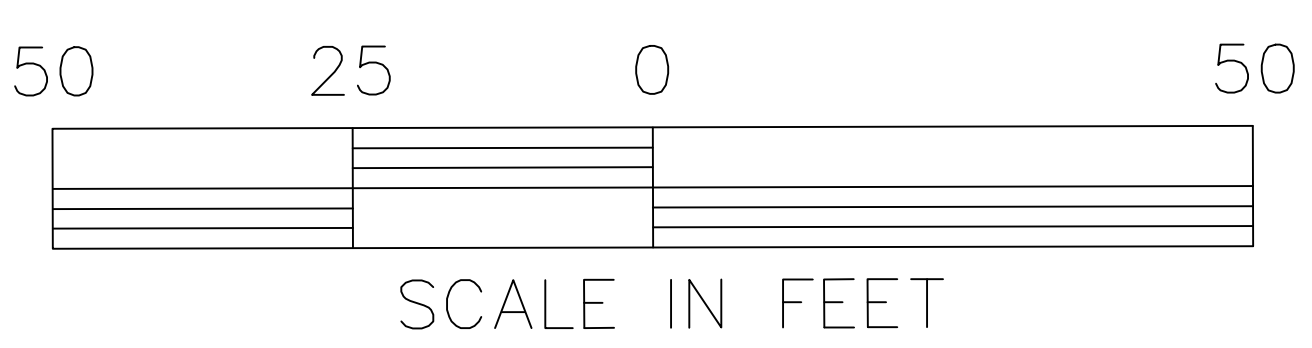

**PARTIAL SITE PLAN**  
 SCALE: 1/16" = 1'-0"

**DAMMON ENGINEERING, INC.**  
 554 Old Spanish Trail, Suite 111, Metairie, LA 70002  
 (504) 885-5832  
 www.dammonengineering.com  
 info@dammonengineering.com  
 Chief Engineer: Brian Mistich, PE  
 554 Old Spanish Trail  
 Metairie, LA 70002

**AS-BUILT**

SEAL:

SEWER SYSTEM RENOVATION;  
 PROJECT NUMBERS: 08-408-11-01 PART 1 &  
 08-408-04B-01, PART 20 & 01-107-06B-11, PART U7  
**BRIDGE CITY CENTER FOR YOUTH**  
 3225 RIVER ROAD  
 BRIDGE CITY, LA 70094  
 JOB NO: 2156 DATE: 9/28/2018  
 DRAWN BY: PFD CHECKED BY: BAC

SHEET TITLE:  
 SITE PLAN

DRAWING NUMBER:  
**C-1.8**